




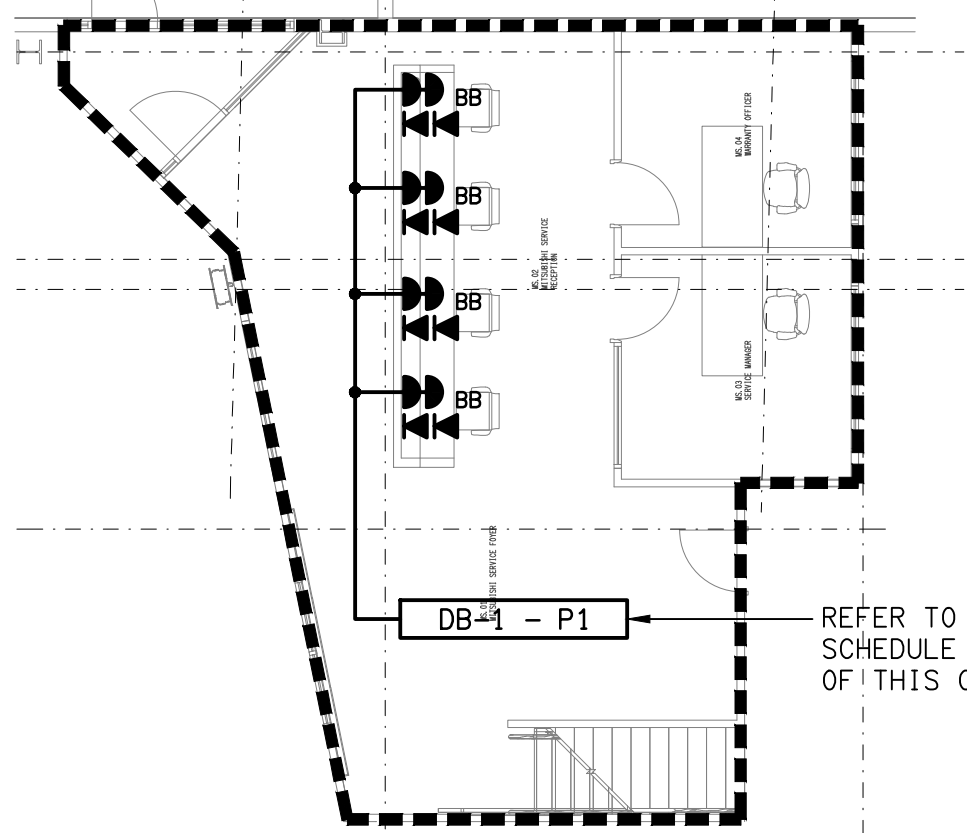


MITSUBISHI BOOK-IN
MEZZANINE FLOOR PLAN
SCALE 1:100

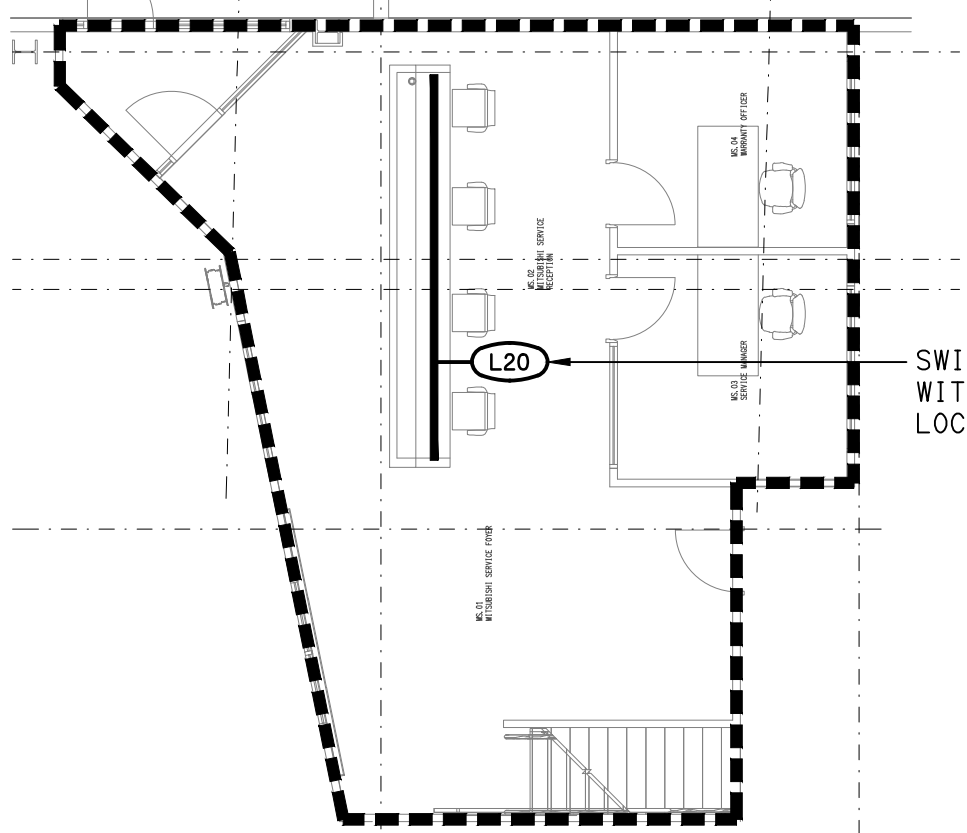



MITSUBISHI BOOK-IN
MEZZANINE REFLECTED CEILING PLAN
SCALE 1:100

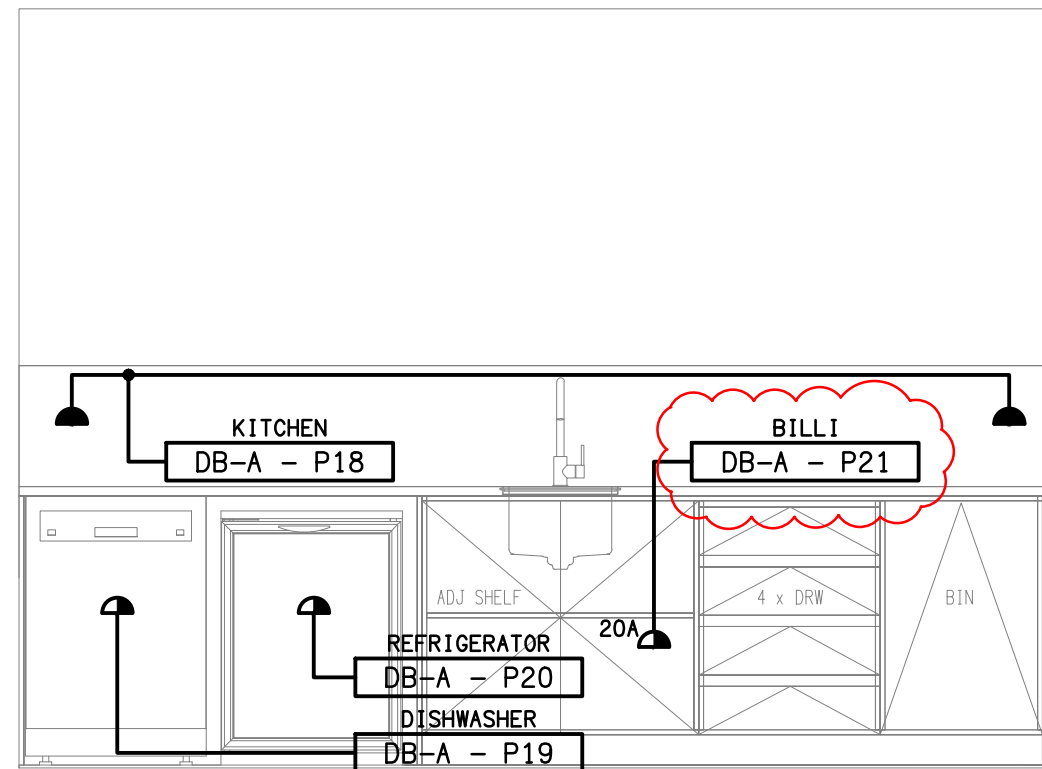

DETAIL A
MITSUBISHI KITCHENETTE ELEVATION
SCALE 1:25

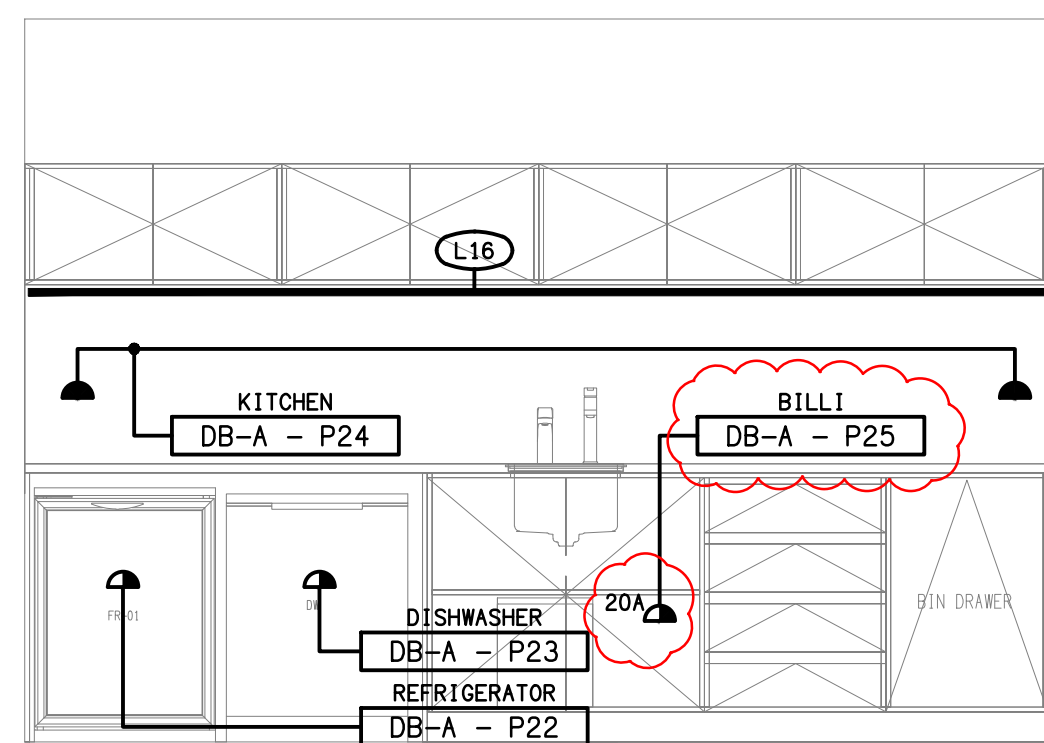

DETAIL B
KIA KITCHENETTE ELEVATION
SCALE 1:25

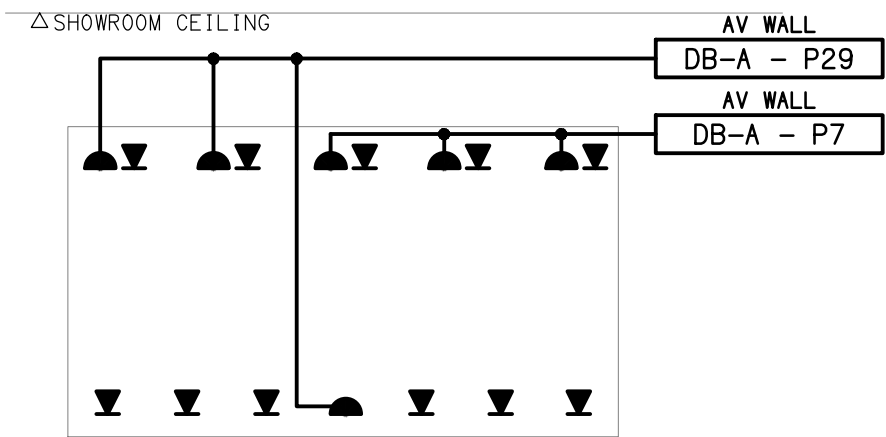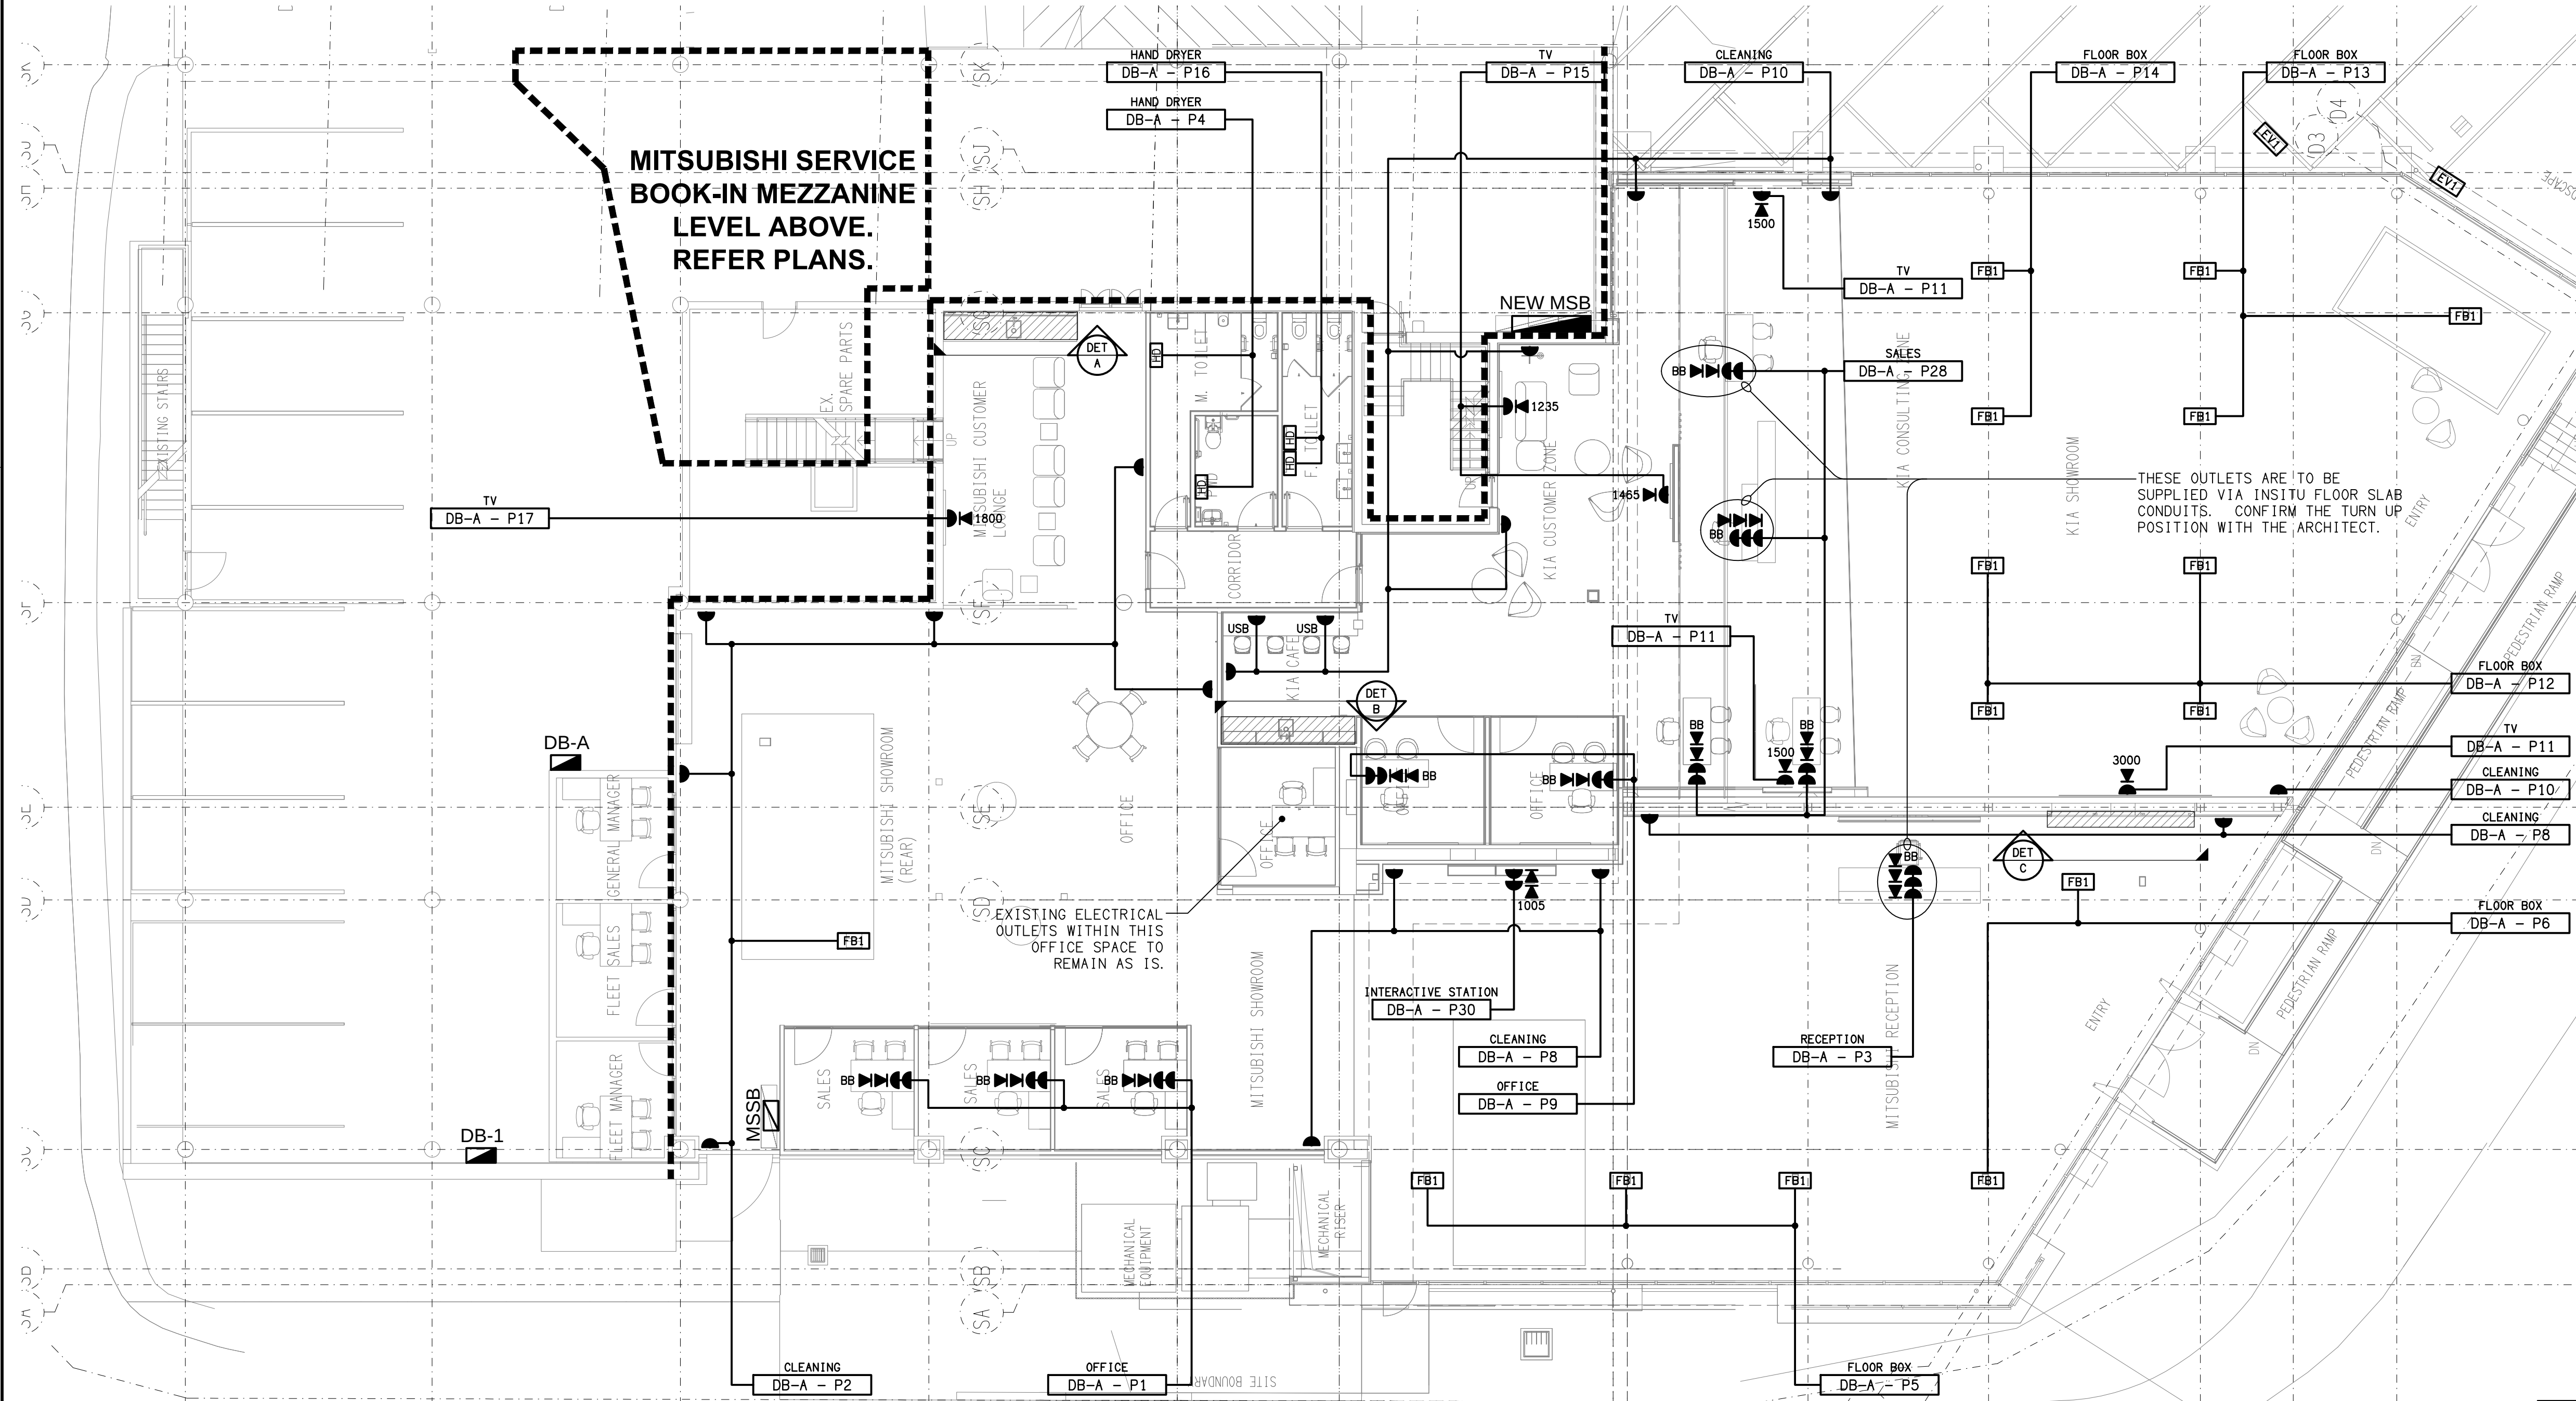

NOTE:
THE AV WALL OUTLETS ARE TO BE PROVIDED AS LOOSE 413 AND CAT-6 SOCKETS AS PER THE ONQ DIGITAL 4 OF 4 DRAWINGS DATED 25-03-2024.

DETAIL C
AV WALL ELEVATION
NOT TO SCALE

ELECTRICAL DESIGN GROUP BRISBANE
PTY LTD
ACN 092 710 793
TRADING AS:
ELECTRICAL DESIGN GROUP

THE COPYRIGHT OF THIS DRAWING
REMAINS THE PROPERTY OF THE
ELECTRICAL DESIGN GROUP.
USE FIGURED DIMENSIONS
IN PREFERENCE TO SCALE.
ALL DIMENSIONS TO BE
VERIFIED ONSITE.

ELECTRICAL DESIGN GROUP
ELECTRICAL BUILDING SERVICES CONSULTANTS
BRISBANE GOLD COAST

P.O. Box 15, Sherwood Q.4075
Phone: (07) 3278 4375
Email: brisbane@edg.net.au
Web: www.edg.net.au

PROJECT:
TOOWONG KIA & MITSUBISHI

601 MILTON ROAD, TOOWONG

J	CONSTRUCTION	10/09/2025
REV.	DESCRIPTION:	DATE:

DRAWING:
ELECTRICAL SERVICES
GROUND LEVEL SHOWROOM
FLOOR PLAN

SCALE:
1:100 UNO AT A1

PROJECT NO:
C3227a

DRAWING NO:
E04

REVISION:
J