



MITSUBISHI BOOK-IN
MEZZANINE FLOOR PLAN
SCALE 1:100

REFER TO THE EQUIPMENT SCHEDULE FOR DETAILS OF THIS CIRCUIT.

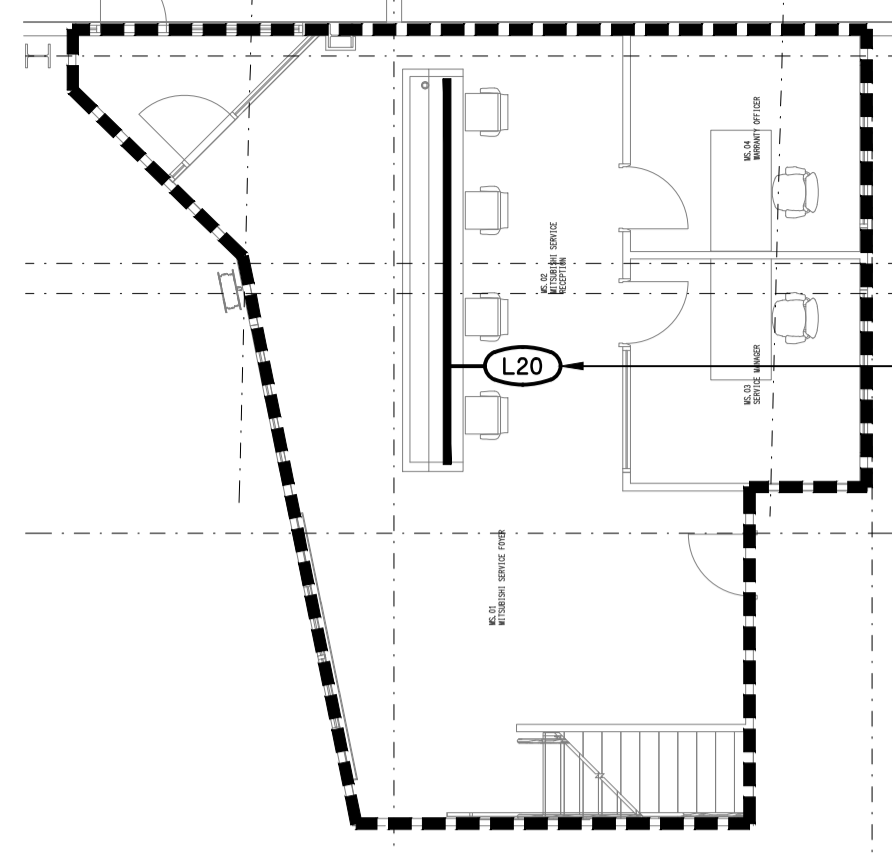


MITSUBISHI BOOK-IN
MEZZANINE REFLECTED CEILING PLAN
SCALE 1:100


SWITCH THIS FITTING WITH THE EXISTING LOCAL LIGHTS.

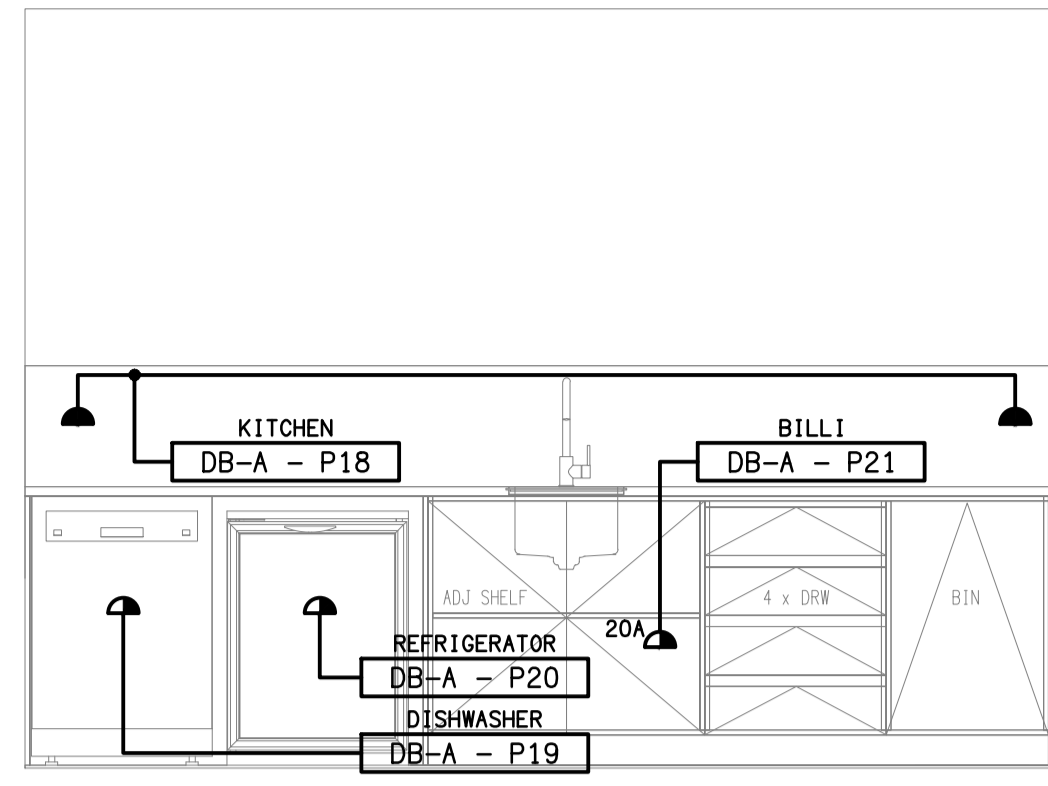

DETAIL A
MITSUBISHI KITCHENETTE ELEVATION
SCALE 1:25

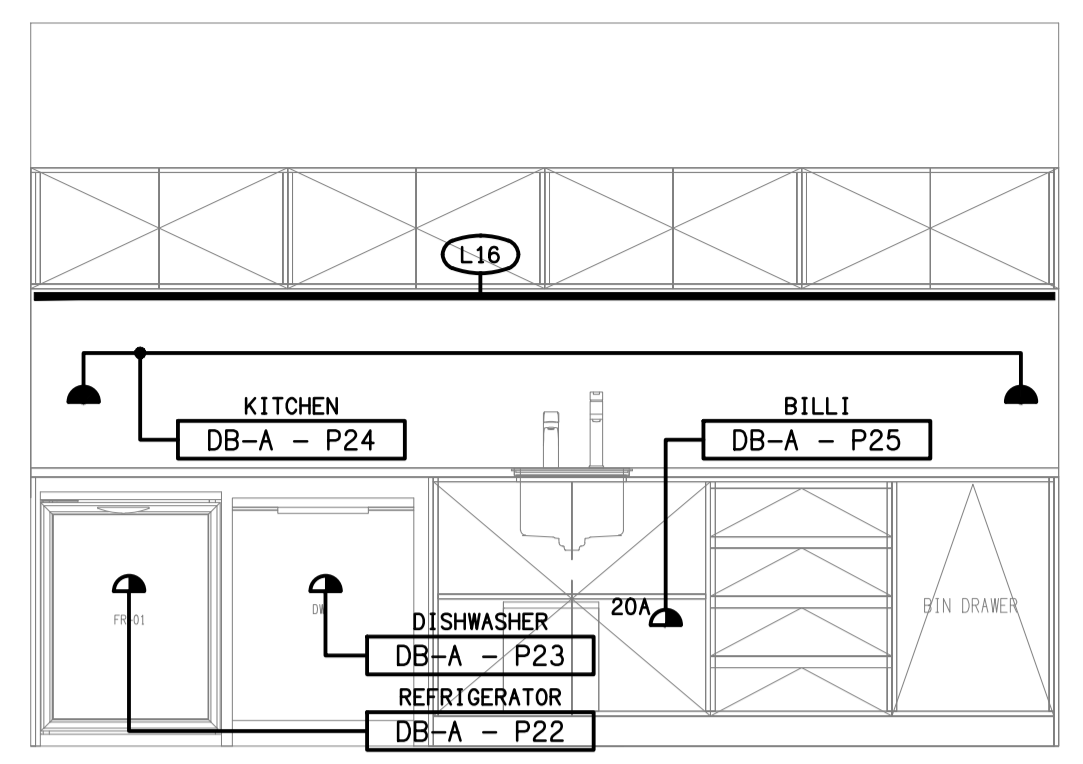


DETAIL B
KIA KITCHENETTE ELEVATION
SCALE 1:25

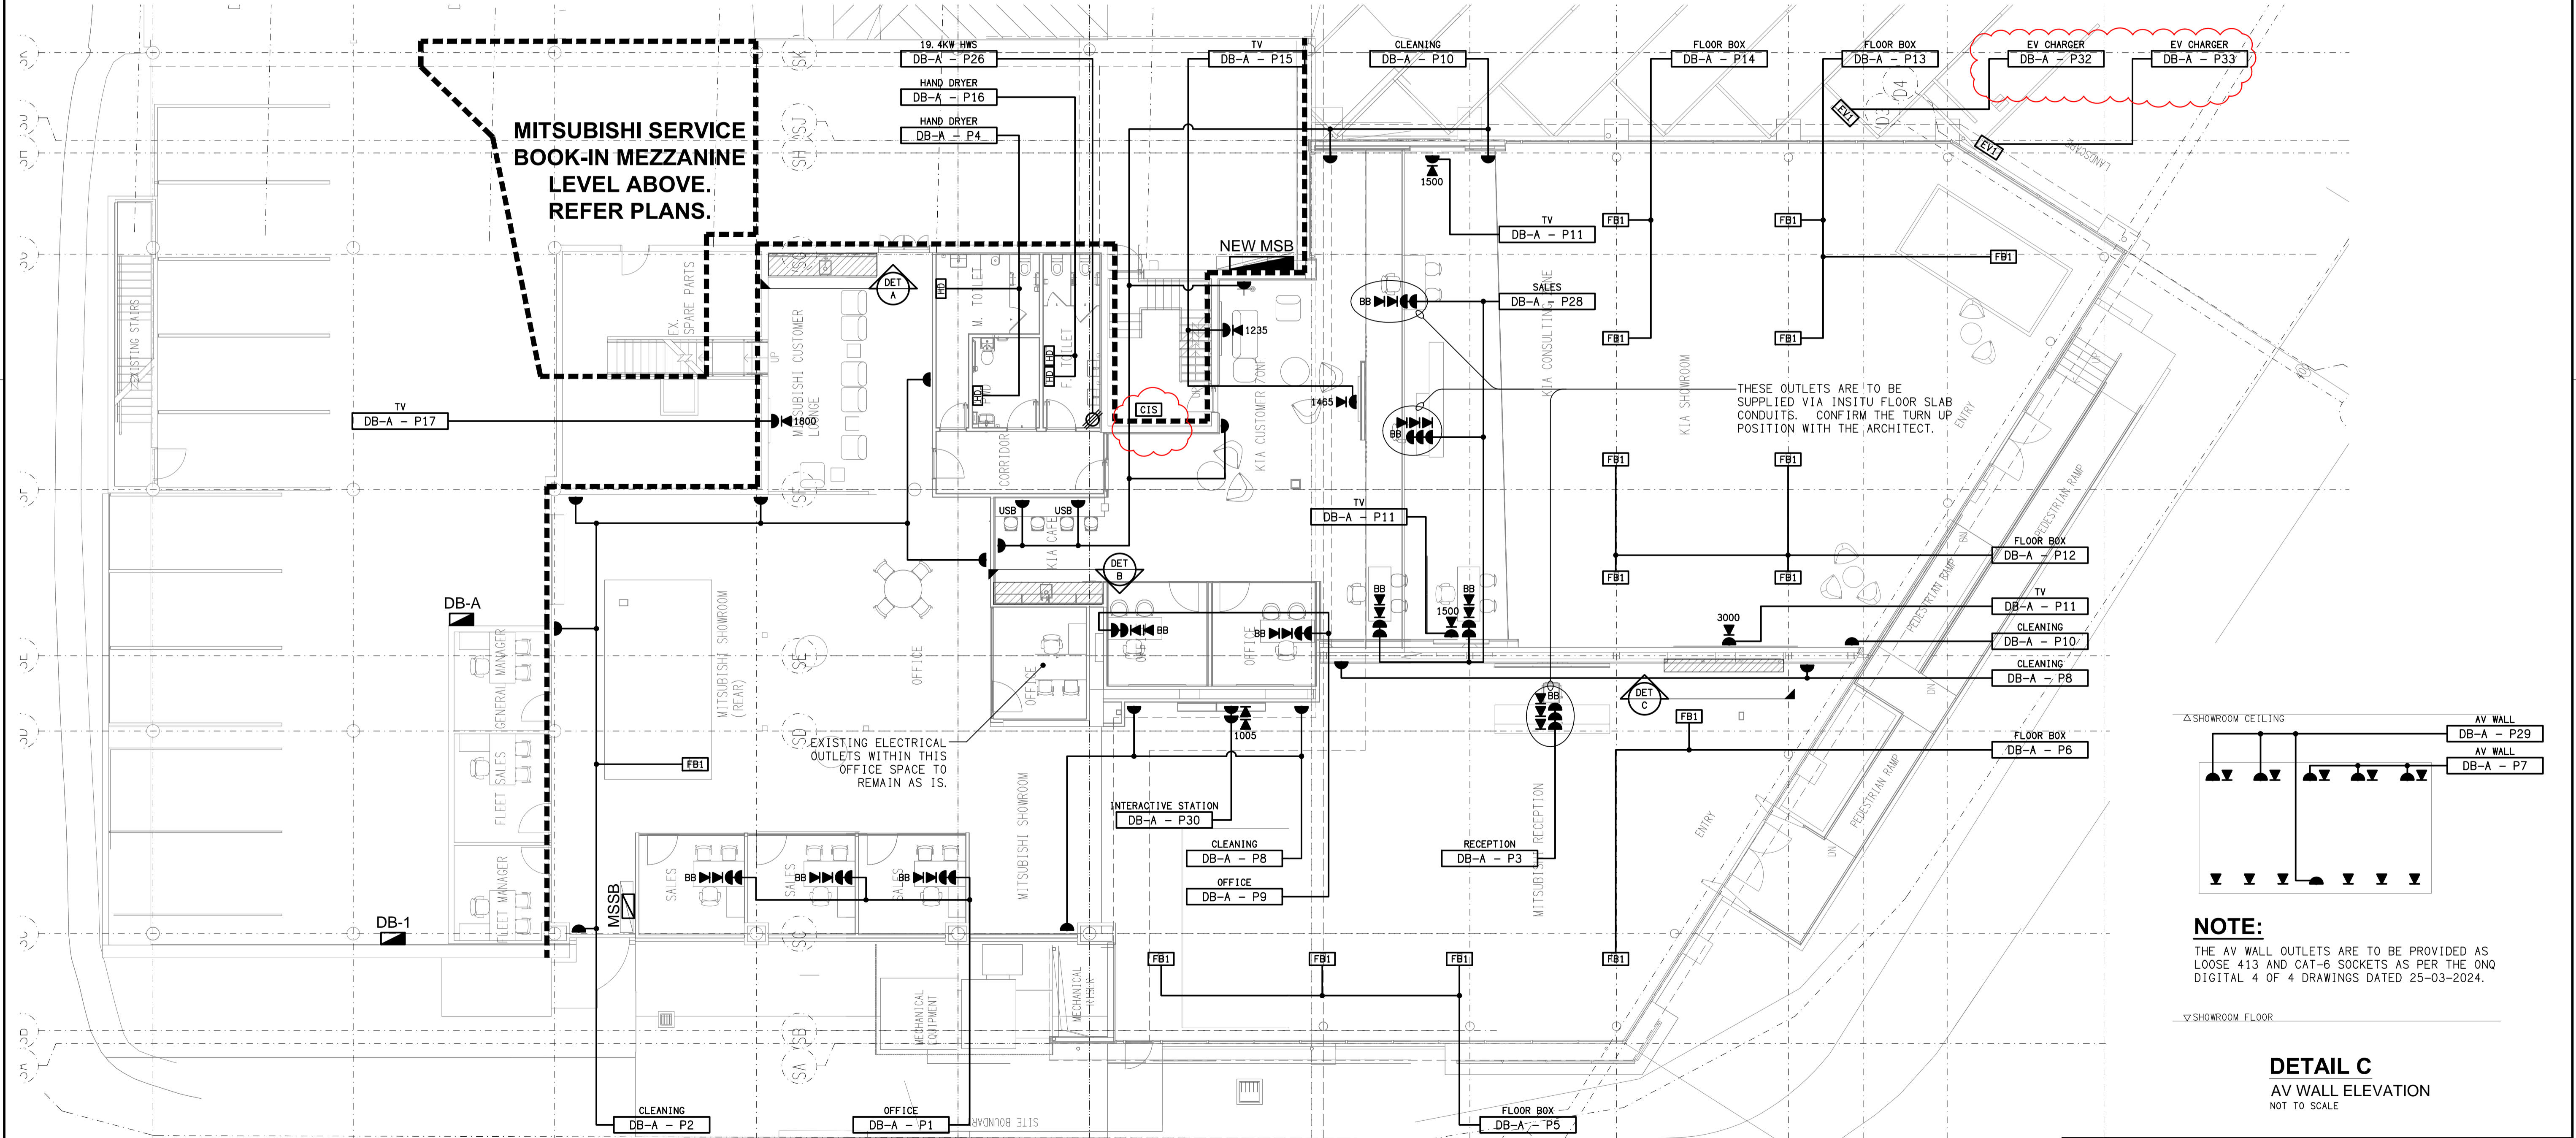

MITSUBISHI SERVICE BOOK-IN MEZZANINE LEVEL ABOVE. REFER PLANS.

THESE OUTLETS ARE TO BE SUPPLIED VIA INSITU FLOOR SLAB CONDUITS. CONFIRM THE TURN UP POSITION WITH THE ARCHITECT.

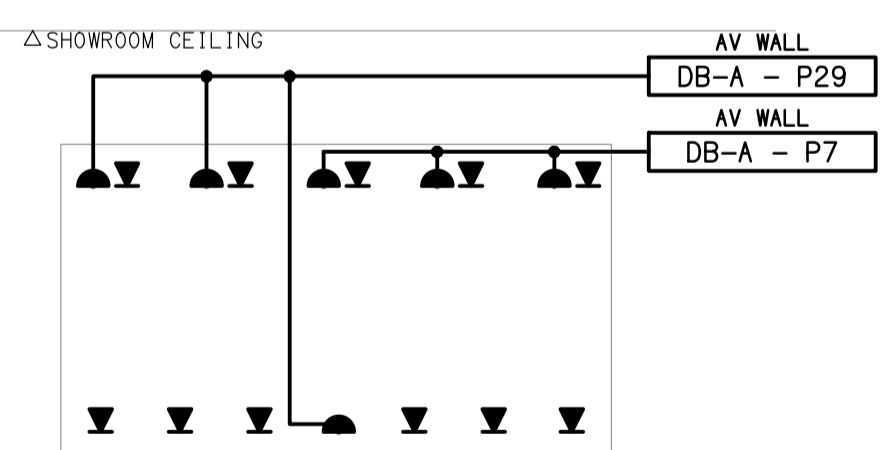

NOTE:
THE AV WALL OUTLETS ARE TO BE PROVIDED AS LOOSE 413 AND CAT-6 SOCKETS AS PER THE ONO DIGITAL 4 OF 4 DRAWINGS DATED 25-03-2024.

DETAIL C
AV WALL ELEVATION
NOT TO SCALE

ELECTRICAL DESIGN GROUP BRISBANE PTY LTD
ACN 092 710 793
TRADING AS:
ELECTRICAL DESIGN GROUP

THE COPYRIGHT OF THIS DRAWING REMAINS THE PROPERTY OF THE ELECTRICAL DESIGN GROUP.
USE FIGURED DIMENSIONS IN PREFERENCE TO SCALE.
ALL DIMENSIONS TO BE VERIFIED ONSITE.

ELECTRICAL DESIGN GROUP
ELECTRICAL BUILDING SERVICES CONSULTANTS
BRISBANE GOLD COAST
P.O. Box 15, Sherwood Q.4075
Phone: (07) 3278 4375
Email: brisbane@edg.net.au
Web: www.edg.net.au

PROJECT:
TOOWONG KIA & MITSUBISHI
601 MILTON ROAD, TOOWONG

L	CONSTRUCTION	30/09/2025
REV:	DESCRIPTION:	DATE:
DRAWING: ELECTRICAL SERVICES GROUND LEVEL SHOWROOM FLOOR PLAN		
SCALE: 1:100 UNO	PROJECT NO: C3227a	DRAWING NO: E04
AT A1	REVISION: L	