


**DETAIL A**  
L1 LIGHTING ELEVATION  
SCALE 1:50

**DETAIL B**  
L1 LIGHTING SECTION  
SCALE 1:50

**DETAIL C**  
L3 LIGHTING ELEVATION  
SCALE 1:50

**DETAIL D**  
L3 LIGHTING ELEVATION  
SCALE 1:50

**DETAIL E**  
L3 / L2 LIGHTING SECTION  
SCALE 1:50

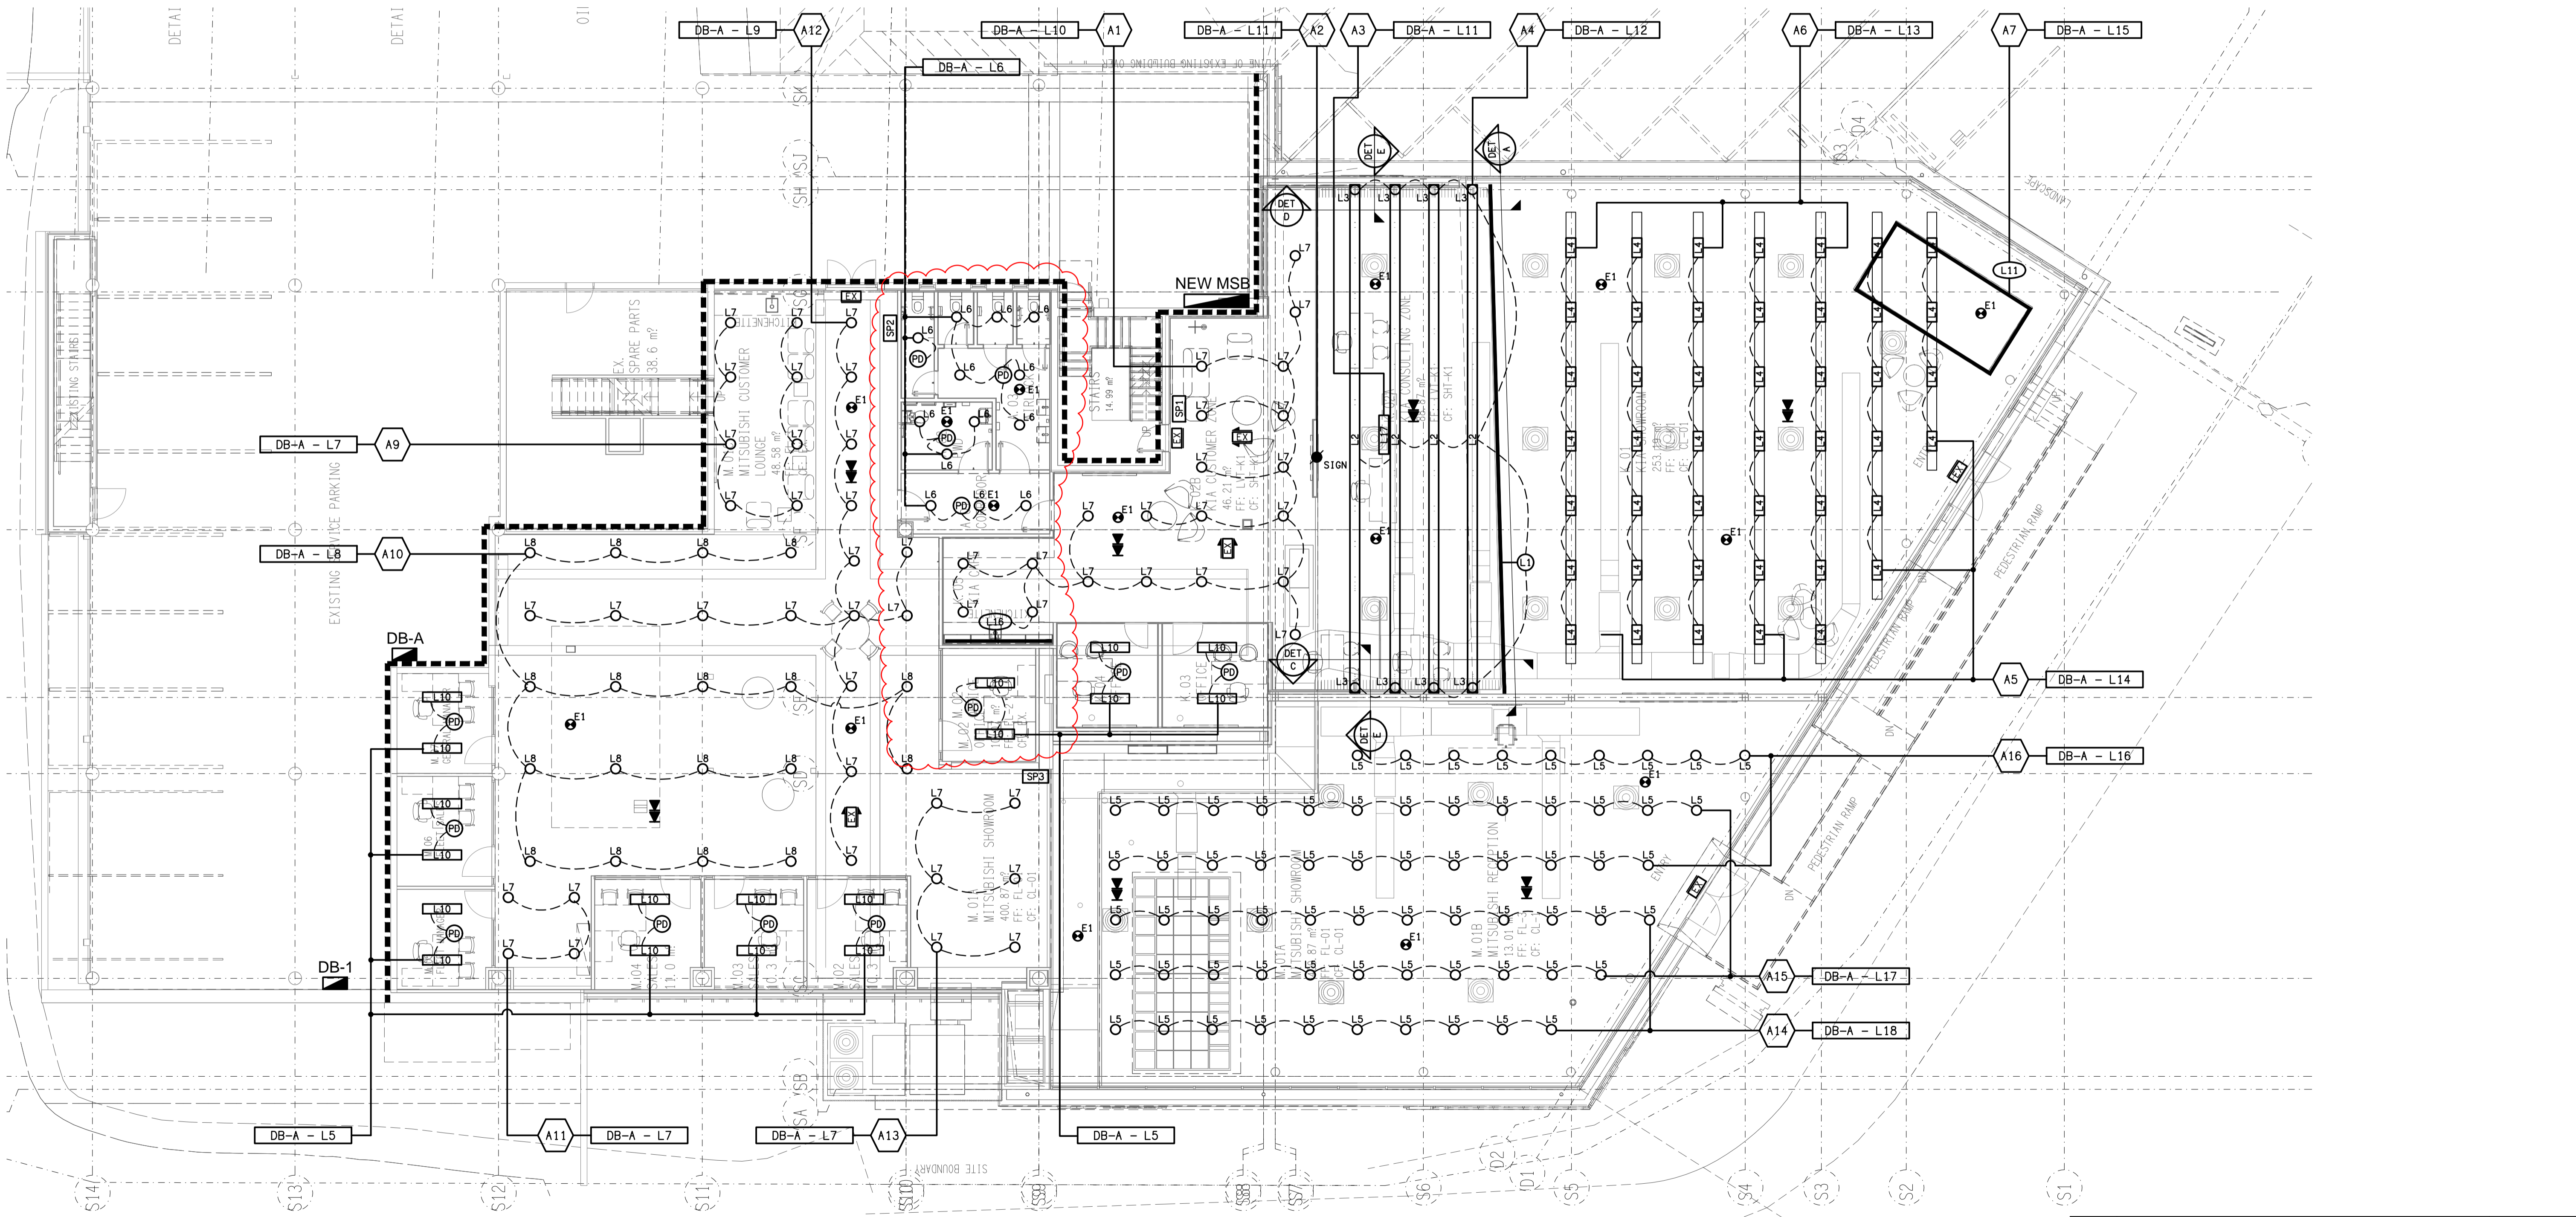

ELECTRICAL DESIGN GROUP BRISBANE  
PTY LTD  
ACN 092 710 793  
TRADING AS:  
ELECTRICAL DESIGN GROUP

THE COPYRIGHT OF THIS DRAWING  
REMAINS THE PROPERTY OF THE  
ELECTRICAL DESIGN GROUP.  
USE FIGURED DIMENSIONS  
IN PREFERENCE TO SCALE.  
ALL DIMENSIONS TO BE  
VERIFIED ONSITE.

**ELECTRICAL DESIGN GROUP**  
ELECTRICAL BUILDING SERVICES CONSULTANTS  
BRISBANE GOLD COAST  
P.O. Box 15, Sherwood Q.4075  
Phone: (07) 3278 4375  
Email: brisbane@edg.net.au  
Web: www.edg.net.au

PROJECT:  
**TOOWONG KIA & MITSUBISHI**  
601 MILTON ROAD, TOOWONG

D	CONSTRUCTION	17/02/2025
REV:	DESCRIPTION:	DATE:
DRAWING: <b>ELECTRICAL SERVICES GROUND LEVEL SHOWROOM REFLECTED CEILING PLAN</b>		
SCALE: 1:100	PROJECT NO: AT A1 <b>C3227a</b>	DRAWING NO: <b>E05</b>
		REVISION: <b>D</b>