


DETAIL A
 CAFE / KITCHEN FLOOR PLAN
 SCALE 1:50

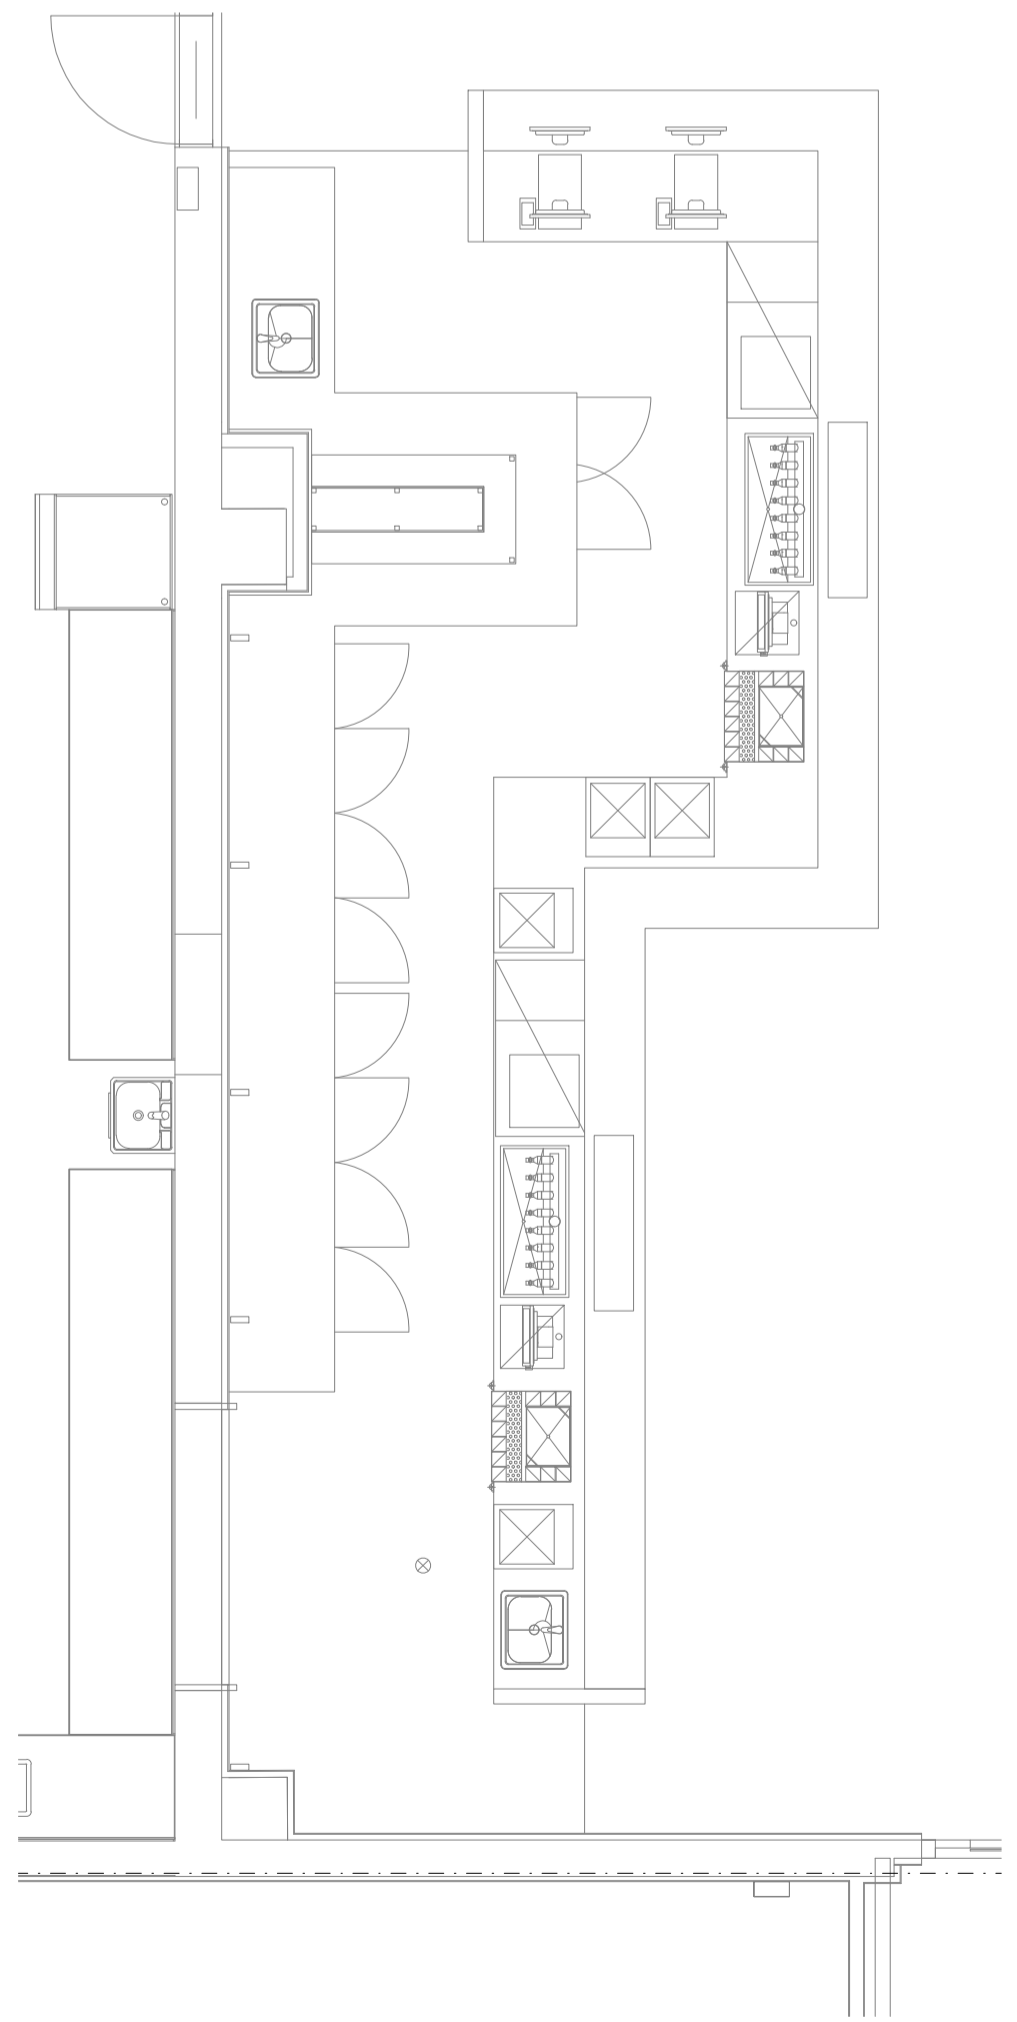

DETAIL B
 SPORTS BAR FLOOR PLAN
 SCALE 1:50

THE COPYRIGHT OF THIS DRAWING REMAINS THE PROPERTY OF THE ELECTRICAL DESIGN GROUP.
 USE FIGURED DIMENSIONS IN PREFERENCE TO SCALE.
 ALL DIMENSIONS TO BE VERIFIED ONSITE.

A	PRELIMINARY	26/07/2024
REV:	DESCRIPTION:	DATE:

ELECTRICAL DESIGN GROUP
 ELECTRICAL BUILDING SERVICES CONSULTANTS

BRISBANE: P.O. Box 15 Sherwood Qld 4075
 Phone: (07) 3278 4375
 Email: brisbane@edg.net.au
 Web: www.edg.net.au

ELECTRICAL DESIGN GROUP BRISBANE / TRADING AS: ELECTRICAL DESIGN GROUP
 PTY LTD / ACN 092 710 793

PROJECT:
CABOOLTURE SPORTS CLUB REFURBISHMENT

SITE ADDRESS:
 19-27 STATION ROAD, MORAYFIELD

SCALE: 1:100 UNO SHEET SIZE: AT A1

DRAWING TITLE:
ELECTRICAL SERVICES GROUND LEVEL PART B FLOOR PLAN

PROJECT NO: DRAWING NO: REVISION:
C3264a E04 A