



**LOWER LEVEL
FLOOR PLAN**
SCALE 1:100

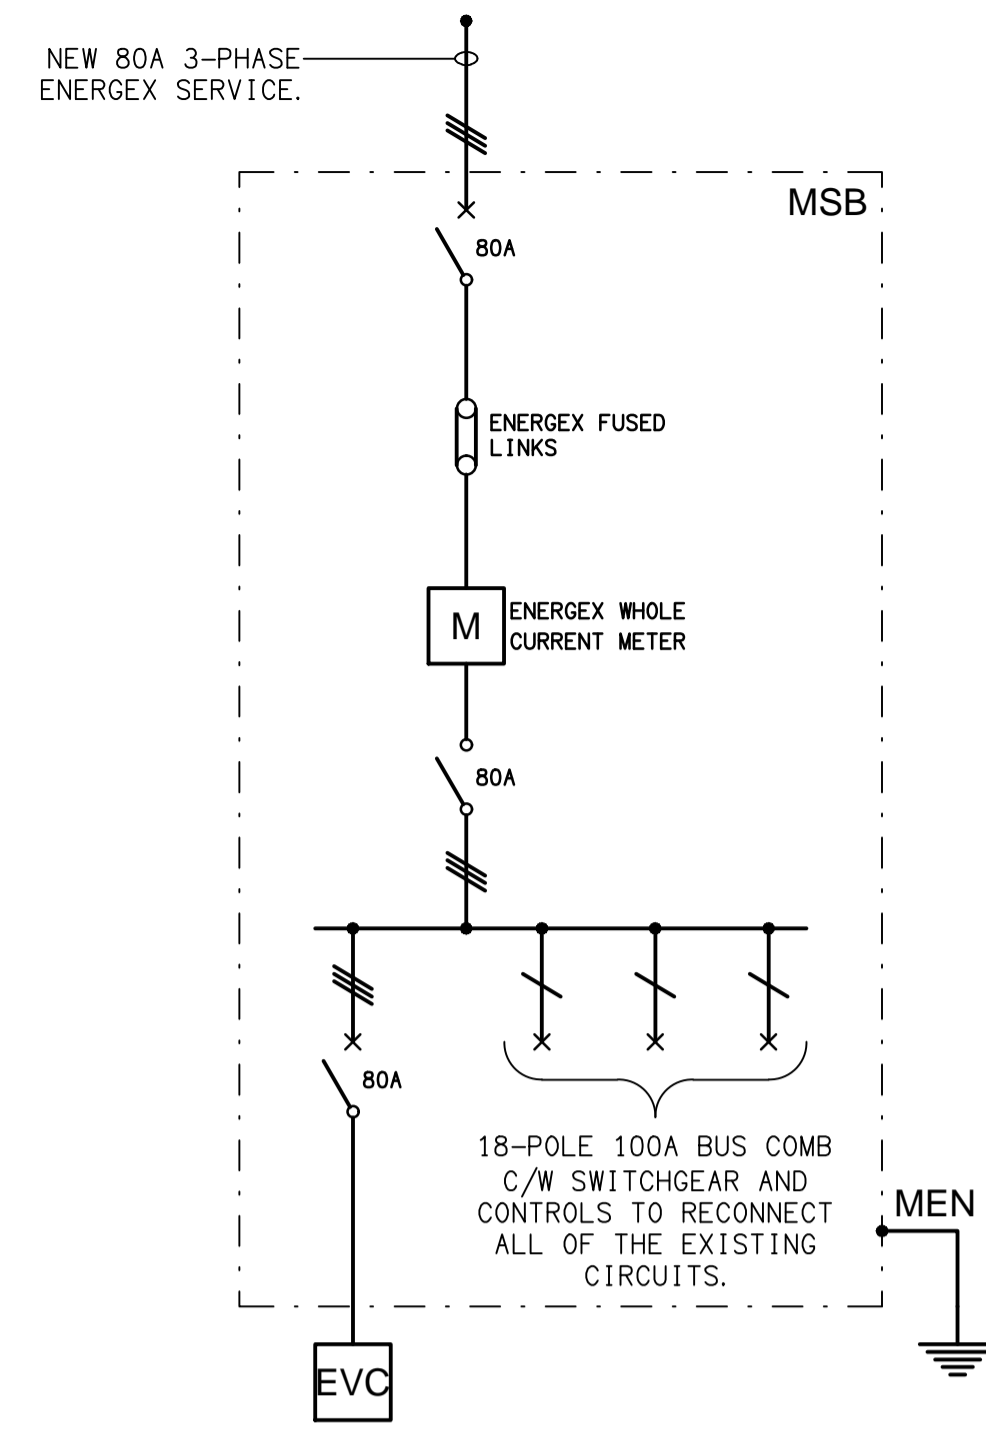


**SCHEMATIC
MSB POWER ARRANGEMENTS**
NOT TO SCALE

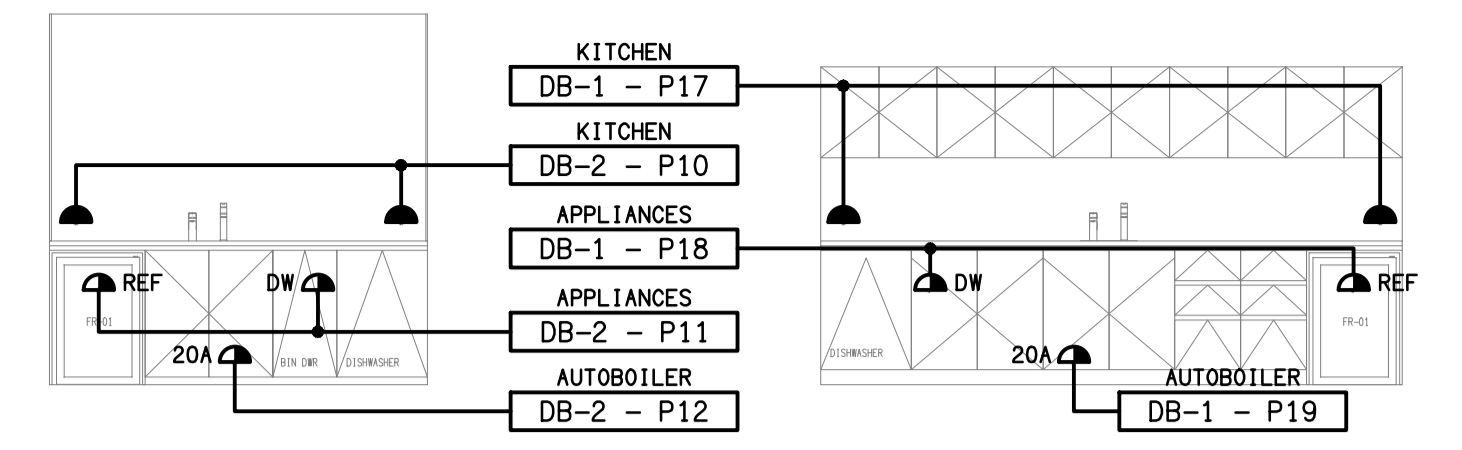

**DETAIL A
KIA KITCHENETTE**
SCALE 1:50


**DETAIL B
MITSUBISHI KITCHENETTE**
SCALE 1:50

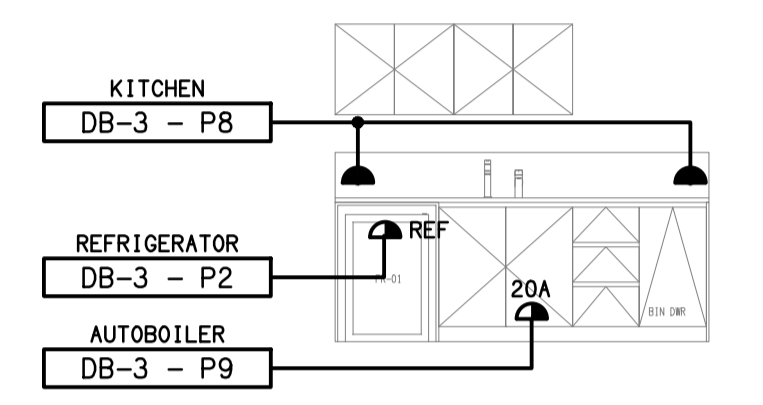

**DETAIL C
SERVICE KITCHENETTE**
SCALE 1:50

EXISTING ELECTRICAL SERVICES OUTSIDE OF THIS AREA ARE TO REMAIN AS IS UNLESS NOTED OTHERWISE

EXISTING ELECTRICAL SERVICES WITHIN THIS AREA ARE TO REMAIN AS IS UNLESS NOTED OTHERWISE

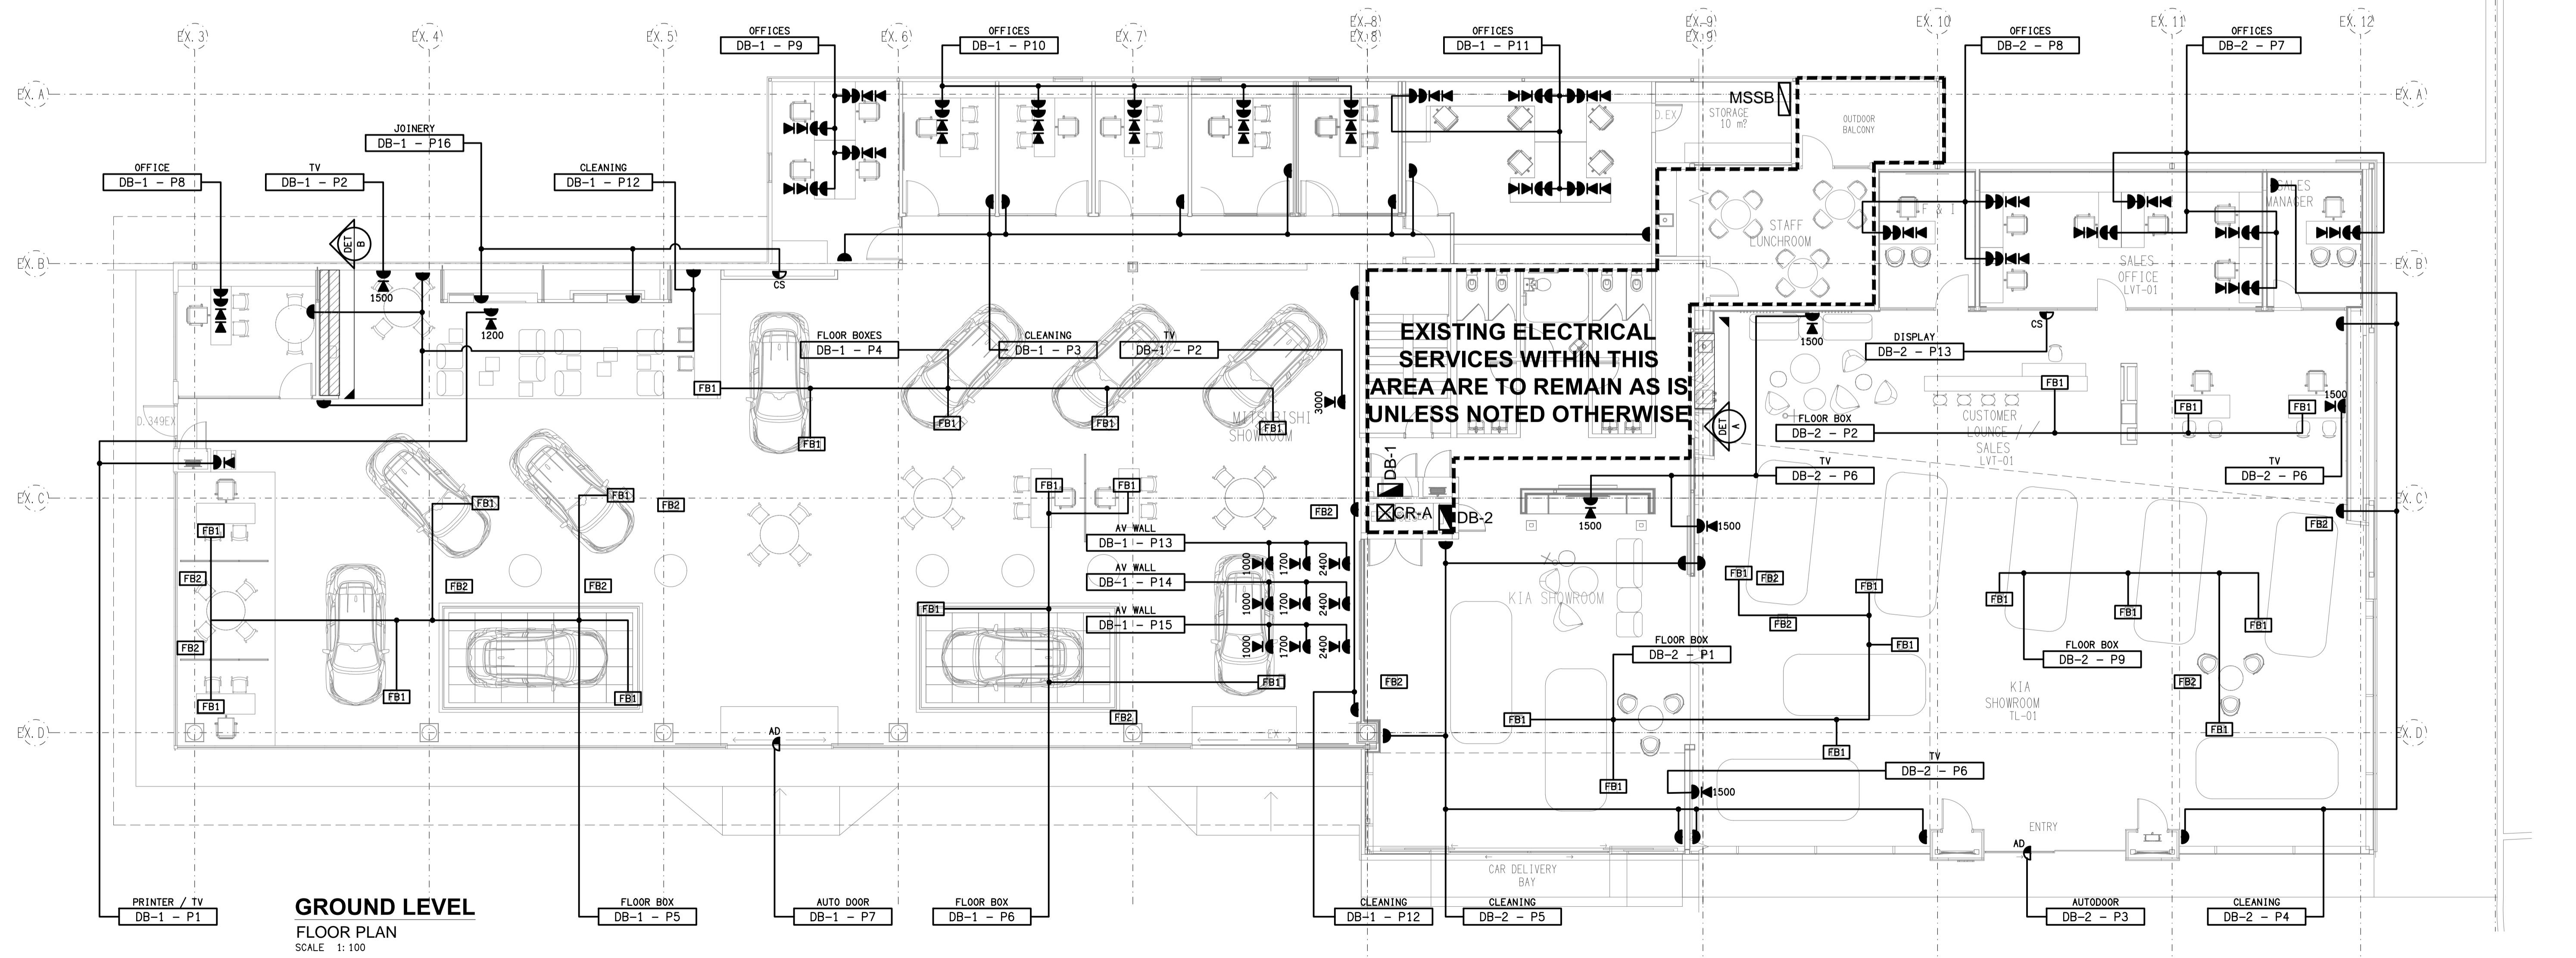

**GROUND LEVEL
FLOOR PLAN**
SCALE 1:100

ELECTRICAL DESIGN GROUP BRISBANE PTY LTD
ACN 092 710 793
TRADING AS:
ELECTRICAL DESIGN GROUP

THE COPYRIGHT OF THIS DRAWING REMAINS THE PROPERTY OF THE ELECTRICAL DESIGN GROUP.
USE FIGURED DIMENSIONS IN PREFERENCE TO SCALE.
ALL DIMENSIONS TO BE VERIFIED ONSITE.

ELECTRICAL DESIGN GROUP
ELECTRICAL BUILDING SERVICES CONSULTANTS
BRISBANE GOLD COAST

P.O. Box 15, Sherwood Q.4075
Phone: (07) 3278 4375
Email: brisbane@edg.net.au
Web: www.edg.net.au

PROJECT:
EAGERS MT GRAVATT - MITSUBISHI & KIA

1332 LOGAN ROAD, MT GRAVATT

D	CONSTRUCTION	23/01/2025
REV:	DESCRIPTION:	DATE:

DRAWING:
**ELECTRICAL SERVICES
FLOOR PLANS**

SCALE:
1:100

PROJECT NO:
C3284a

DRAWING NO:
E03

REVISION:
D