



LOWER LEVEL
FLOOR PLAN
SCALE 1:100

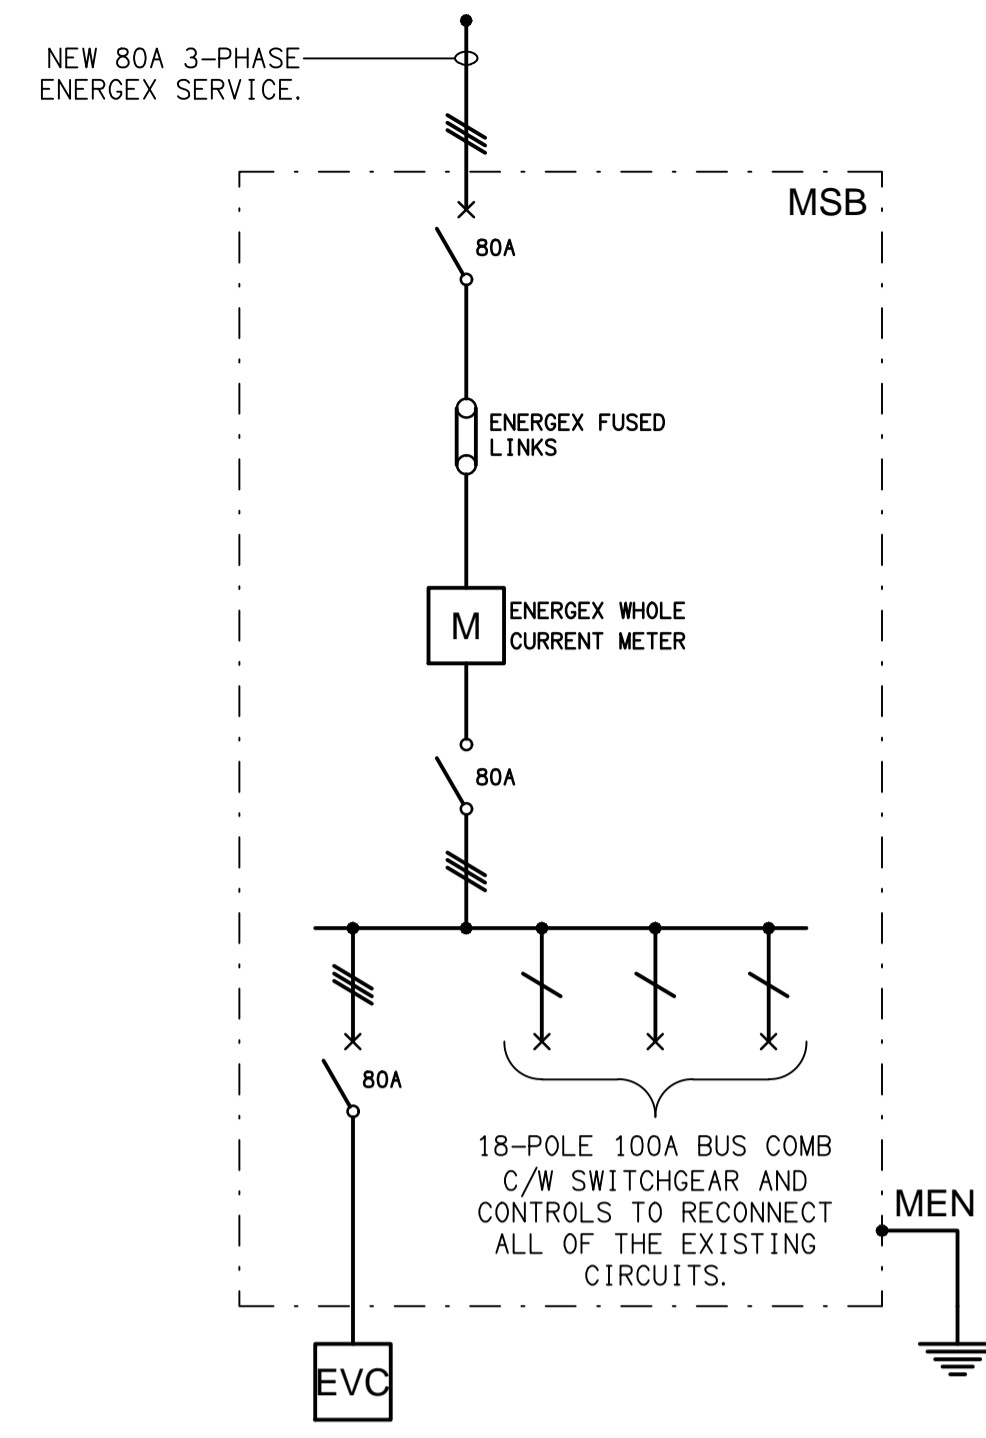


SCHEMATIC
MSB POWER ARRANGEMENTS
NOT TO SCALE

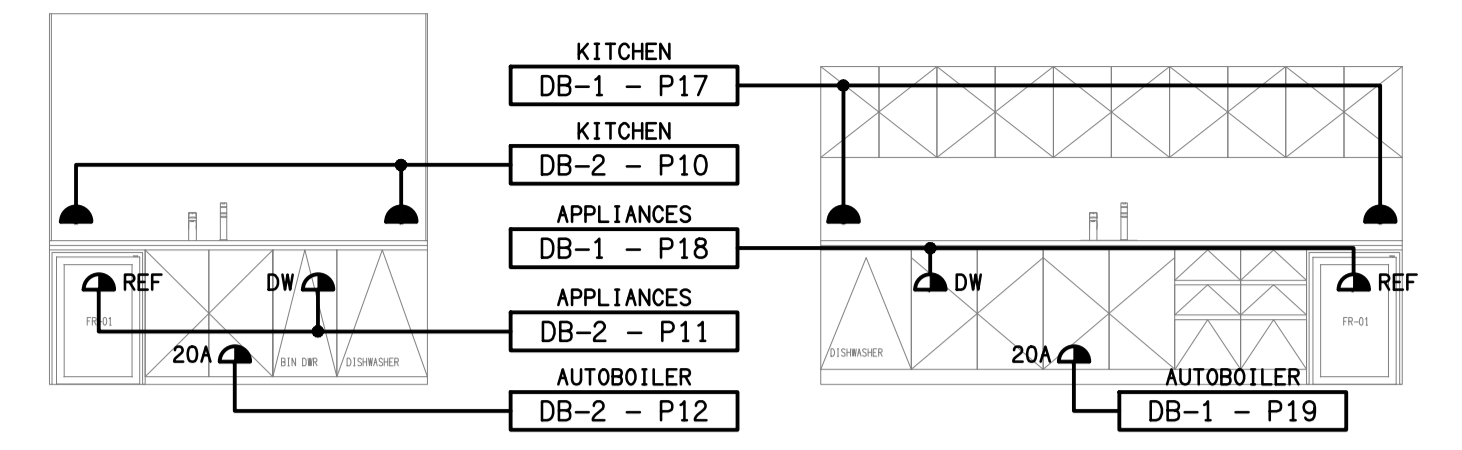


DETAIL A
KIA KITCHENETTE
SCALE 1:50

DETAIL B
MITSUBISHI KITCHENETTE
SCALE 1:50

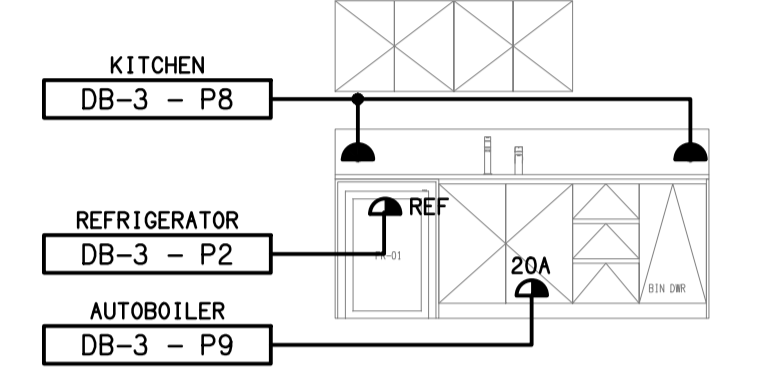

DETAIL C
SERVICE KITCHENETTE
SCALE 1:50

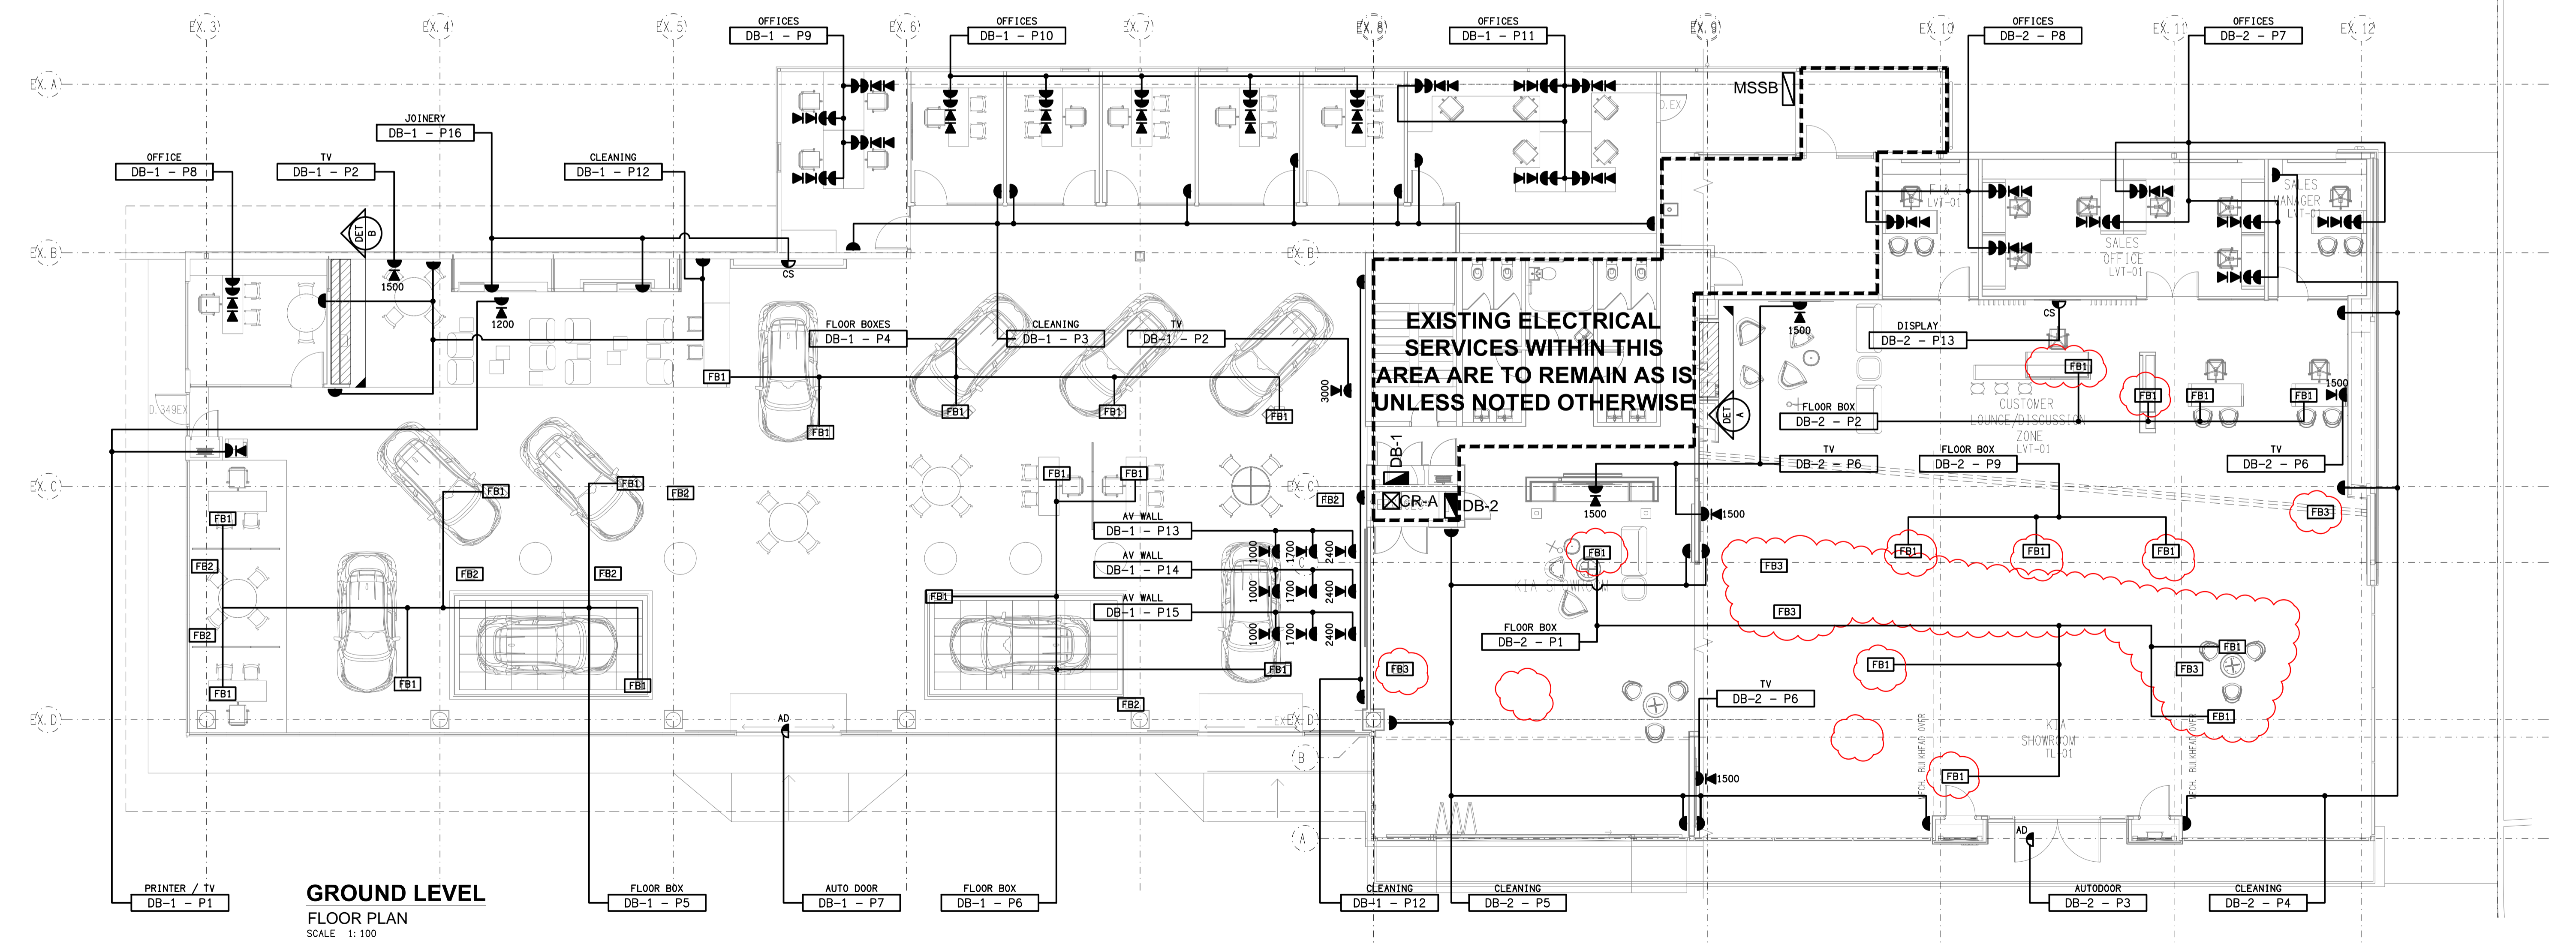

GROUND LEVEL
FLOOR PLAN
SCALE 1:100

ELECTRICAL DESIGN GROUP BRISBANE
PTY LTD
ACN 092 710 793
TRADING AS:
ELECTRICAL DESIGN GROUP

THE COPYRIGHT OF THIS DRAWING
REMAINS THE PROPERTY OF THE
ELECTRICAL DESIGN GROUP.
USE FIGURED DIMENSIONS
IN PREFERENCE TO SCALE.
ALL DIMENSIONS TO BE
VERIFIED ONSITE.

ELECTRICAL DESIGN GROUP
ELECTRICAL BUILDING SERVICES CONSULTANTS
BRISBANE GOLD COAST

P.O. Box 15, Sherwood Q.4075
Phone: (07) 3278 4375
Email: brisbane@edg.net.au
Web: www.edg.net.au

PROJECT:
EAGERS MT GRAVATT - MITSUBISHI & KIA

1332 LOGAN ROAD, MT GRAVATT

F	CONSTRUCTION	19/02/2025
REV:	DESCRIPTION:	DATE:

DRAWING:
**ELECTRICAL SERVICES
FLOOR PLANS**

SCALE:
1:100

PROJECT NO:
C3284a

DRAWING NO:
E03

REVISION:
F