




DETAIL C
L3 LIGHTING ELEVATION
SCALE 1:50

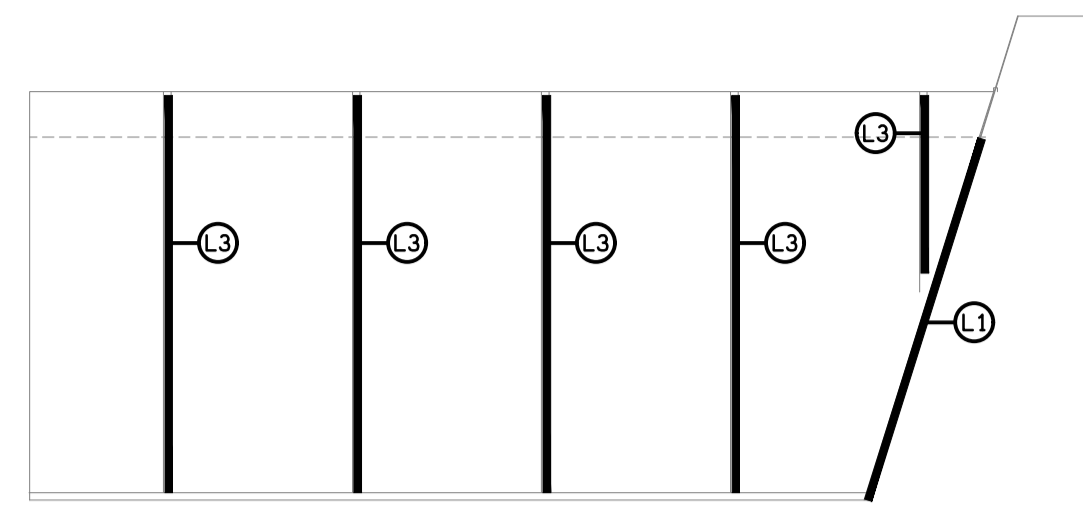


DETAIL D
L3 LIGHTING ELEVATION
SCALE 1:50

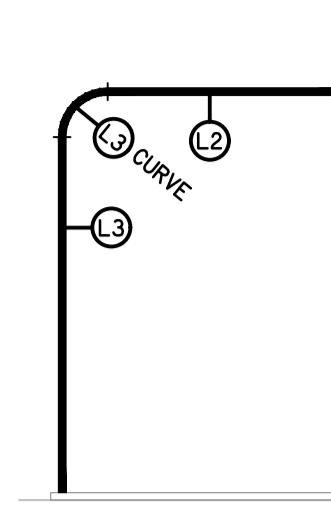


DETAIL E
L3 / L2 LIGHTING SECTION
SCALE 1:50

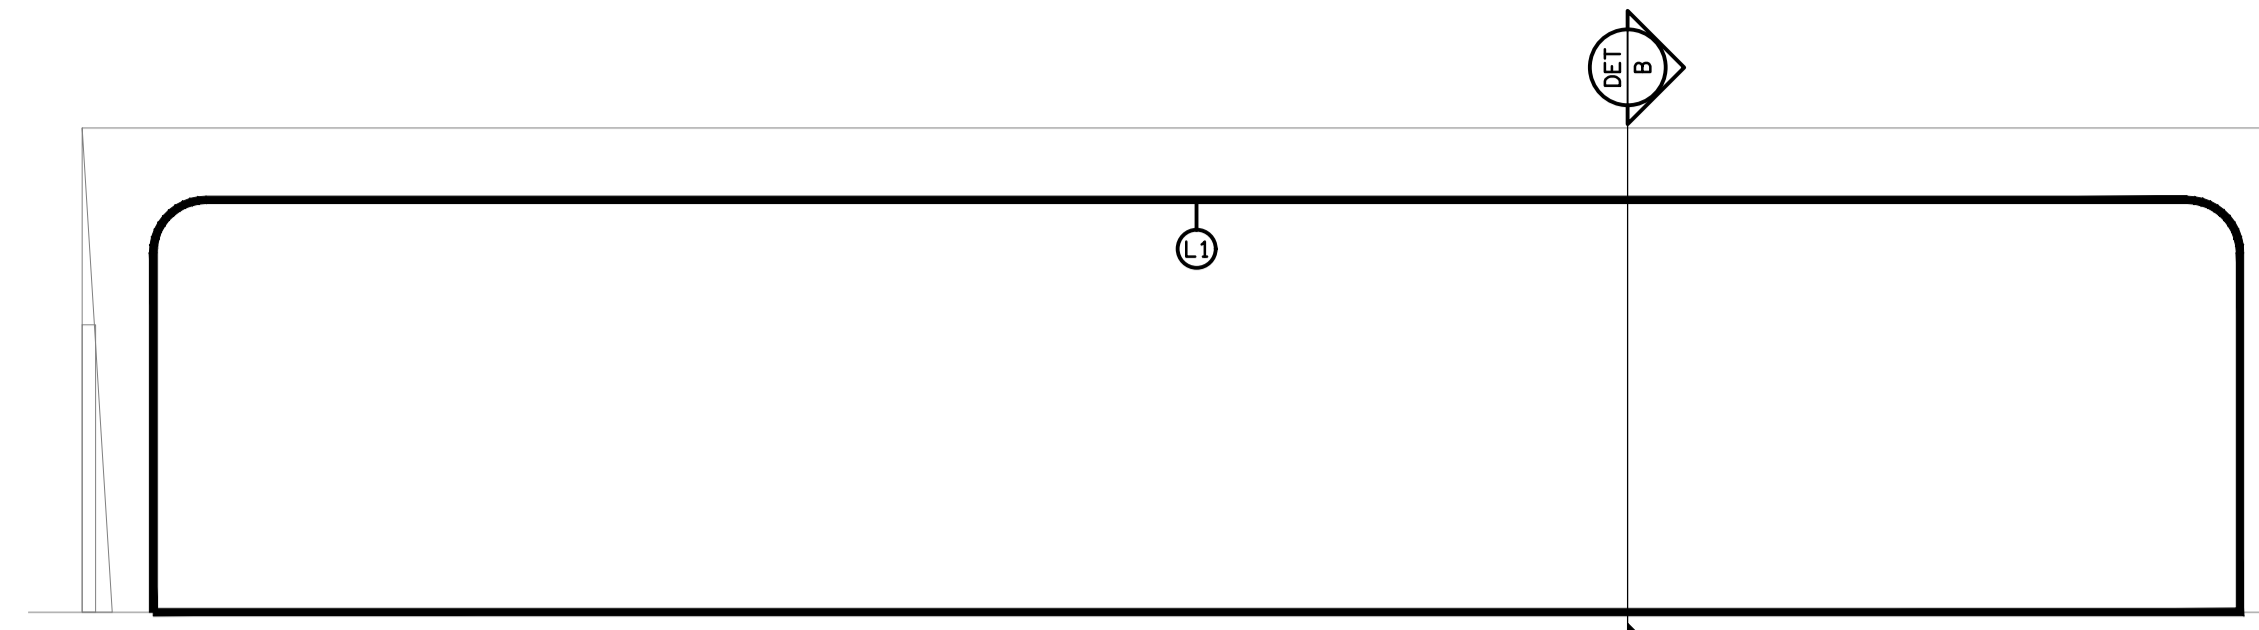

DETAIL A
L1 LIGHTING ELEVATION
SCALE 1:50

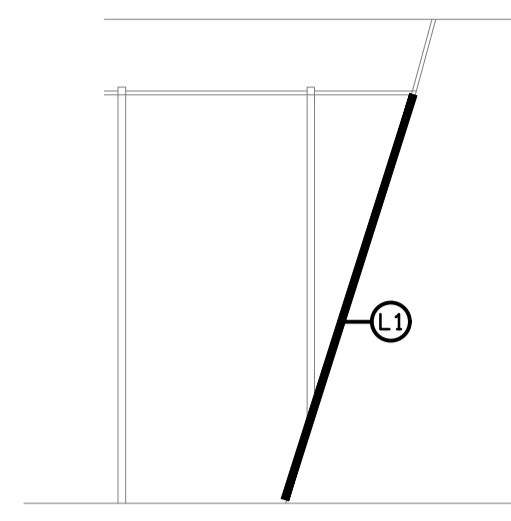

DETAIL B
L1 LIGHTING SECTION
SCALE 1:50

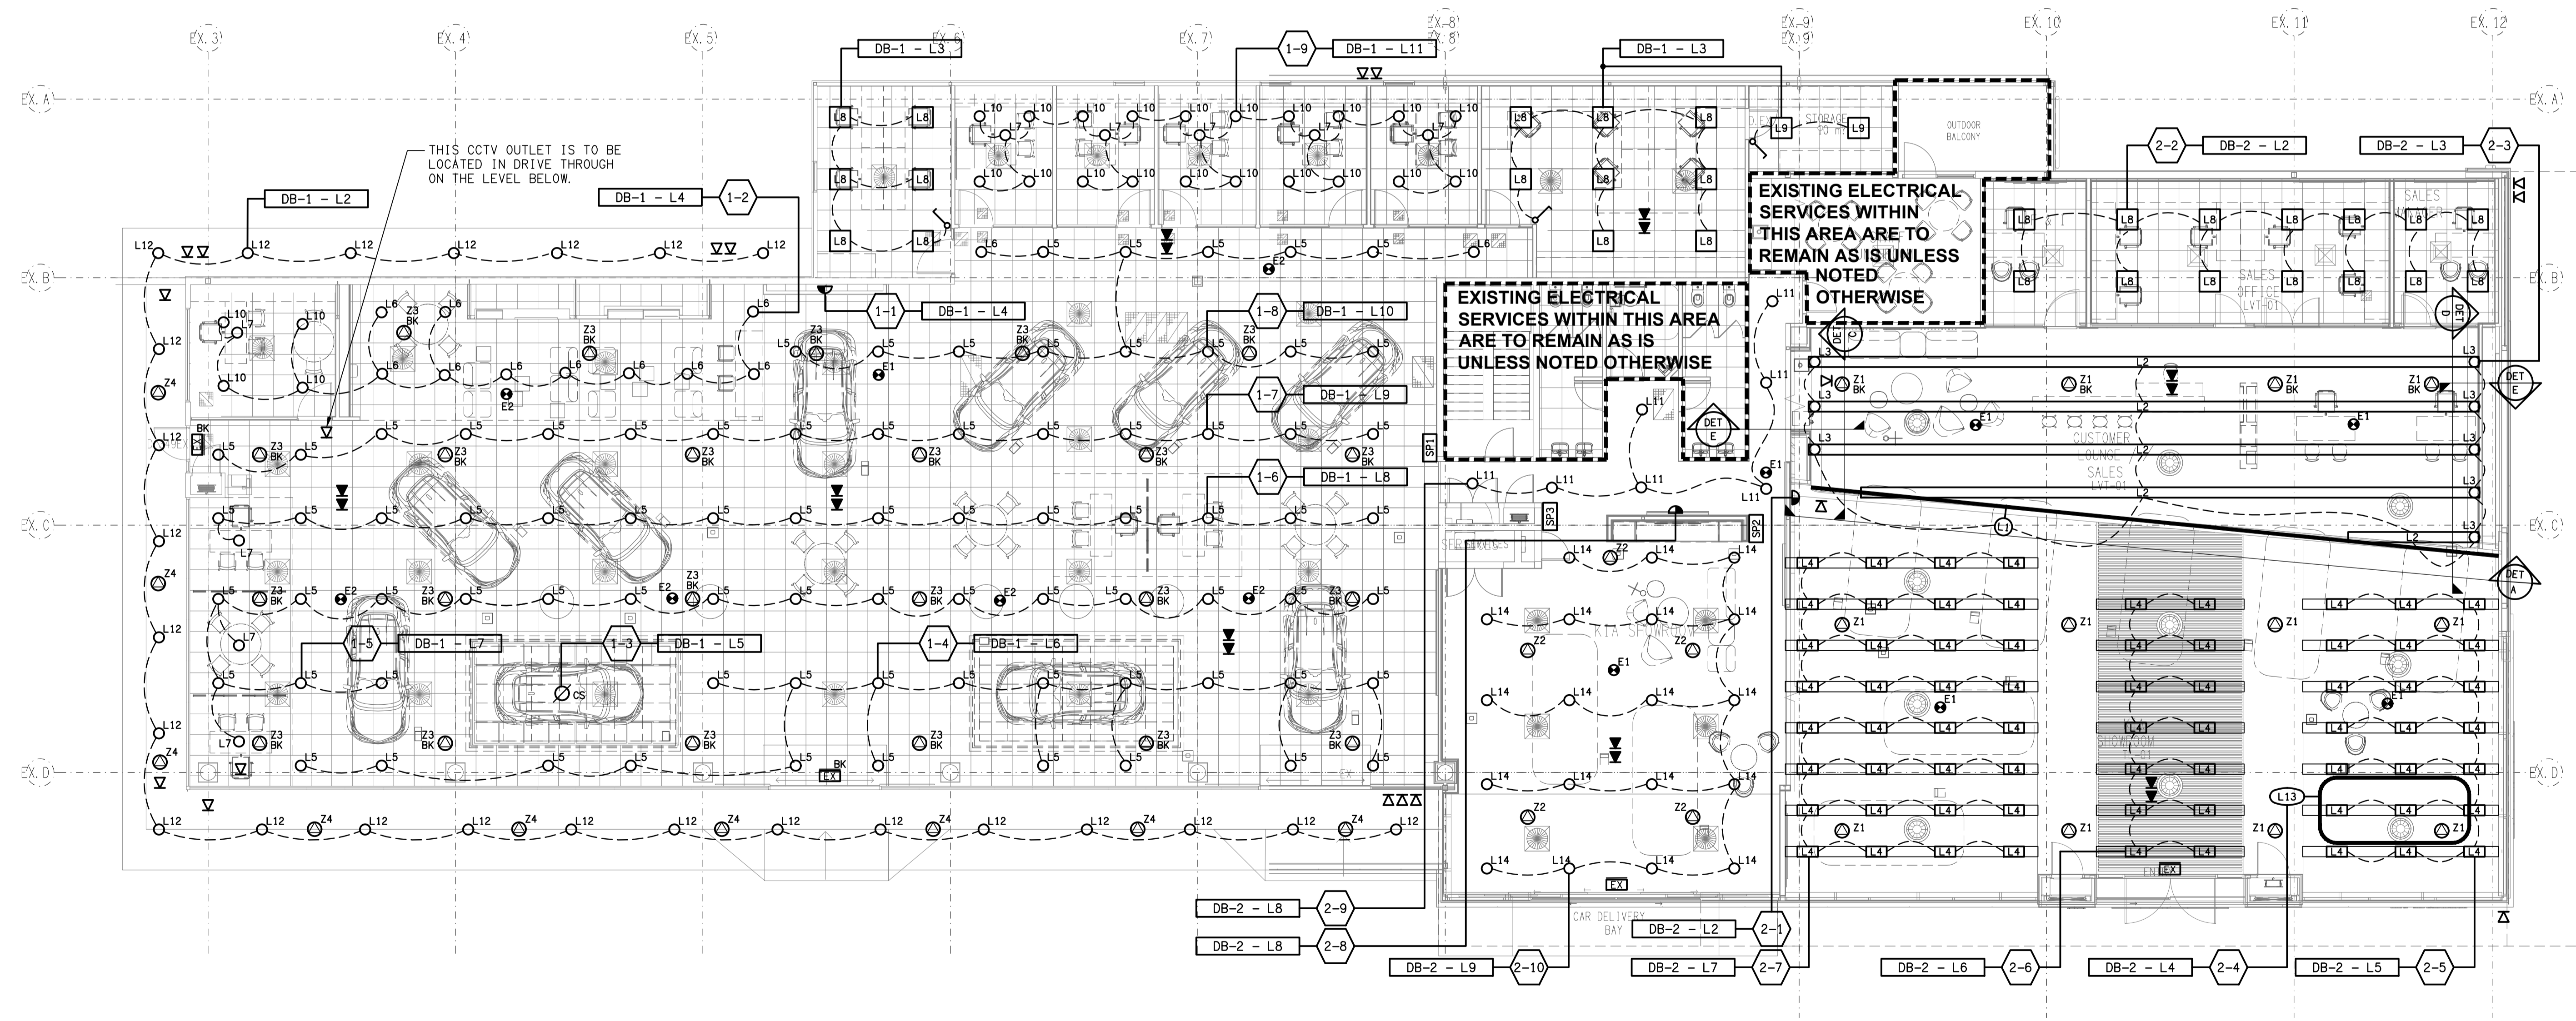

ELECTRICAL DESIGN GROUP BRISBANE
PTY LTD
ACN 092 710 793
TRADING AS:
ELECTRICAL DESIGN GROUP

THE COPYRIGHT OF THIS DRAWING
REMAINS THE PROPERTY OF THE
ELECTRICAL DESIGN GROUP.
USE FIGURED DIMENSIONS
IN PREFERENCE TO SCALE.
ALL DIMENSIONS TO BE
VERIFIED ONSITE.

ELECTRICAL DESIGN GROUP
ELECTRICAL BUILDING SERVICES CONSULTANTS
BRISBANE GOLD COAST
P.O. Box 15, Sherwood Q. 4075
Phone: (07) 3278 4375
Email: brisbane@edg.net.au
Web: www.edg.net.au

PROJECT:
EAGERS MT GRAVATT - MITSUBISHI & KIA
1332 LOGAN ROAD, MT GRAVATT

E	CONSTRUCTION	23/01/2025
REV.	DESCRIPTION:	DATE:
DRAWING: ELECTRICAL SERVICES REFLECTED CEILING PLANS		
SCALE: 1:100	AT A1	PROJECT NO: C3284a
		DRAWING NO: E04
		REVISION: E