


FLOOR PLAN
ALFA / FIAT & JEEP
SCALE 1:50

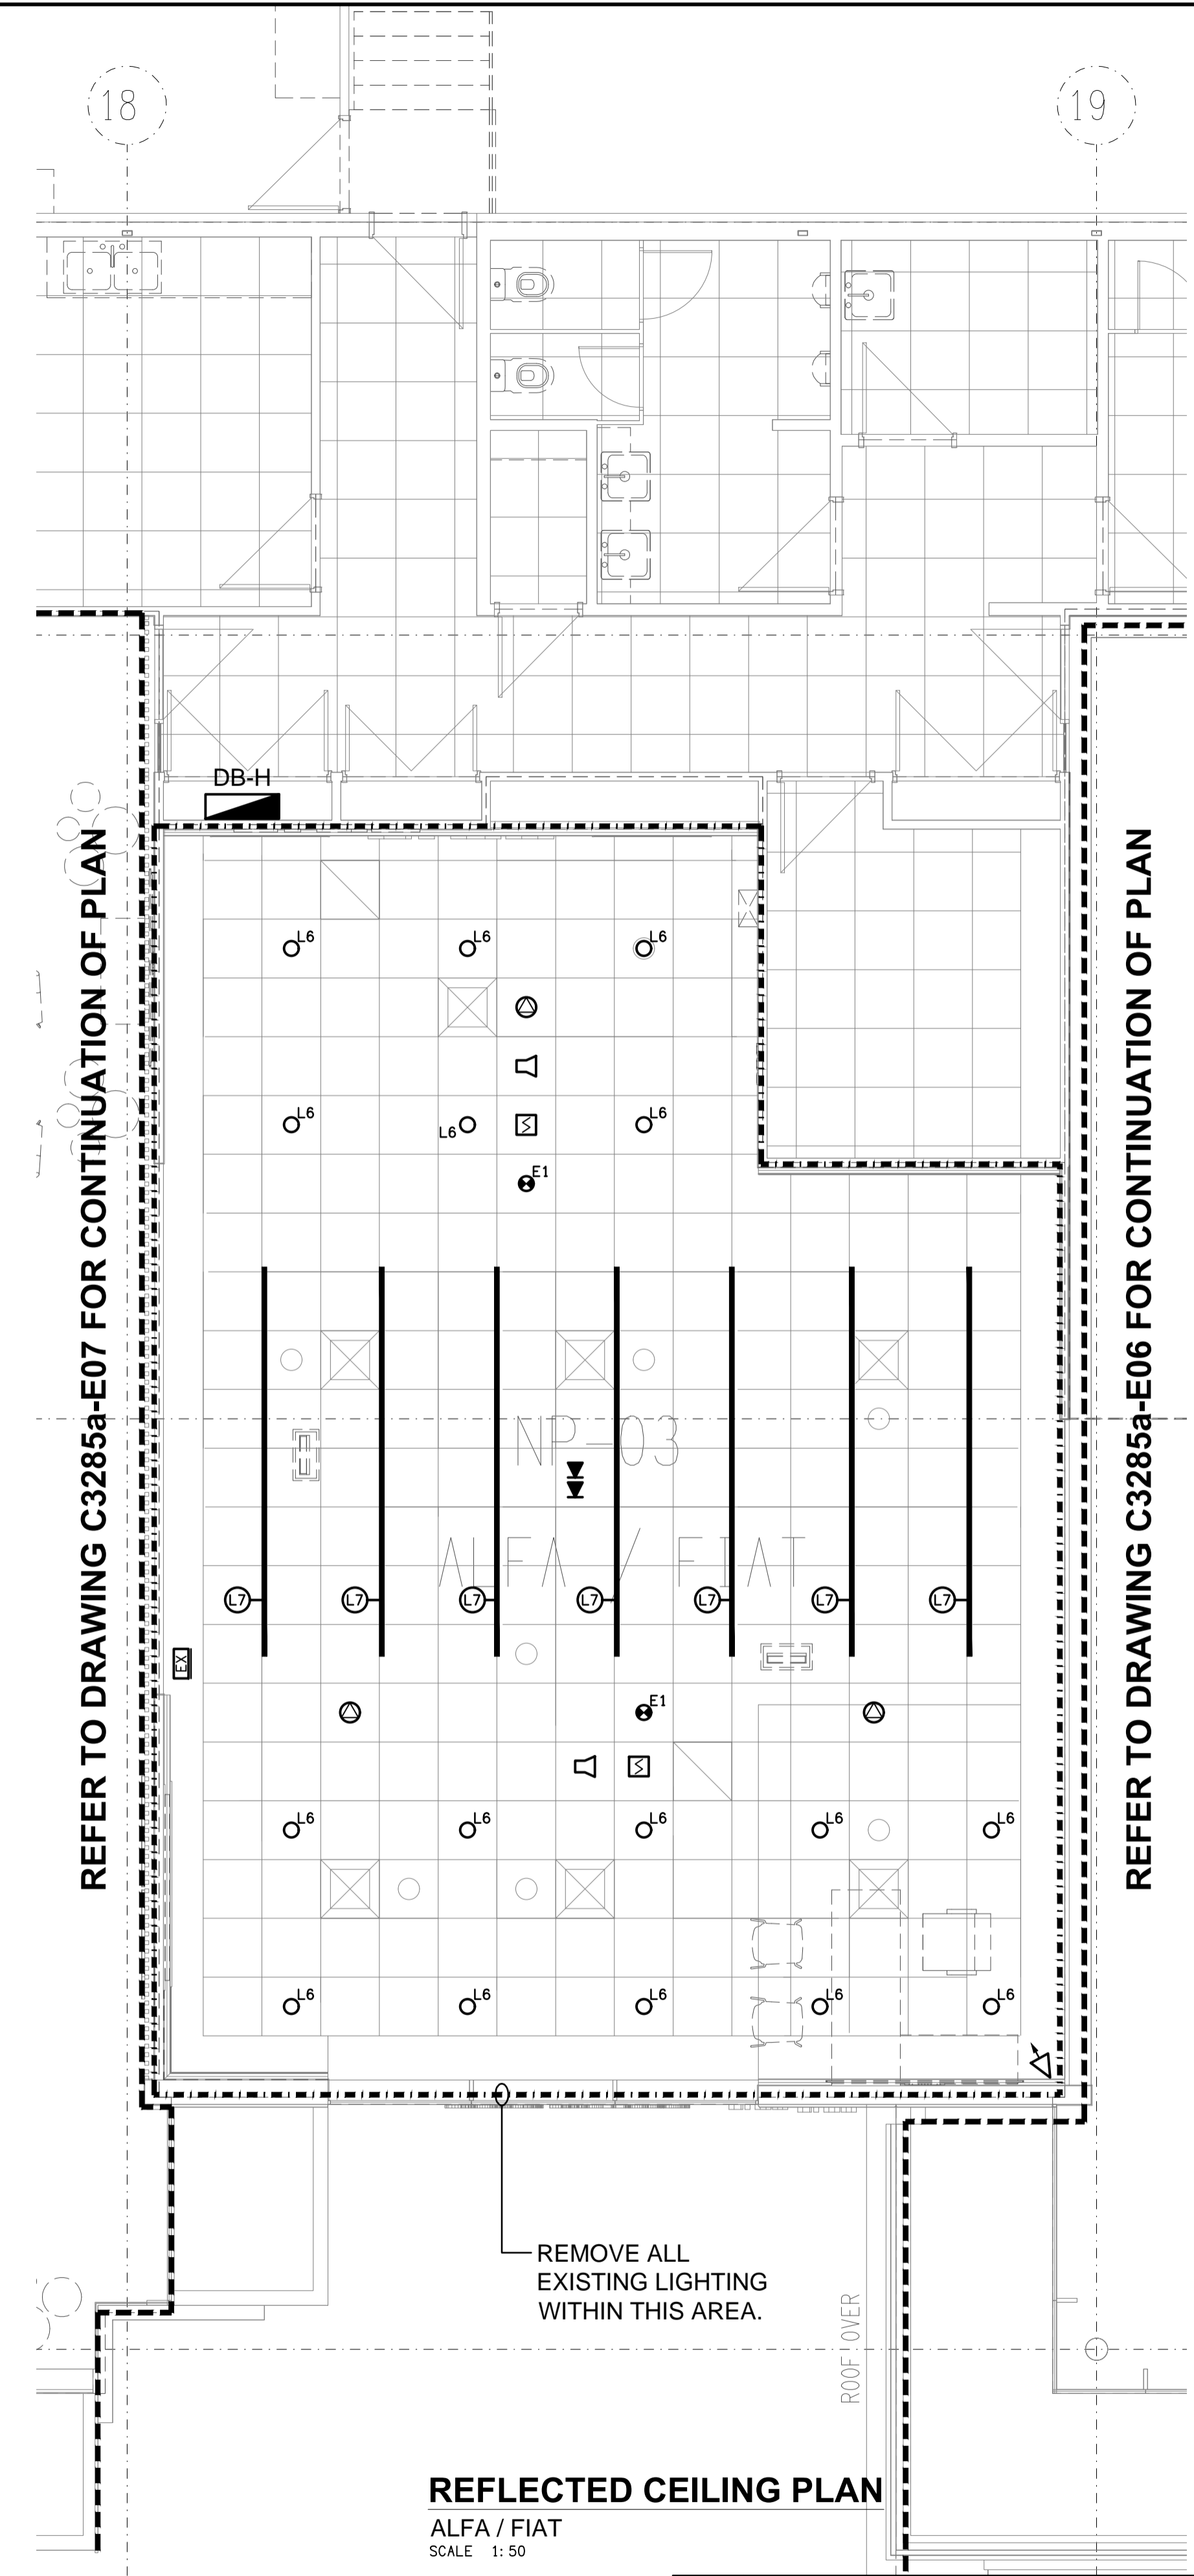

REFLECTED CEILING PLAN
ALFA / FIAT
SCALE 1:50

ELECTRICAL DESIGN GROUP BRISBANE
PTY LTD
ACN 092 710 793
TRADING AS:
ELECTRICAL DESIGN GROUP

THE COPYRIGHT OF THIS DRAWING
REMAINS THE PROPERTY OF THE
ELECTRICAL DESIGN GROUP.
USE FIGURED DIMENSIONS
IN PREFERENCE TO SCALE.
ALL DIMENSIONS TO BE
VERIFIED ONSITE.

ELECTRICAL DESIGN GROUP
ELECTRICAL BUILDING SERVICES CONSULTANTS
BRISBANE GOLD COAST
P.O. Box 15, Sherwood Q.4075
Phone: (07) 3278 4375
Email: brisbane@edg.net.au
Web: www.edg.net.au

PROJECT:
EAGERS ASPLEY AUTOMALL
1442 GYMPIE ROAD, ASPLEY, QUEENSLAND

C	CONSTRUCTION	20/01/2025
REV.	DESCRIPTION:	DATE:
DRAWING: ELECTRICAL SERVICES ALFA / FIAT FLOOR PLAN & REFLECTED CEILING PLAN		
SCALE: 1:50	PROJECT NO: C3285a	DRAWING NO: E05
AT A1	REVISION: C	