




**NOTE:**  
ALL WORKSHOP AND ASSOCIATED STORE ROOMS ARE TO HAVE BLACK OR IP65 OUTLETS.

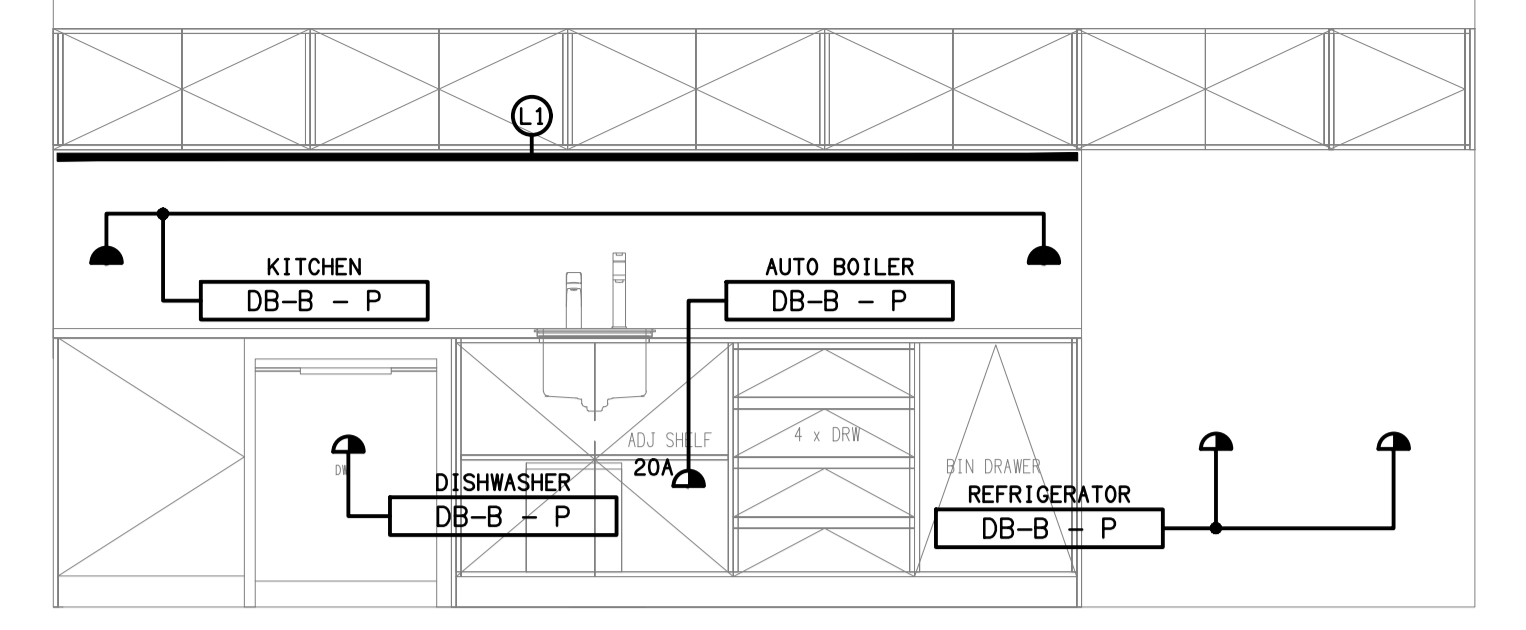


**DETAIL A**  
LUNCH ROOM 1 KITCHENETTE ELEVATION  
SCALE 1:25

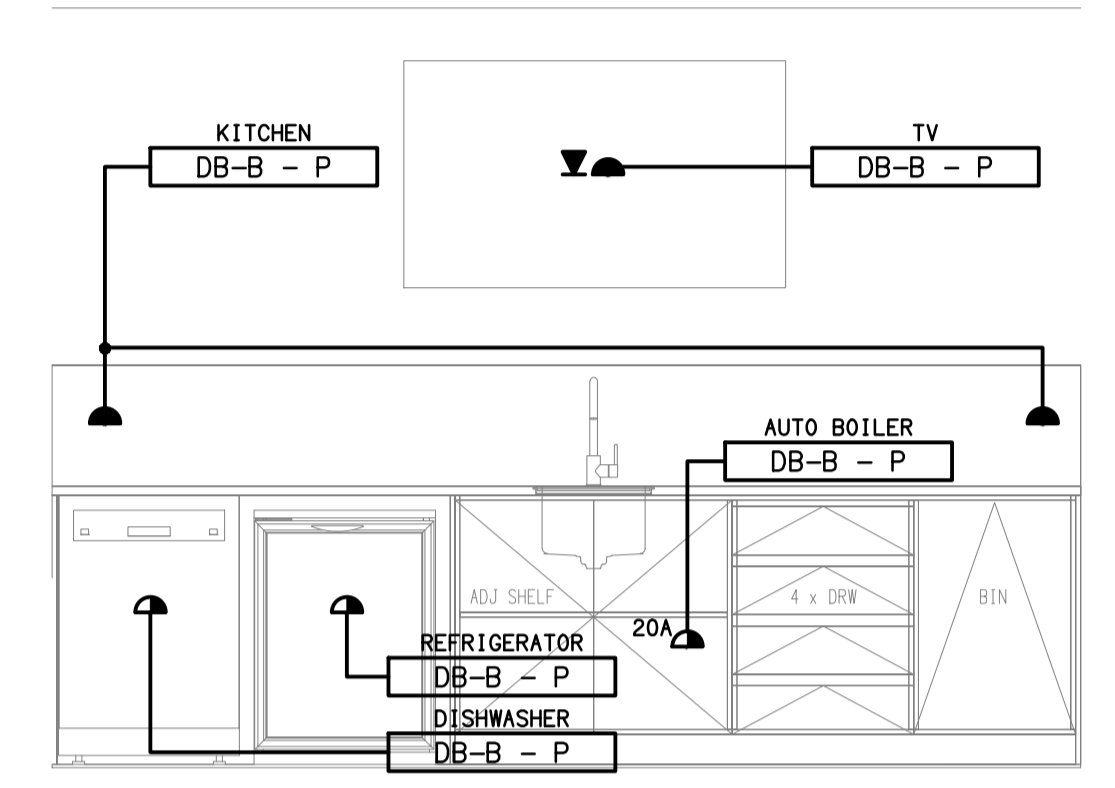

**DETAIL B**  
RECEPTION CAFE KITCHENETTE  
SCALE 1:25

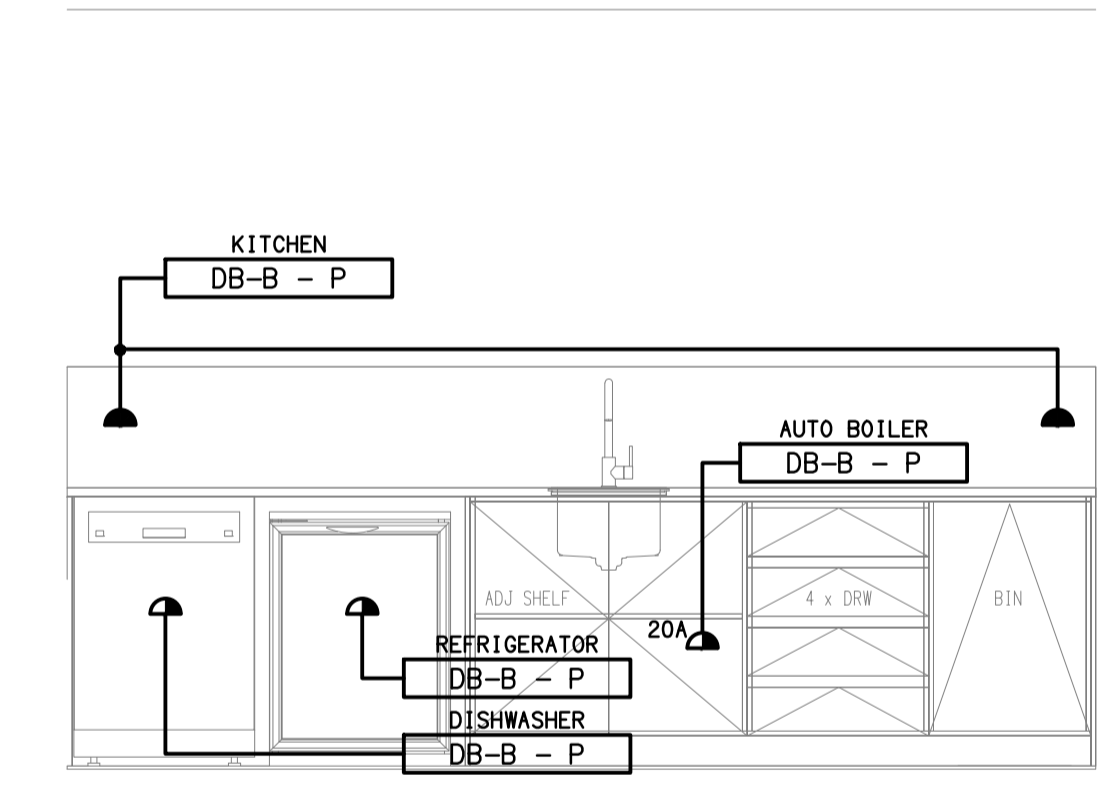

**DETAIL C**  
SHOWROOM CAFE KITCHENETTE  
SCALE 1:25

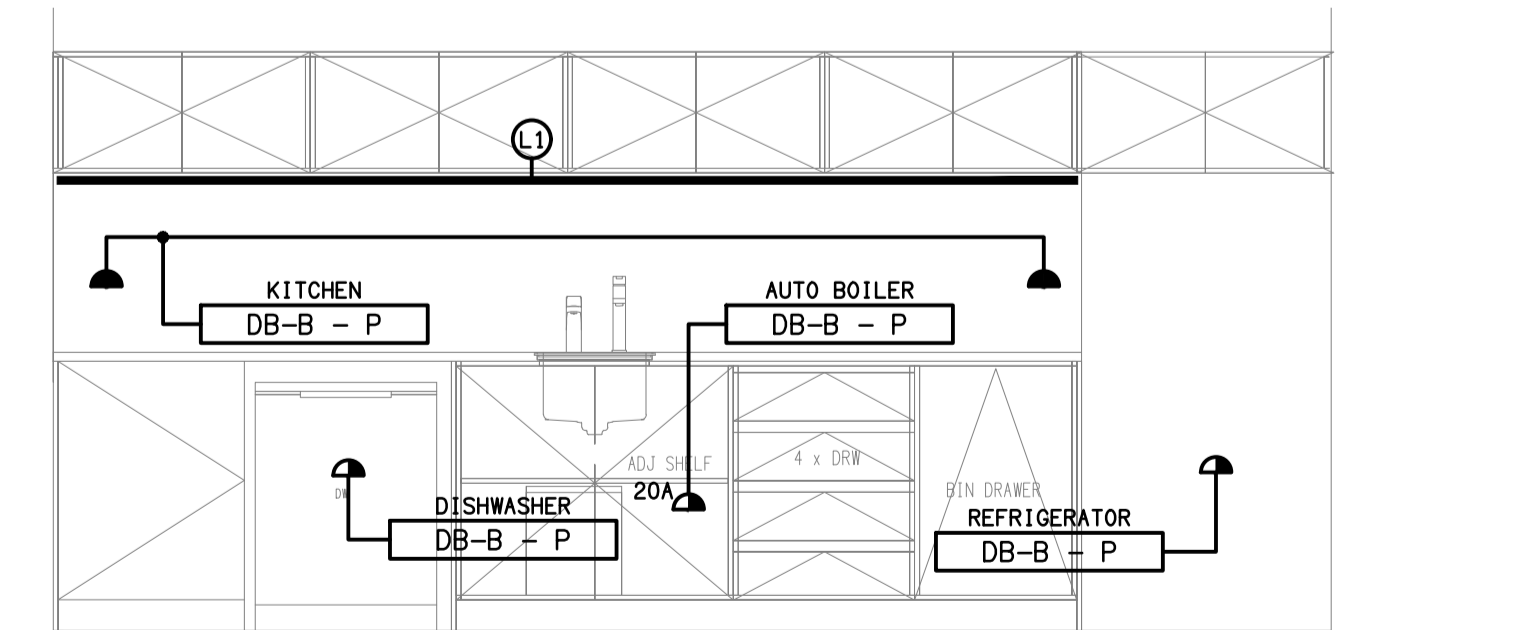

**DETAIL D**  
LUNCH ROOM 2 KITCHENETTE ELEVATION  
SCALE 1:25

ELECTRICAL DESIGN GROUP BRISBANE PTY LTD  
ACN 092 710 793  
TRADING AS:  
ELECTRICAL DESIGN GROUP

THE COPYRIGHT OF THIS DRAWING REMAINS THE PROPERTY OF THE ELECTRICAL DESIGN GROUP.  
USE FIGURED DIMENSIONS IN PREFERENCE TO SCALE.  
ALL DIMENSIONS TO BE VERIFIED ONSITE.



Rohrig (Qld) Pty Ltd  
ABN 67 093 753 970  
QBSA LIC NO 740842  
250 Abbotsford Road, Bowen Hills Qld 4006  
PO Box 86 Albion DC Qld 4010  
T+61 (7) 3257 4411 F+61 (7) 3257 2211  
www.rohrig.com.au

**ELECTRICAL DESIGN GROUP**  
ELECTRICAL BUILDING SERVICES CONSULTANTS  
BRISBANE GOLD COAST  
P.O. Box 15, Sherwood Q. 4075  
Phone: (07) 3278 4375  
Email: brisbane@edg.net.au  
Web: www.edg.net.au

PROJECT:  
**LLEWELLYN MOTORS SPRINGFIELD - LOT 32**  
LOT 32 AUGUSTA PARKWAY, AUGUSTINE HEIGHTS

B	50% DEVELOPED	28/11/2024
REV:	DESCRIPTION:	DATE:
DRAWING: <b>ELECTRICAL SERVICES</b> <b>GROUND LEVEL FLOOR PLAN</b>		
SCALE: 1:100 UNO	PROJECT NO: <b>C3294a</b>	DRAWING NO: <b>E04</b>
AT A1	REVISION: <b>B</b>	