




DETAIL A
LUNCH ROOM 1 KITCHENETTE ELEVATION
SCALE 1:25

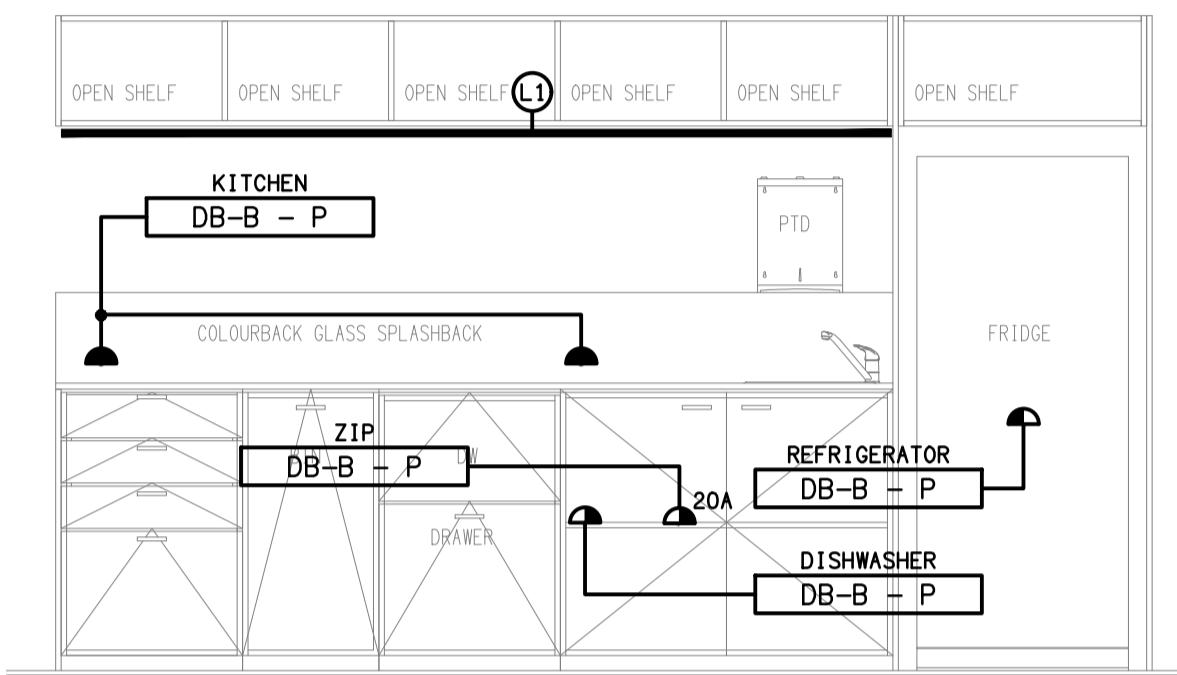

DETAIL B
RECEPTION CAFE KITCHENETTE
SCALE 1:25

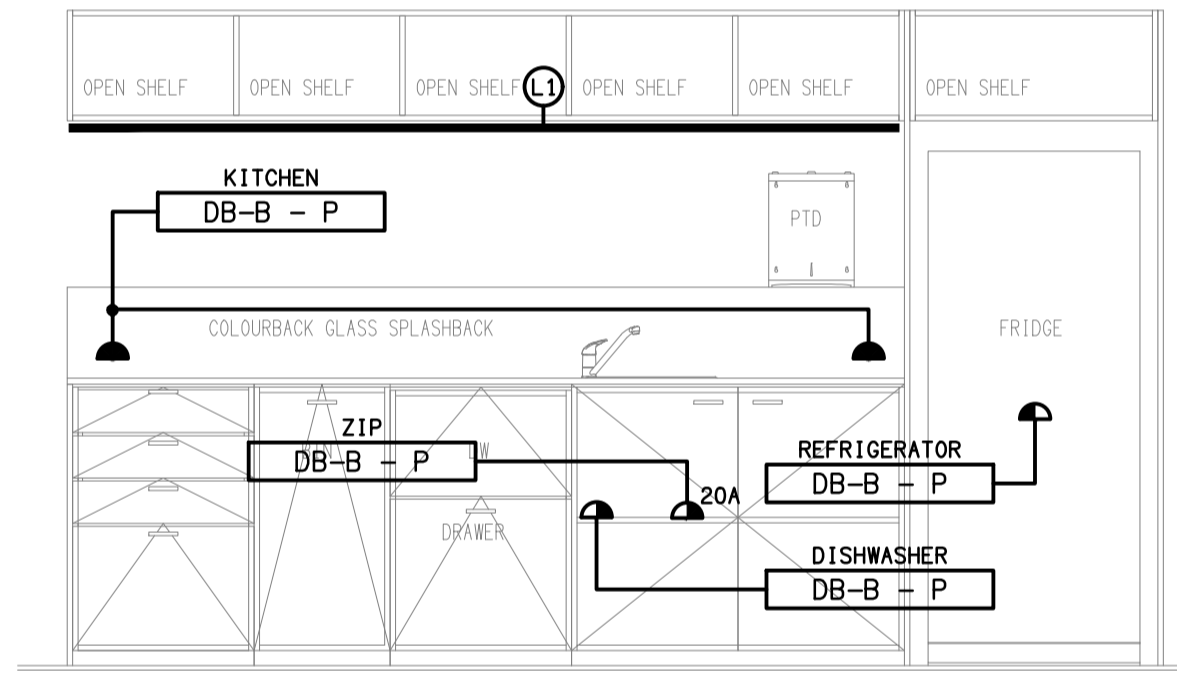

DETAIL C
SHOWROOM CAFE KITCHENETTE
SCALE 1:25

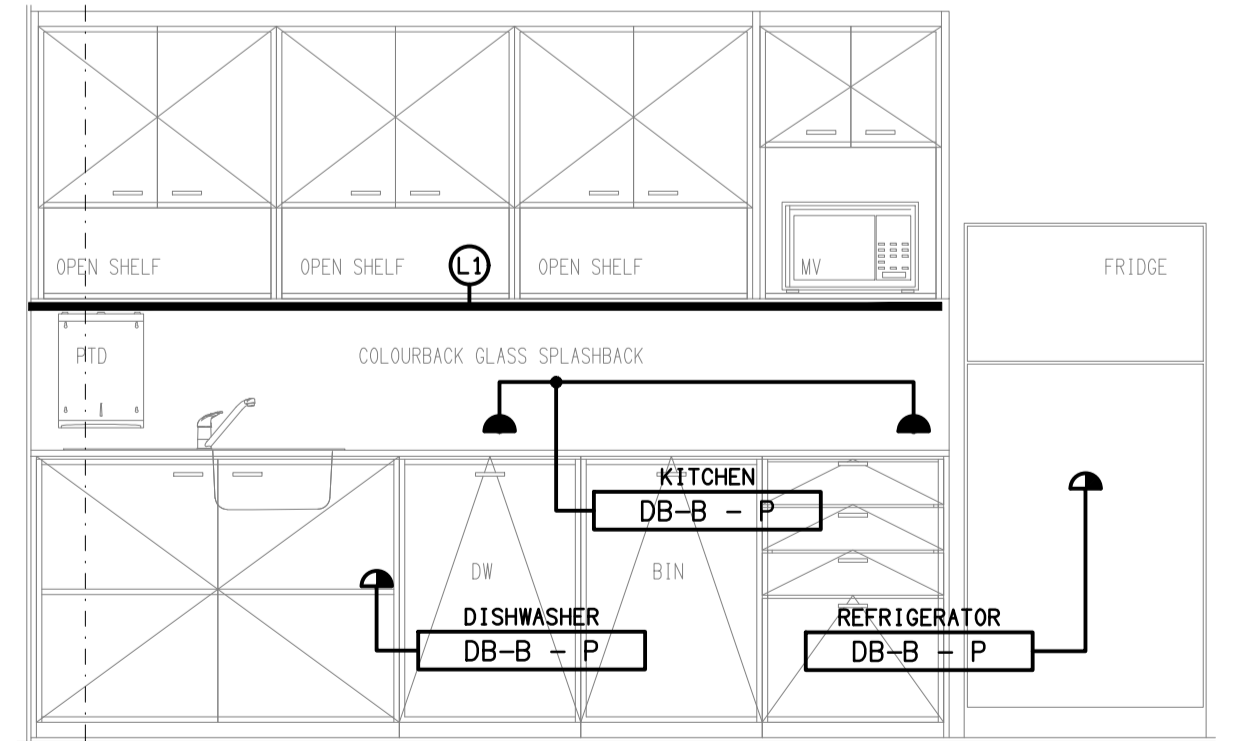

DETAIL D
LUNCH ROOM 2 KITCHENETTE ELEVATION
SCALE 1:25

NOTE:
ALL WORKSHOP AND ASSOCIATED STORE ROOMS ARE TO HAVE BLACK OR IP65 OUTLETS.

ELECTRICAL DESIGN GROUP BRISBANE
PTY LTD
ACN 092 710 793
TRADING AS:
ELECTRICAL DESIGN GROUP

THE COPYRIGHT OF THIS DRAWING
REMAINS THE PROPERTY OF THE
ELECTRICAL DESIGN GROUP.
USE FIGURED DIMENSIONS
IN PREFERENCE TO SCALE.
ALL DIMENSIONS TO BE
VERIFIED ONSITE.



Rohrig (Qld) Pty Ltd
ABN 67 093 753 970
QBSA LIC NO 740842
250 Abbotsford Road, Bowen Hills Qld 4006
PO Box 86 Albion DC Qld 4010
T+61 (7) 3257 4411 F+61 (7) 3257 2211
www.rohrig.com.au

ELECTRICAL DESIGN GROUP
ELECTRICAL BUILDING SERVICES CONSULTANTS
BRISBANE GOLD COAST
P.O. Box 15, Sherwood Q. 4075
Phone: (07) 3278 4375
Email: brisbane@edg.net.au
Web: www.edg.net.au

PROJECT:
LLEWELLYN MOTORS SPRINGFIELD - LOT 32
LOT 32 AUGUSTA PARKWAY, AUGUSTINE HEIGHTS

D	80% DEVELOPED	24/02/2025
REV:	DESCRIPTION:	DATE:
DRAWING: ELECTRICAL SERVICES GROUND LEVEL FLOOR PLAN		
SCALE: 1:100 UNO	PROJECT NO: C3294a	DRAWING NO: E04
AT A1	REVISION: D	