



**REFLECTED CEILING PLAN**  
MEZZANINE LEVEL  
SCALE 1: 100

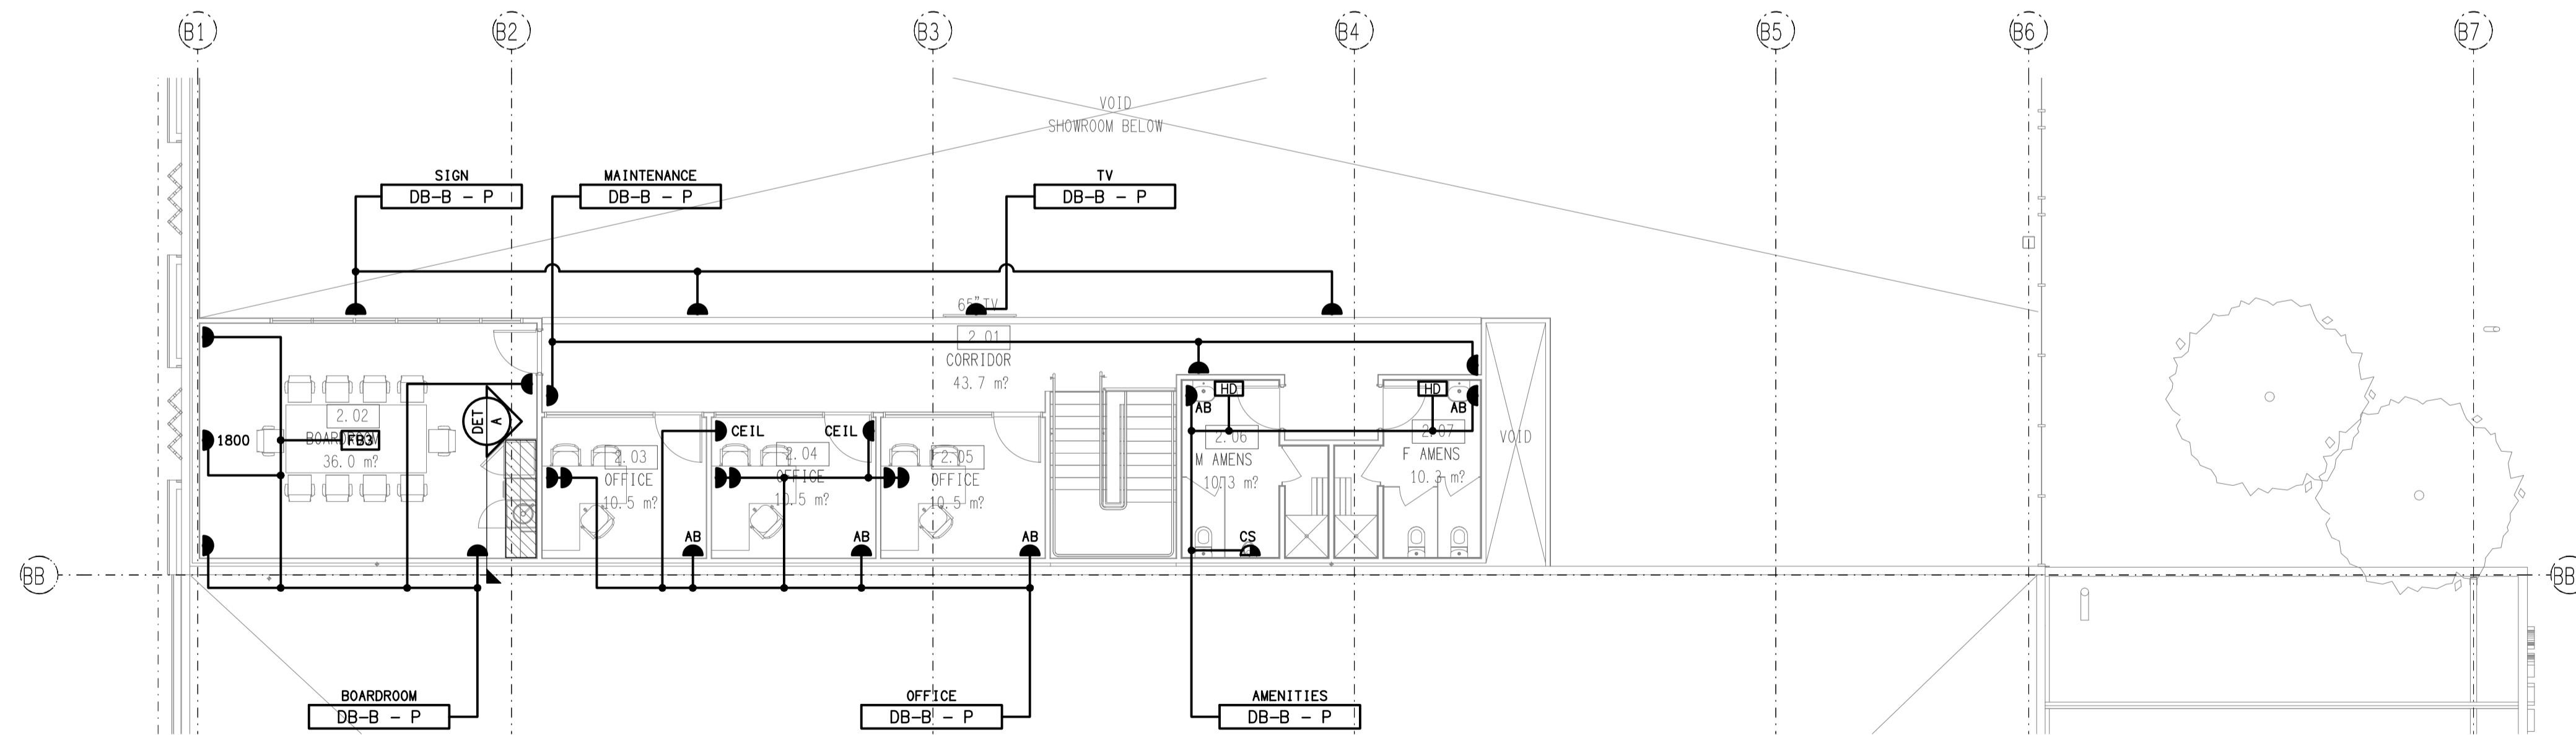

**FLOOR PLAN**  
MEZZANINE LEVEL  
SCALE 1: 100

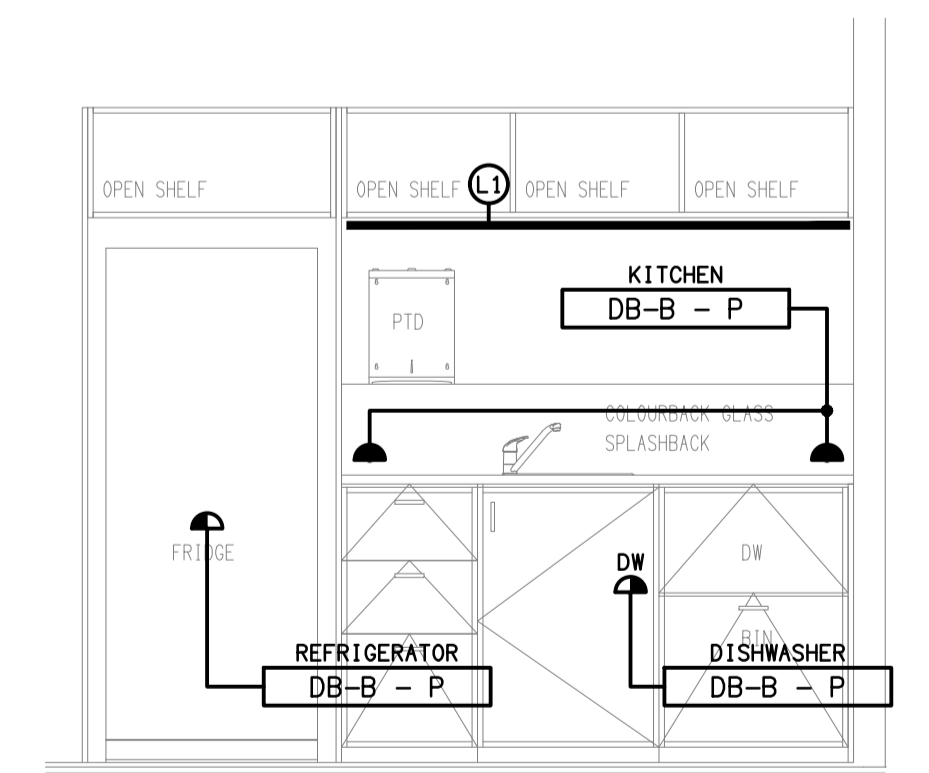

**DETAIL A**  
BOARD ROOM KITCHENETTE ELEVATION  
SCALE 1: 25

ELECTRICAL DESIGN GROUP BRISBANE  
PTY LTD  
ACN 092 710 793  
TRADING AS:  
ELECTRICAL DESIGN GROUP

THE COPYRIGHT OF THIS DRAWING  
REMAINS THE PROPERTY OF THE  
ELECTRICAL DESIGN GROUP.

USE FIGURED DIMENSIONS  
IN PREFERENCE TO SCALE.

ALL DIMENSIONS TO BE  
VERIFIED ONSITE.



Rohrig (Qld) Pty Ltd  
ABN 67 093 753 970  
QBSA LIC NO 740842  
250 Abbotsford Road, Bowen Hills Qld 4006  
PO Box 86 Albion DC Qld 4010  
T+61 (7) 3257 4411 F+61 (7) 3257 2211  
www.rohrig.com.au

**ELECTRICAL DESIGN GROUP**  
ELECTRICAL BUILDING SERVICES CONSULTANTS  
BRISBANE GOLD COAST

P.O. Box 15, Sherwood Q.4075  
Phone: (07) 3278 4375  
Email: brisbane@edg.net.au  
Web: www.edg.net.au

PROJECT:  
**LLEWELLYN MOTORS SPRINGFIELD - LOT 32**

LOT 32 AUGUSTA PARKWAY, AUGUSTINE HEIGHTS

D	80% DEVELOPED	24/02/2025
REV.	DESCRIPTION:	DATE:

DRAWING:  
**ELECTRICAL SERVICES**  
MEZZANINE LEVEL  
FLOOR & REFLECTED CEILING PLANS

SCALE: 1:100 UNO	PROJECT NO: AT A1 <b>C3294a</b>	DRAWING NO: <b>E06</b>	REVISION: <b>D</b>
---------------------	---------------------------------------	---------------------------	-----------------------