


AUGUSTA PARKWAY

1 x 100mm DIA WHITE AND
6 x 125mm DIA ORANGE CONDUITS WITHIN
THE ENERGEX FOOTPATH ZONE.


PROPOSED 4800 x 5000
PADMOUNT SUBSTATION
TRANSFORMER LOCATION.

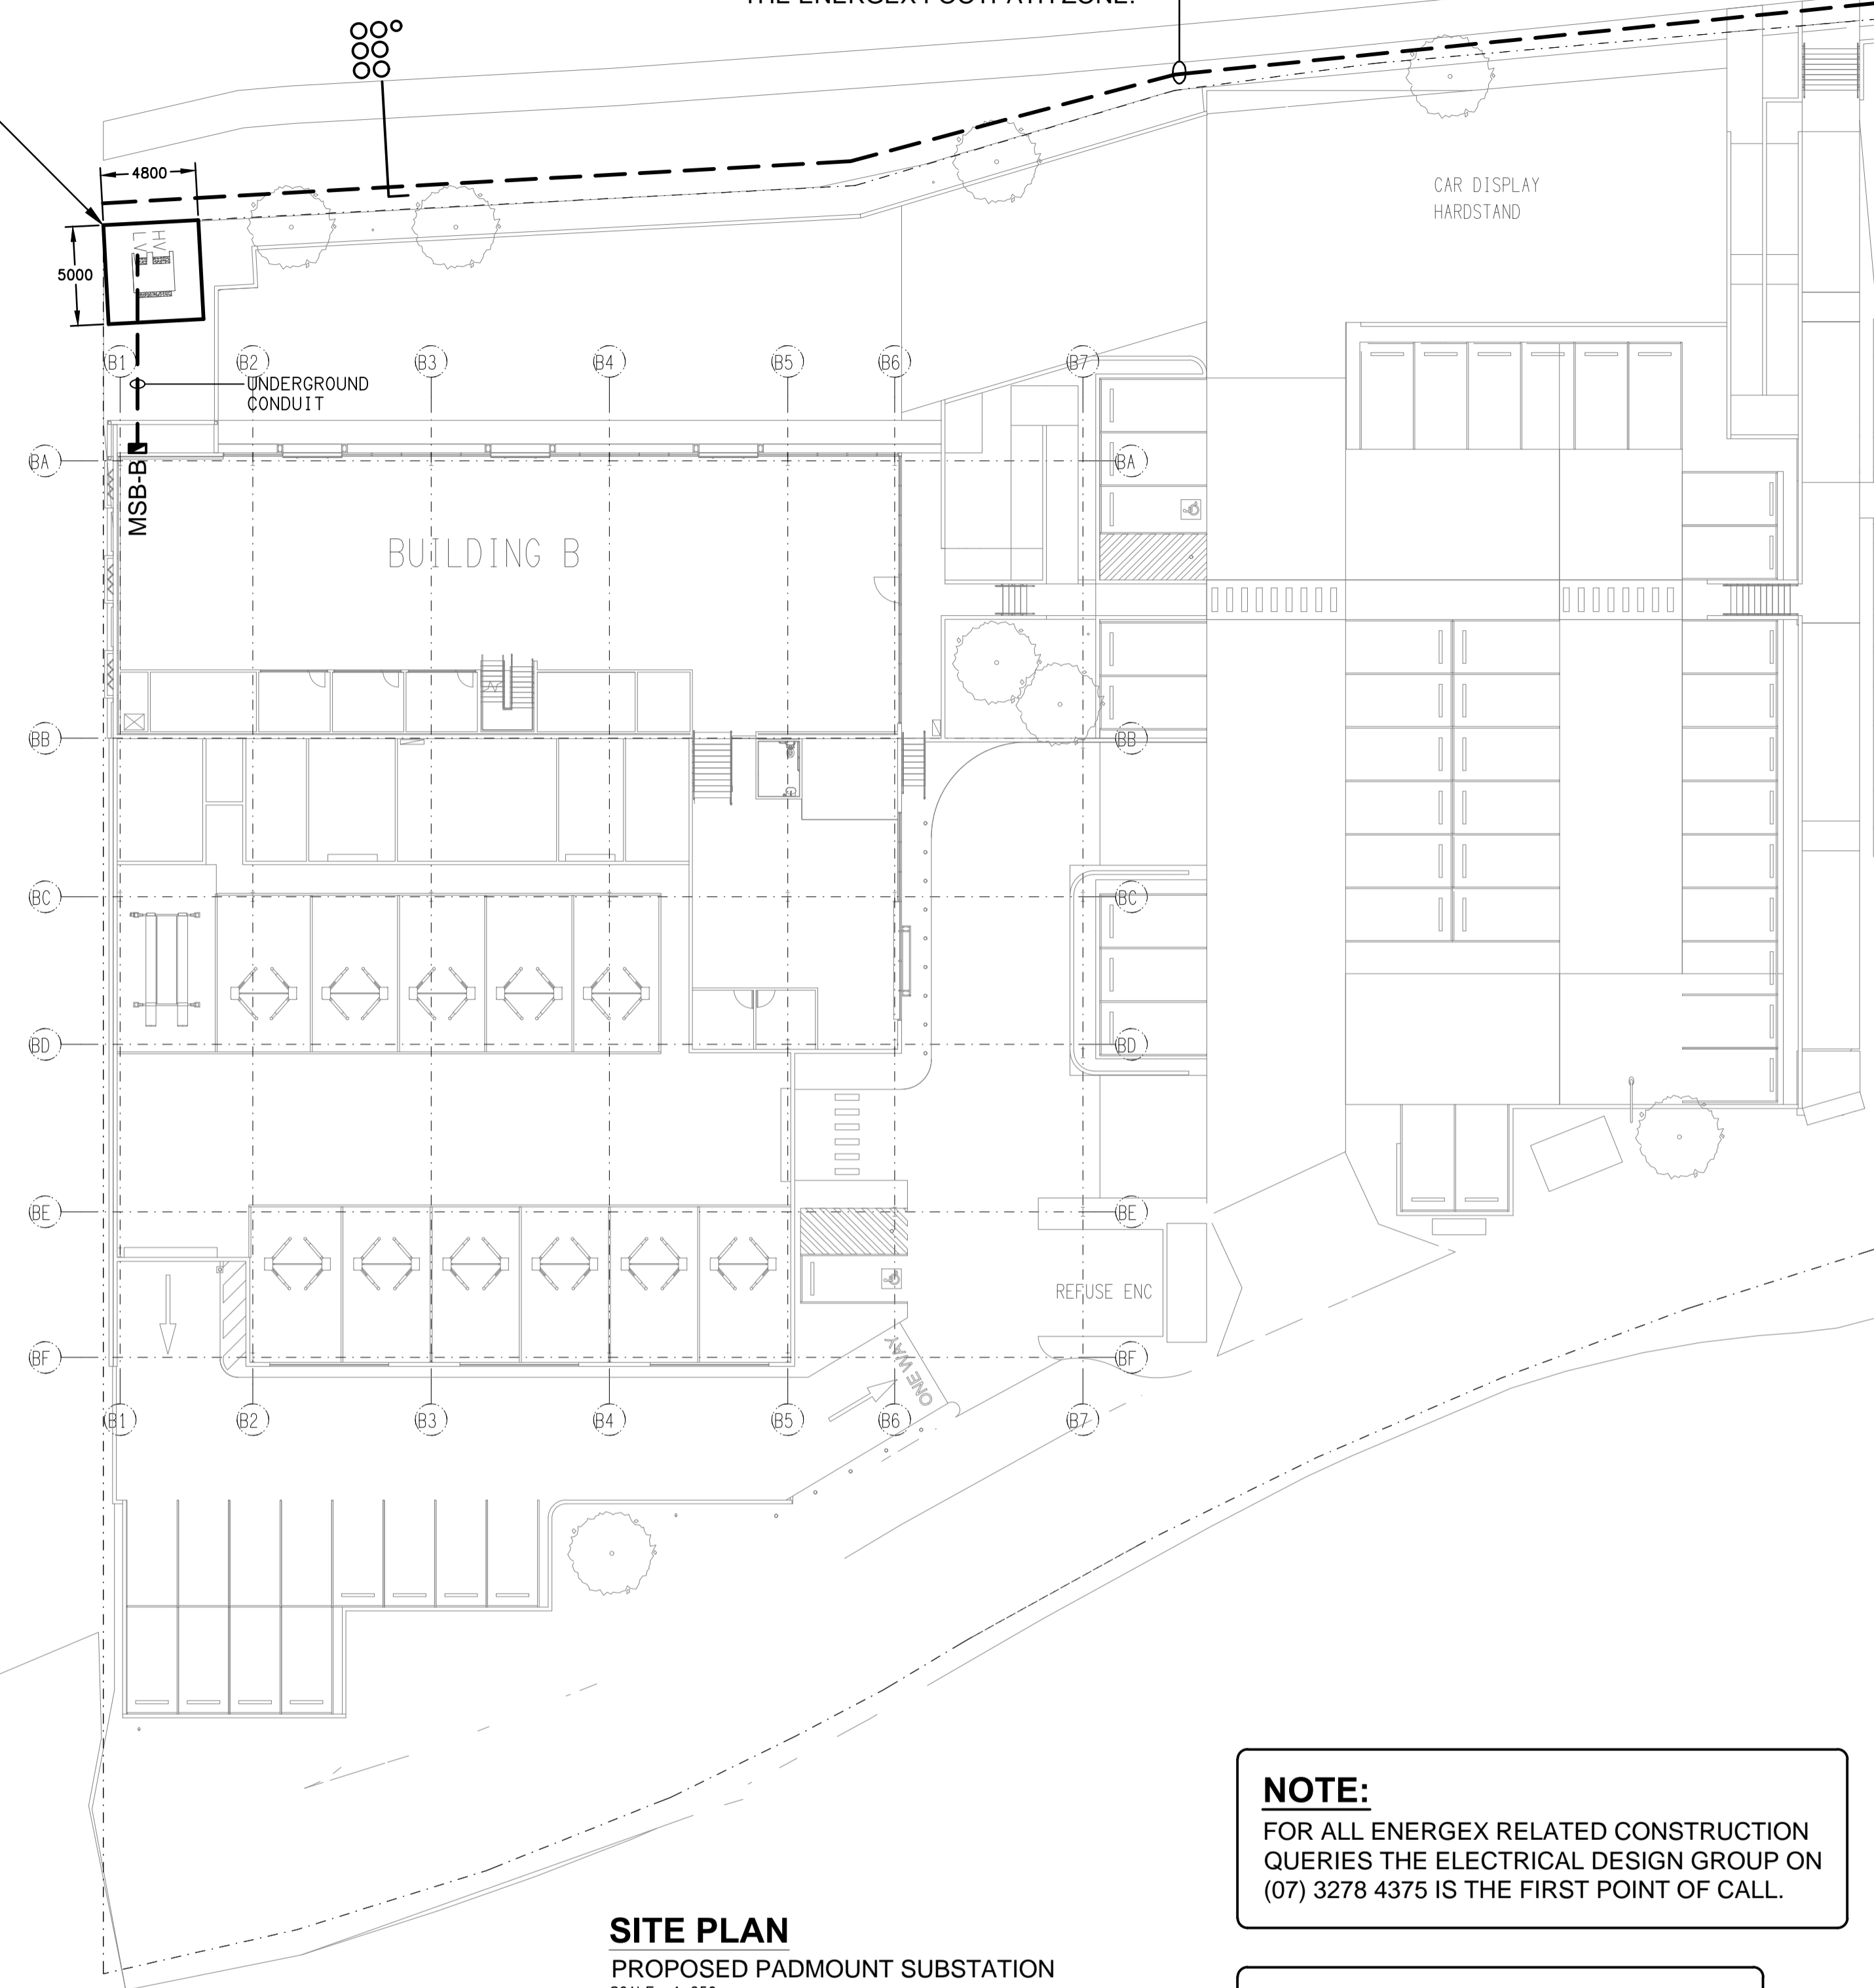

SITE PLAN
PROPOSED PADMOUNT SUBSTATION
SCALE 1:250

NOTE:
FOR ALL ENERGEX RELATED CONSTRUCTION
QUERIES THE ELECTRICAL DESIGN GROUP ON
(07) 3278 4375 IS THE FIRST POINT OF CALL.

NOTE:
Q100 FLOOD LEVEL RL TBA AHD.
PADMOUNT SUBSTATION RL TBA AHD.

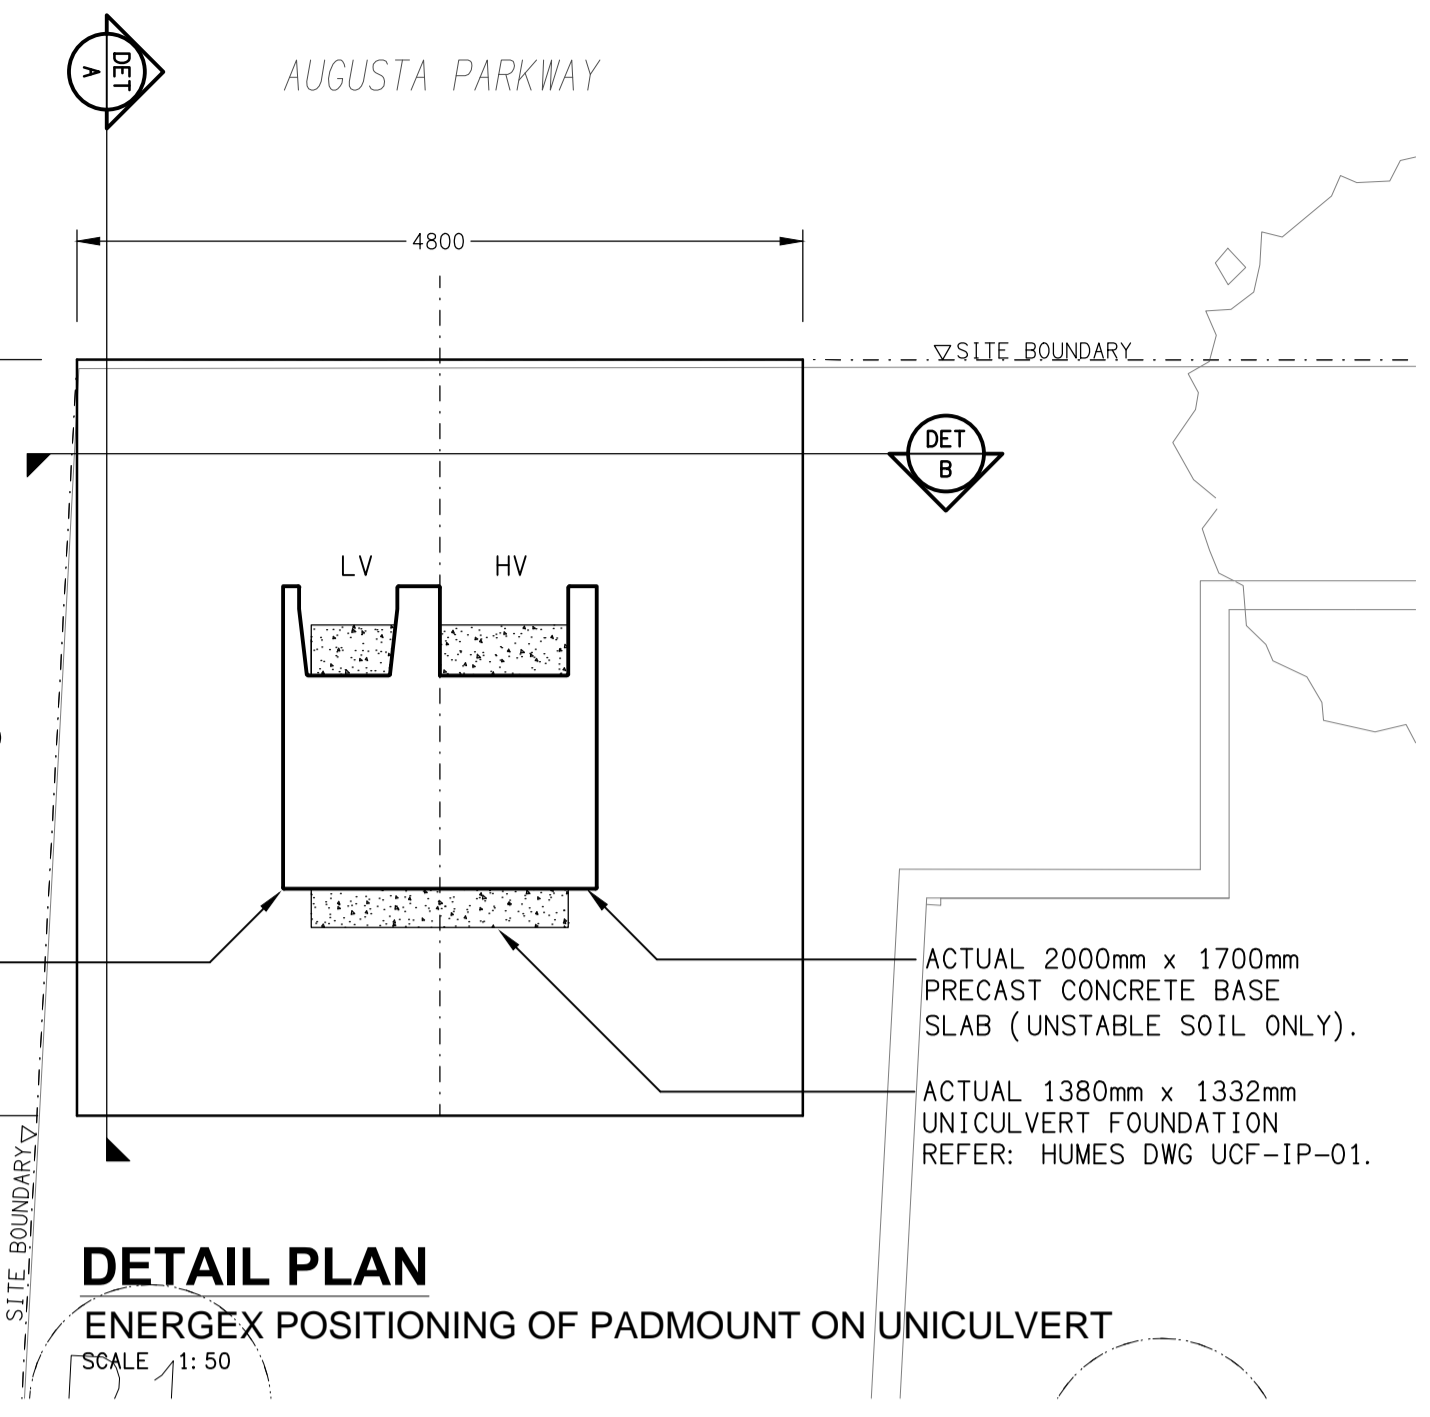


NOTE:
DO NOT RUN PRIVATE
SERVICE CABLE
THROUGH CULVERT


PRECAST PLINTH WITH
TRANSFORMER. WILSON PMT
2075mm x 2000mm.

ACTUAL 2000mm x 1700mm
PRECAST CONCRETE BASE
SLAB (UNSTABLE SOIL ONLY).
ACTUAL 1380mm x 1332mm
UNICULVERT FOUNDATION
REFER: HUMES DWG UCF-IP-01.

DETAIL PLAN
ENERGEX POSITIONING OF PADMOUNT ON UNICULVERT
SCALE 1:50

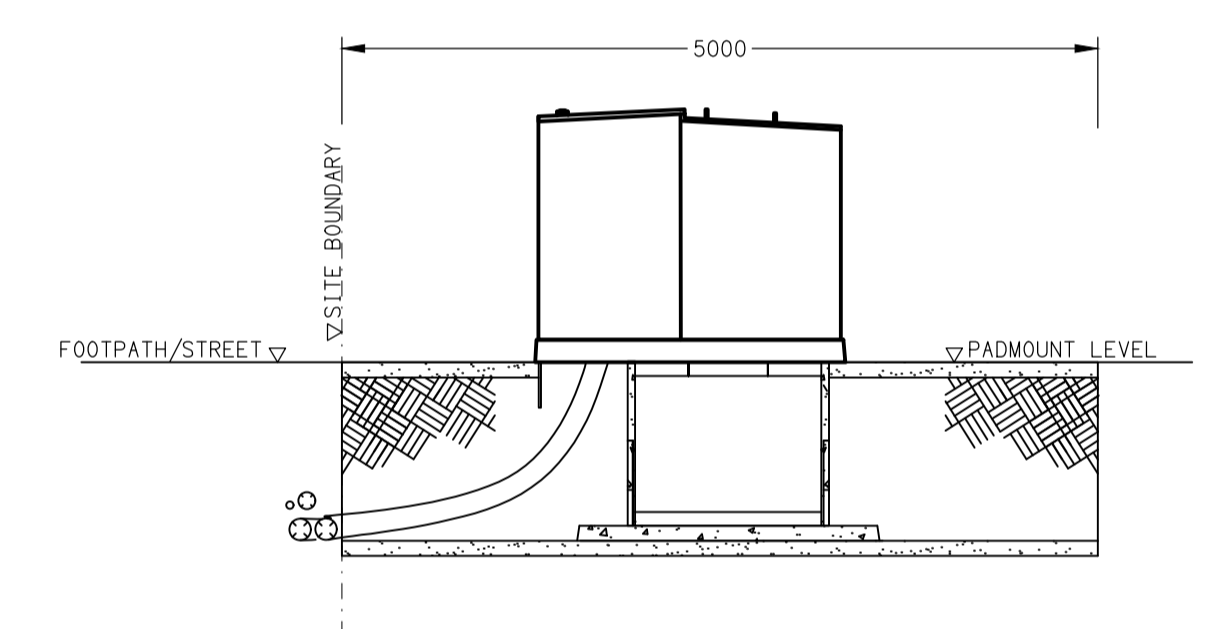

DETAIL A
PADMOUNT SECTION VIEW
SCALE 1:50

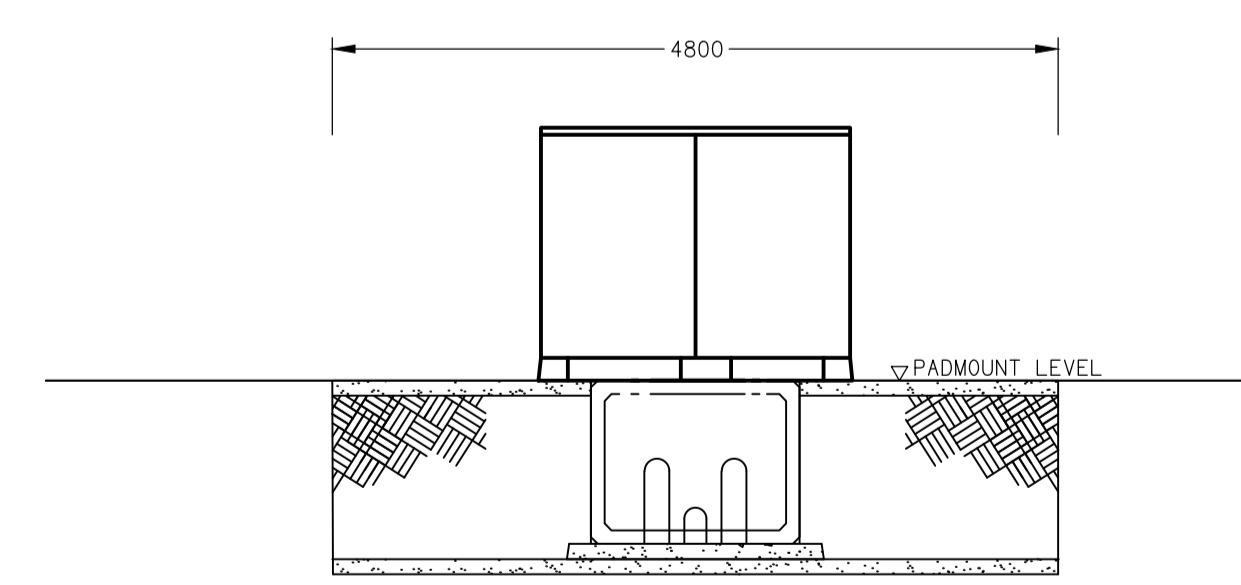

DETAIL B
PADMOUNT SECTION VIEW
SCALE 1:50

ENERGEX ACCEPTANCE

NAME

OFFICE

SIGNED

DATE / /

ENERGEX takes no responsibility for
the accuracy of the information provided
on this drawing



CULVERT INSPECTION REQUIRED BEFORE TRANSFORMER IS DELIVERED
- 5 BUSINESS DAYS PRIOR NOTICE NEEDED.
CONTACT _____ PH: _____ EMAIL: _____

TRANSFORMER WILL NOT BE ENERGISED UNTIL ALL REQUIREMENTS ARE MET.

ELECTRICAL DESIGN GROUP BRISBANE
PTY LTD
ACN 092 710 793
TRADING AS:
ELECTRICAL DESIGN GROUP

THE COPYRIGHT OF THIS DRAWING
REMAINS THE PROPERTY OF THE
ELECTRICAL DESIGN GROUP.
USE FIGURED DIMENSIONS
IN PREFERENCE TO SCALE.
ALL DIMENSIONS TO BE
VERIFIED ONSITE.



Rohrig (Qld) Pty Ltd
ABN 67 093 753 970
QBSA LIC NO 740842
250 Abbotsford Road, Bowen Hills Qld 4006
PO Box 86 Albion DC Qld 4010
T+61 (7) 3257 4411 F+61 (7) 3257 2211
www.rohrig.com.au

ELECTRICAL DESIGN GROUP
ELECTRICAL BUILDING SERVICES CONSULTANTS
BRISBANE GOLD COAST
P.O. Box 15, Sherwood Q.4075
Phone: (07) 3278 4375
Email: brisbane@edg.net.au
Web: www.edg.net.au

PROJECT:
LLEWELLYN MOTORS SPRINGFIELD - LOT 32
LOT 32 AUGUSTA PARKWAY, AUGUSTINE HEIGHTS

B	50% DEVELOPED	28/11/2024
REV:	DESCRIPTION:	DATE:
DRAWING: ELECTRICAL SERVICES ENERGEX PADMOUNT SUBSTATION SITE PLAN & DETAILS		
SCALE: 1:250 & 1:50	PROJECT NO: C3294a	DRAWING NO: EN01
AT A1	REVISION: B	