



DETAIL
 PROPOSED EXTERNAL BUILDING ELEVATION
 SCALE 1:100

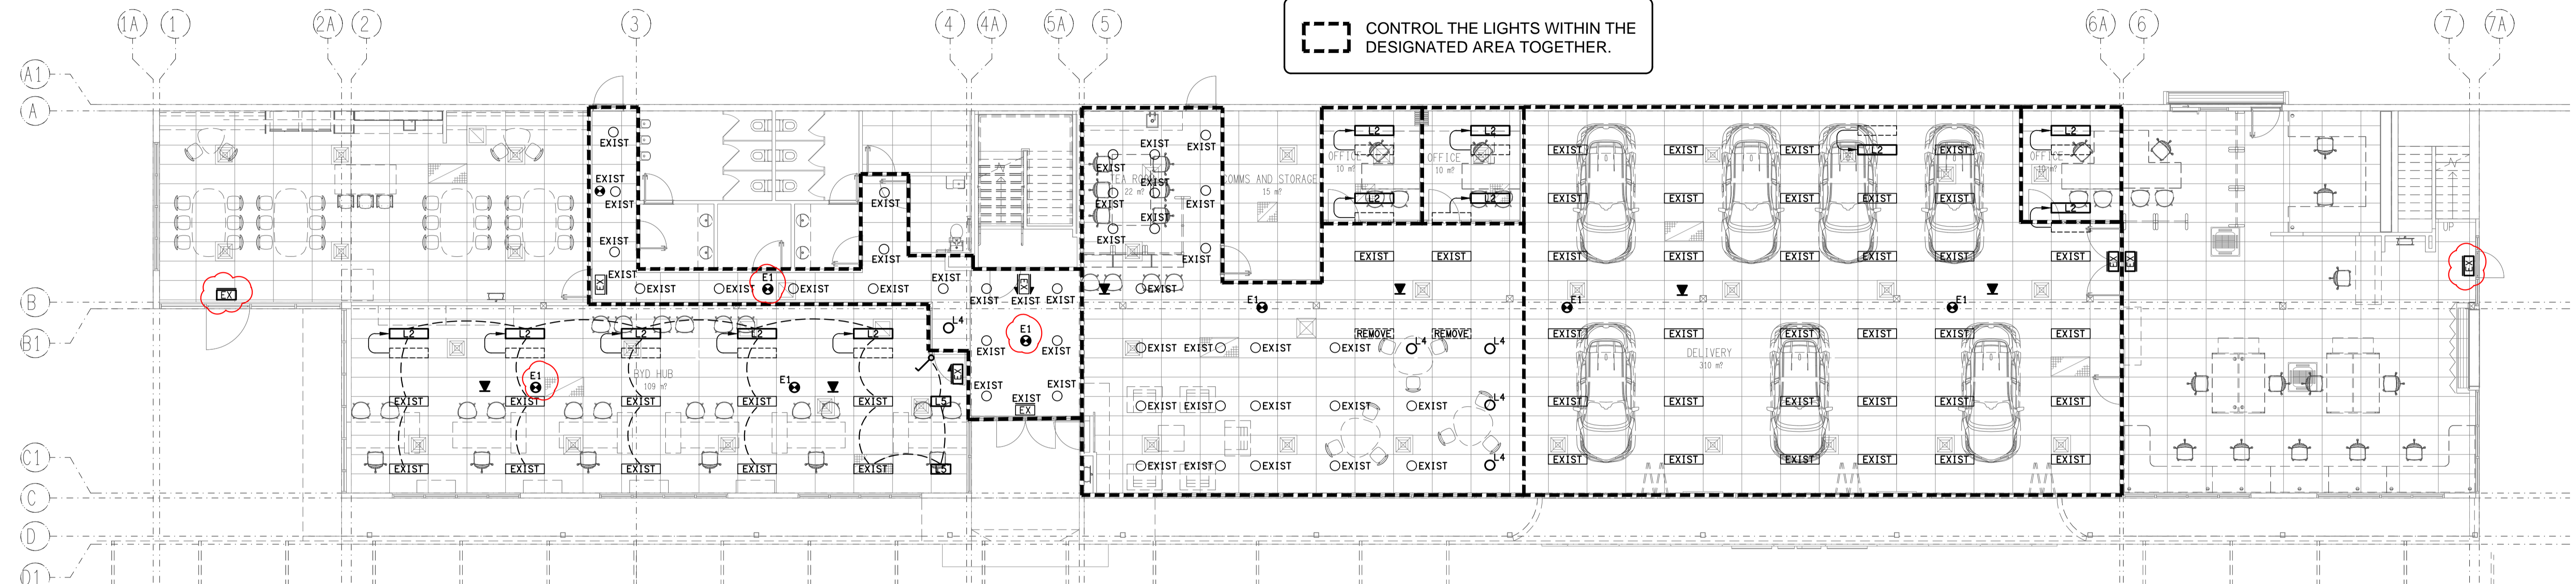

GROUND LEVEL
 PROPOSED REFLECTED CEILING PLAN
 SCALE 1:100

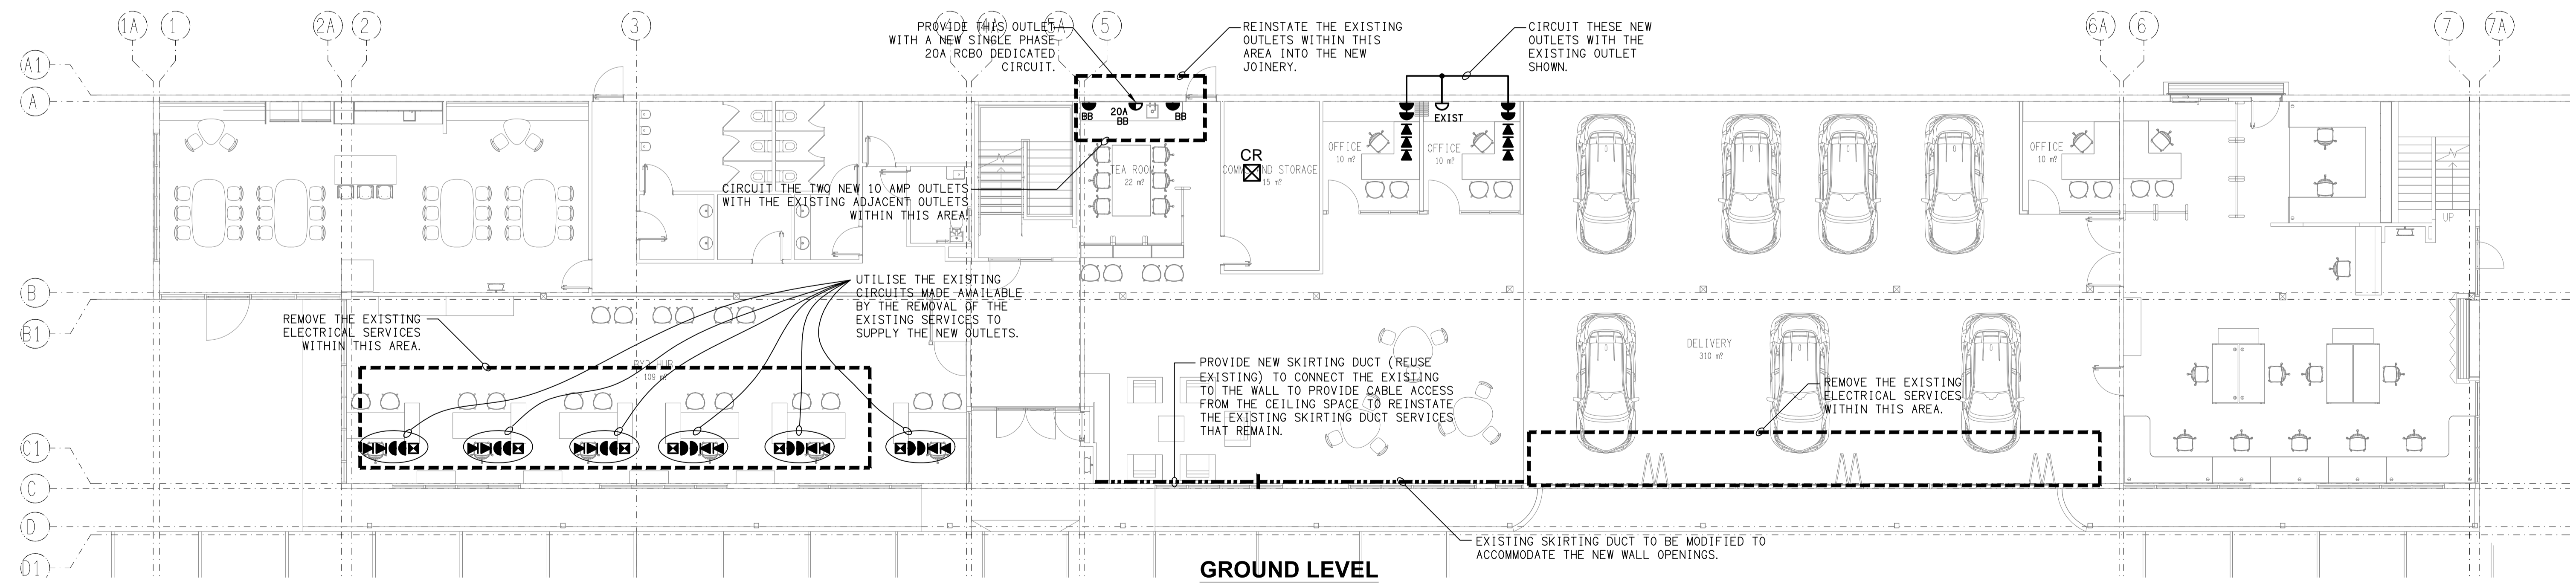

GROUND LEVEL
 PROPOSED FLOOR PLAN
 SCALE 1:100

ELECTRICAL DESIGN GROUP BRISBANE PTY LTD
 ACN 092 710 793
 TRADING AS:
 ELECTRICAL DESIGN GROUP

THE COPYRIGHT OF THIS DRAWING REMAINS THE PROPERTY OF THE ELECTRICAL DESIGN GROUP.
 USE FIGURED DIMENSIONS IN PREFERENCE TO SCALE.
 ALL DIMENSIONS TO BE VERIFIED ONSITE.

ELECTRICAL DESIGN GROUP
 ELECTRICAL BUILDING SERVICES CONSULTANTS
 BRISBANE GOLD COAST
 P.O. Box 15, Sherwood Q.4075
 Phone: (07) 3278 4375
 Email: brisbane@edg.net.au
 Web: www.edg.net.au

PROJECT:
BYD BRISBANE AIRPORT - OFFICE UPGRADE
 5-7 VIOLA PLACE, BRISBANE AIRPORT, QUEENSLAND

D	CONSTRUCTION	23/01/2025
REV:	DESCRIPTION:	DATE:
DRAWING: ELECTRICAL SERVICES GROUND LEVEL PLANS		
SCALE: 1:100	AT A1	PROJECT NO: C3298a
		DRAWING NO: E02
		REVISION: D