


REFLECTED CEILING PLAN
NORTHERN SHED
SCALE 1:100

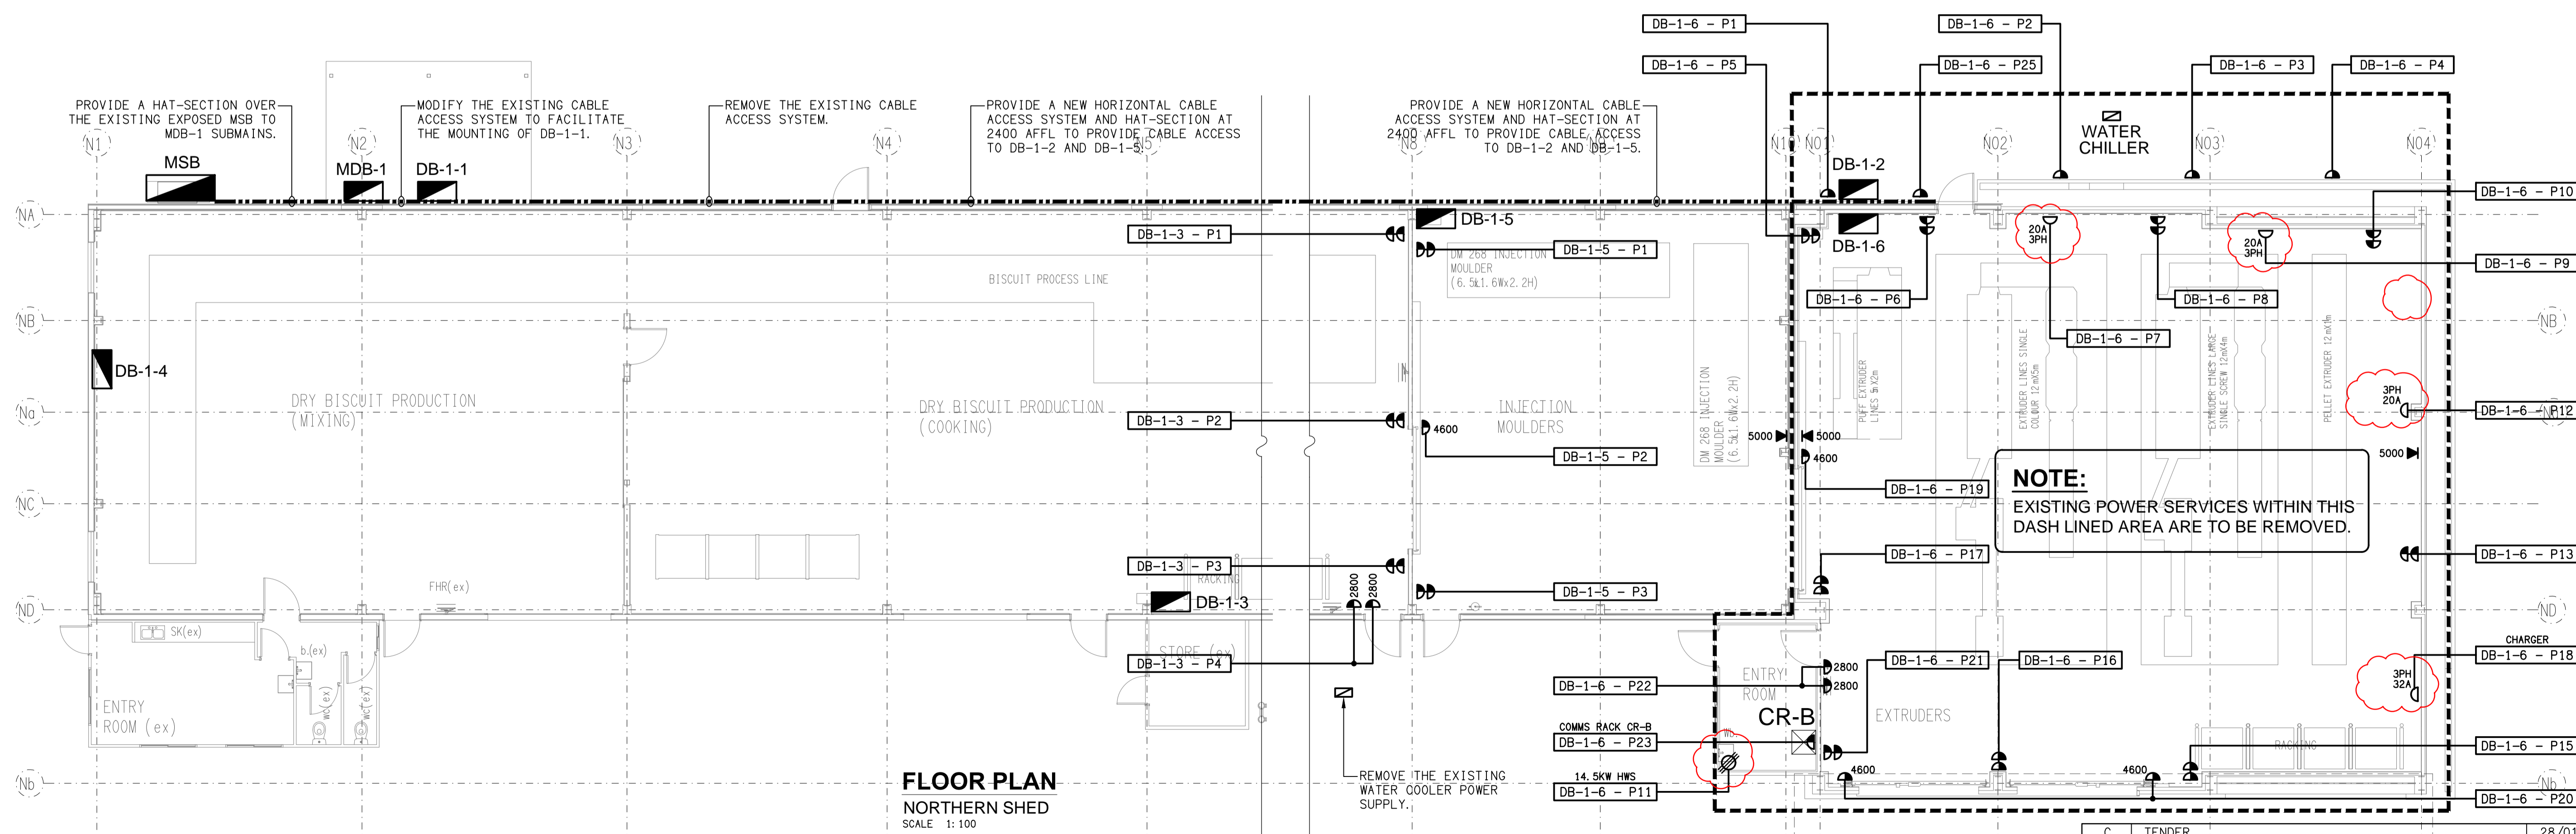

FLOOR PLAN
NORTHERN SHED
SCALE 1:100

ELECTRICAL DESIGN GROUP BRISBANE
PTY LTD
ACN 092 710 793
TRADING AS:
ELECTRICAL DESIGN GROUP

THE COPYRIGHT OF THIS DRAWING
REMAINS THE PROPERTY OF THE
ELECTRICAL DESIGN GROUP.
USE FIGURED DIMENSIONS
IN PREFERENCE TO SCALE.
ALL DIMENSIONS TO BE
VERIFIED ONSITE.

ELECTRICAL DESIGN GROUP
ELECTRICAL BUILDING SERVICES CONSULTANTS
BRISBANE GOLD COAST
P.O. Box 15, Sherwood Q.4075
Phone: (07) 3278 4375
Email: brisbane@edg.net.au
Web: www.edg.net.au

PROJECT:
REWARD PET FOODS, WILSONTON
41-45 INDUSTRIAL AVENUE, WILSONTON TOowoomba

C	TENDER	28/01/2025
REV.	DESCRIPTION:	DATE:
DRAWING: ELECTRICAL SERVICES NORTHERN SHED FLOOR PLAN & REFLECTED CEILING PLAN		
SCALE: 1:100	PROJECT NO: C3351a	DRAWING NO: E04
AT A1	REVISION: C	