


ALL EXISTING ELECTRICAL SERVICES WITHIN THIS AREA ARE TO BE REMOVED, UNLESS NOTED OTHERWISE.

LIFT THE CABLE LADDER SO IT RUNS FLAT ONCE THE REDUNDANT DUCT HAS BEEN REMOVED.

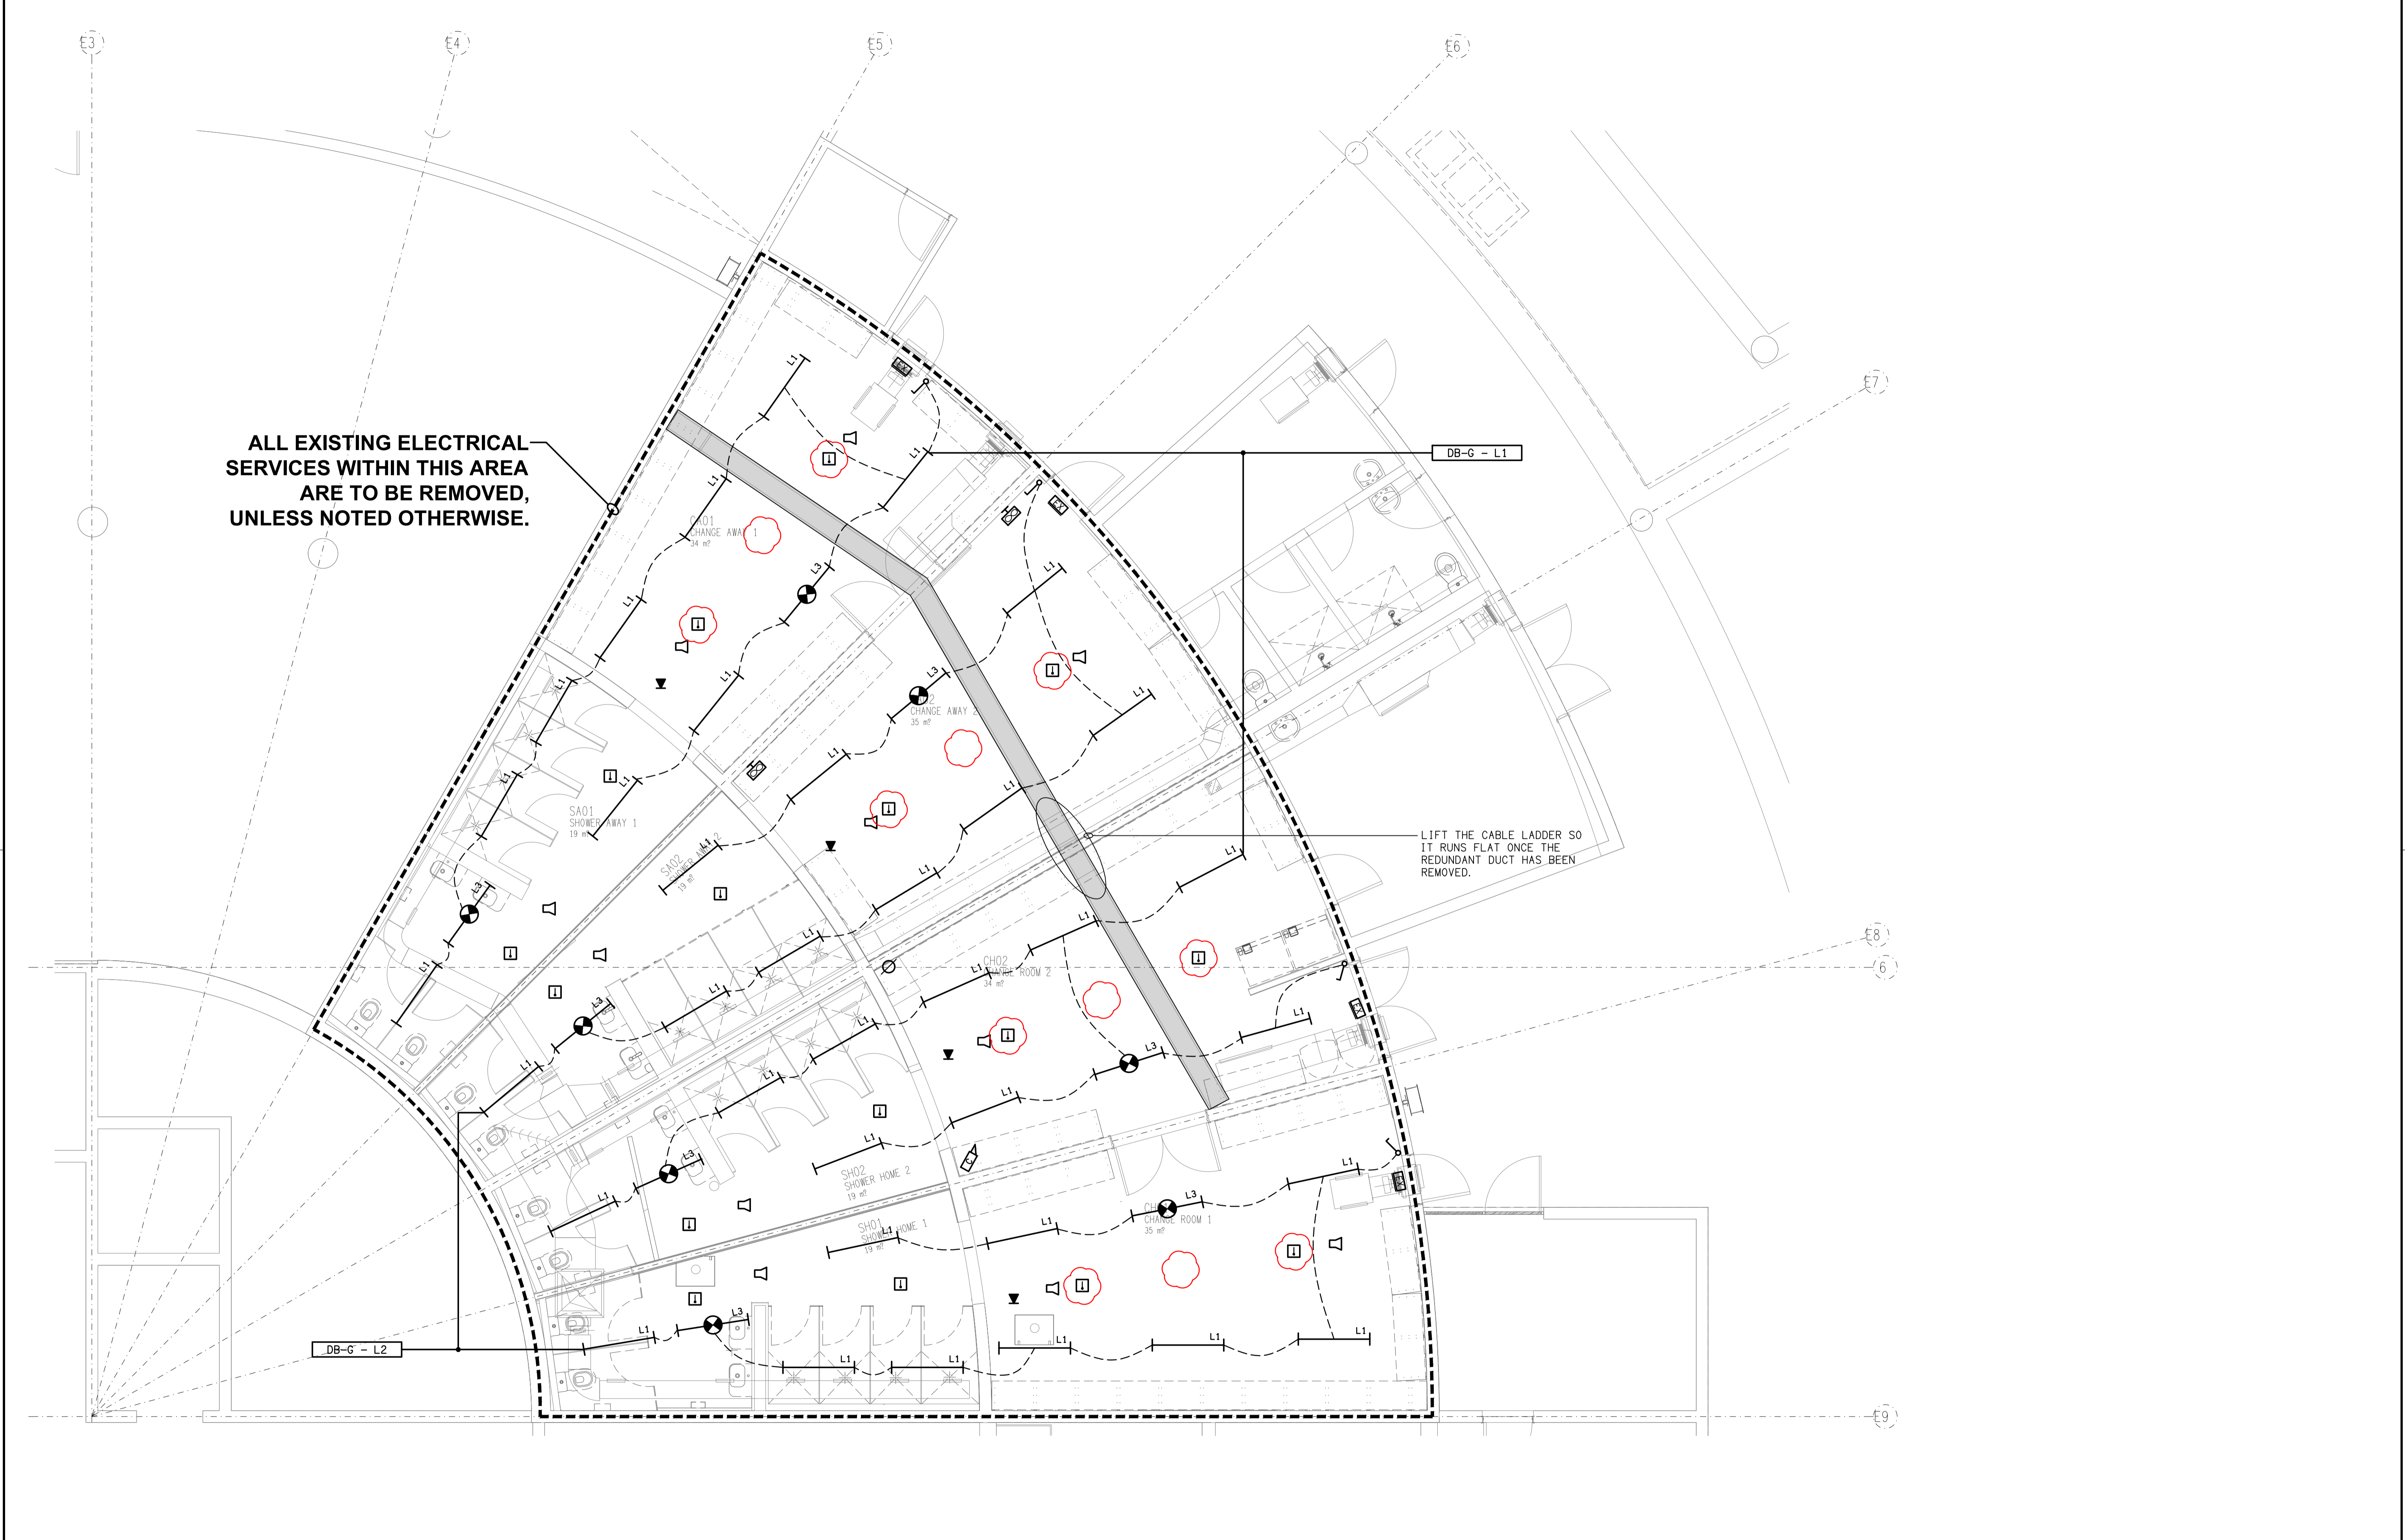

ELECTRICAL DESIGN GROUP BRISBANE
PTY LTD
ACN 092 710 793
TRADING AS:
ELECTRICAL DESIGN GROUP

THE COPYRIGHT OF THIS DRAWING
REMAINS THE PROPERTY OF THE
ELECTRICAL DESIGN GROUP.
USE FIGURED DIMENSIONS
IN PREFERENCE TO SCALE.
ALL DIMENSIONS TO BE
VERIFIED ONSITE.

ELECTRICAL DESIGN GROUP
ELECTRICAL BUILDING SERVICES CONSULTANTS
BRISBANE GOLD COAST
P.O. Box 15, Sherwood Q.4075
Phone: (07) 3278 4375
Email: brisbane@edg.net.au
Web: www.edg.net.au

PROJECT:
**BROTHERS LEAGUES CLUB, IPSWICH
CHANGE ROOM REFURBISHMENT**
WILDEY STREET, IPSWICH

D	CONSTRUCTION	23/01/2025
REV:	DESCRIPTION:	DATE:
DRAWING: ELECTRICAL SERVICES REFLECTED CEILING PLAN		
SCALE: 1:50	AT A1	PROJECT NO: C3352a
		DRAWING NO: E03
		REVISION: D