


**SITE PLAN**  
CARPARK REFURBISHMENT  
SCALE 1:250

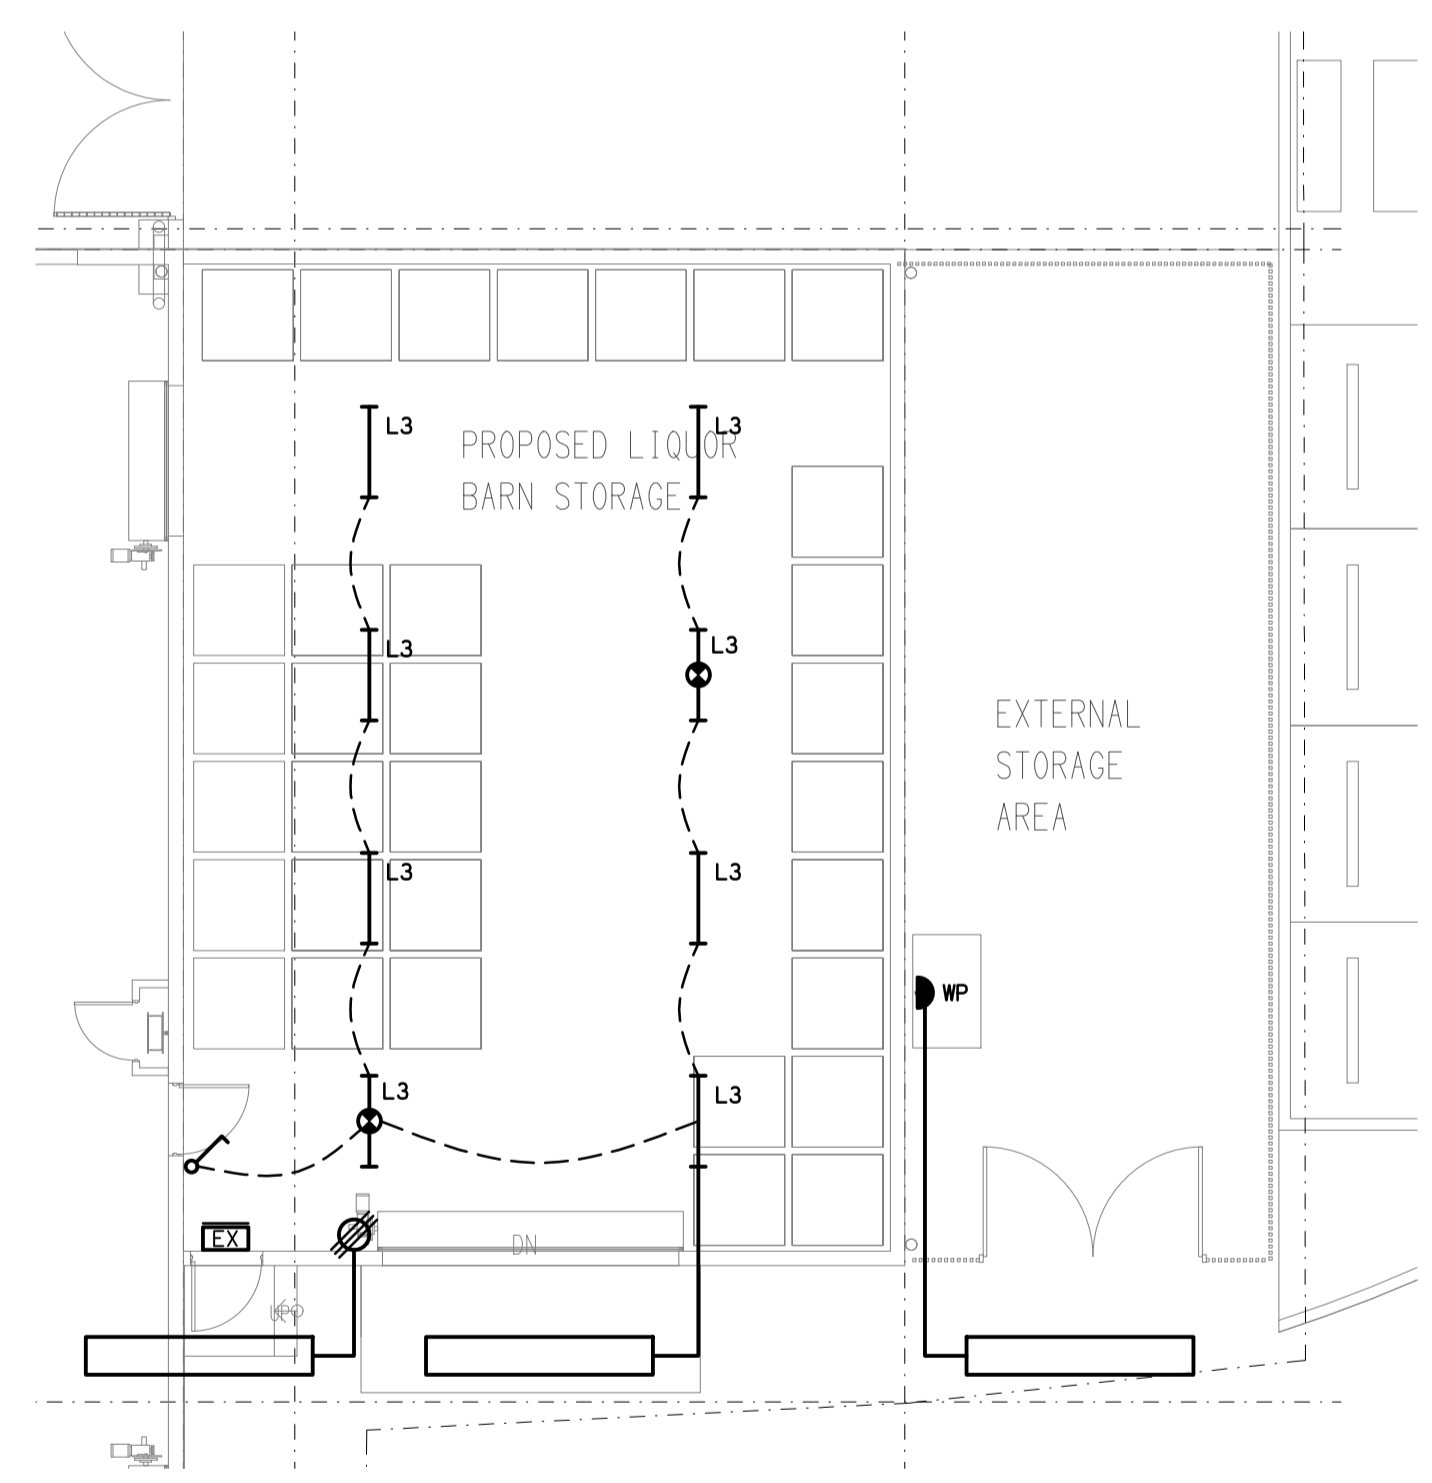

**LIQUOR BARN**  
FLOOR / REFLECTED CEILING PLAN  
SCALE 1:100

ELECTRICAL DESIGN GROUP BRISBANE  
PTY LTD  
ACN 092 710 793  
TRADING AS:  
ELECTRICAL DESIGN GROUP

THE COPYRIGHT OF THIS DRAWING  
REMAINS THE PROPERTY OF THE  
ELECTRICAL DESIGN GROUP.  
USE FIGURED DIMENSIONS  
IN PREFERENCE TO SCALE.  
ALL DIMENSIONS TO BE  
VERIFIED ONSITE.

**ELECTRICAL DESIGN GROUP**  
ELECTRICAL BUILDING SERVICES CONSULTANTS  
BRISBANE GOLD COAST  
P.O. Box 15, Sherwood Q.4075  
Phone: (07) 3278 4375  
Email: brisbane@edg.net.au  
Web: www.edg.net.au

PROJECT:  
**BRACKEN RIDGE TAVERN**  
154 BARRETT STREET, BRACKEN RIDGE

A	PRELIMINARY	28/02/2025
REV:	DESCRIPTION:	DATE:
DRAWING: <b>ELECTRICAL SERVICES</b> <b>SITE PLAN</b>		
SCALE: AS SHOWN	AT A1	PROJECT NO: <b>C3358a</b>
		DRAWING NO: <b>E04</b>
		REVISION: <b>A</b>