


DETAIL A
SPORTS BAR FLOOR PLAN
SCALE 1:50

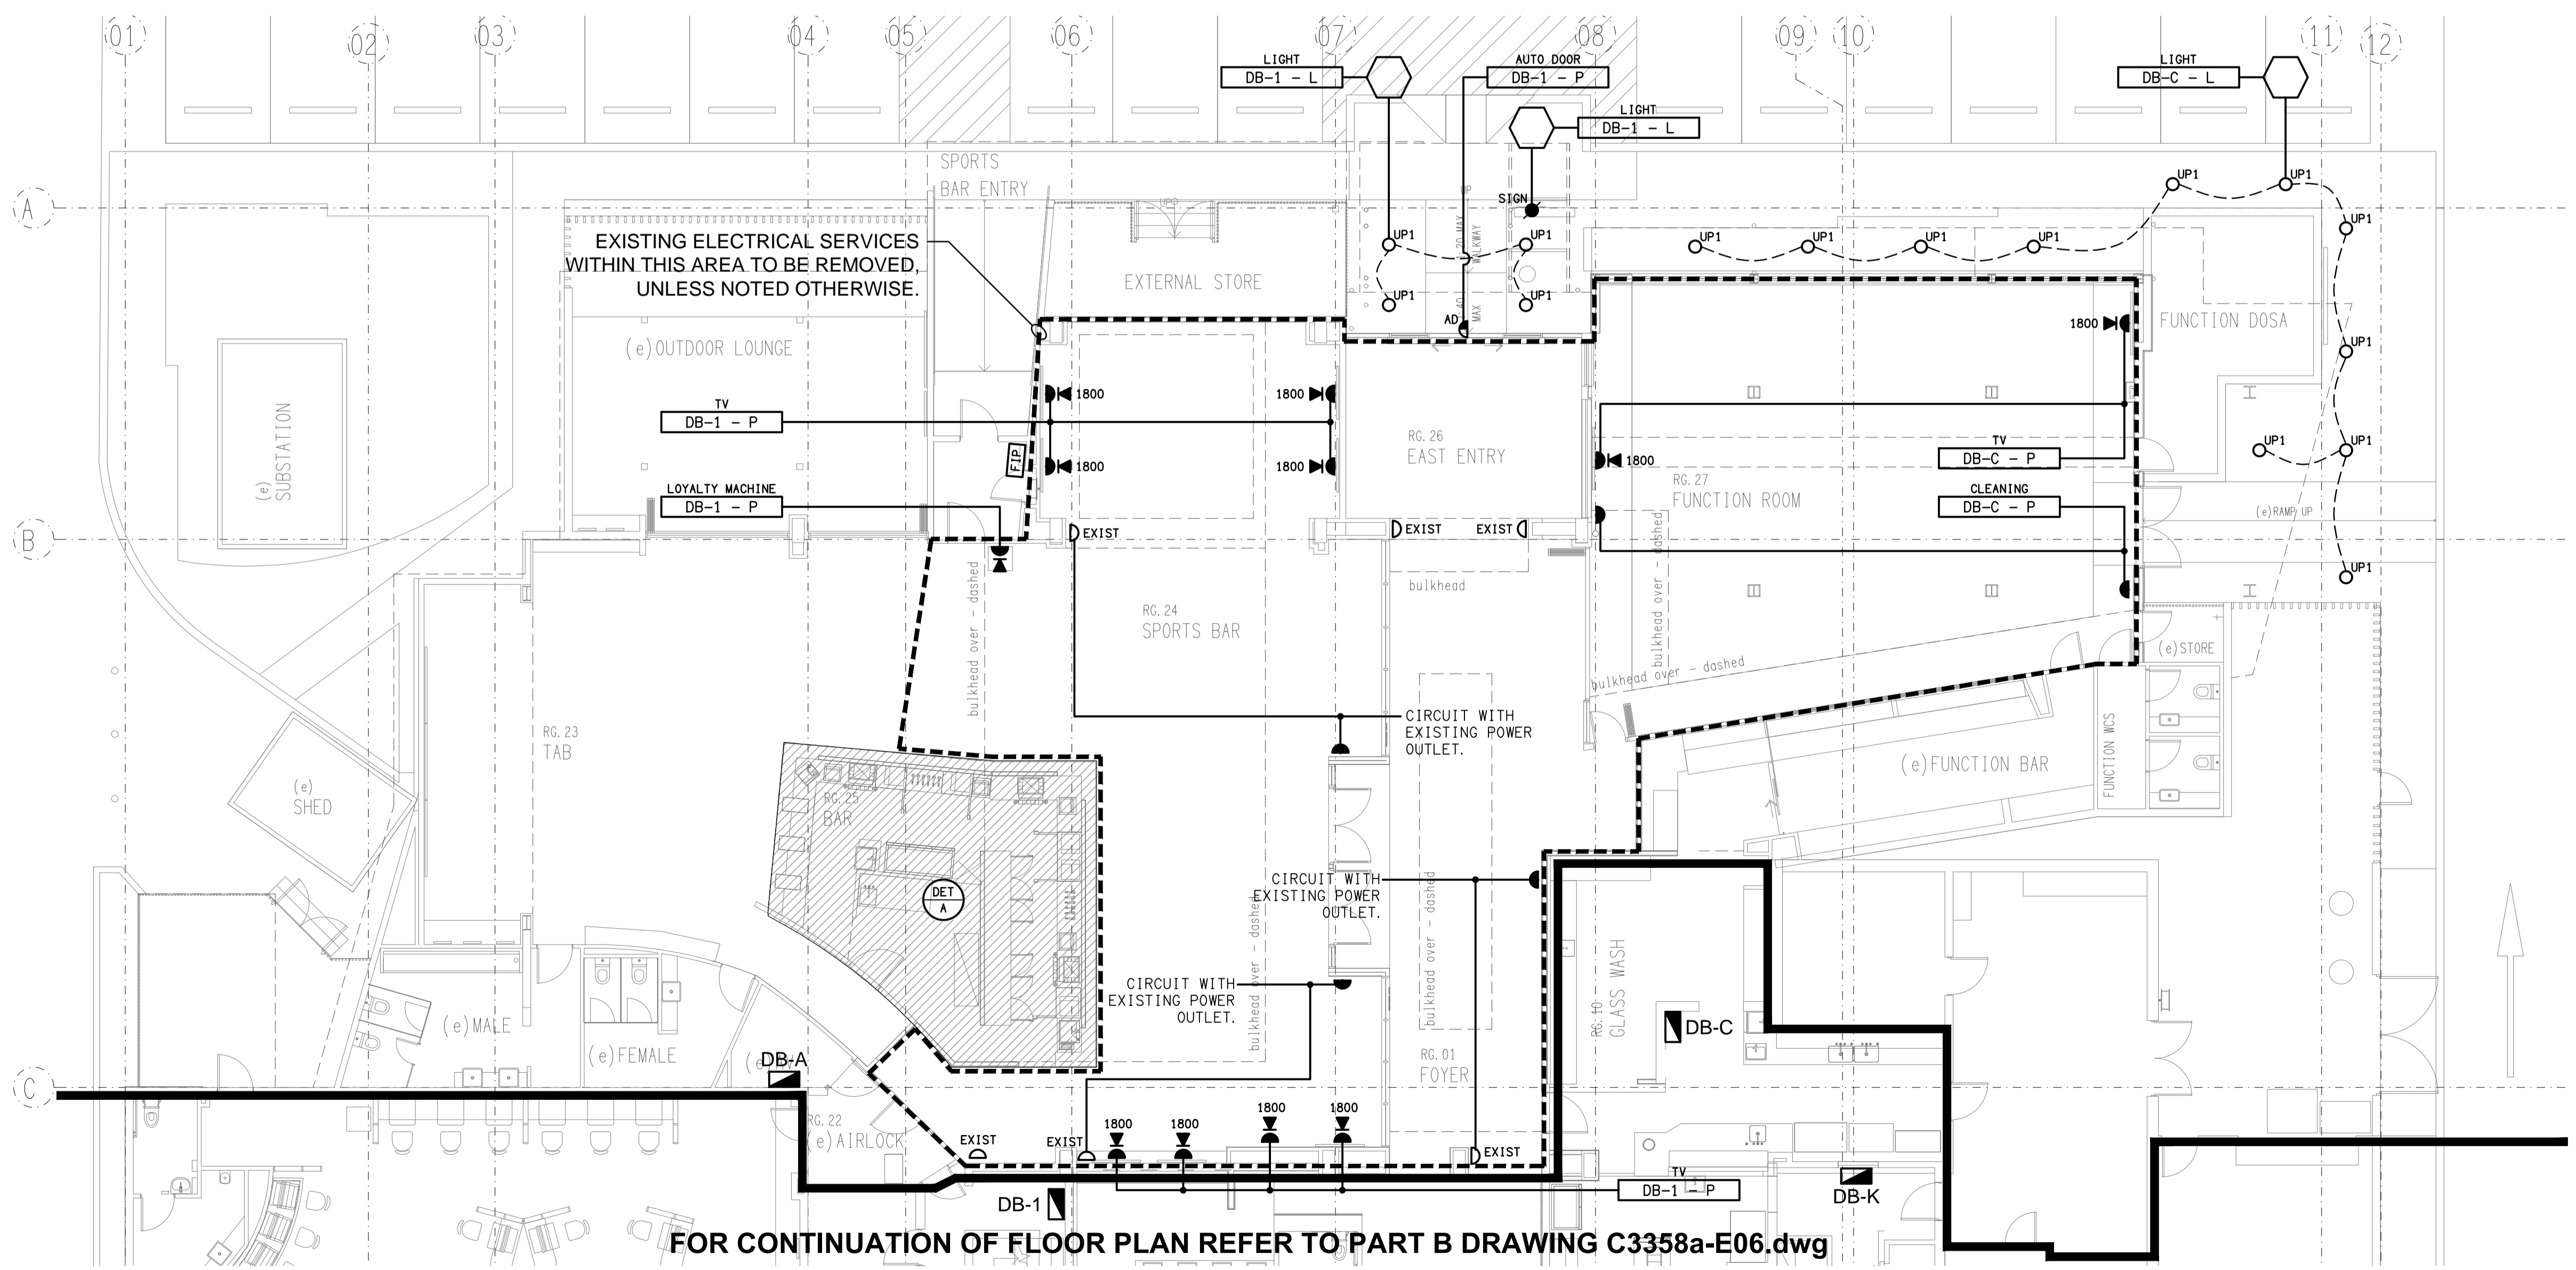

FOR CONTINUATION OF FLOOR PLAN REFER TO PART B DRAWING C3358a-E06.dwg

ELECTRICAL DESIGN GROUP BRISBANE
PTY LTD
ACN 092 710 793
TRADING AS:
ELECTRICAL DESIGN GROUP

THE COPYRIGHT OF THIS DRAWING
REMAINS THE PROPERTY OF THE
ELECTRICAL DESIGN GROUP.
USE FIGURED DIMENSIONS
IN PREFERENCE TO SCALE.
ALL DIMENSIONS TO BE
VERIFIED ONSITE.

ELECTRICAL DESIGN GROUP
ELECTRICAL BUILDING SERVICES CONSULTANTS
BRISBANE GOLD COAST
P.O. Box 15, Sherwood Q.4075
Phone: (07) 3278 4375
Email: brisbane@edg.net.au
Web: www.edg.net.au

PROJECT:
BRACKEN RIDGE TAVERN
154 BARRETT STREET, BRACKEN RIDGE

A	PRELIMINARY	28/02/2025
REV.	DESCRIPTION:	DATE:
DRAWING: ELECTRICAL SERVICES PART A FLOOR PLAN		
SCALE: 1:100 UNO	PROJECT NO: C3358a	DRAWING NO: E05
AT A1	REVISION: A	