


PENDING FURTHER INFORMATION


PENDING FURTHER INFORMATION

**DETAIL B**  
SPORTS BAR FRONT COUNTER ELEVATION  
SCALE 1:50

**DETAIL C**  
SPORTS BAR REAR WALL ELEVATION  
SCALE 1:50

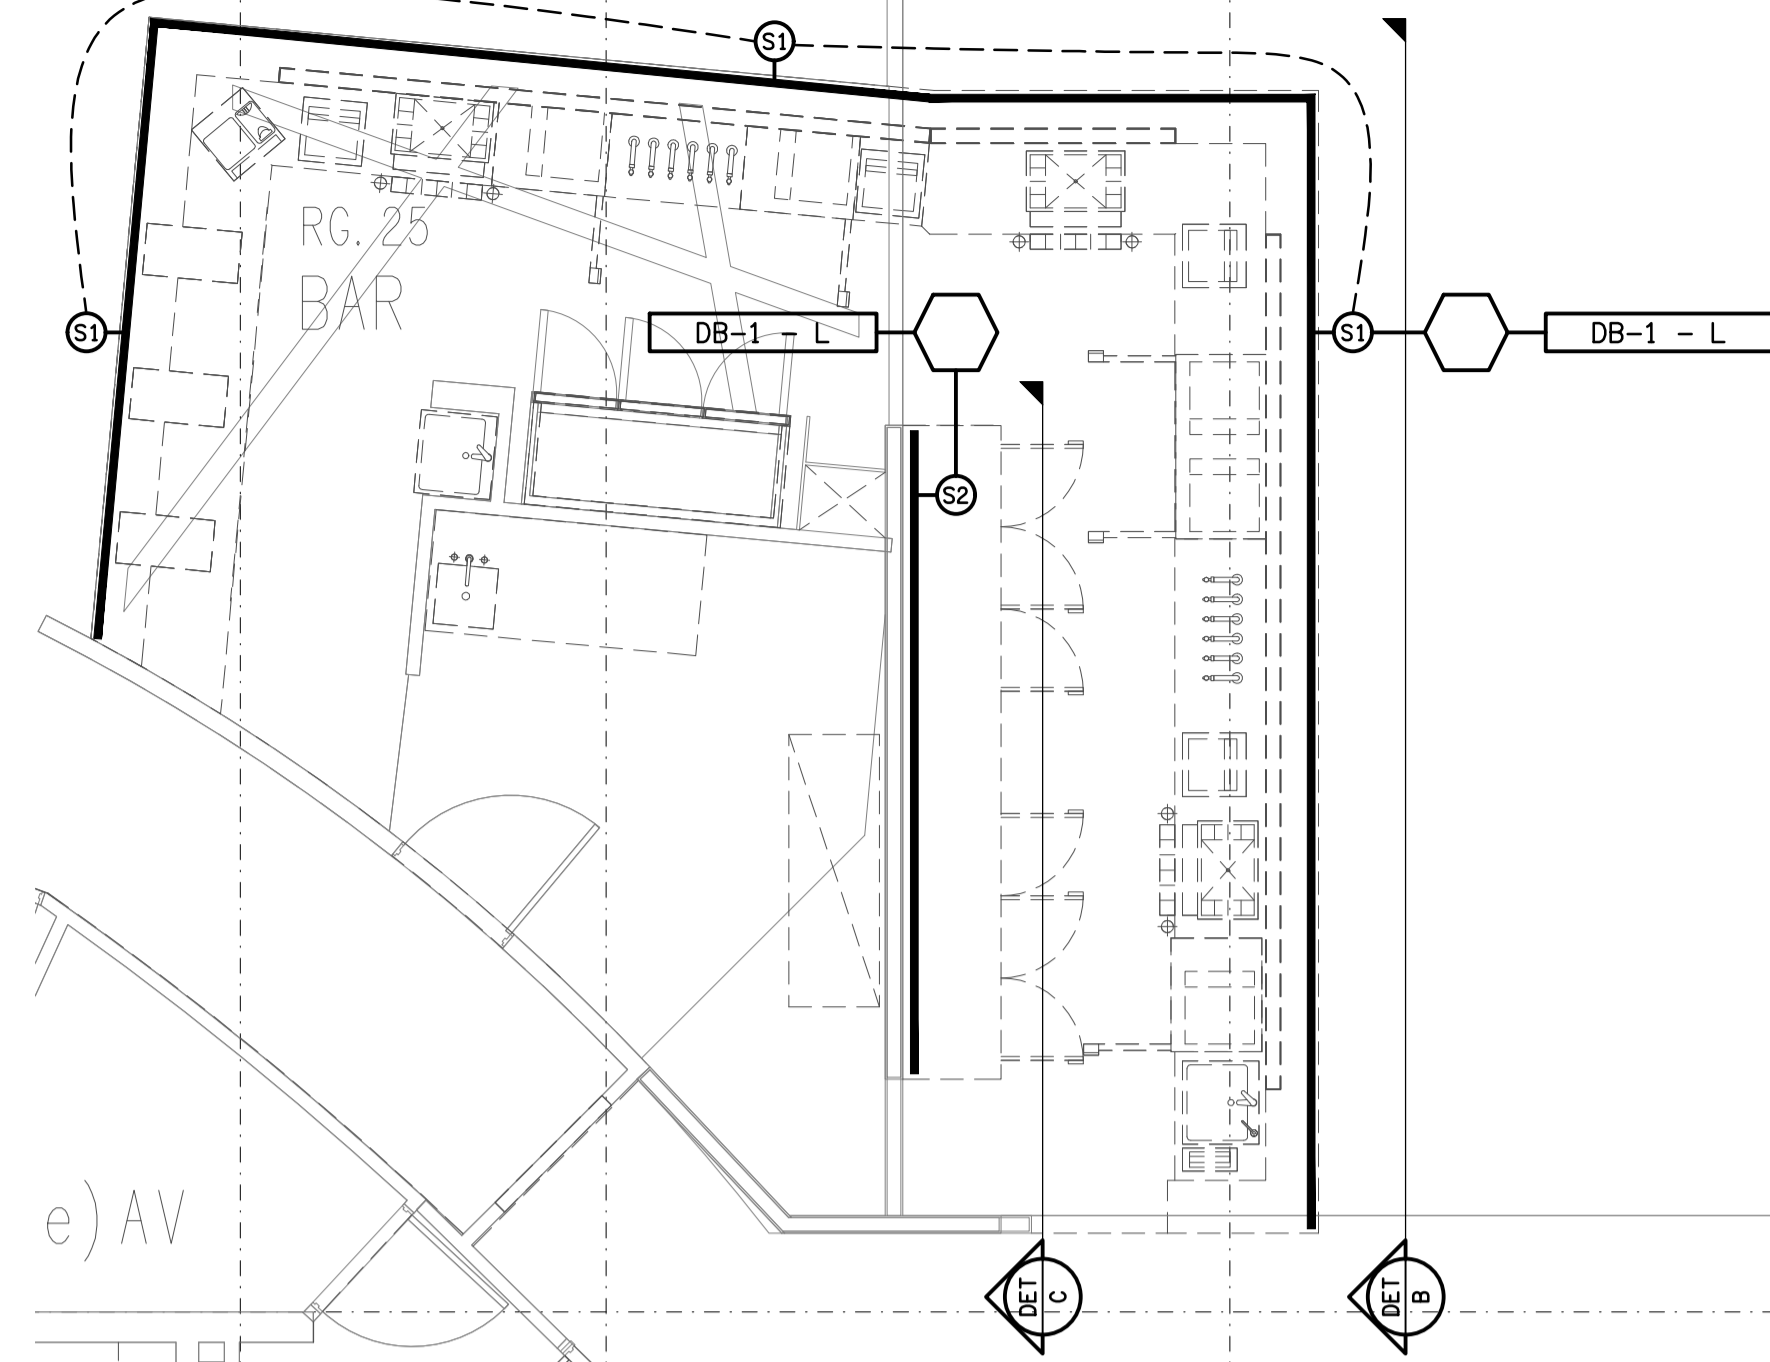

**DETAIL A**  
SPORTS BAR LIGHTING PLAN  
SCALE 1:50

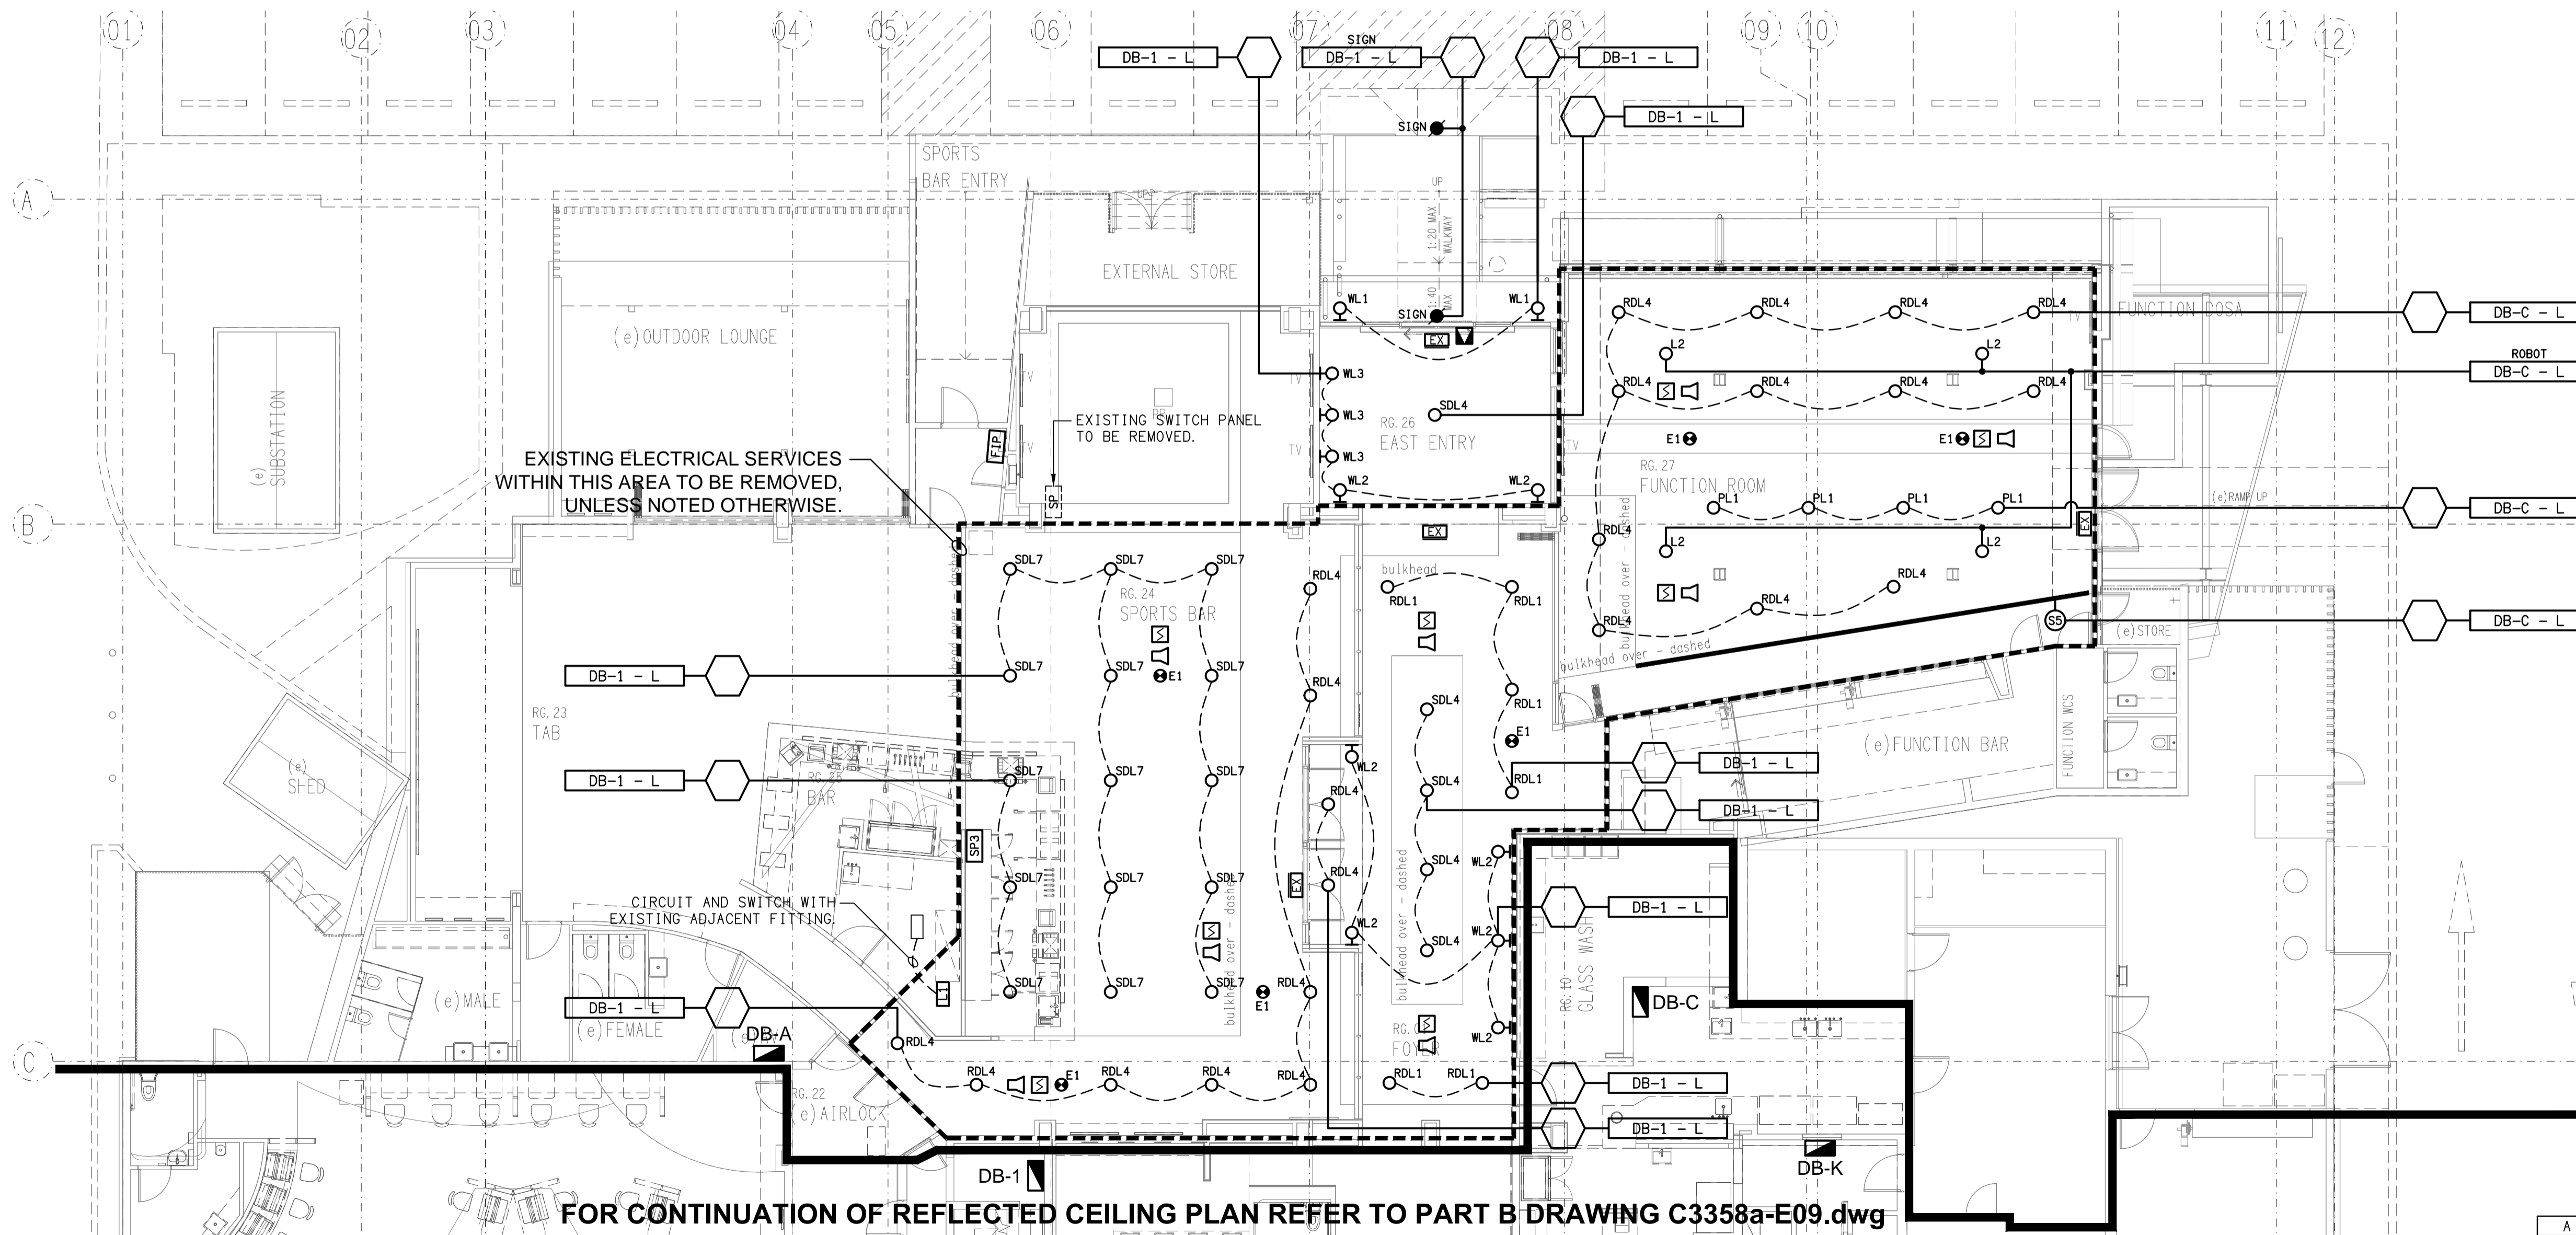

FOR CONTINUATION OF REFLECTED CEILING PLAN REFER TO PART B DRAWING C3358a-E09.dwg

ELECTRICAL DESIGN GROUP BRISBANE  
PTY LTD  
ACN 092 710 793

THE COPYRIGHT OF THIS DRAWING  
REMAINS THE PROPERTY OF THE  
ELECTRICAL DESIGN GROUP.

USE FIGURED DIMENSIONS  
IN PREFERENCE TO SCALE.

ALL DIMENSIONS TO BE  
VERIFIED ONSITE.

**ELECTRICAL DESIGN GROUP**  
ELECTRICAL BUILDING SERVICES CONSULTANTS  
BRISBANE GOLD COAST

P.O. Box 15, Sherwood Q.4075  
Phone: (07) 3278 4375  
Email: brisbane@edg.net.au  
Web: www.edg.net.au

PROJECT:  
**BRACKEN RIDGE TAVERN**

154 BARRETT STREET, BRACKEN RIDGE

A	PRELIMINARY	28/02/2025
REV:	DESCRIPTION:	DATE:

DRAWING: <b>ELECTRICAL SERVICES</b>			
PART A REFLECTED CEILING PLAN			
SCALE: 1:100 UNO	PROJECT NO: <b>C3358a</b>	DRAWING NO: <b>E08</b>	REVISION: <b>A</b>