



NOTE:
EXISTING ELECTRICAL SERVICES WITHIN THIS DASH LINED AREA ARE TO BE REMOVED UNLESS NOTED OTHERWISE.

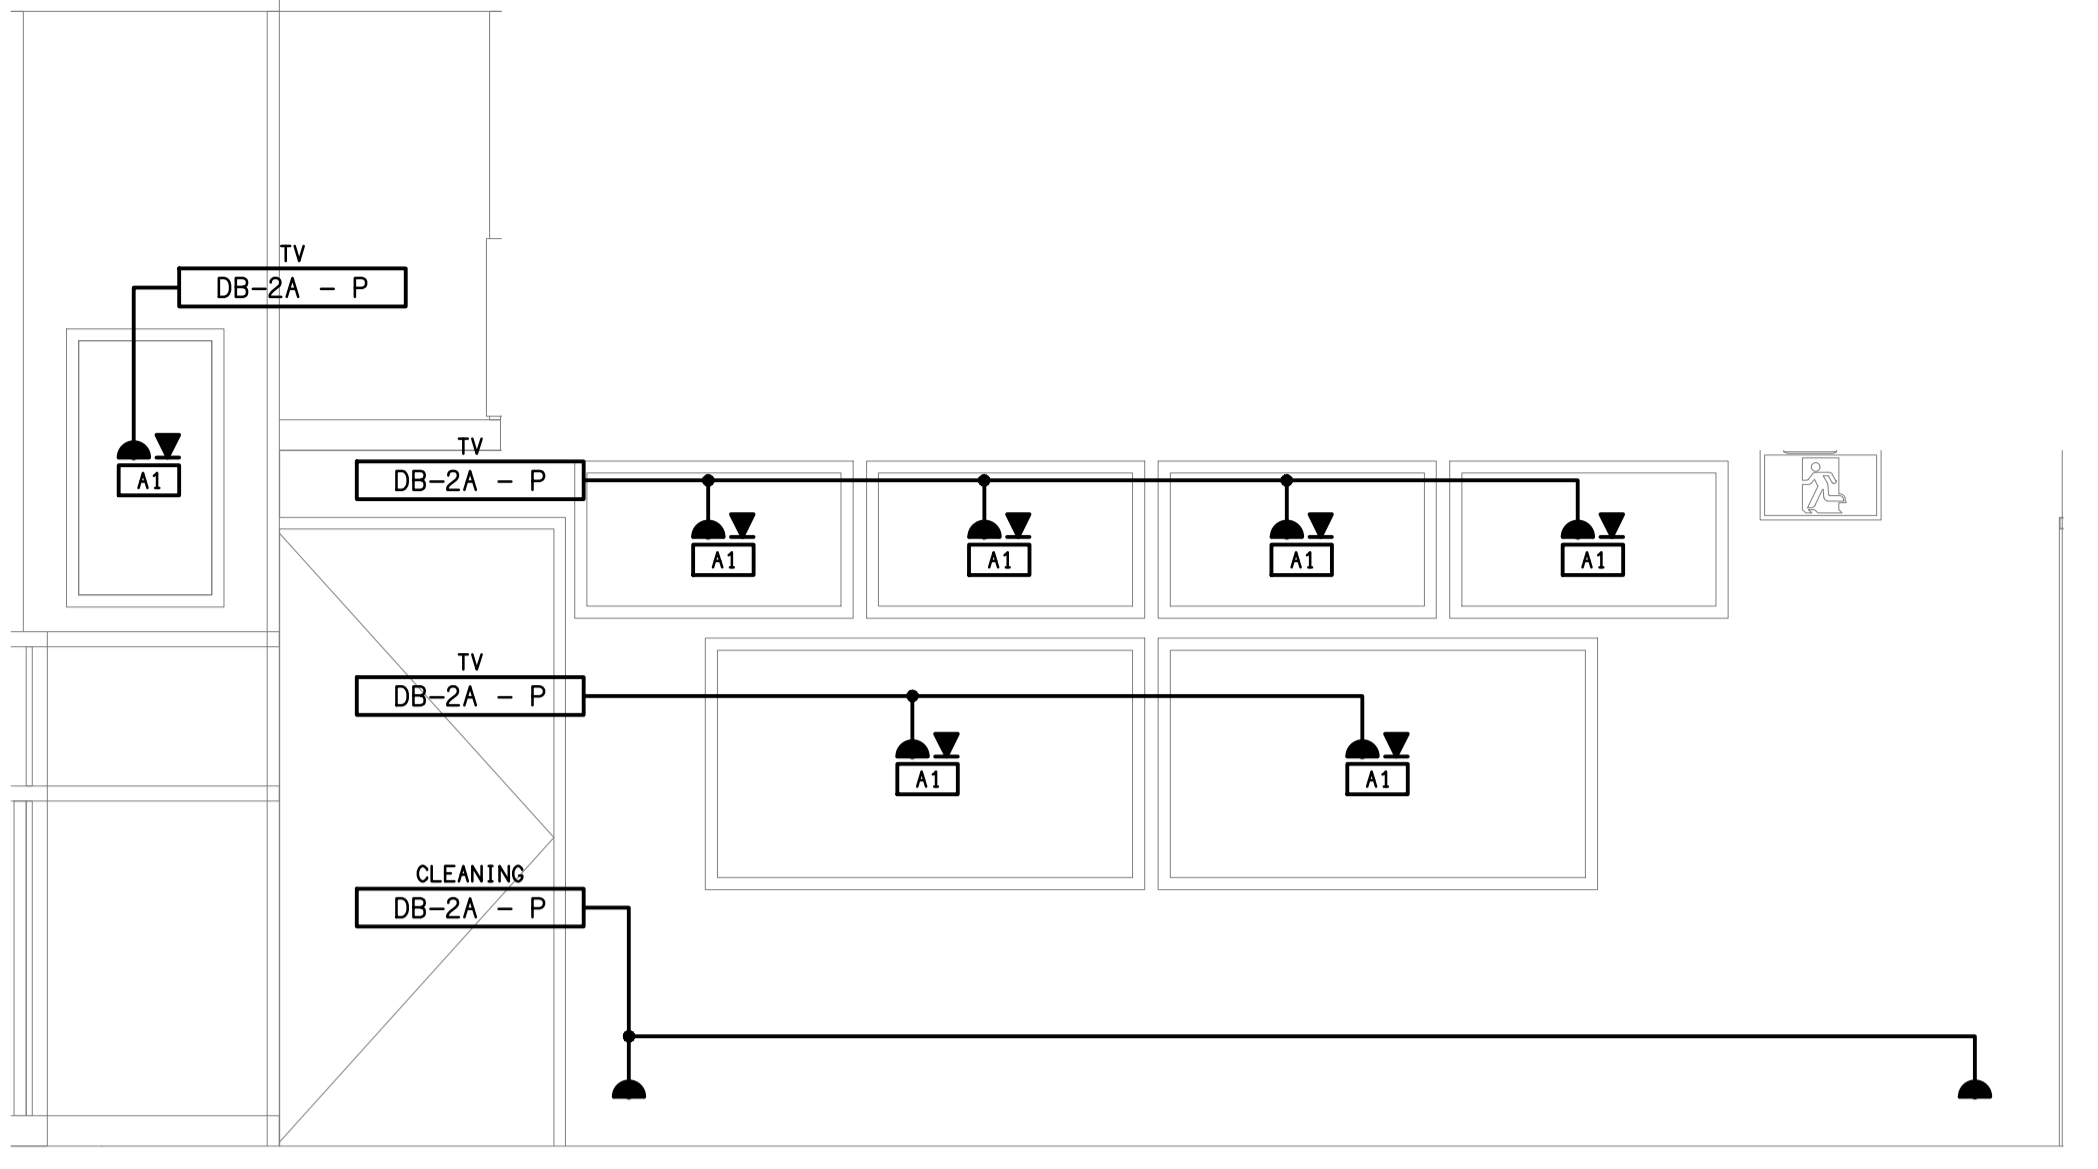

DETAIL B
TAB SCREENS ELEVATION
SCALE 1:25

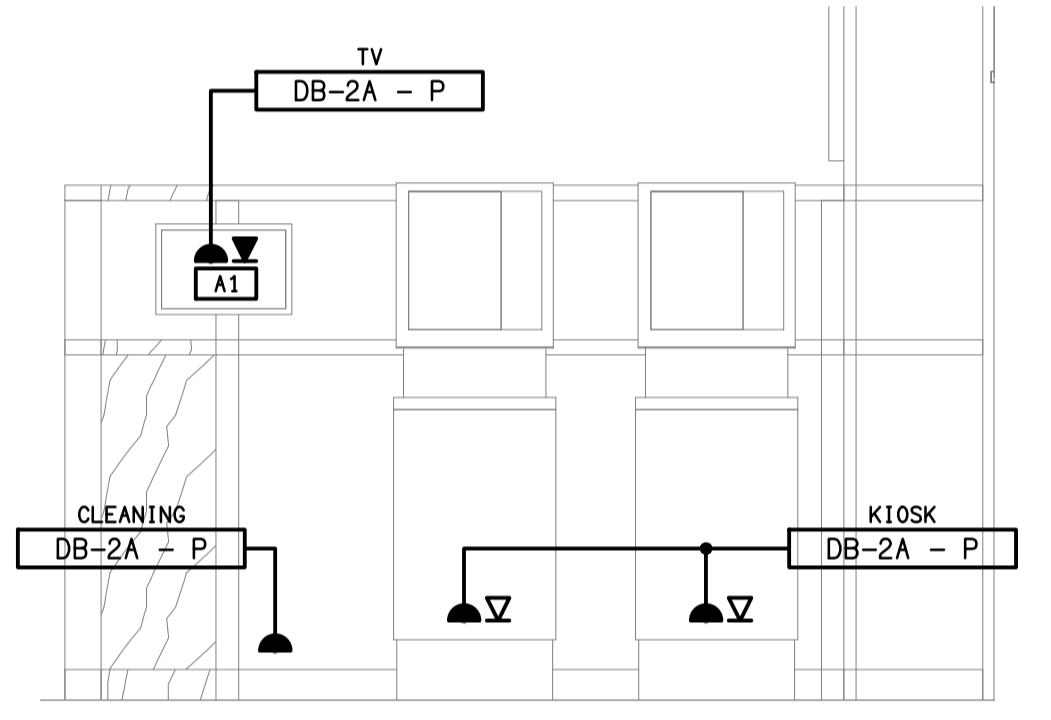

DETAIL A
TAB KIOSKS ELEVATION
SCALE 1:25

ELECTRICAL DESIGN GROUP BRISBANE
PTY LTD
ACN 092 710 793
TRADING AS:
ELECTRICAL DESIGN GROUP

THE COPYRIGHT OF THIS DRAWING
REMAINS THE PROPERTY OF THE
ELECTRICAL DESIGN GROUP.
USE FIGURED DIMENSIONS
IN PREFERENCE TO SCALE.
ALL DIMENSIONS TO BE
VERIFIED ONSITE.

ELECTRICAL DESIGN GROUP
ELECTRICAL BUILDING SERVICES CONSULTANTS
BRISBANE GOLD COAST
P.O. Box 15, Sherwood Q.4075
Phone: (07) 3278 4375
Email: brisbane@edg.net.au
Web: www.edg.net.au

PROJECT:
**MAROOCHY RSL
SPORTS BAR REFURBISHMENT**
105 MEMORIAL AVENUE, MAROOCHYDORE

A	PRELIMINARY	02/12/2024
REV:	DESCRIPTION:	DATE:
ELECTRICAL SERVICES FLOOR PLAN		
SCALE: 1:50	AT A1	PROJECT NO: C3365a
		DRAWING NO: E03
		REVISION: A