




**DETAIL A**  
SPORTS BAR ENTRANCE ELEVATION  
SCALE 1:50

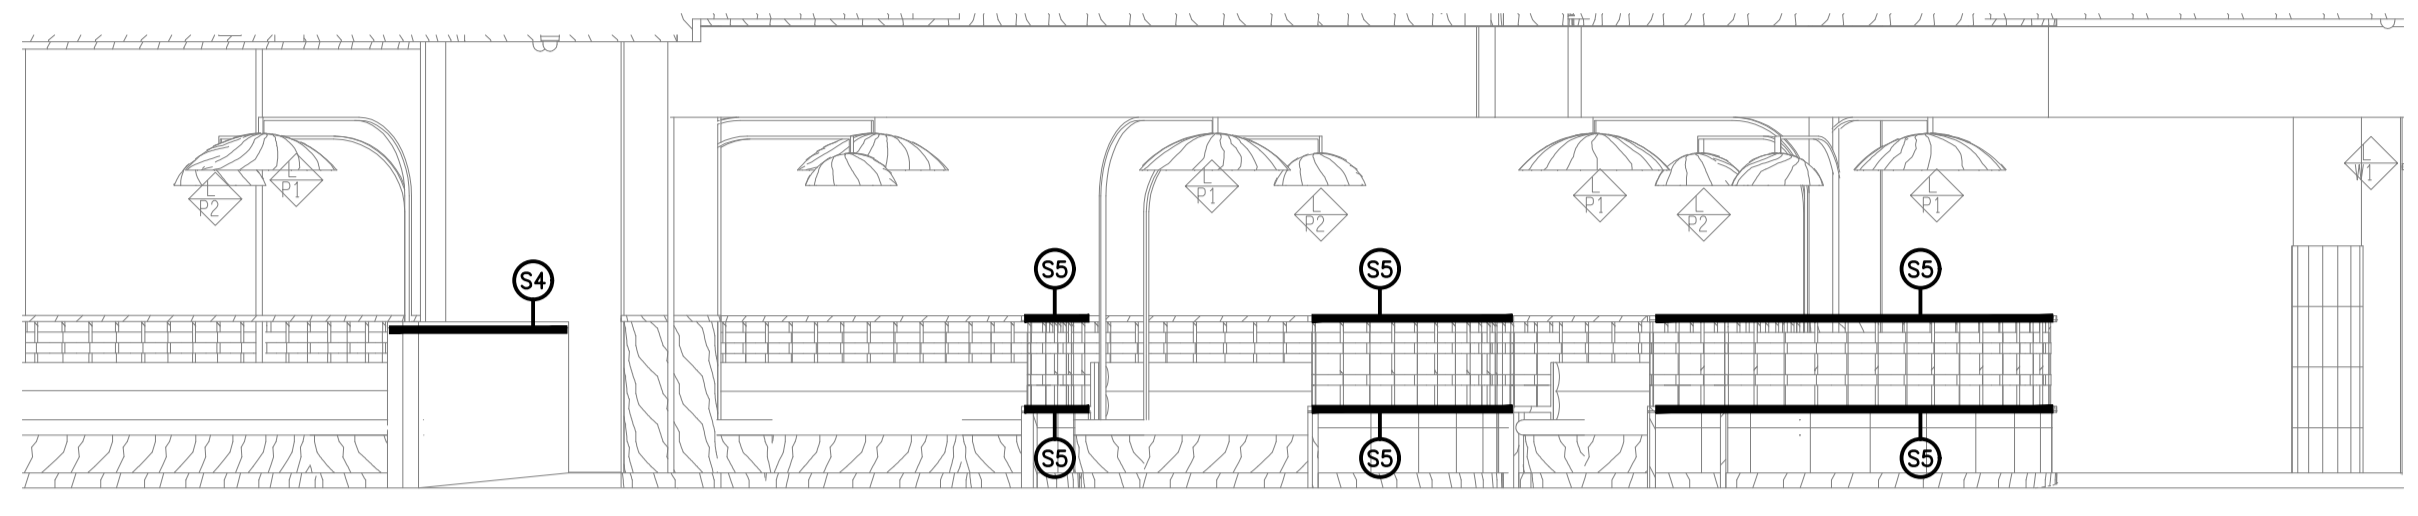


**DETAIL B**  
SPORTS BAR BOOTH ELEVATION  
SCALE 1:50

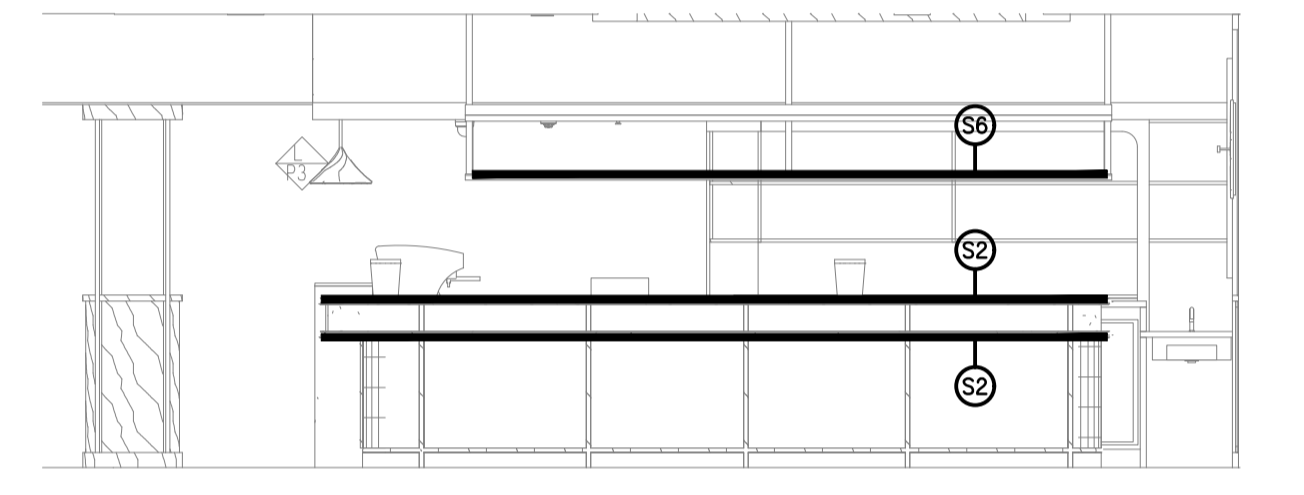


**DETAIL C**  
COCKTAIL BAR ELEVATION  
SCALE 1:50

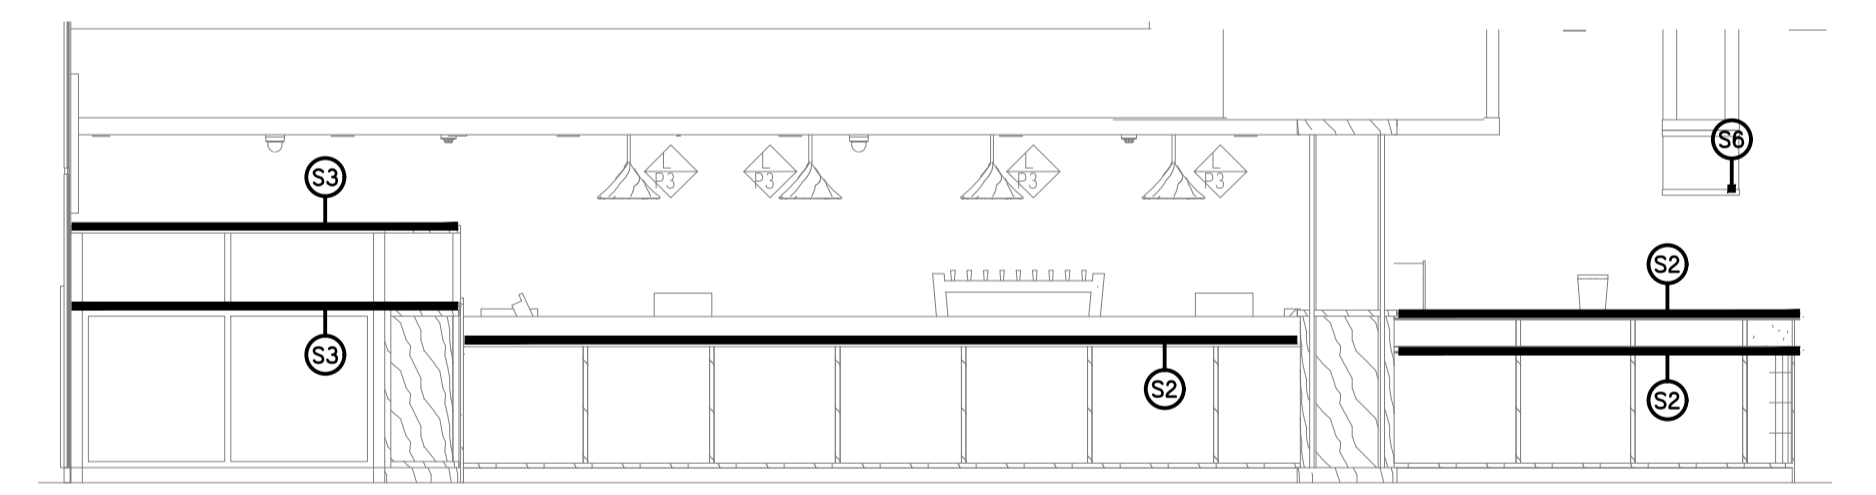

**DETAIL D**  
TAB / BAR ELEVATION  
SCALE 1:50

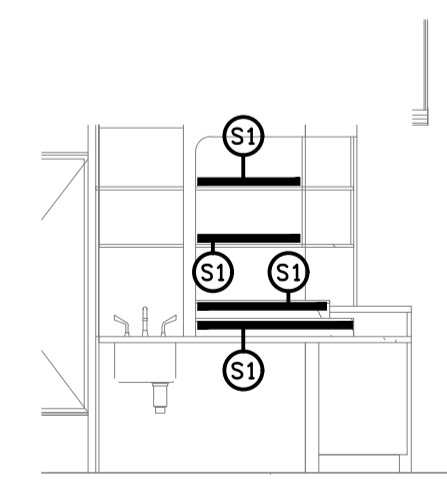

**DETAIL E**  
COCKTAIL REAR WALL ELEVATION  
SCALE 1:50

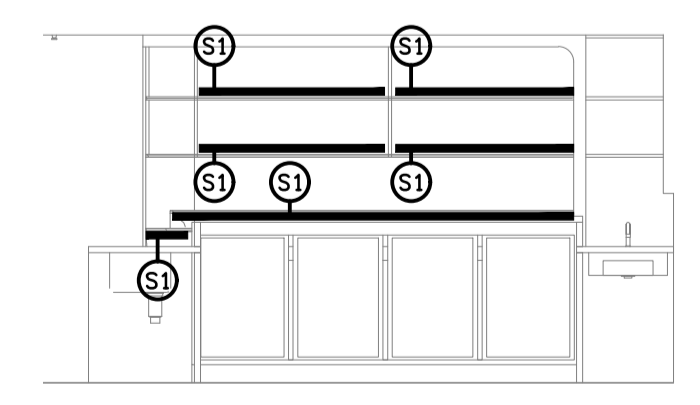

**DETAIL F**  
COCKTAIL REAR WALL ELEVATION  
SCALE 1:50

ELECTRICAL DESIGN GROUP BRISBANE  
PTY LTD  
ACN 092 710 793  
TRADING AS:  
ELECTRICAL DESIGN GROUP

THE COPYRIGHT OF THIS DRAWING  
REMAINS THE PROPERTY OF THE  
ELECTRICAL DESIGN GROUP.  
USE FIGURED DIMENSIONS  
IN PREFERENCE TO SCALE.  
ALL DIMENSIONS TO BE  
VERIFIED ONSITE.

**ELECTRICAL DESIGN GROUP**  
ELECTRICAL BUILDING SERVICES CONSULTANTS  
BRISBANE GOLD COAST

P.O. Box 15, Sherwood Q.4075  
Phone: (07) 3278 4375  
Email: brisbane@edg.net.au  
Web: www.edg.net.au

PROJECT:  
**MAROOCHEY RSL  
SPORTS BAR REFURBISHMENT**

105 MEMORIAL AVENUE, MAROOCHYDORE

A	PRELIMINARY	02/12/2024
REV:	DESCRIPTION:	DATE:

DRAWING:  
**ELECTRICAL SERVICES  
JOINERY LIGHTING PLAN & DETAILS**

SCALE: 1:50 AT A1 PROJECT NO: **C3365a** DRAWING NO: **E05** REVISION: **A**