


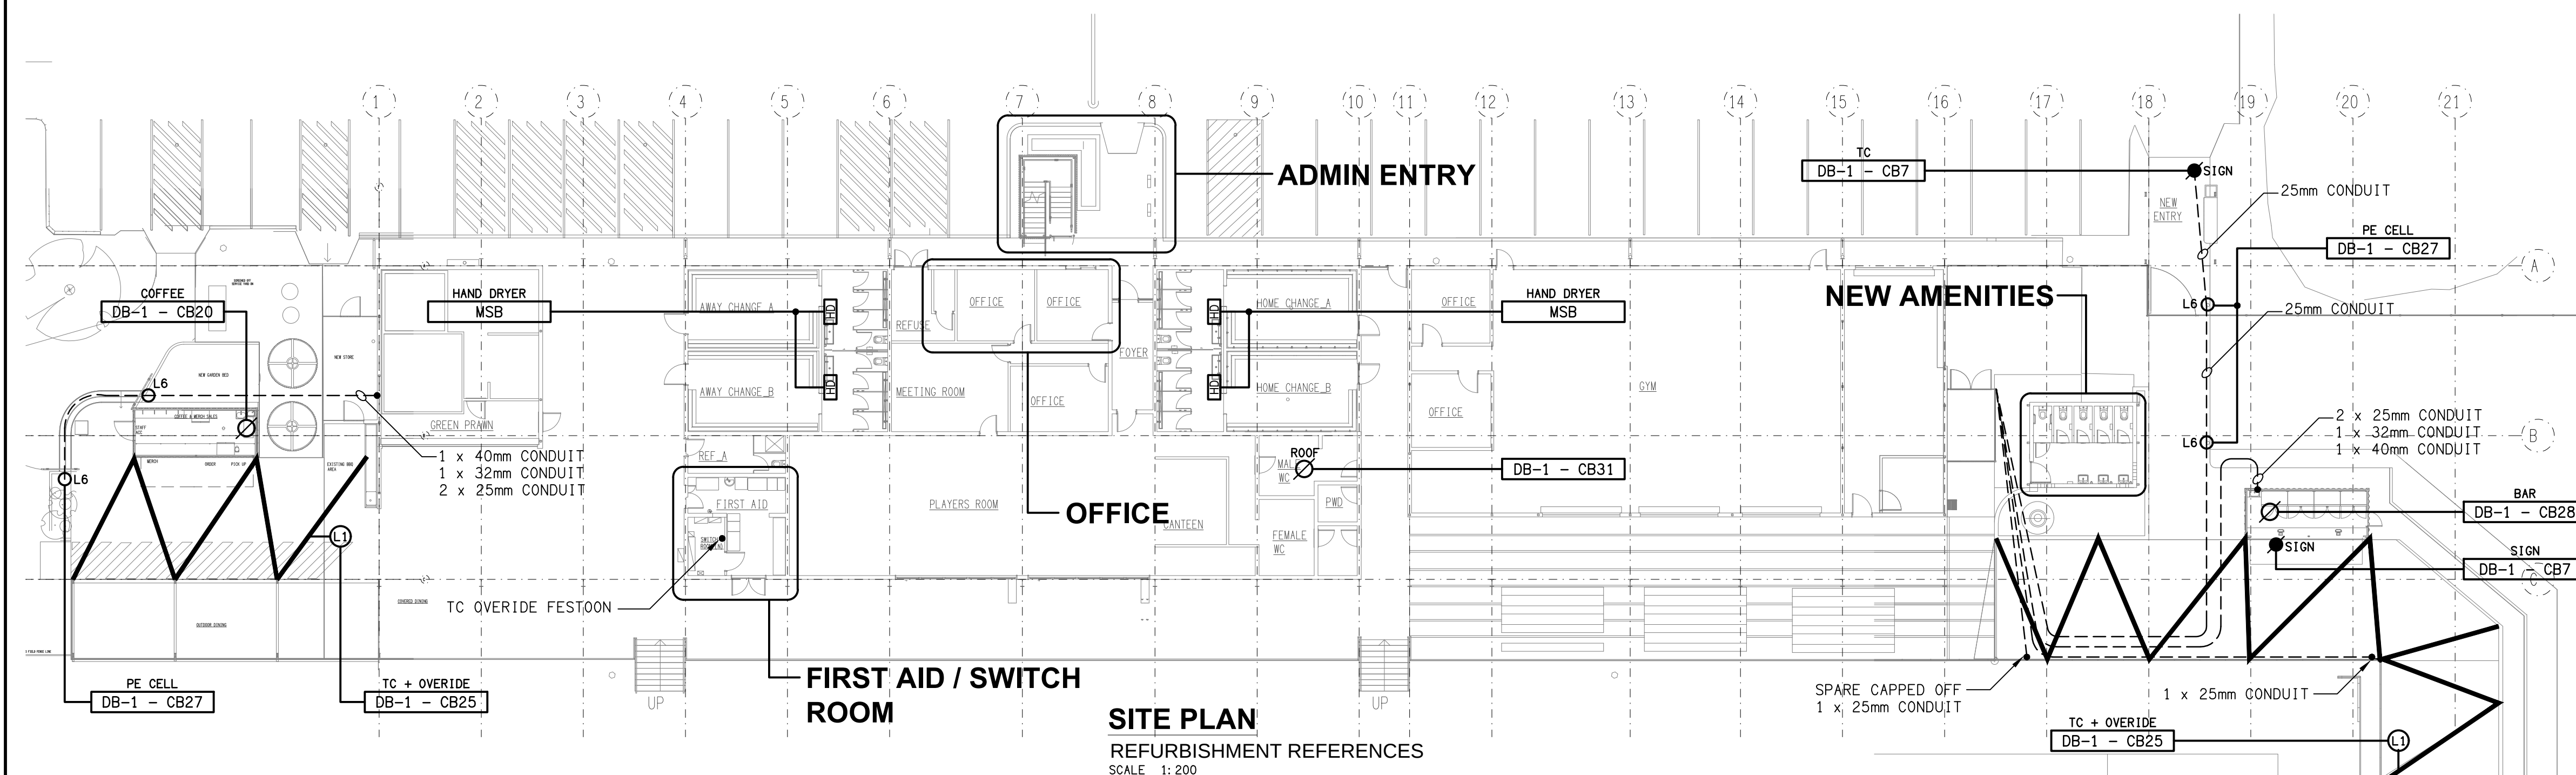

K	AS CONSTRUCTED	11/08/2025
REV:	DESCRIPTION:	DATE:
DRAWING:		
ELECTRICAL SERVICES LEGEND & SITE PLAN		
SCALE:	PROJECT NO:	DRAWING NO:
1:200	C3377a	E01
AT A1		REVISION:
		K