



SWITCHROOM
FLOOR / REFLECTED CEILING PLAN
SCALE 1:50

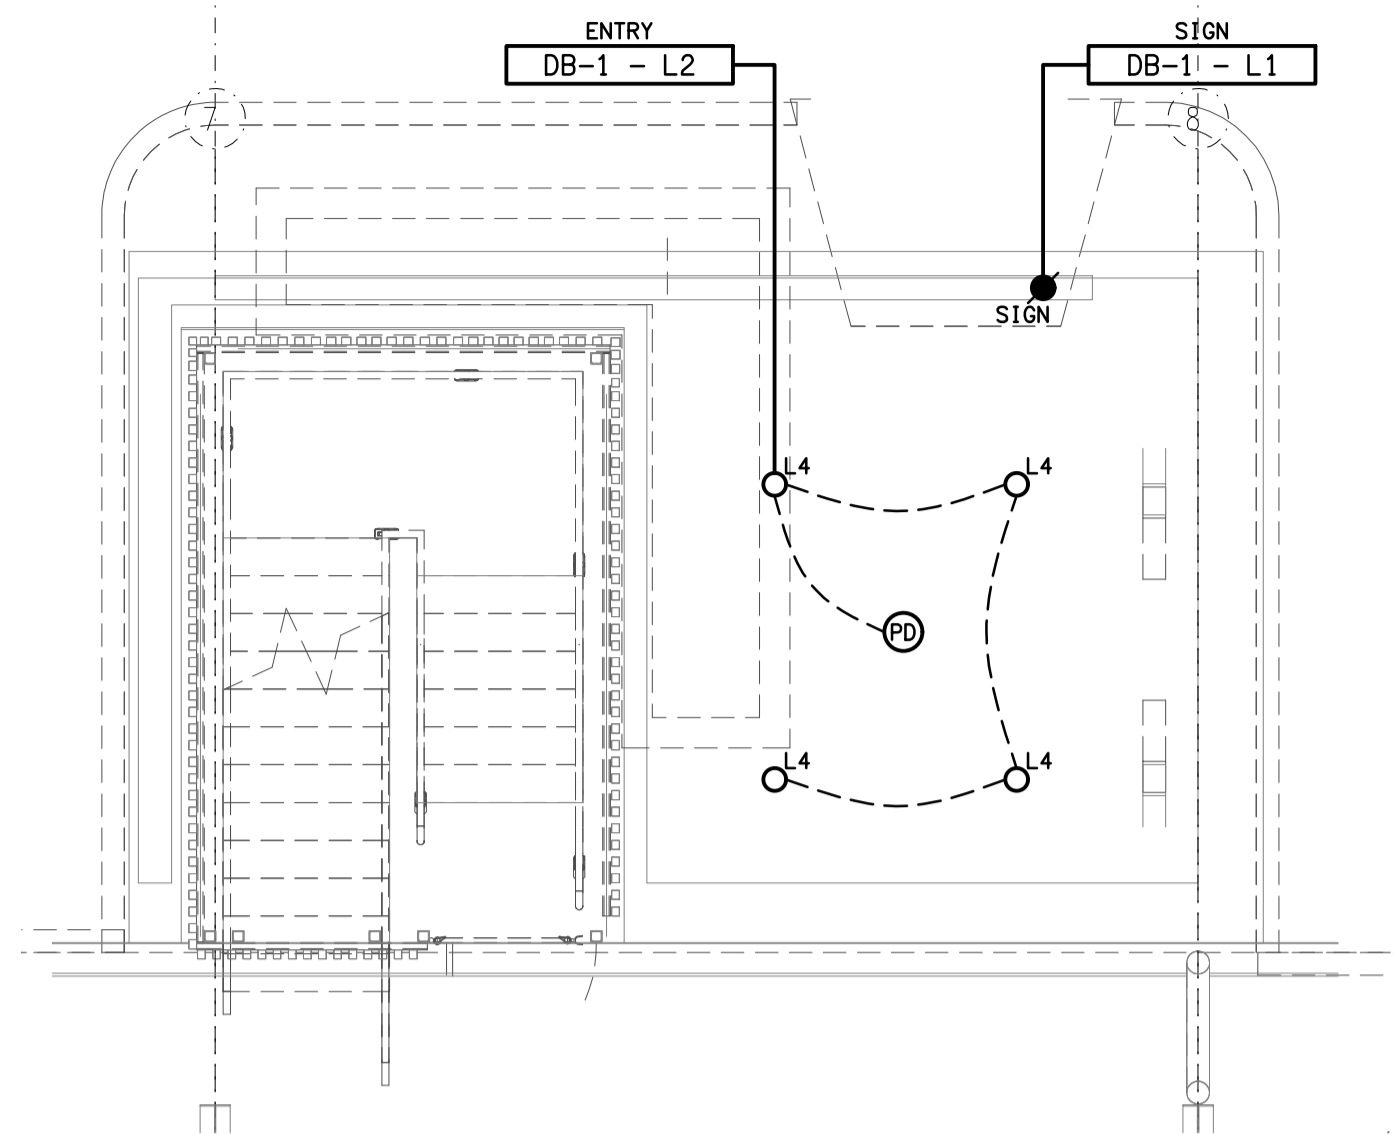

ADMIN ENTRY
FLOOR / REFLECTED CEILING PLAN
SCALE 1:50

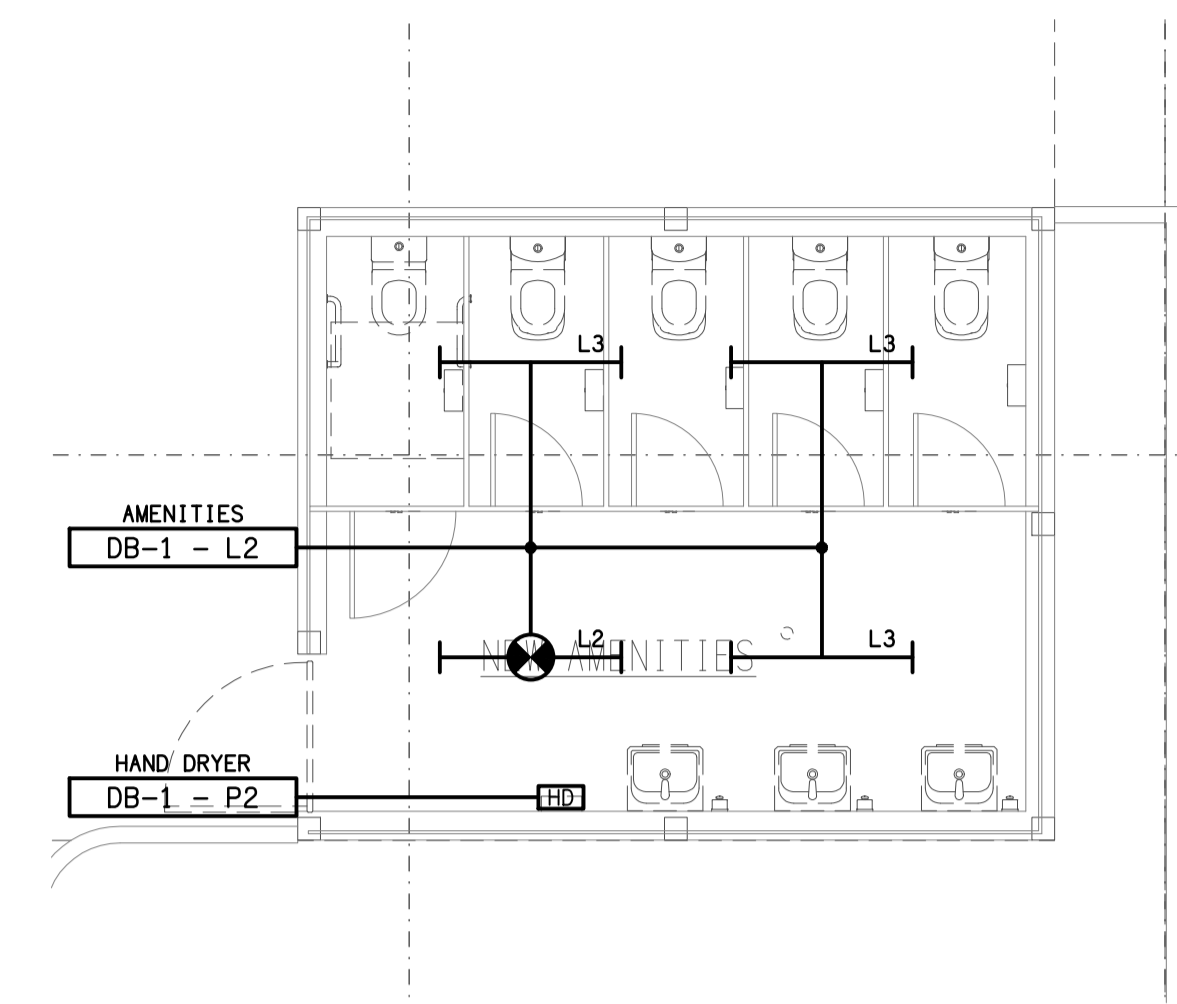

NEW AMENITIES
FLOOR / REFLECTED CEILING PLAN
SCALE 1:50

ELECTRICAL DESIGN GROUP BRISBANE
PTY LTD
ACN 092 710 793
TRADING AS:
ELECTRICAL DESIGN GROUP

THE COPYRIGHT OF THIS DRAWING
REMAINS THE PROPERTY OF THE
ELECTRICAL DESIGN GROUP.

USE FIGURED DIMENSIONS
IN PREFERENCE TO SCALE.

ALL DIMENSIONS TO BE
VERIFIED ONSITE.

ELECTRICAL DESIGN GROUP
ELECTRICAL BUILDING SERVICES CONSULTANTS
BRISBANE GOLD COAST

P.O.Box 15, Sherwood Q.4075
Phone: (07) 3278 4375
Email: brisbane@edg.net.au
Web: www.edg.net.au

PROJECT:
SUNNYBANK RUGBY CLUB

162 GRANADILLA STREET, SUNNYBANK

C	CONSTRUCTION	23/01/2025
REV:	DESCRIPTION:	DATE:

DRAWING:
**ELECTRICAL SERVICES
SWITCHROOM, ENTRY & AMENITIES PLANS**

SCALE:
1:50

AT A1

PROJECT NO:
C3377a

DRAWING NO:
E02

REVISION:
C