


**FLOOR PLAN**  
 AMENITIES BLOCK UPGRADE  
 SCALE 1: 100

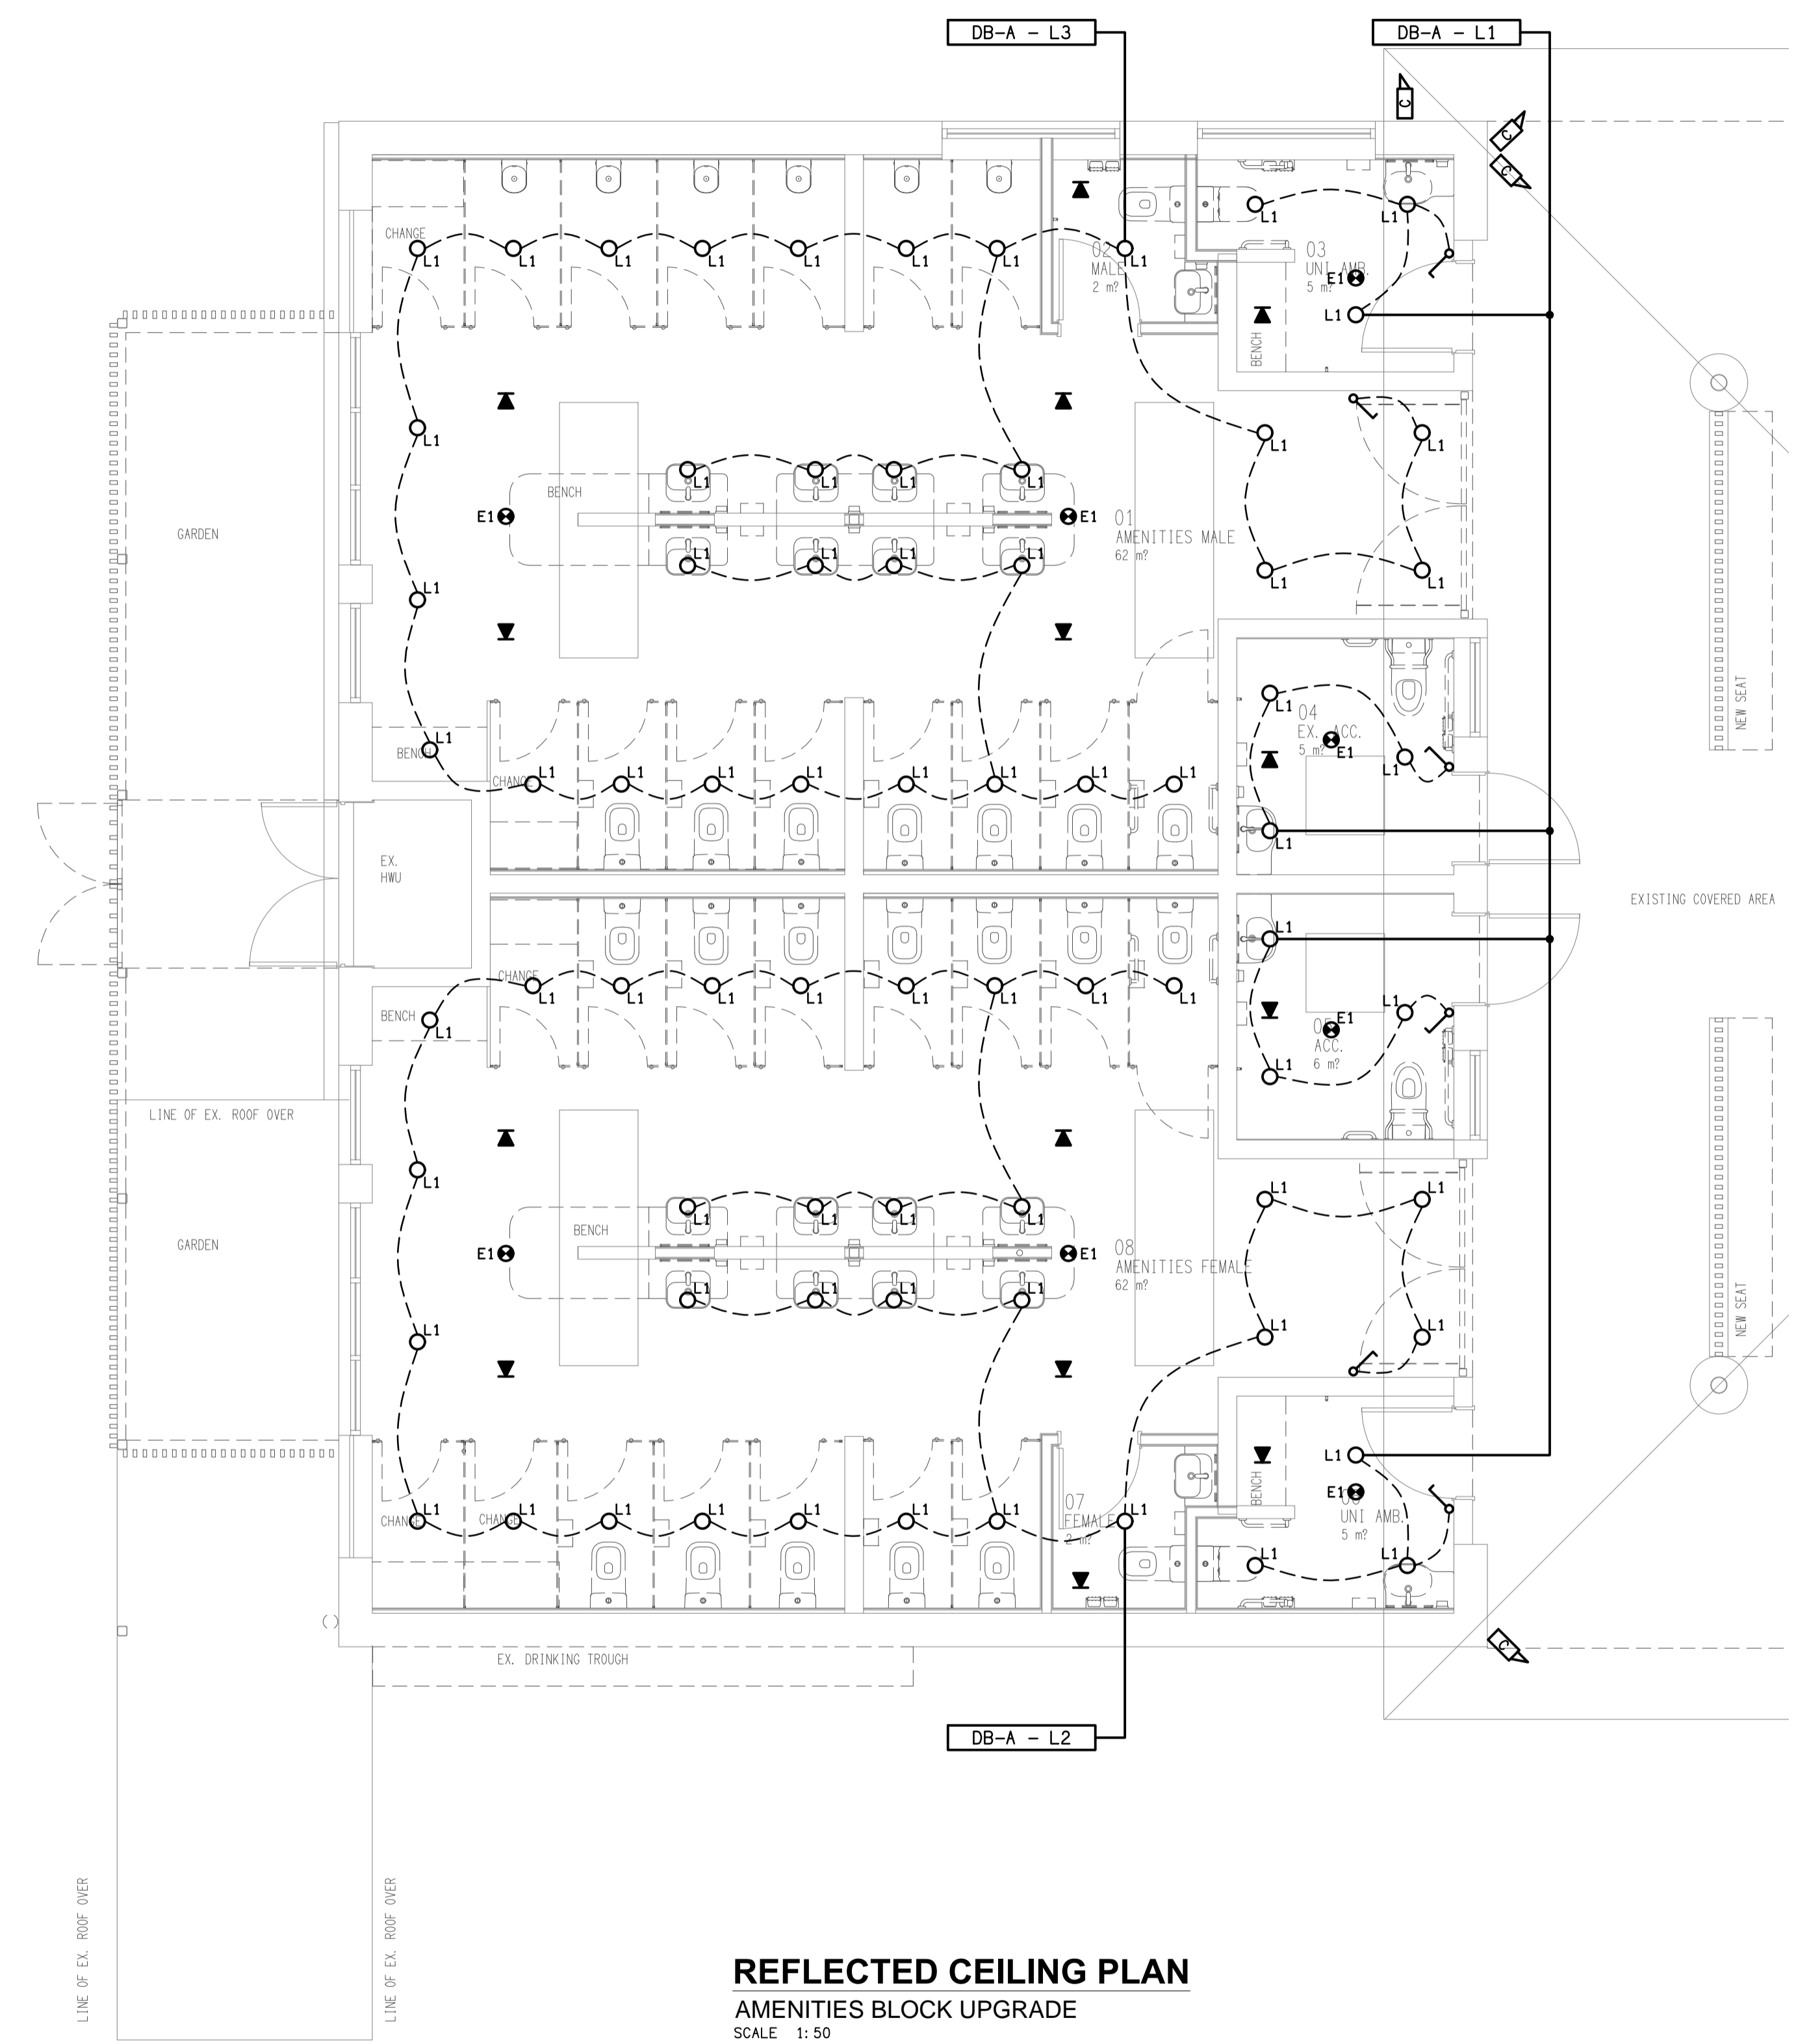

**REFLECTED CEILING PLAN**  
 AMENITIES BLOCK UPGRADE  
 SCALE 1: 50

ELECTRICAL DESIGN GROUP BRISBANE PTY LTD  
 ACN 092 710 793  
 TRADING AS:  
 ELECTRICAL DESIGN GROUP

THE COPYRIGHT OF THIS DRAWING REMAINS THE PROPERTY OF THE ELECTRICAL DESIGN GROUP.  
 USE FIGURED DIMENSIONS IN PREFERENCE TO SCALE.  
 ALL DIMENSIONS TO BE VERIFIED ONSITE.

**ELECTRICAL DESIGN GROUP**  
 ELECTRICAL BUILDING SERVICES CONSULTANTS  
 BRISBANE GOLD COAST  
 P.O. Box 15, Sherwood Q.4075  
 Phone: (07) 3278 4375  
 Email: brisbane@edg.net.au  
 Web: www.edg.net.au

PROJECT:  
**ST JOHNS ANGLICAN COLLEGE  
 FOREST LAKE - AMENITIES BLOCK**  
 COLLEGE AVENUE, FOREST LAKE

B	TENDER	13/11/2024
REV.	DESCRIPTION:	DATE:
DRAWING: <b>ELECTRICAL SERVICES FLOOR PLAN &amp; REFLECTED CEILING PLAN</b>		
SCALE: 1:50 & 1:100	PROJECT NO: <b>C3378a</b>	DRAWING NO: <b>E02</b>
AT A1	REVISION: <b>B</b>	