



**FLOOR PLAN**  
CABLE ROUTE LAYOUT  
SCALE 1:100

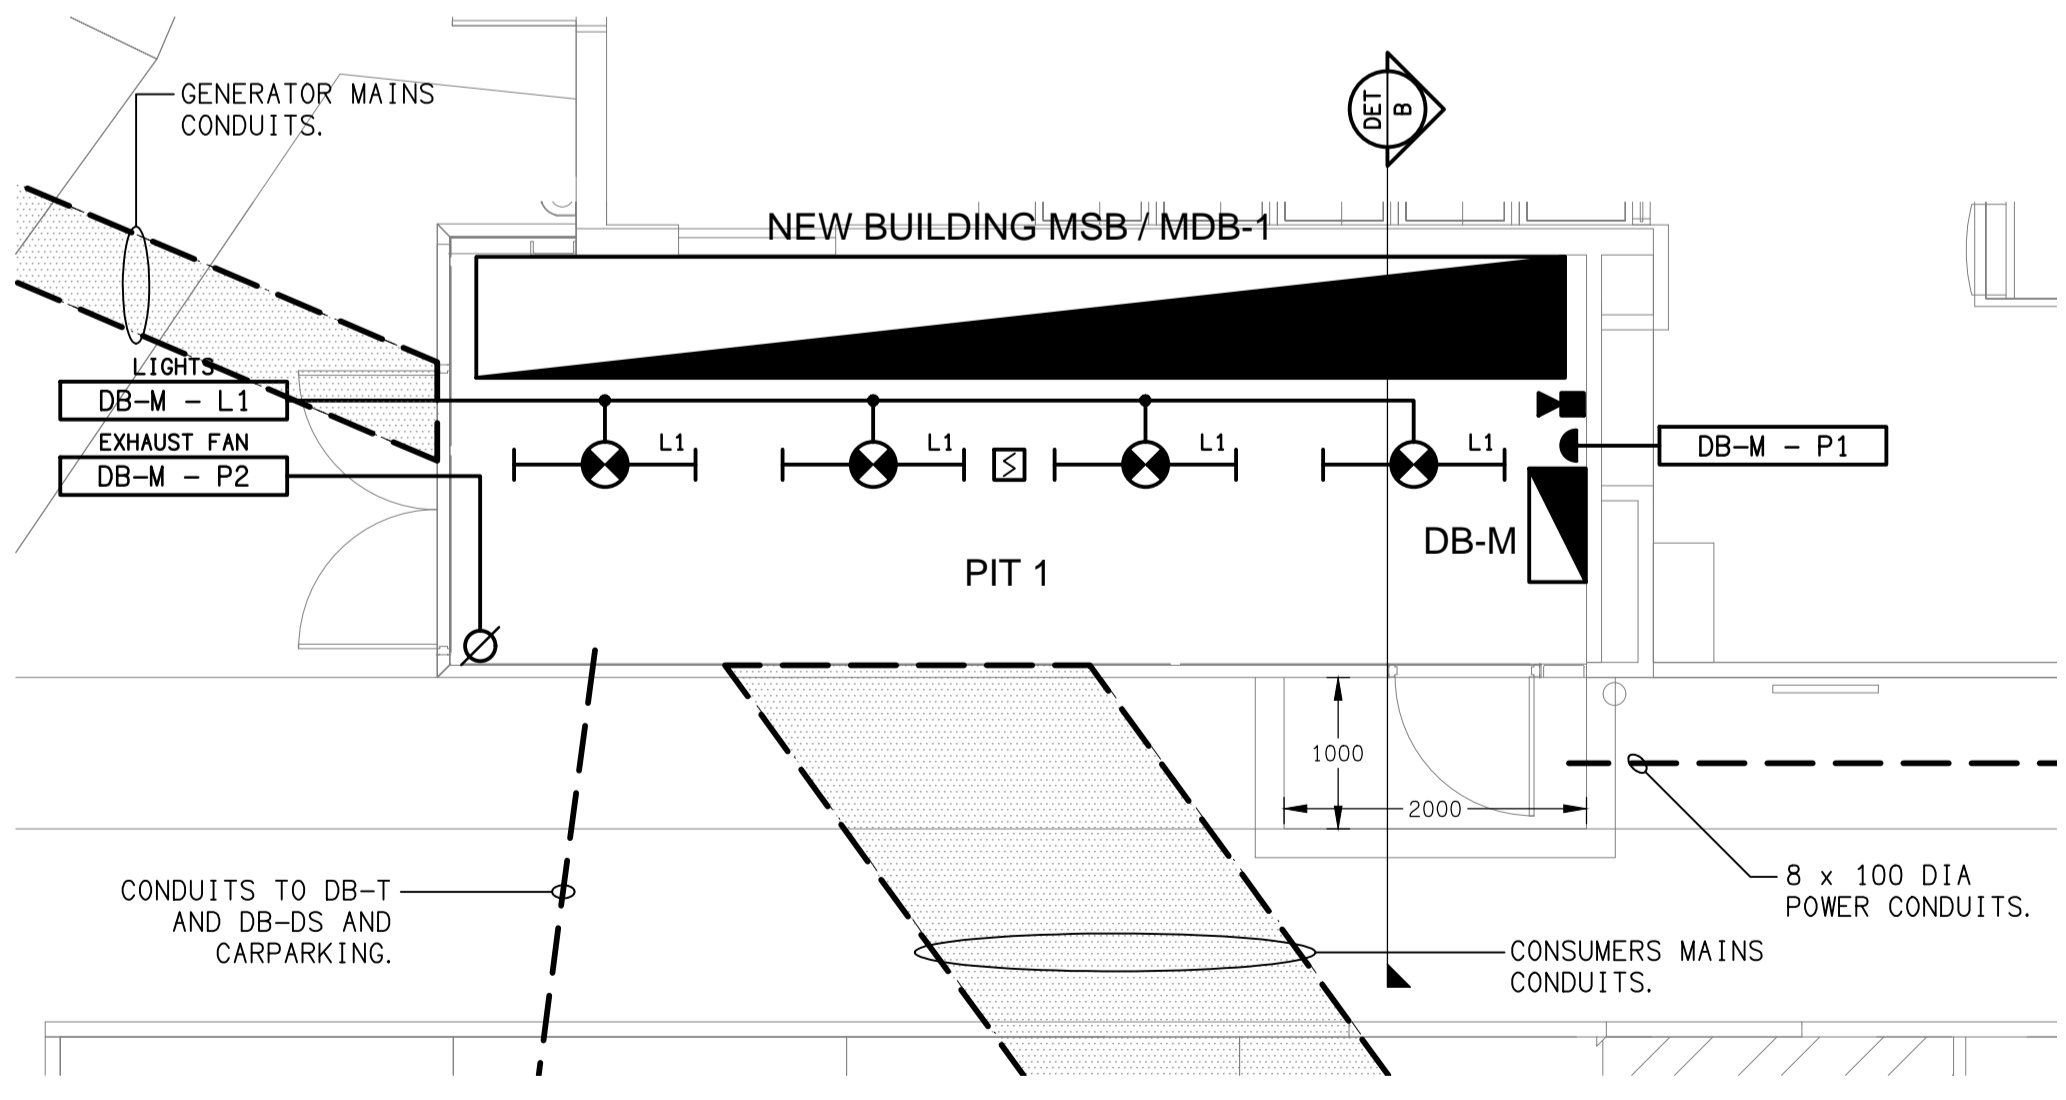

**DETAIL A**  
MDB-1 ROOM PLAN VIEW  
SCALE 1:50

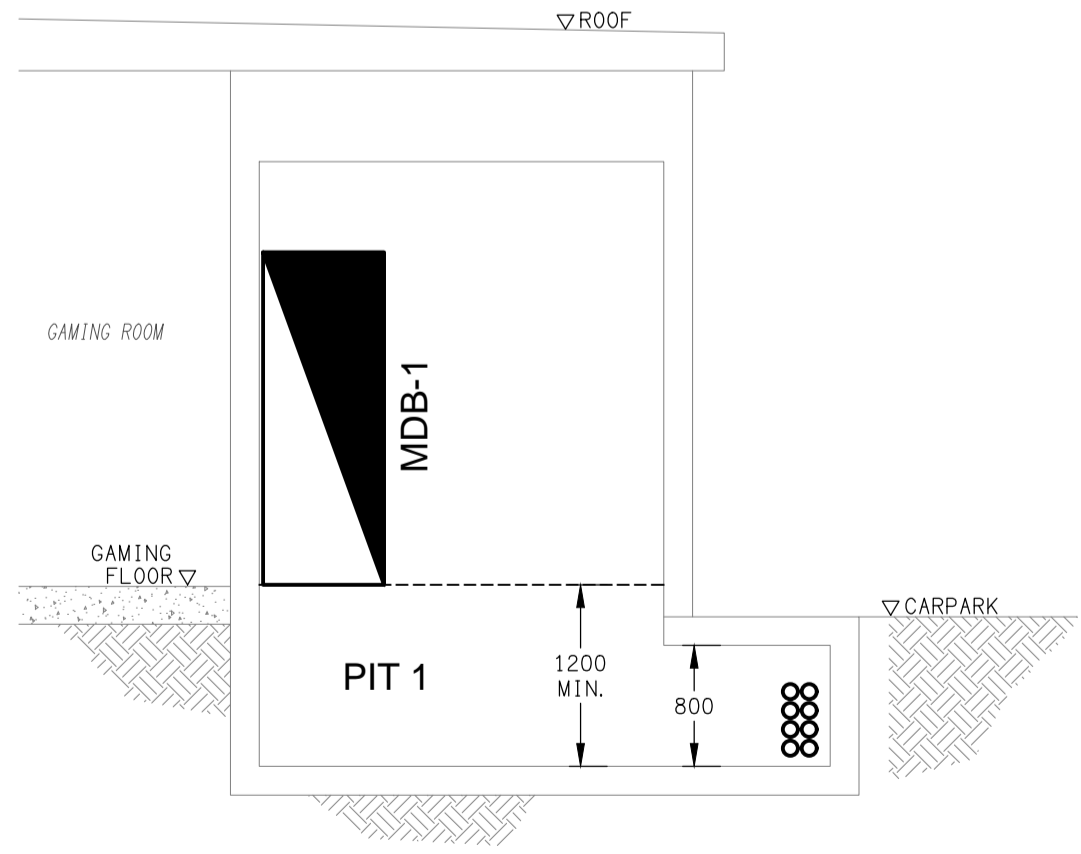

**DETAIL B**  
MDB-1 ROOM SECTION VIEW  
SCALE 1:50

ELECTRICAL DESIGN GROUP BRISBANE  
PTY LTD  
ACN 092 710 793  
TRADING AS:  
ELECTRICAL DESIGN GROUP

THE COPYRIGHT OF THIS DRAWING  
REMAINS THE PROPERTY OF THE  
ELECTRICAL DESIGN GROUP.  
USE FIGURED DIMENSIONS  
IN PREFERENCE TO SCALE.  
ALL DIMENSIONS TO BE  
VERIFIED ONSITE.

**ELECTRICAL DESIGN GROUP**  
ELECTRICAL BUILDING SERVICES CONSULTANTS  
BRISBANE GOLD COAST  
P.O. Box 15, Sherwood Q.4075  
Phone: (07) 3278 4375  
Email: brisbane@edg.net.au  
Web: www.edg.net.au

PROJECT:  
**THE LION RICHLANDS - CARPARK UPGRADE**  
133 PINE ROAD, RICHLANDS

B	PRELIMINARY	14/02/2025
REV:	DESCRIPTION:	DATE:
DRAWING: <b>ELECTRICAL SERVICES MDB-1 &amp; CABLE ROUTE PLANS</b>		
SCALE: AS SHOWN	AT A1	PROJECT NO: <b>C3379a</b>
		DRAWING NO: <b>E04</b>
		REVISION: <b>B</b>