


**EXISTING / DEMOLITION**  
 LIGHTING LAYOUT  
 SCALE 1: 50

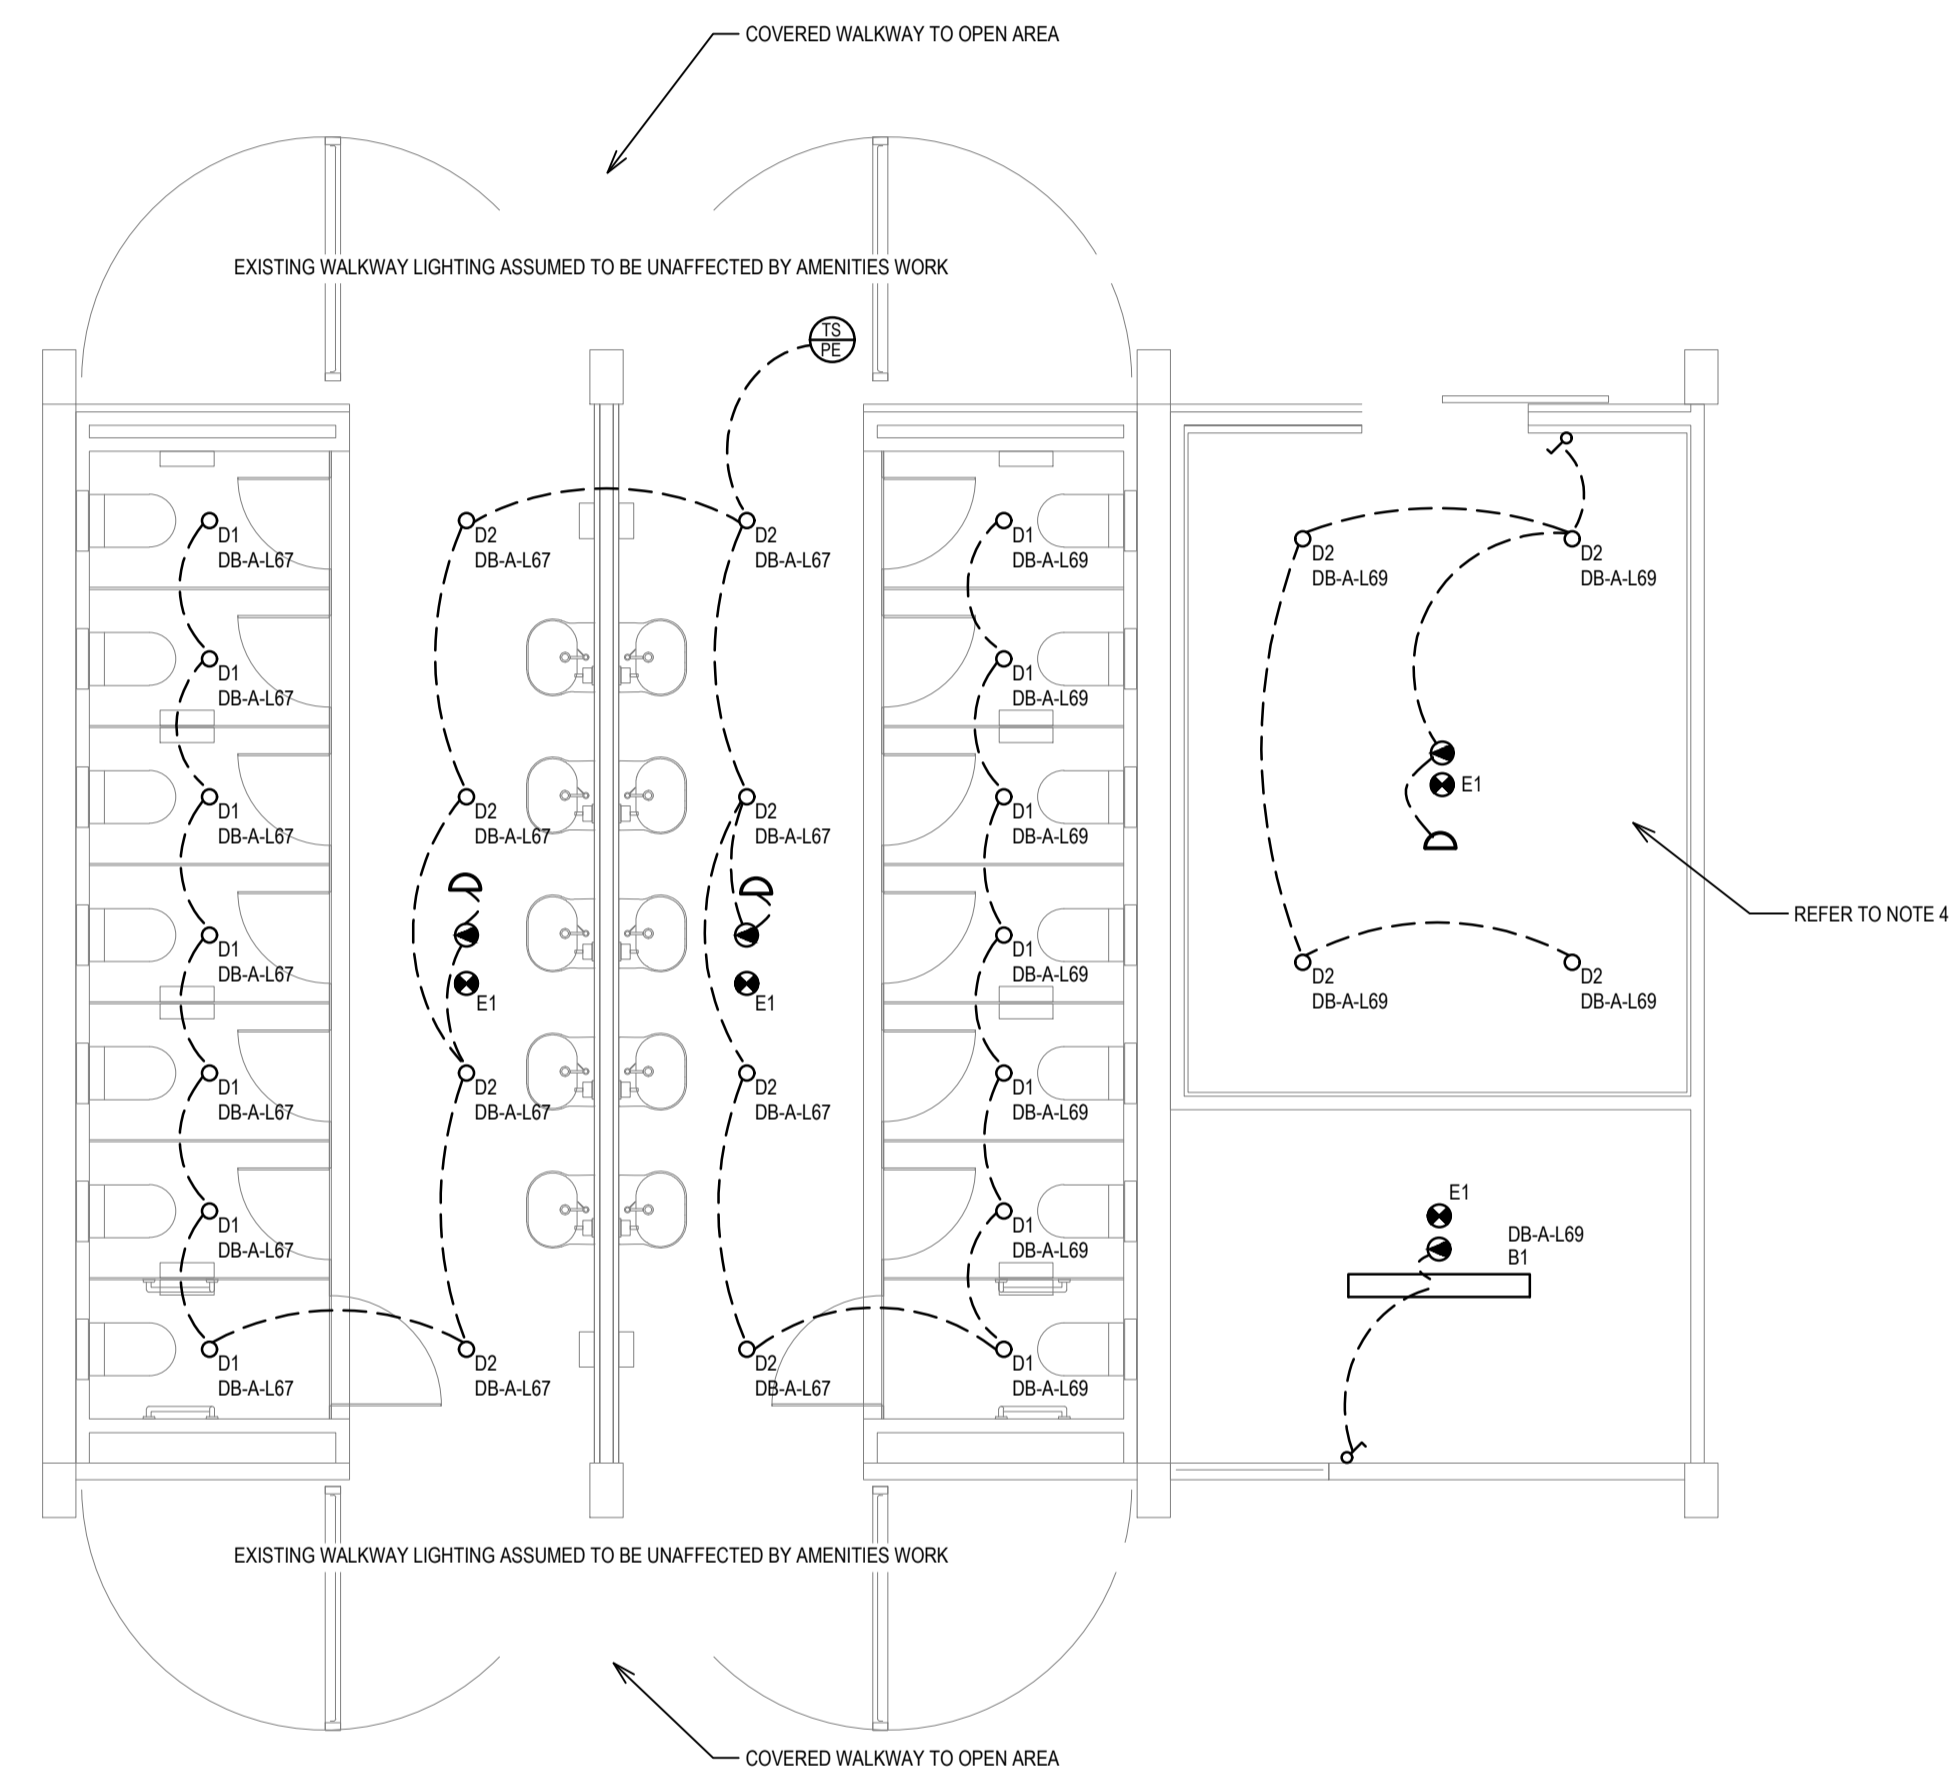

**PROPOSED**  
 LIGHTING LAYOUT JUNIOR STUDENTS  
 SCALE 1: 50

ELECTRICAL DESIGN GROUP BRISBANE  
 PTY LTD  
 ACN 092 710 793  
 TRADING AS:  
 ELECTRICAL DESIGN GROUP

THE COPYRIGHT OF THIS DRAWING  
 REMAINS THE PROPERTY OF THE  
 ELECTRICAL DESIGN GROUP.  
 USE FIGURED DIMENSIONS  
 IN PREFERENCE TO SCALE.  
 ALL DIMENSIONS TO BE  
 VERIFIED ONSITE.



E: info@aswelectrical.com.au  
 M: 0450 440 569  
 www.aswelectrical.com.au

**ELECTRICAL DESIGN GROUP**  
 ELECTRICAL BUILDING SERVICES CONSULTANTS  
 BRISBANE GOLD COAST

P.O. Box 15, Sherwood Q.4075  
 Phone: (07) 3278 4375  
 Email: brisbane@edg.net.au  
 Web: www.edg.net.au

PROJECT:  
**BOONAH STATE HIGH SCHOOL  
 AMENITIES UPGRADE**  
 32 MACQUARIE STREET, BOONAH, QUEENSLAND

C	CONSTRUCTION	19/12/2024
REV:	DESCRIPTION:	DATE:

DRAWING:  
**ELECTRICAL SERVICES  
 BLOCK A - AMENITIES JUNIOR LIGHTING  
 LAYOUTS**

SCALE: 1:50	AT A1	PROJECT NO: <b>C3388a</b>	DRAWING NO: <b>E02</b>	REVISION: <b>C</b>
----------------	-------	------------------------------	---------------------------	-----------------------