


NOTE:
 REFER TO DRAWING C3391a-E06.dwg FOR THE
 ADDITIONAL JOINERY & WALL LIGHTING PLAN.
 REFER TO DRAWING C3391a-E07.dwg FOR THE
 ADDITIONAL CEILING FAN & DECK HEATER PLAN.

**CEILING ELECTRICAL SERVICES
 OUTSIDE OF THIS AREA ARE TO REMAIN
 AS IS, UNLESS NOTED OTHERWISE.**

**THIS AREA IS NOT PART
 OF THE CEILING
 ELECTRICAL WORKS**

**CEILING ELECTRICAL SERVICES
 OUTSIDE OF THIS AREA ARE TO REMAIN
 AS IS, UNLESS NOTED OTHERWISE.**

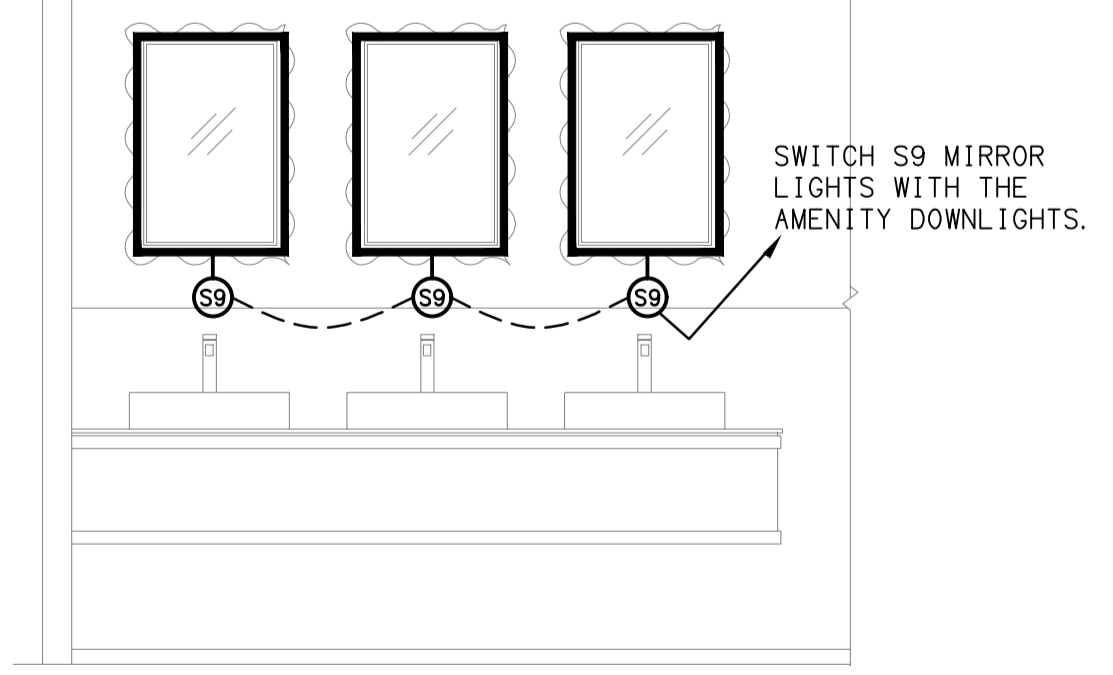

DETAIL A
 TYPICAL GAMING VANITY BENCH ELEVATION
 SCALE 1:25

ELECTRICAL DESIGN GROUP BRISBANE PTY LTD ACN 092 710 793 TRADING AS: ELECTRICAL DESIGN GROUP	THE COPYRIGHT OF THIS DRAWING REMAINS THE PROPERTY OF THE ELECTRICAL DESIGN GROUP. USE FIGURED DIMENSIONS IN PREFERENCE TO SCALE. ALL DIMENSIONS TO BE VERIFIED ONSITE.	ELECTRICAL DESIGN GROUP ELECTRICAL BUILDING SERVICES CONSULTANTS BRISBANE GOLD COAST P.O. Box 15, Sherwood Q. 4075 Phone: (07) 3278 4375 Email: brisbane@edg.net.au Web: www.edg.net.au	PROJECT: WATERFRONT HOTEL, DIDDILLIBAH	B TENDER 22/11/2024
			2 / 46 DAVID LOW WAY, DIDDILLIBAH, SUNSHINE COAST	REV: DESCRIPTION: DATE:
			DRAWING: ELECTRICAL SERVICES REFLECTED CEILING PLAN	SCALE: 1:100
			PROJECT NO: C3391a	DRAWING NO: E05
			REVISION: B	