



NOTE:
 REFER TO DRAWING C3391a-E06.dwg FOR THE
 ADDITIONAL JOINERY & WALL LIGHTING PLAN.
 REFER TO DRAWING C3391a-E07.dwg FOR THE
 ADDITIONAL CEILING FAN & DECK HEATER PLAN.

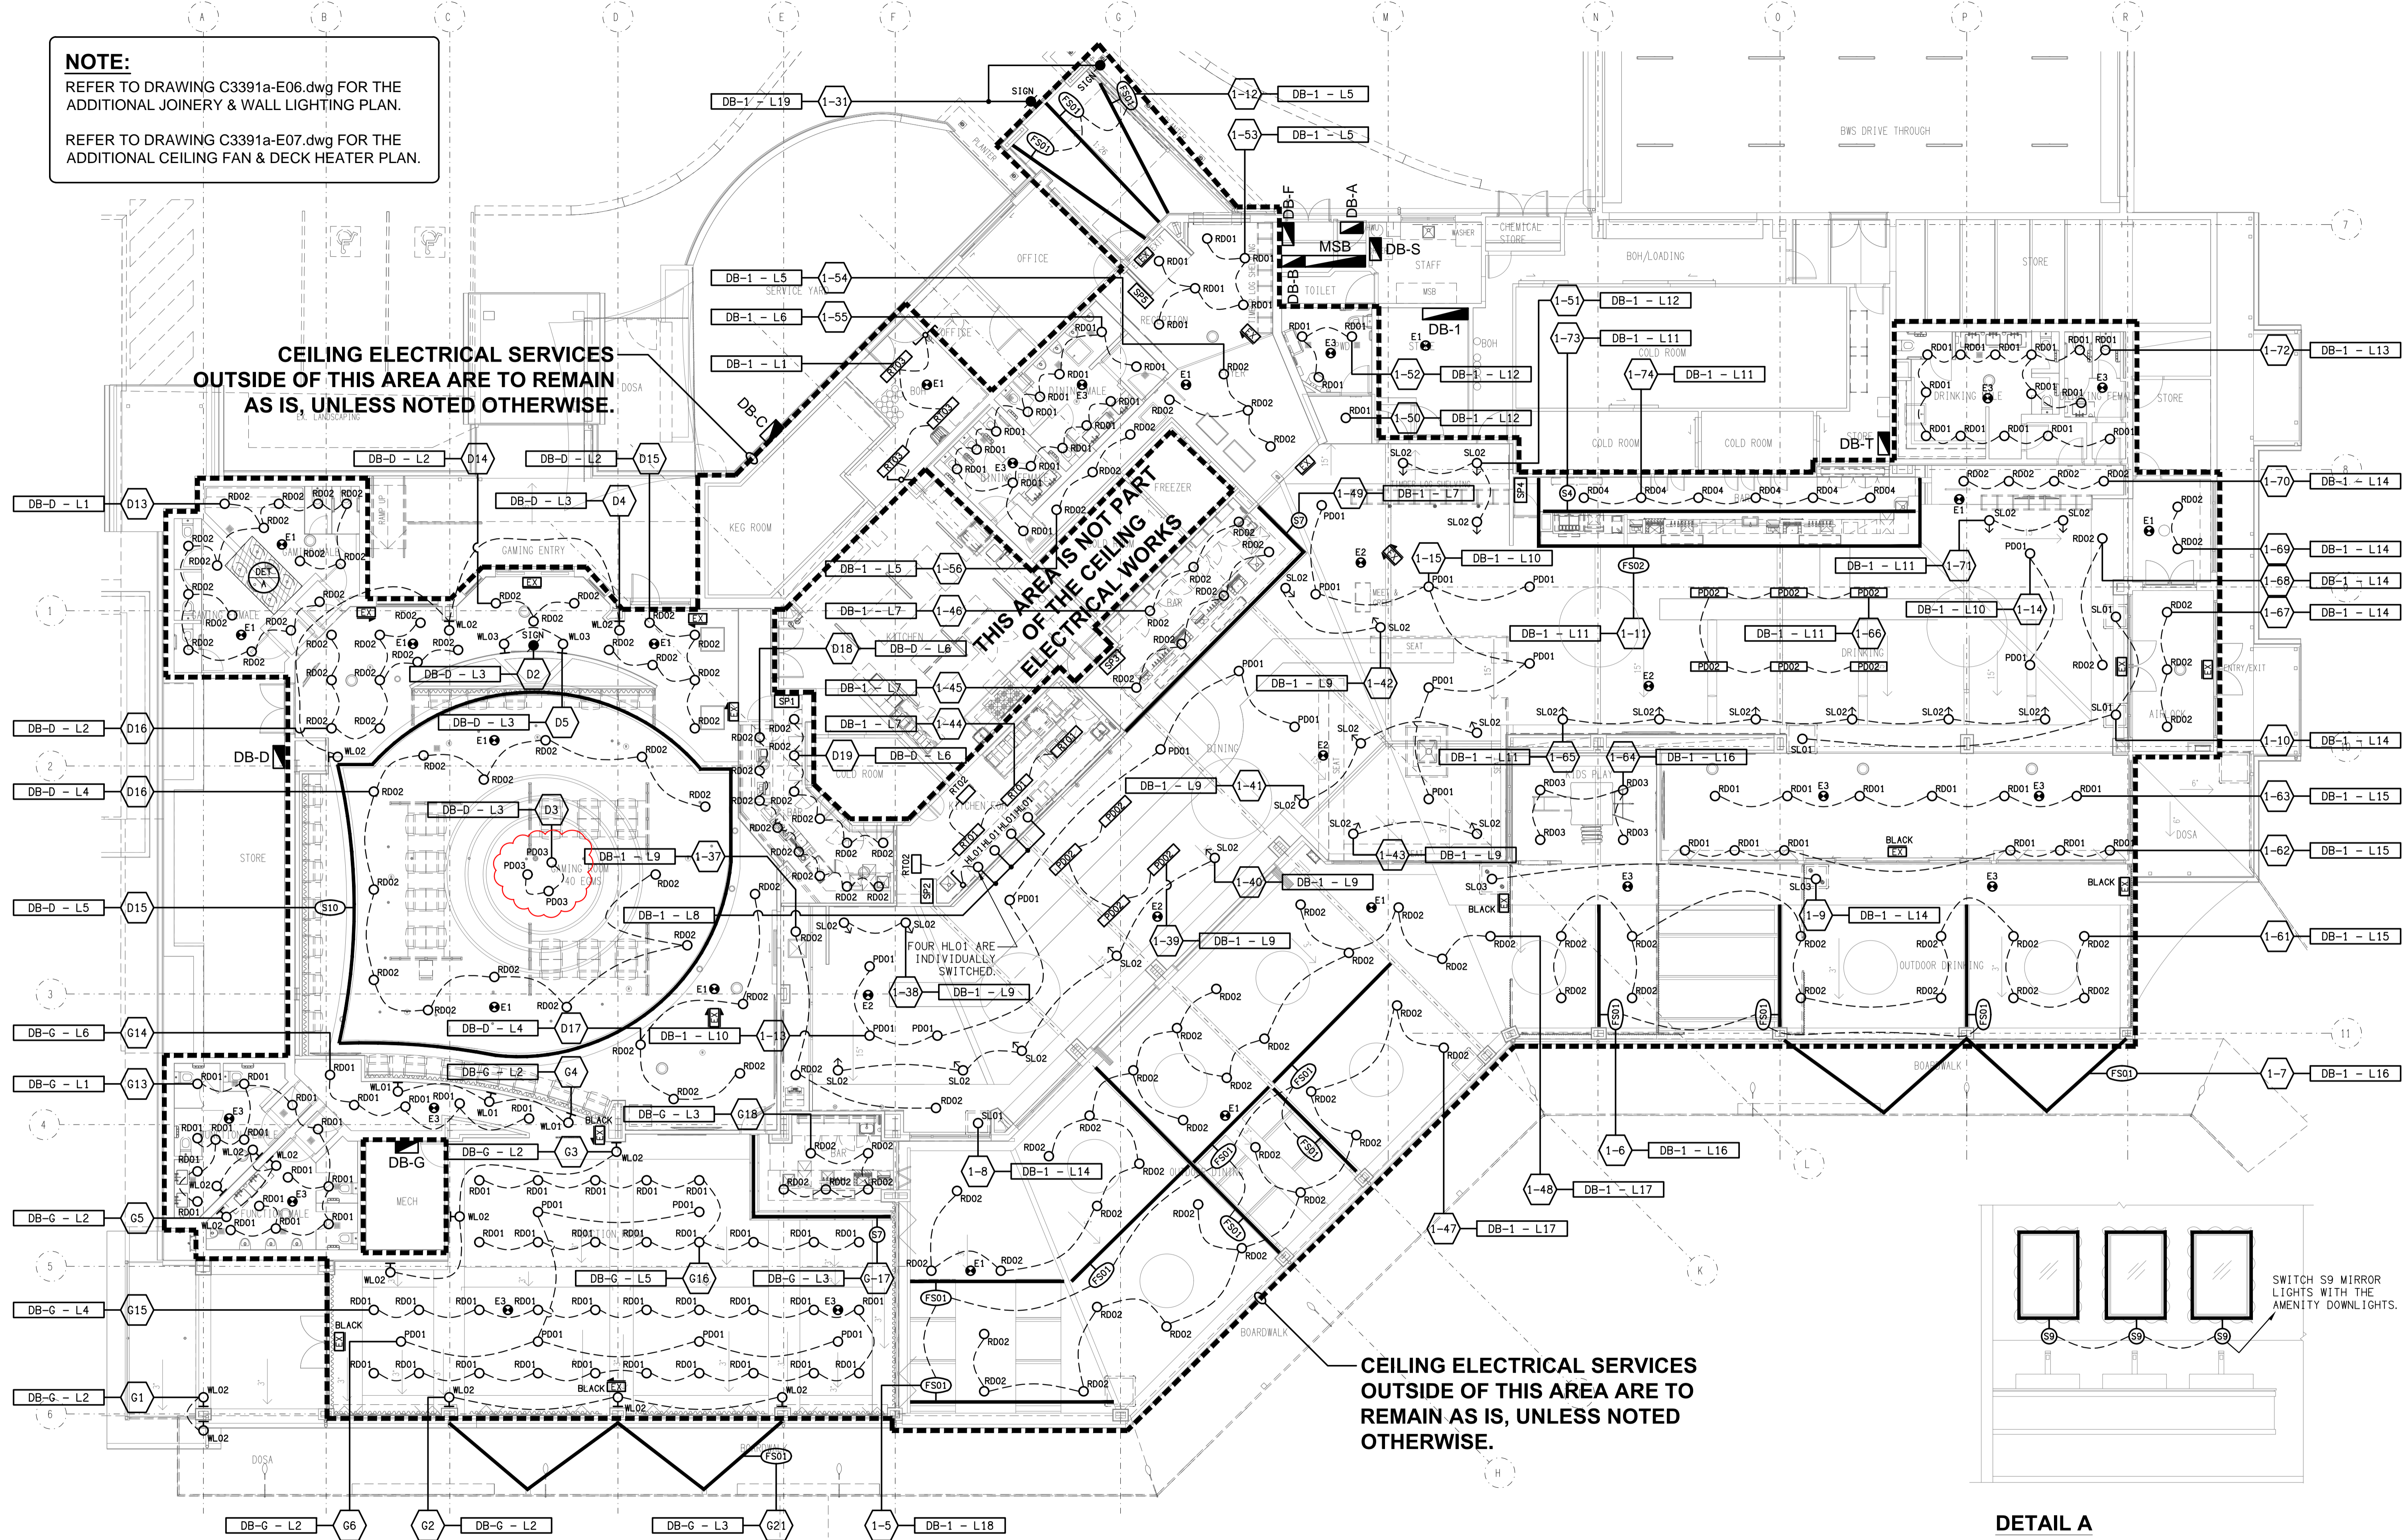

**CEILING ELECTRICAL SERVICES
 OUTSIDE OF THIS AREA ARE TO REMAIN
 AS IS, UNLESS NOTED OTHERWISE.**

**THIS AREA IS NOT PART
 OF THE CEILING
 ELECTRICAL WORKS**

**CEILING ELECTRICAL SERVICES
 OUTSIDE OF THIS AREA ARE TO REMAIN
 AS IS, UNLESS NOTED
 OTHERWISE.**

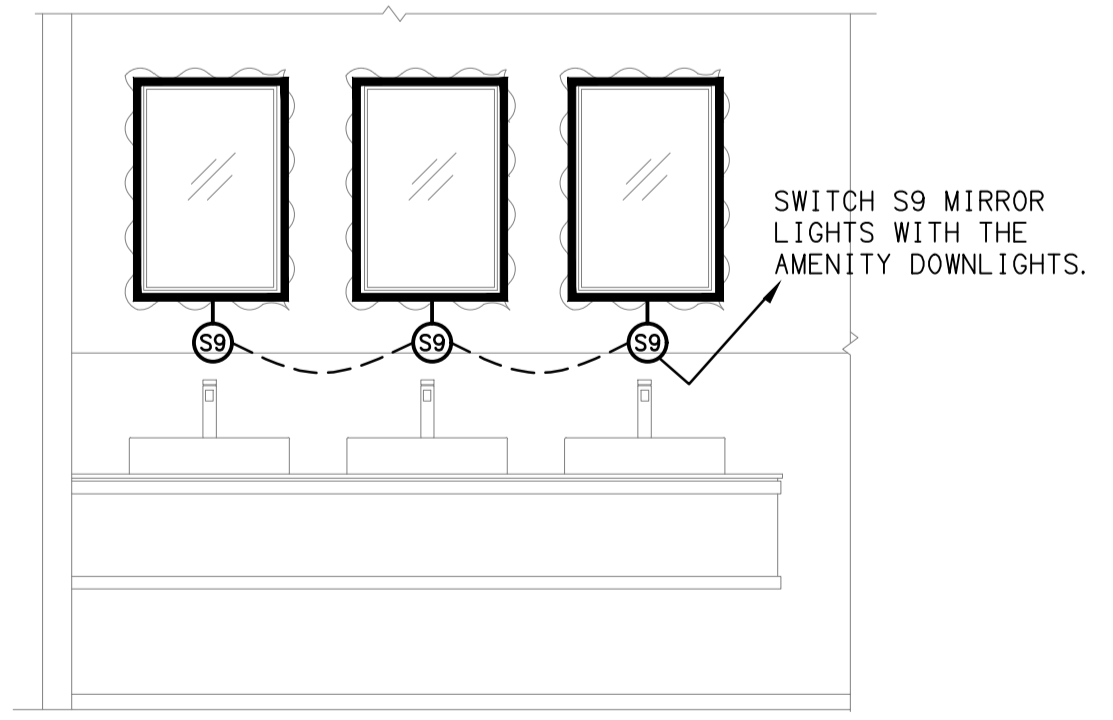

DETAIL A
 TYPICAL GAMING VANITY BENCH ELEVATION
 SCALE 1:25

D	CONSTRUCTION	25/02/2025
REV:	DESCRIPTION:	DATE: