



**JOINERY & WALL LIGHTING**  
PART FLOOR PLAN  
SCALE 1: 100


**DETAIL 0**  
TYPICAL S2 MOUNTING SECTION  
SCALE 1: 20

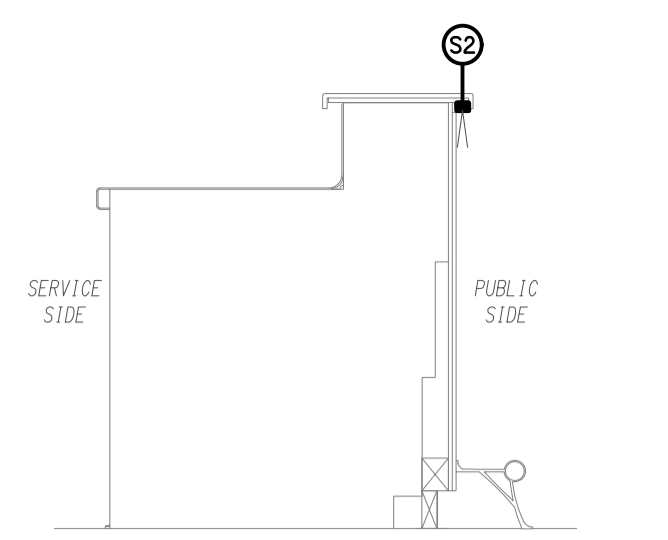


**DETAIL 1**  
DINING BAR REAR WALL ELEVATION  
SCALE 1: 50

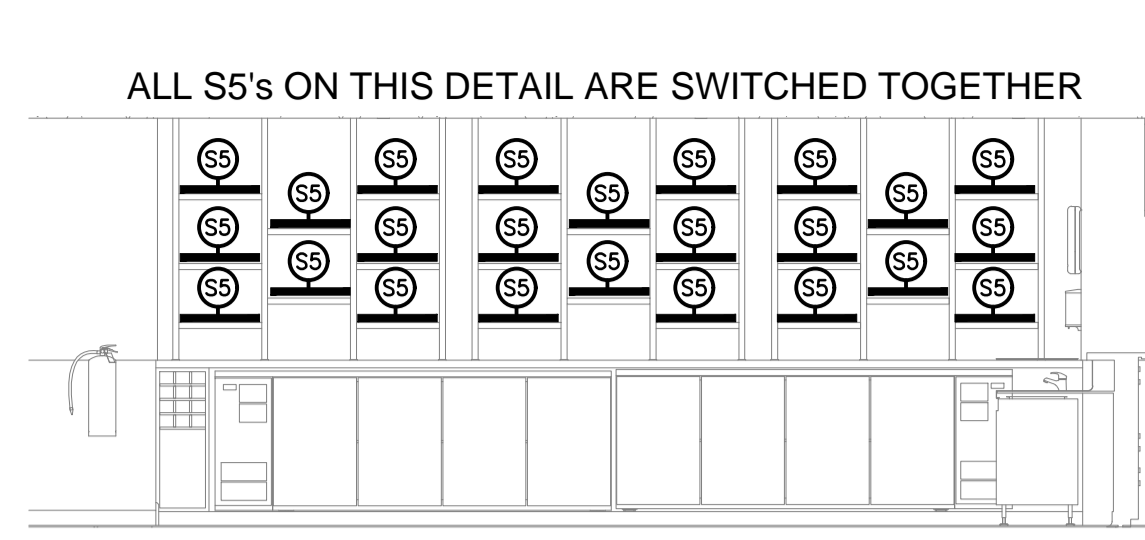


**DETAIL 10**  
TYPICAL WL05 FITTING ELEVATION  
SCALE 1: 50

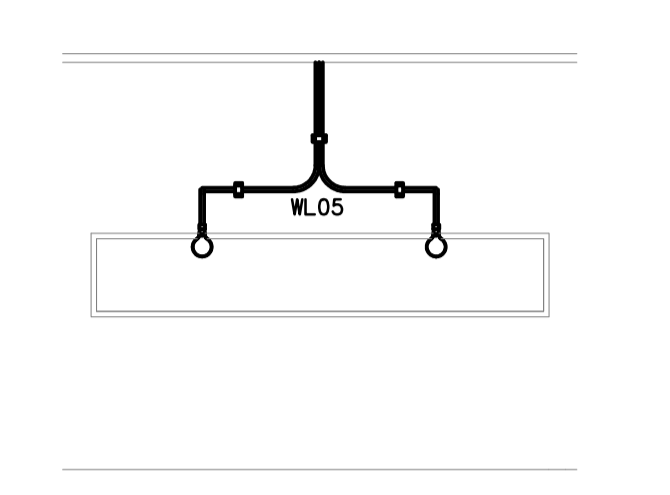


**DETAIL 3**  
FUNCTION BAR REAR WALL ELEVATION  
SCALE 1: 50

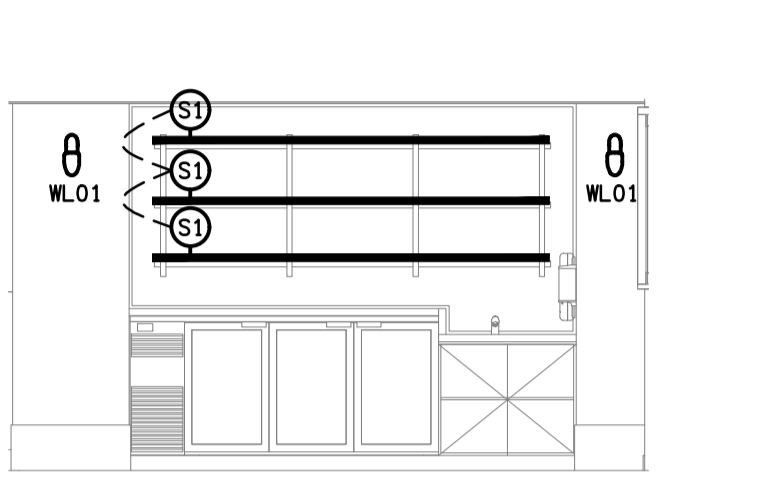


**DETAIL 4 / 5 / 6**  
GAMING BAR REAR WALL ELEVATION  
SCALE 1: 50

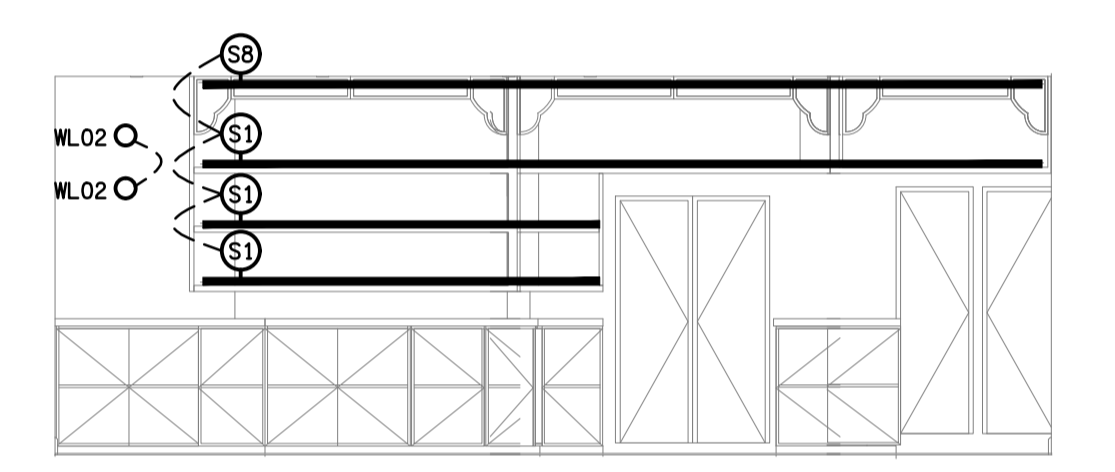


**DETAIL 7**  
DRINKING SHEVING ELEVATION  
SCALE 1: 50

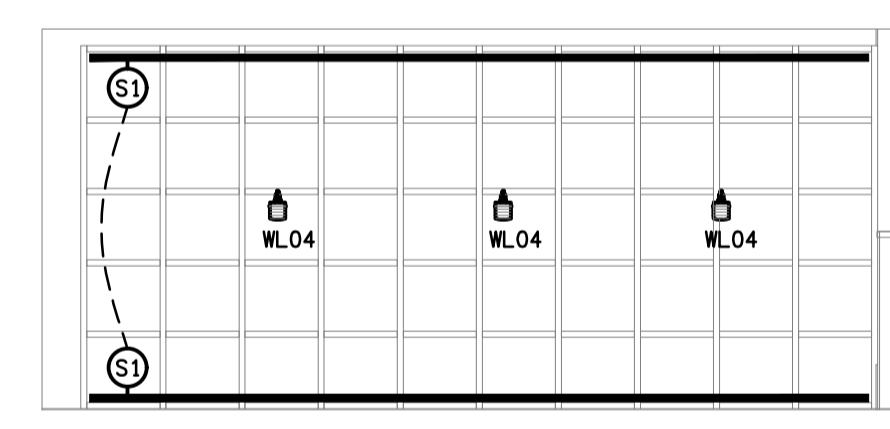


**DETAIL 8**  
DRINKING ENTRY ELEVATION  
SCALE 1: 50

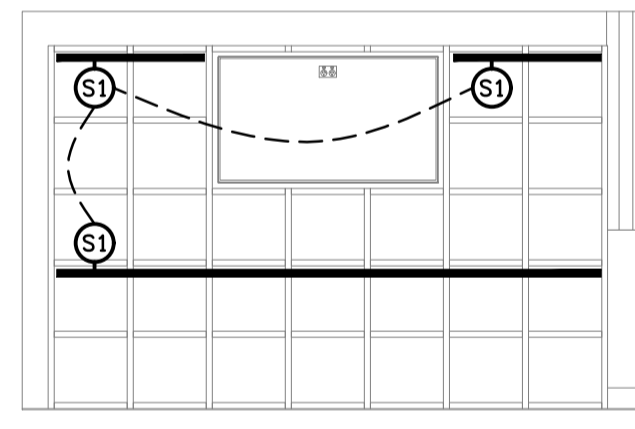

**DETAIL 2**  
DRINKING BAR REAR WALL ELEVATION  
SCALE 1: 50

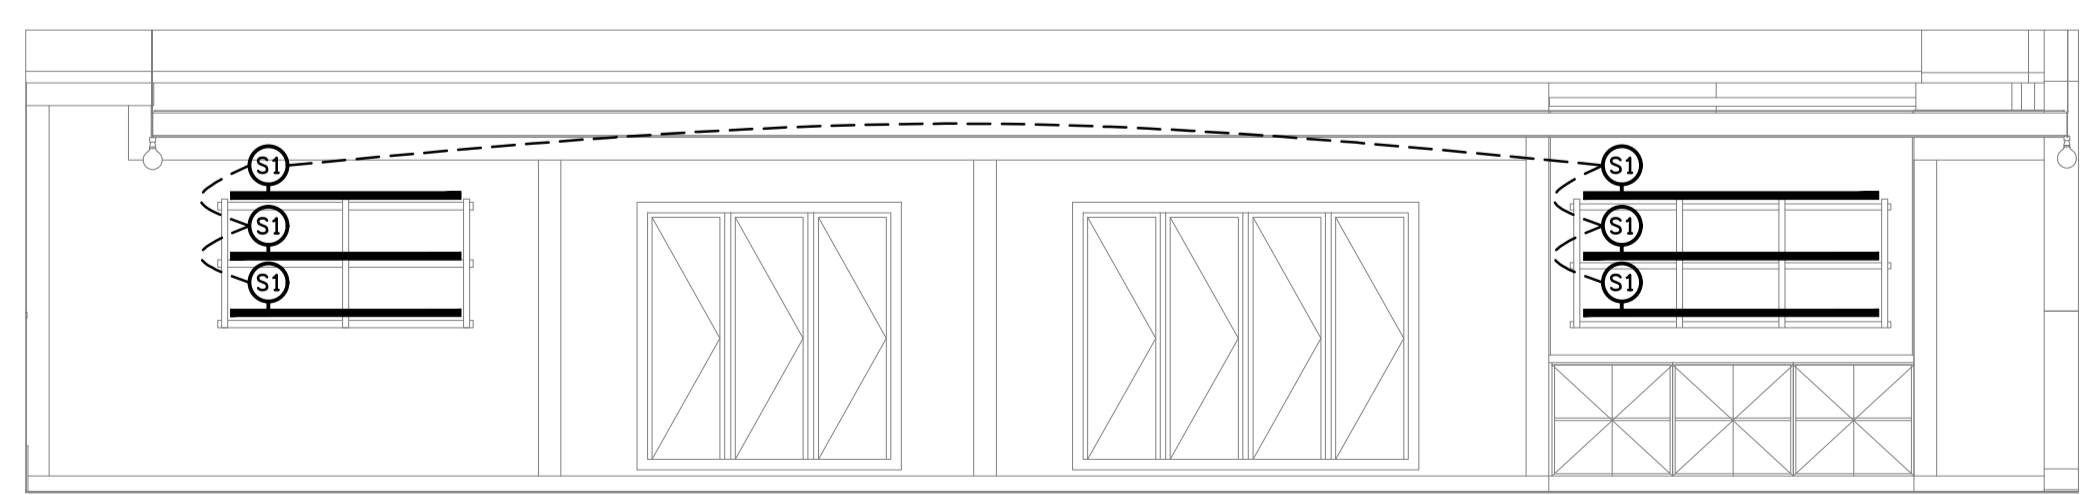

**DETAIL 9**  
MAIN ENTRY SHELVING ELEVATION  
SCALE 1: 50

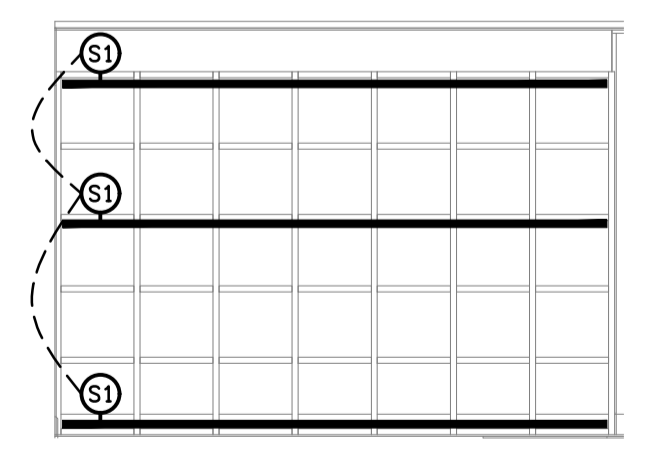

ELECTRICAL DESIGN GROUP BRISBANE  
PTY LTD  
ACN 092 710 793  
TRADING AS:  
ELECTRICAL DESIGN GROUP

THE COPYRIGHT OF THIS DRAWING  
REMAINS THE PROPERTY OF THE  
ELECTRICAL DESIGN GROUP.  
USE FIGURED DIMENSIONS  
IN PREFERENCE TO SCALE.  
ALL DIMENSIONS TO BE  
VERIFIED ONSITE.

**ELECTRICAL DESIGN GROUP**  
ELECTRICAL BUILDING SERVICES CONSULTANTS  
BRISBANE GOLD COAST

P.O. Box 15, Sherwood Q.4075  
Phone: (07) 3278 4375  
Email: brisbane@edg.net.au  
Web: www.edg.net.au

PROJECT:  
**WATERFRONT HOTEL, DIDDILLIBAH**

2 / 46 DAVID LOW WAY, DIDDILLIBAH, SUNSHINE COAST

B	TENDER	22/11/2024
REV.	DESCRIPTION:	DATE:

DRAWING:  
**ELECTRICAL SERVICES**  
**JOINERY & WALL LIGHTING PLANS**

SCALE: 1:100 & 1:50	AT A1	PROJECT NO: <b>C3391a</b>	DRAWING NO: <b>E06</b>	REVISION: <b>B</b>
------------------------	-------	------------------------------	---------------------------	-----------------------