



JOINERY & WALL LIGHTING
PART FLOOR PLAN
SCALE 1: 100


DETAIL 0
TYPICAL S2 MOUNTING SECTION
SCALE 1: 20

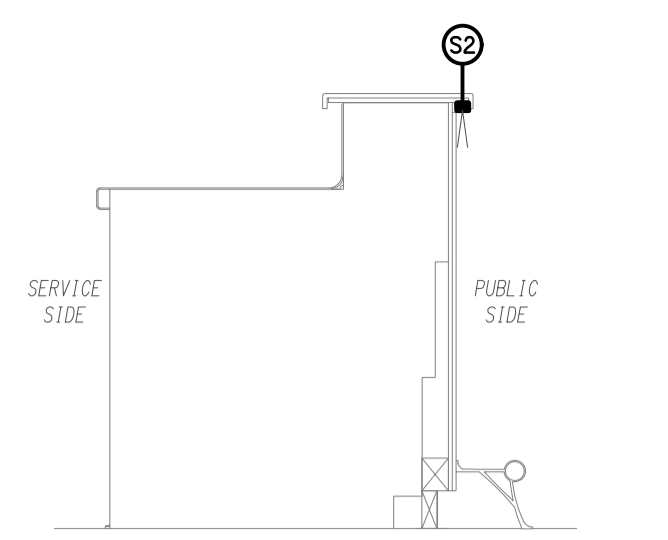


DETAIL 1
DINING BAR REAR WALL ELEVATION
SCALE 1: 50

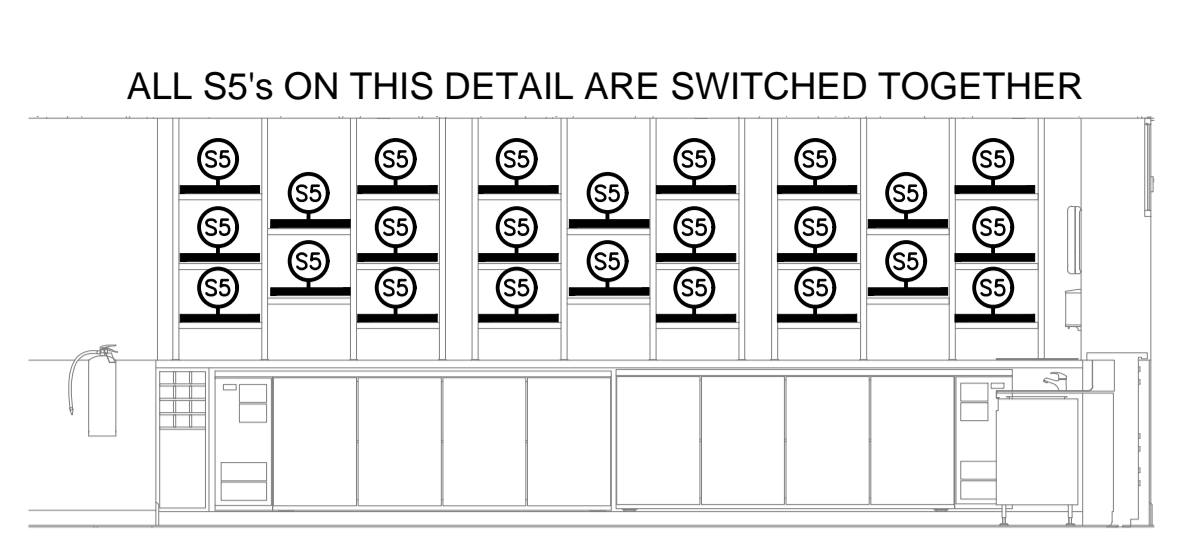


DETAIL 10
TYPICAL WL05 FITTING ELEVATION
SCALE 1: 50

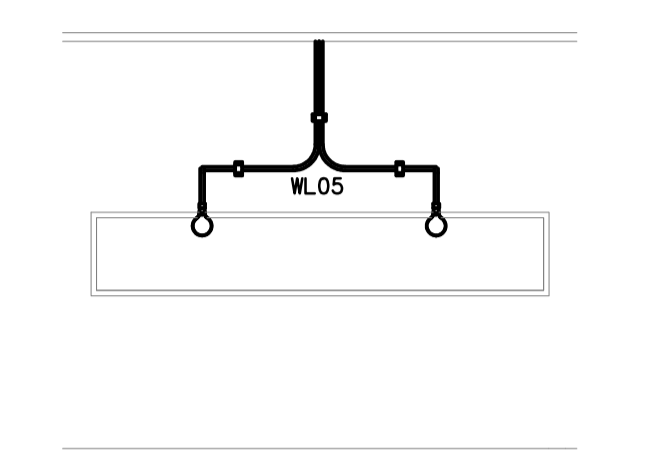


DETAIL 3
FUNCTION BAR REAR WALL ELEVATION
SCALE 1: 50

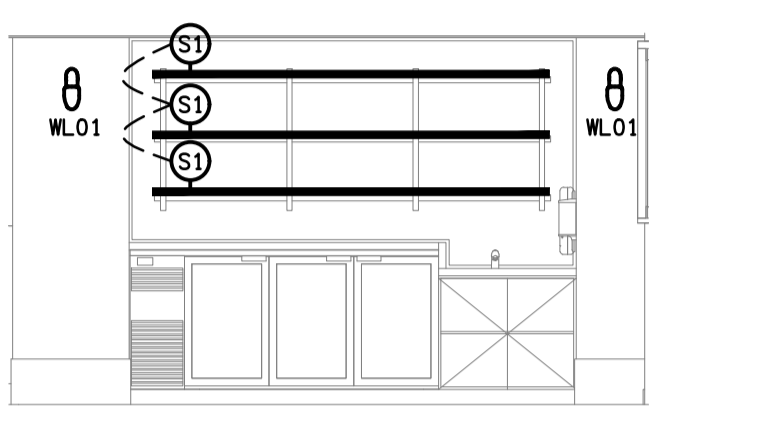


DETAIL 4 / 5 / 6
GAMING BAR REAR WALL ELEVATION
SCALE 1: 50

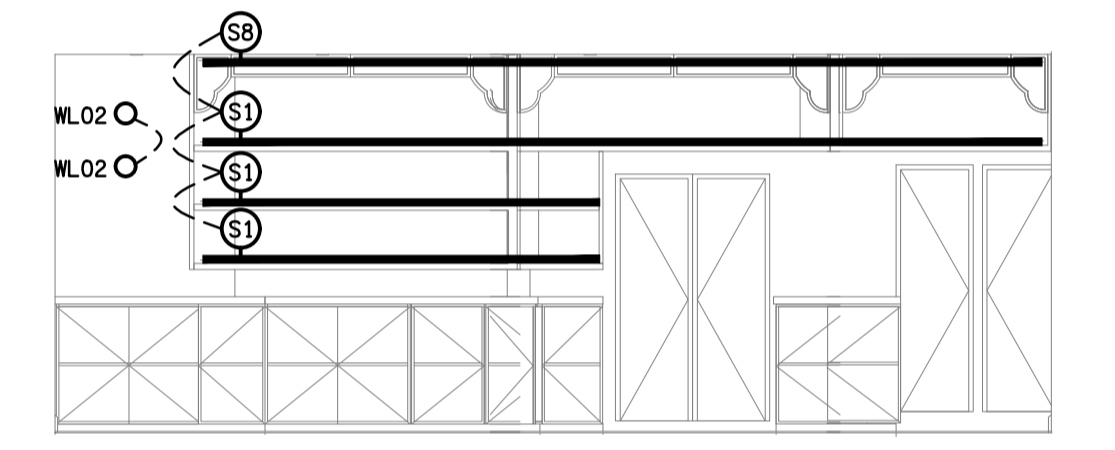


DETAIL 7
DRINKING SHEVING ELEVATION
SCALE 1: 50

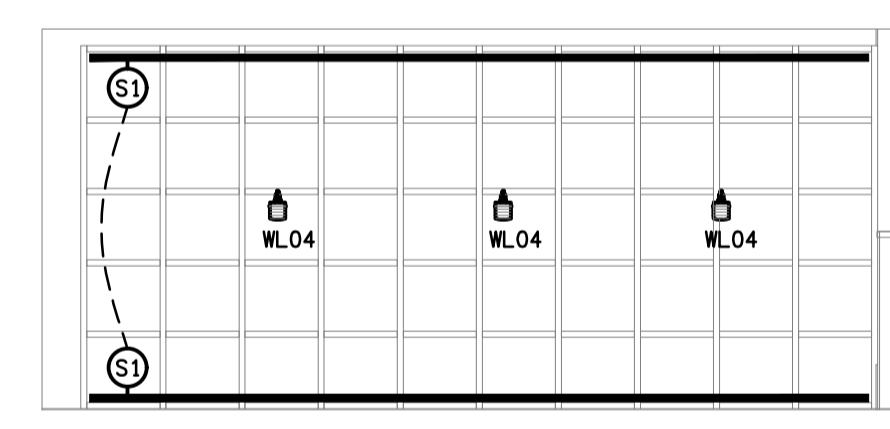


DETAIL 8
DRINKING ENTRY ELEVATION
SCALE 1: 50

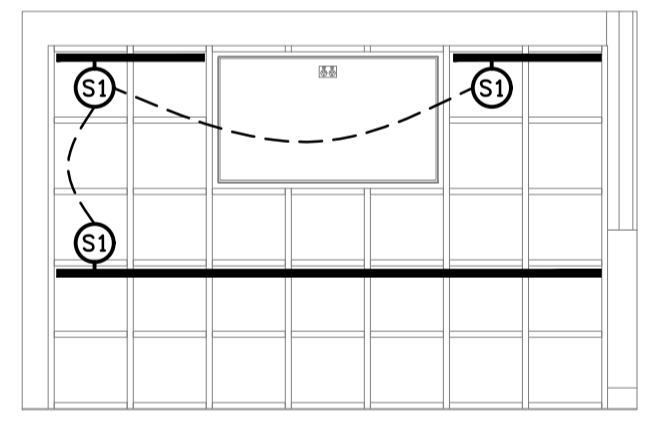

DETAIL 2
DRINKING BAR REAR WALL ELEVATION
SCALE 1: 50

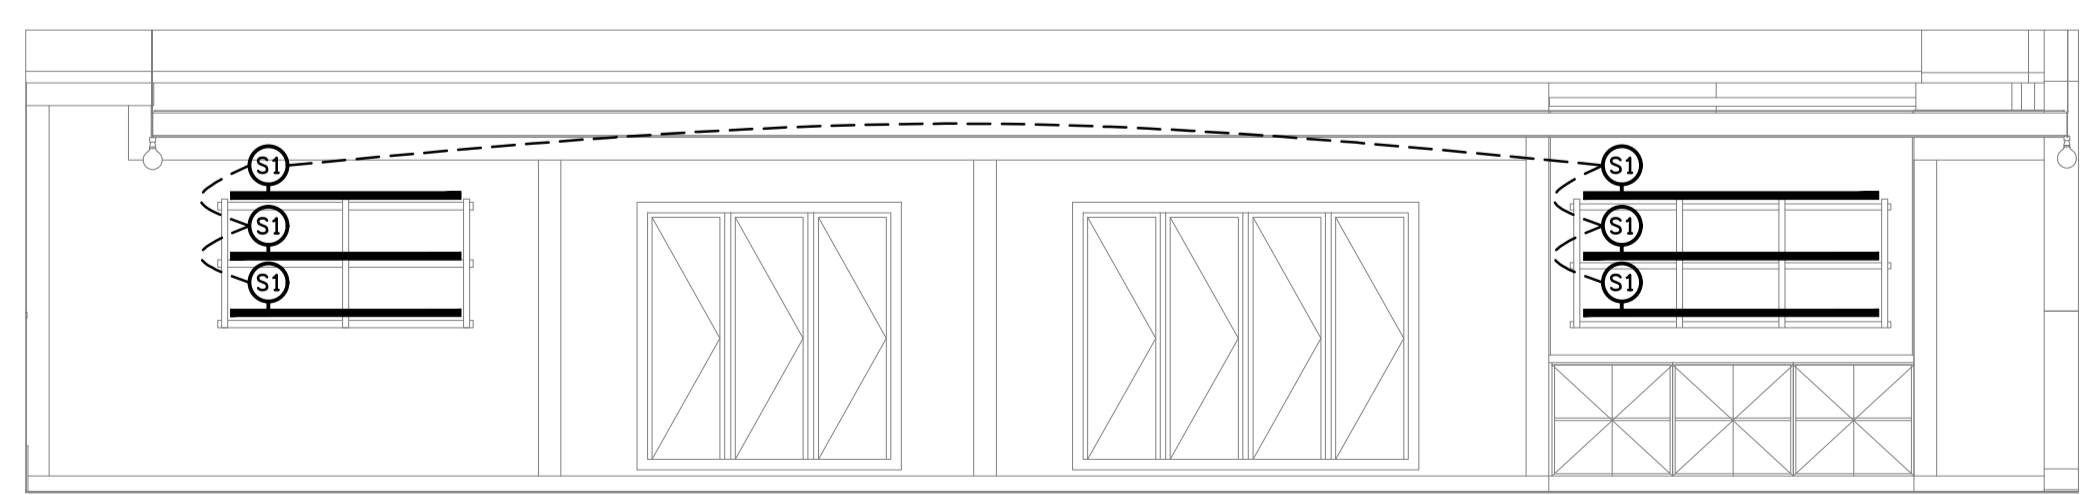

DETAIL 9
MAIN ENTRY SHELVING ELEVATION
SCALE 1: 50

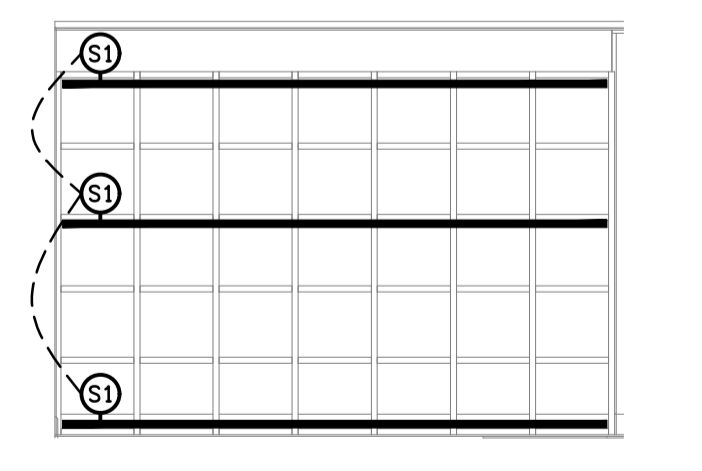

ELECTRICAL DESIGN GROUP BRISBANE
PTY LTD
ACN 092 710 793
TRADING AS:
ELECTRICAL DESIGN GROUP

THE COPYRIGHT OF THIS DRAWING
REMAINS THE PROPERTY OF THE
ELECTRICAL DESIGN GROUP.
USE FIGURED DIMENSIONS
IN PREFERENCE TO SCALE.
ALL DIMENSIONS TO BE
VERIFIED ONSITE.

ELECTRICAL DESIGN GROUP
ELECTRICAL BUILDING SERVICES CONSULTANTS
BRISBANE GOLD COAST

P.O. Box 15, Sherwood Q.4075
Phone: (07) 3278 4375
Email: brisbane@edg.net.au
Web: www.edg.net.au

PROJECT:
WATERFRONT HOTEL, DIDDILLIBAH
2 / 46 DAVID LOW WAY, DIDDILLIBAH, SUNSHINE COAST

| | | |
|------|--------------|------------|
| D | CONSTRUCTION | 28/02/2025 |
| REV. | DESCRIPTION: | DATE: |

DRAWING:
ELECTRICAL SERVICES
JOINERY & WALL LIGHTING PLANS

| | | | | |
|------------------------|-------|------------------------------|---------------------------|-----------------------|
| SCALE: 1:100 & 1:50 | AT A1 | PROJECT NO: C3391a | DRAWING NO: E06 | REVISION: D |
|------------------------|-------|------------------------------|---------------------------|-----------------------|