



DETAIL A
CUSTOMER KITCHENETTE ELEVATION
SCALE 1:25

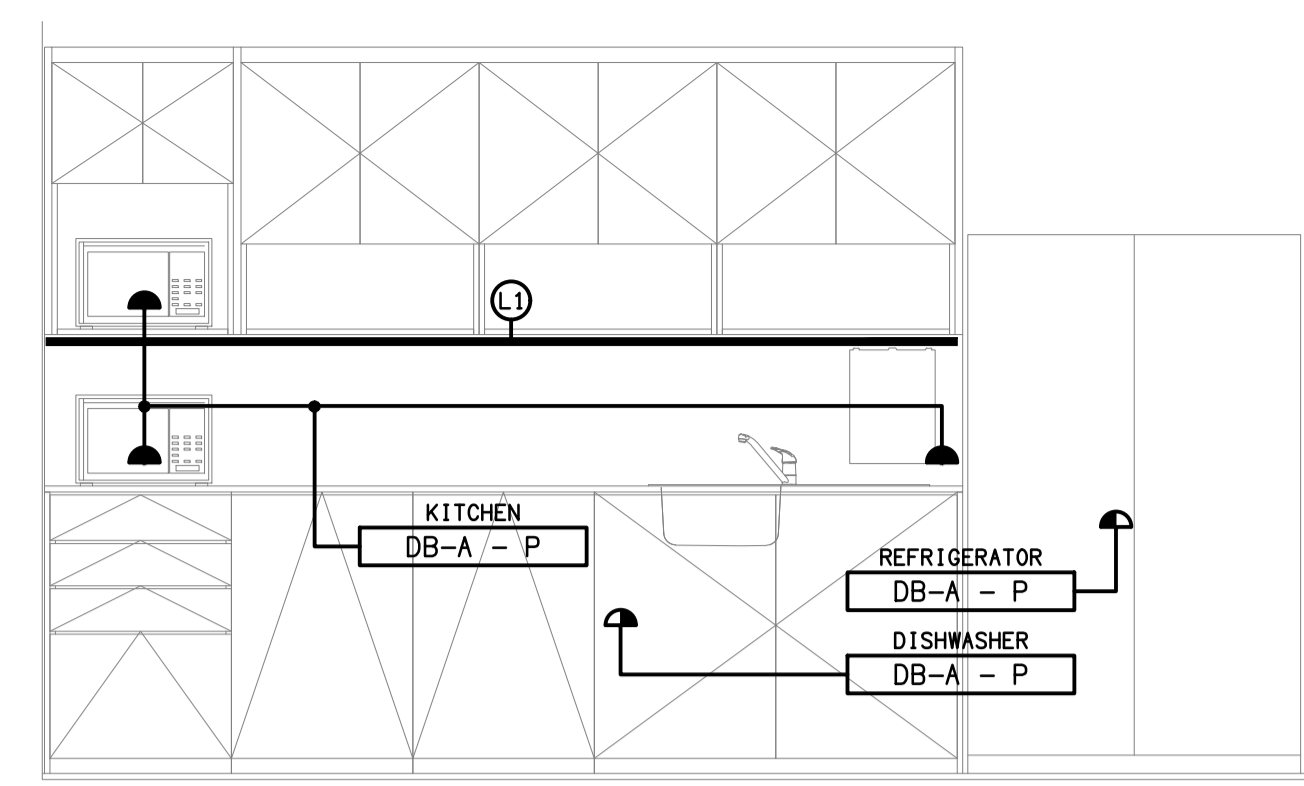

DETAIL B
LUNCH ROOM KITCHENETTE
SCALE 1:25

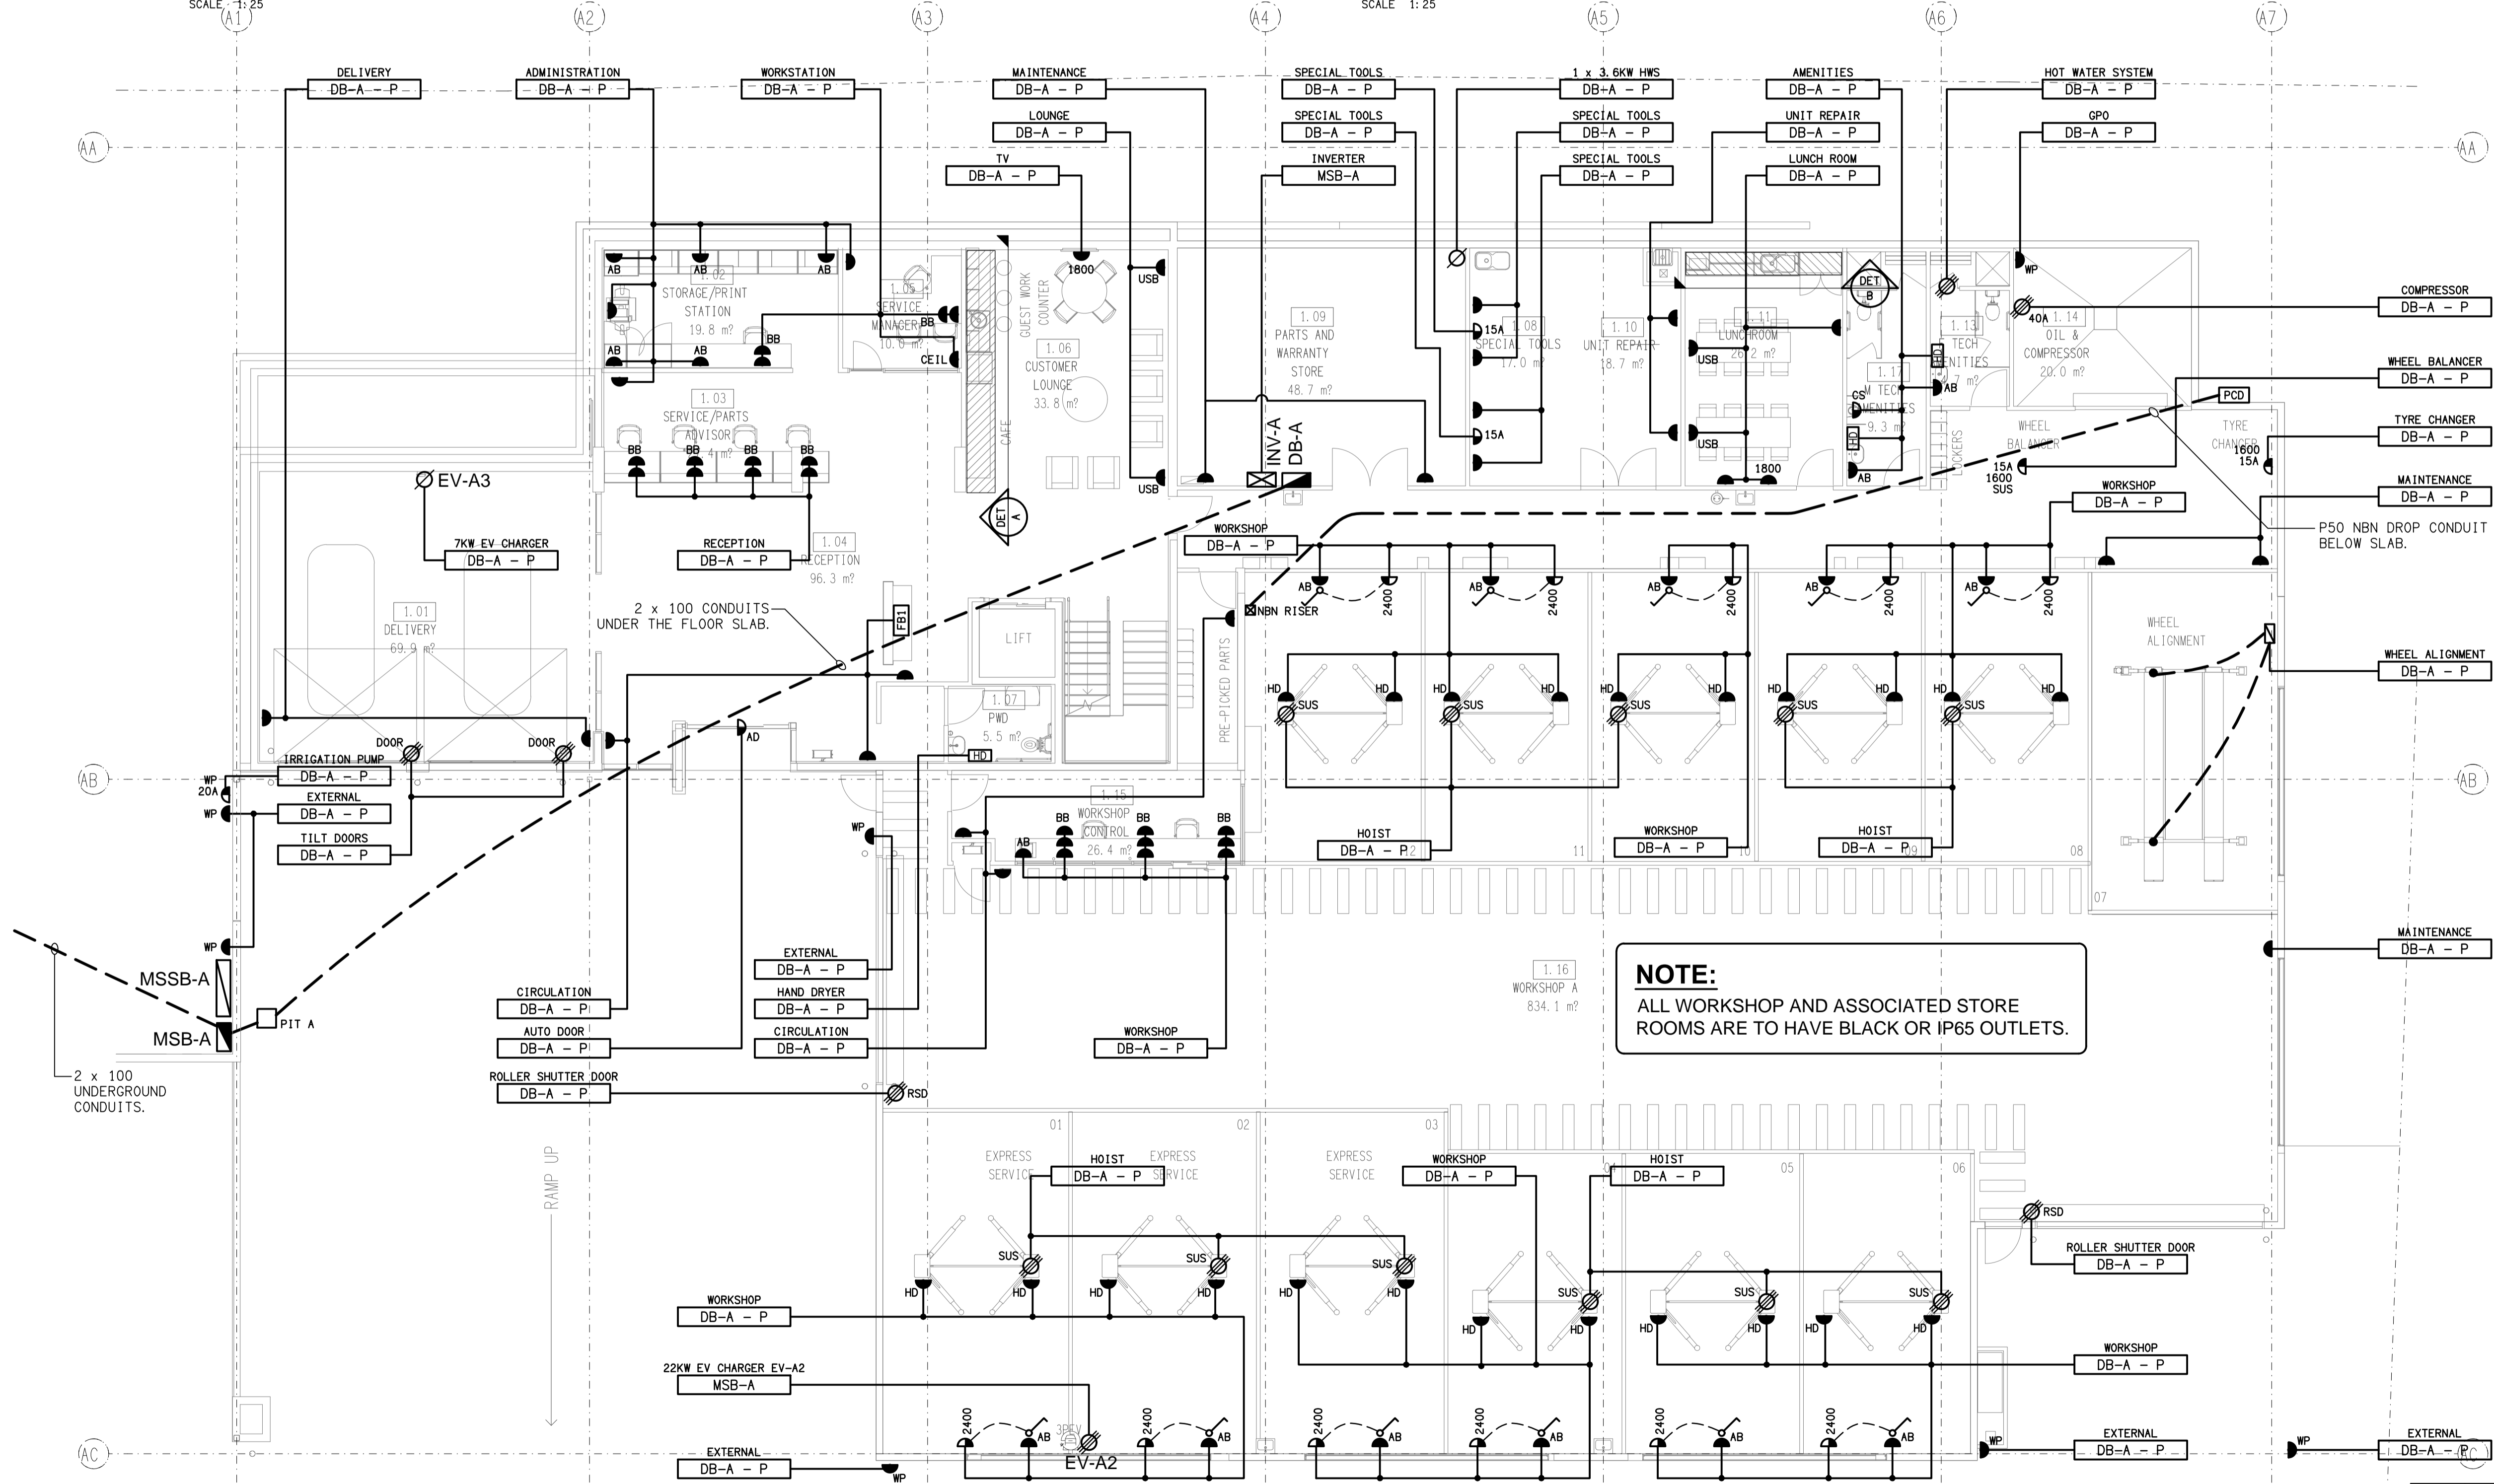

NOTE:
ALL WORKSHOP AND ASSOCIATED STORE ROOMS ARE TO HAVE BLACK OR IP65 OUTLETS.

ELECTRICAL DESIGN GROUP BRISBANE PTY LTD
ACN 092 710 793
TRADING AS:
ELECTRICAL DESIGN GROUP

THE COPYRIGHT OF THIS DRAWING REMAINS THE PROPERTY OF THE ELECTRICAL DESIGN GROUP.
USE FIGURED DIMENSIONS IN PREFERENCE TO SCALE.
ALL DIMENSIONS TO BE VERIFIED ONSITE.



Rohrig (Qld) Pty Ltd
ABN 67 093 753 970
QBSA LIC NO 740842
250 Abbotsford Road, Bowen Hills Qld 4006
PO Box 86 Albion DC Qld 4010
T+61 (7) 3257 4411 F+61 (7) 3257 2211
www.rohrig.com.au

ELECTRICAL DESIGN GROUP
ELECTRICAL BUILDING SERVICES CONSULTANTS
BRISBANE GOLD COAST
P.O. Box 15, Sherwood Q. 4075
Phone: (07) 3278 4375
Email: brisbane@edg.net.au
Web: www.edg.net.au

PROJECT:
LLEWELLYN MOTORS SPRINGFIELD - LOT 34
LOT 34 AUGUSTA PARKWAY, AUGUSTINE HEIGHTS

D	80% DEVELOPED	24/02/2025
REV:	DESCRIPTION:	DATE:
DRAWING: ELECTRICAL SERVICES LOWER GROUND LEVEL FLOOR PLAN		
SCALE: 1:100 UNO	AT A1	PROJECT NO: C3396a
		DRAWING NO: E04
		REVISION: D