




REFLECTED CEILING PLAN
GROUND LEVEL
SCALE 1:100

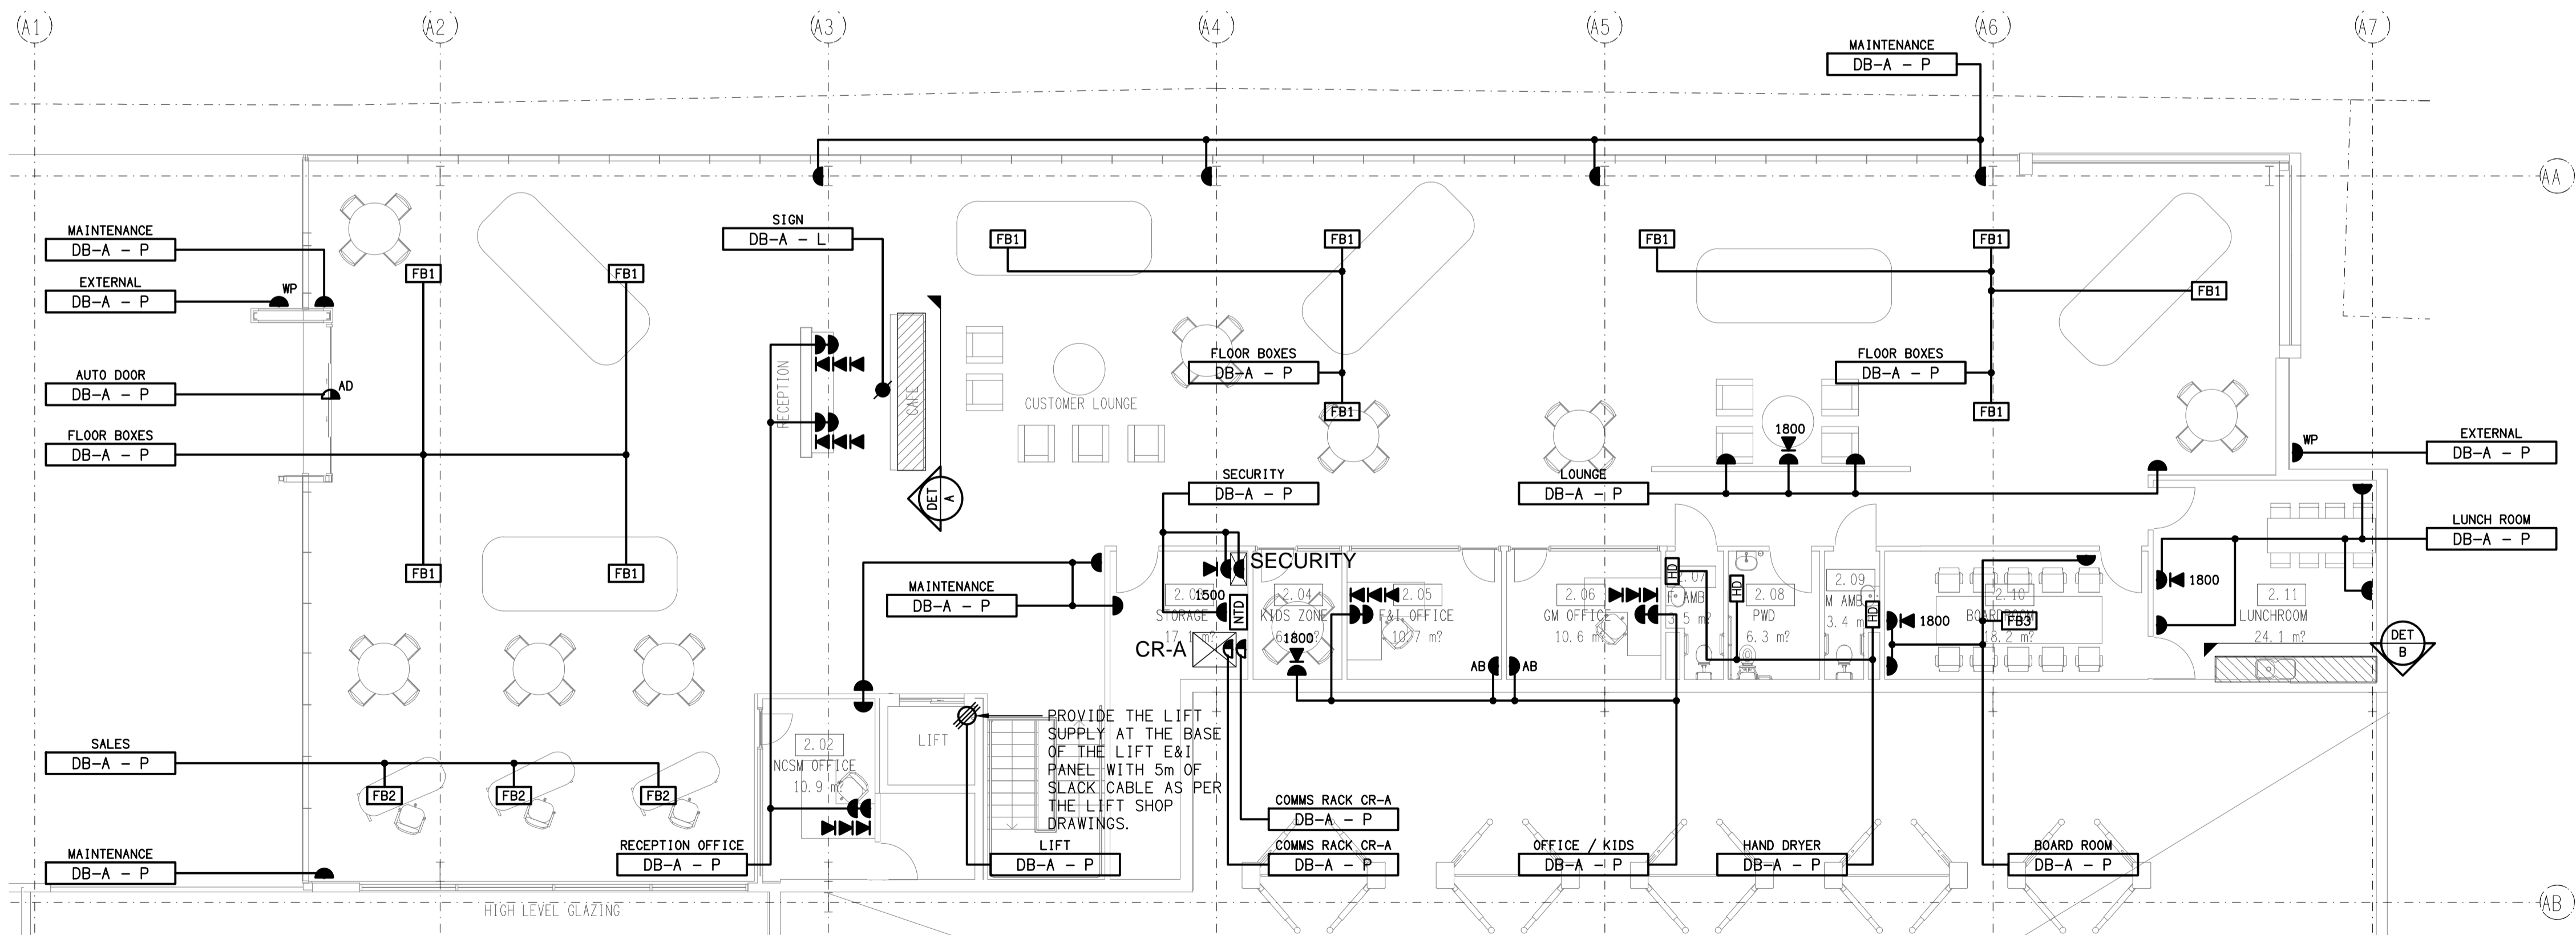

FLOOR PLAN
GROUND LEVEL
SCALE 1:100

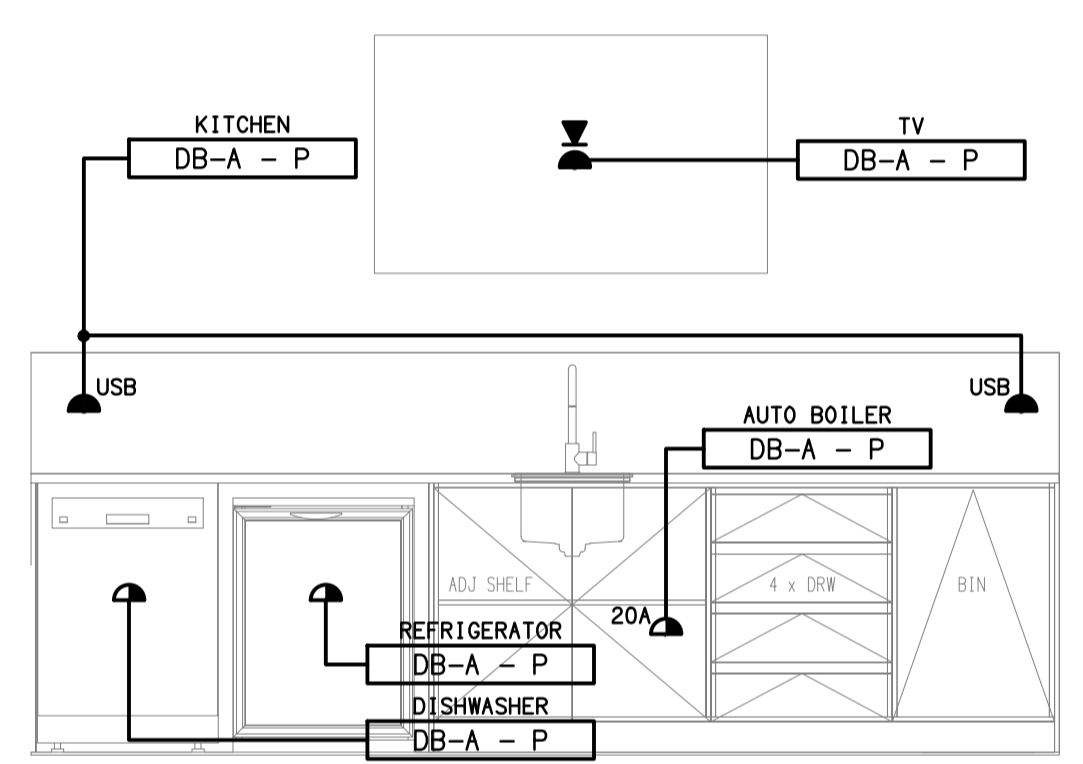

DETAIL A
CUSTOMER CAFE KITCHENETTE
SCALE 1:25

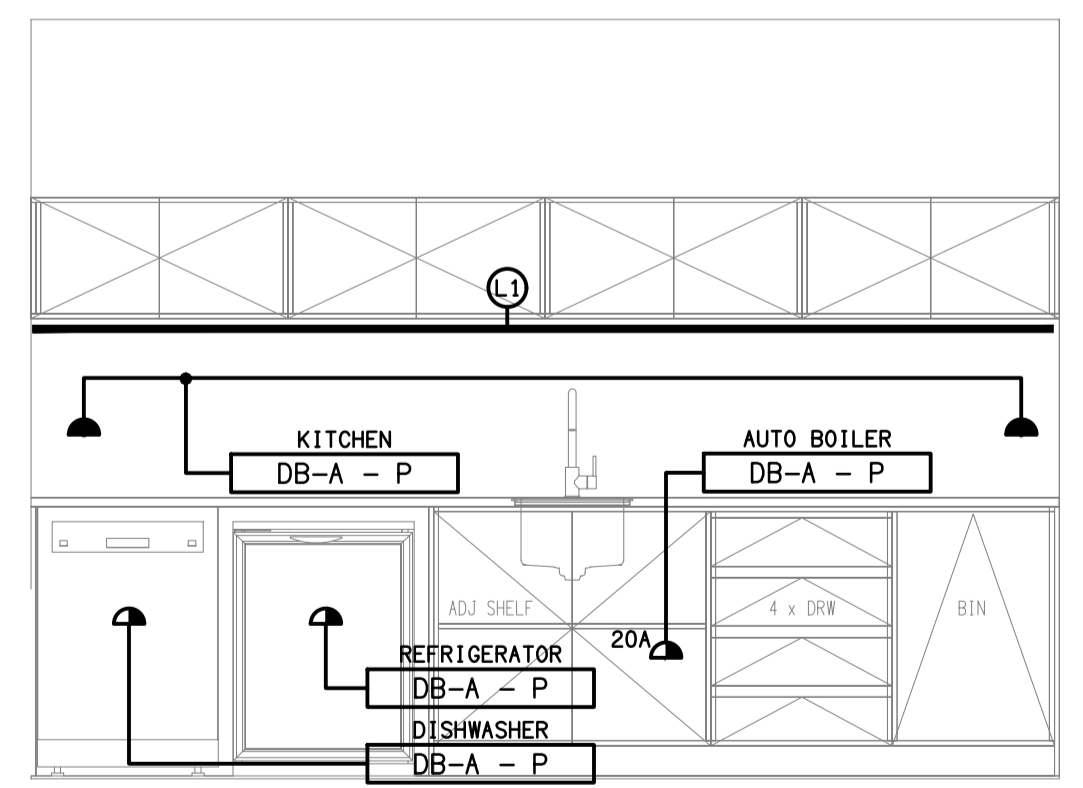

DETAIL B
LUNCH ROOM KITCHENETTE
SCALE 1:25

<p>ELECTRICAL DESIGN GROUP BRISBANE PTY LTD ACN 092 710 793 TRADING AS: ELECTRICAL DESIGN GROUP</p>	<p>THE COPYRIGHT OF THIS DRAWING REMAINS THE PROPERTY OF THE ELECTRICAL DESIGN GROUP. USE FIGURED DIMENSIONS IN PREFERENCE TO SCALE. ALL DIMENSIONS TO BE VERIFIED ONSITE.</p>	<p>rohrig constructions Rohrig (Qld) Pty Ltd ABN 67 093 753 970 QBSA LIC NO 740842 250 Abbotsford Road, Bowen Hills Qld 4006 PO Box 86 Albion DC Qld 4010 T+61 (7) 3257 4411 F+61 (7) 3257 2211 www.rohrig.com.au</p>	<p>ELECTRICAL DESIGN GROUP ELECTRICAL BUILDING SERVICES CONSULTANTS BRISBANE GOLD COAST P.O. Box 15, Sherwood Q.4075 Phone: (07) 3278 4375 Email: brisbane@edg.net.au Web: www.edg.net.au</p>	<p>PROJECT: LLEWELLYN MOTORS SPRINGFIELD - LOT 34 LOT 34 AUGUSTA PARKWAY, AUGUSTINE HEIGHTS</p>	<table border="1"> <tr> <td>B</td> <td>50% DEVELOPED</td> <td>28/11/2024</td> </tr> <tr> <td>REV:</td> <td>DESCRIPTION:</td> <td>DATE:</td> </tr> <tr> <td colspan="3">DRAWING: ELECTRICAL SERVICES GROUND LEVEL FLOOR & REFLECTED CEILING PLAN</td> </tr> <tr> <td>SCALE: 1:100 UNO</td> <td>PROJECT NO: AT A1 C3396a</td> <td>DRAWING NO: E06</td> </tr> <tr> <td></td> <td></td> <td>REVISION: B</td> </tr> </table>	B	50% DEVELOPED	28/11/2024	REV:	DESCRIPTION:	DATE:	DRAWING: ELECTRICAL SERVICES GROUND LEVEL FLOOR & REFLECTED CEILING PLAN			SCALE: 1:100 UNO	PROJECT NO: AT A1 C3396a	DRAWING NO: E06			REVISION: B
B	50% DEVELOPED	28/11/2024																		
REV:	DESCRIPTION:	DATE:																		
DRAWING: ELECTRICAL SERVICES GROUND LEVEL FLOOR & REFLECTED CEILING PLAN																				
SCALE: 1:100 UNO	PROJECT NO: AT A1 C3396a	DRAWING NO: E06																		
		REVISION: B																		