




ROOF LEVEL
FLOOR PLAN
SCALE 1: 200

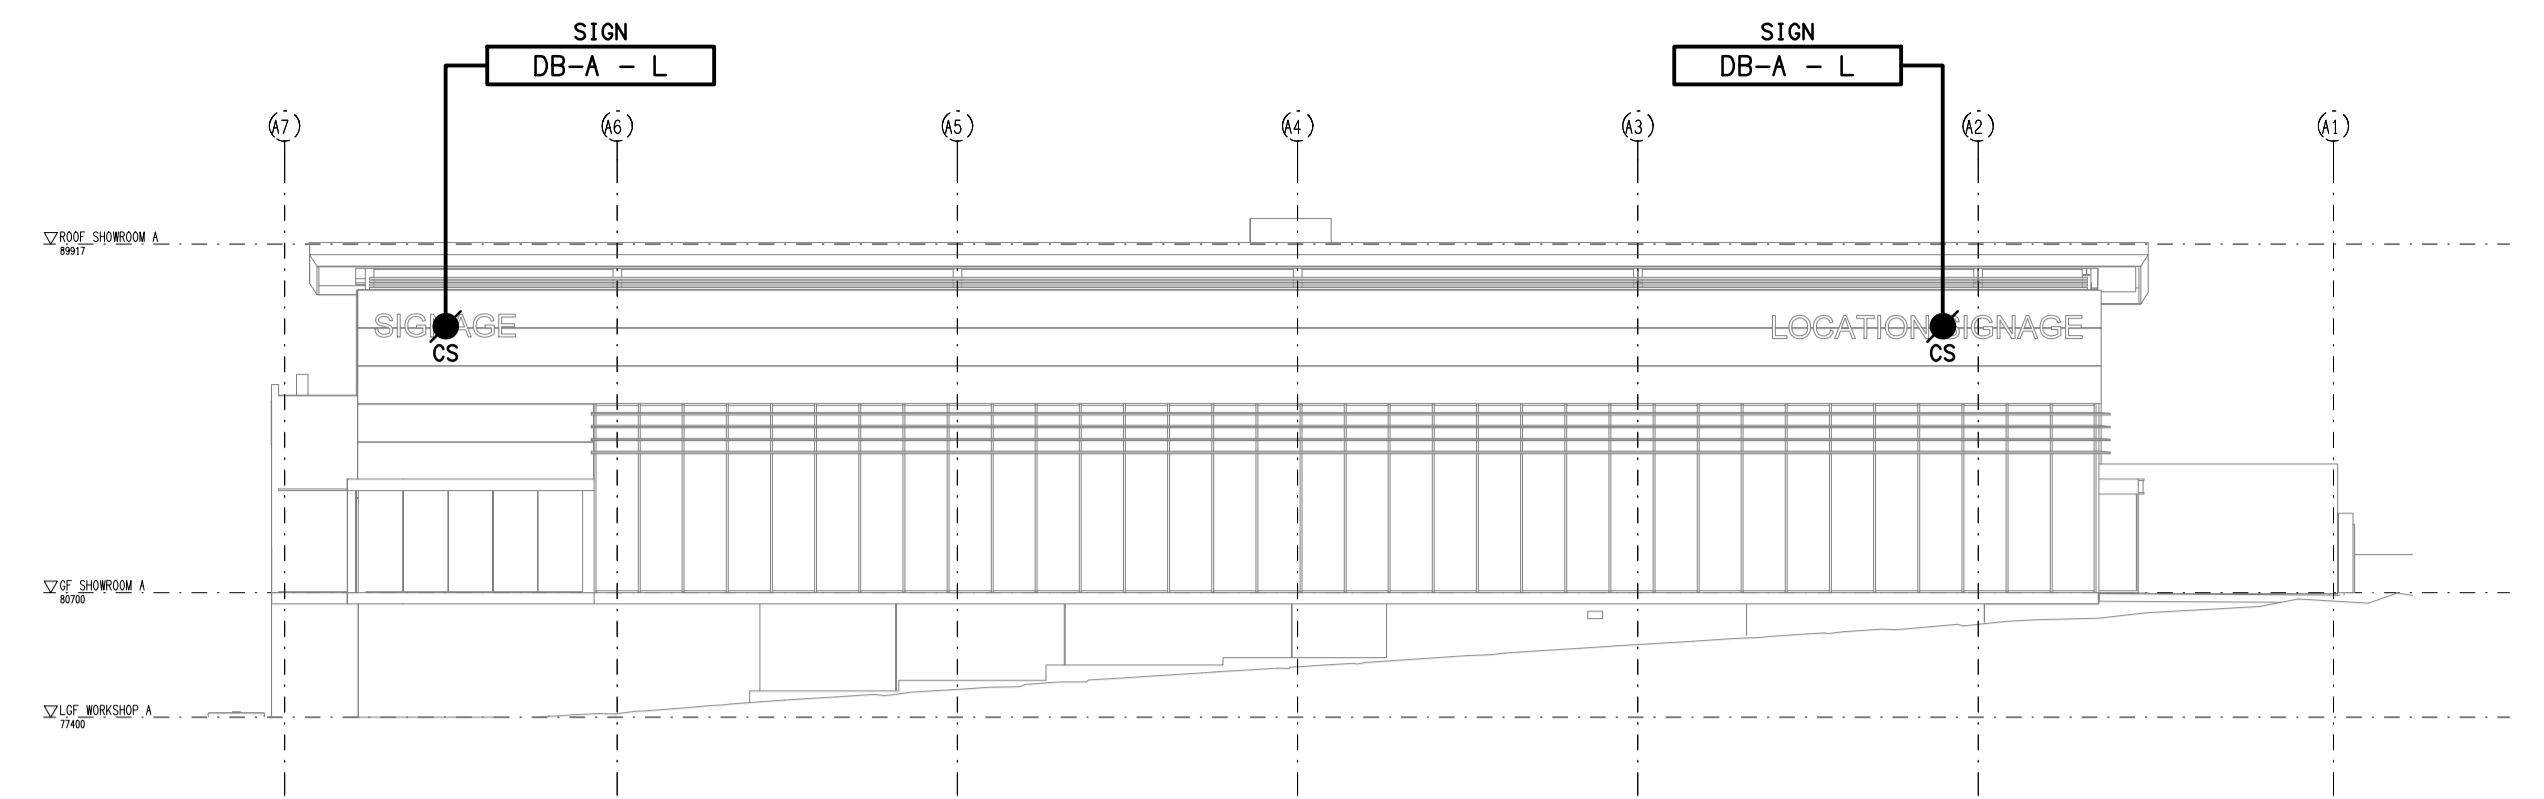


NORTHERN ELEVATION

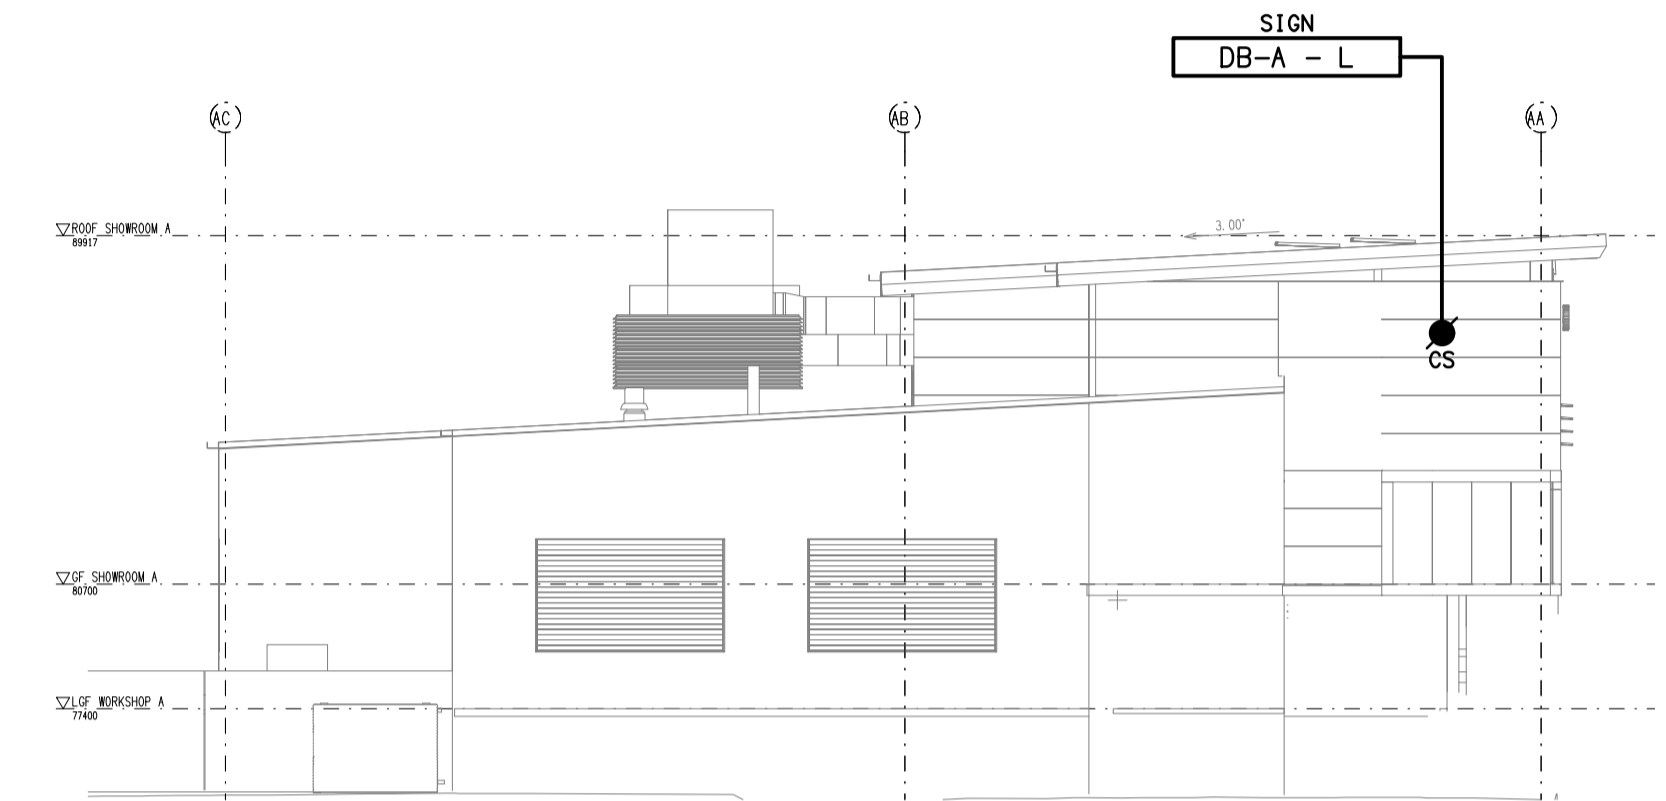

EASTERN ELEVATION

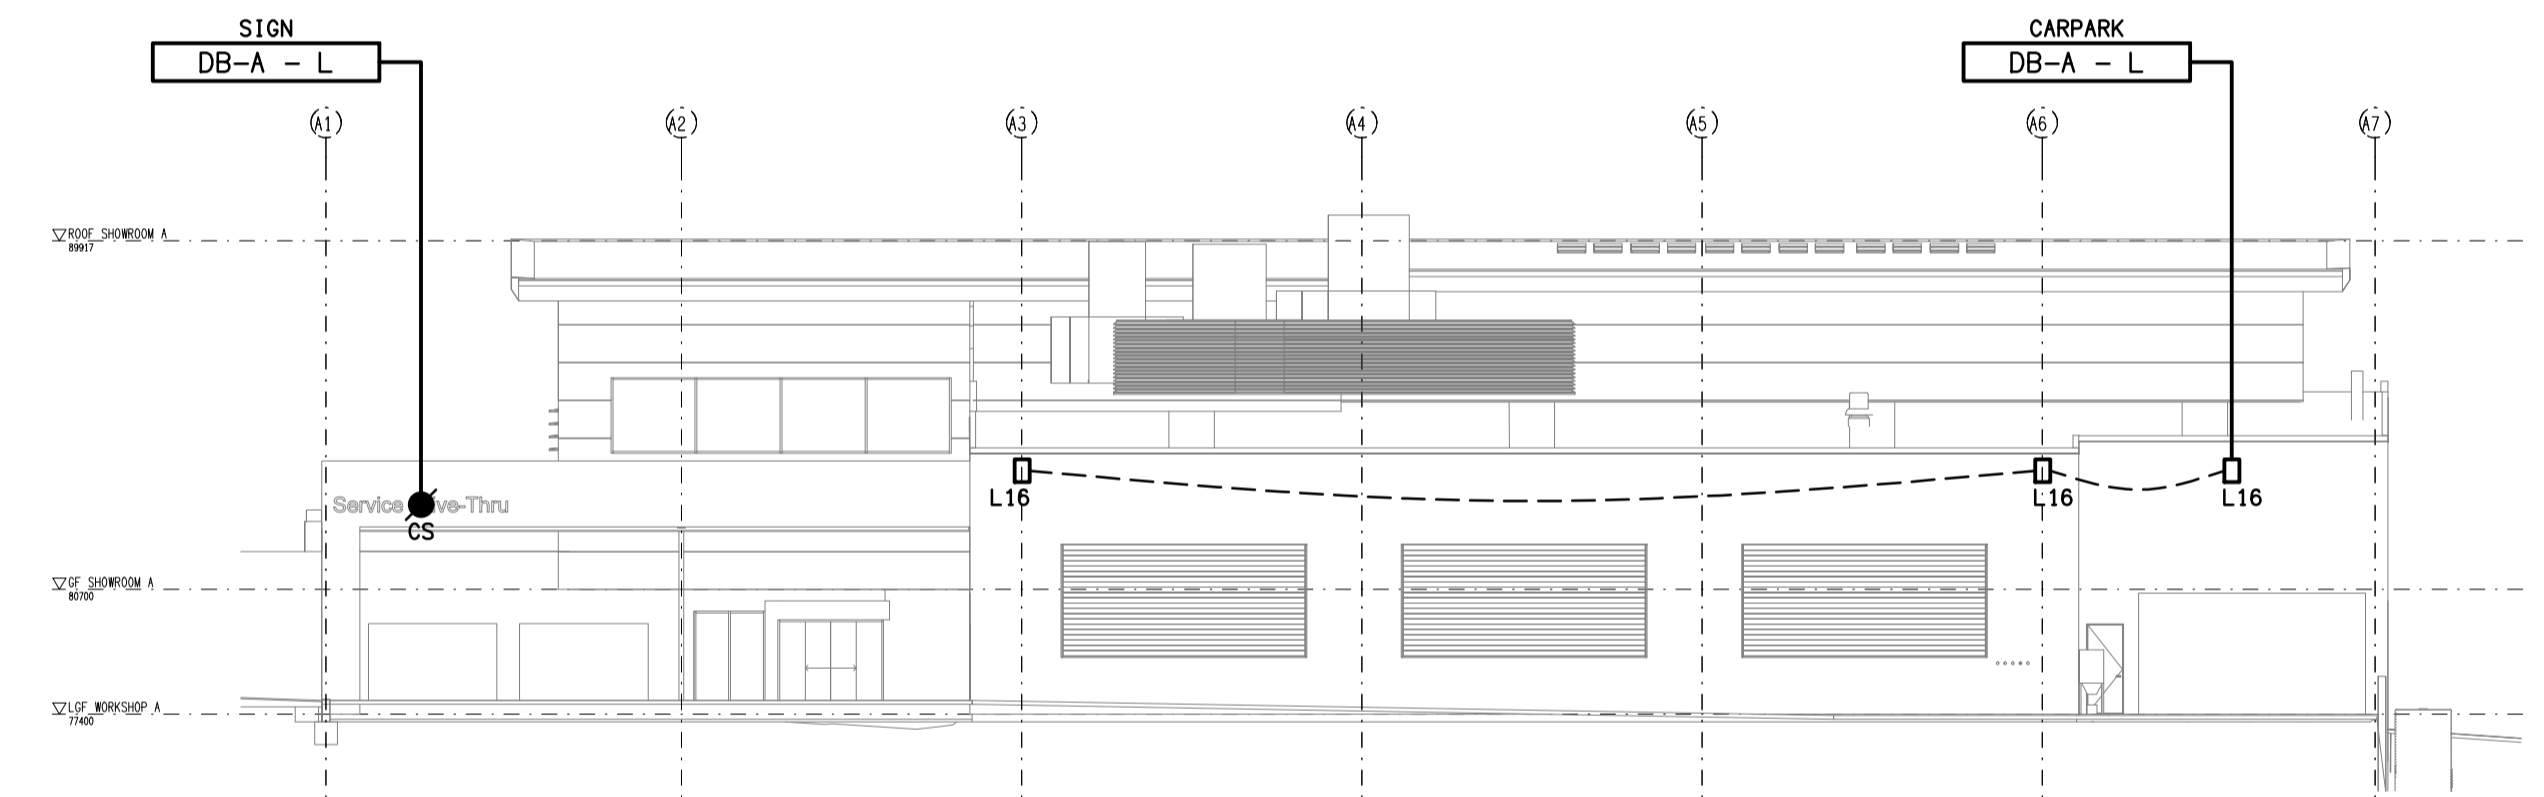

SOUTHERN ELEVATION

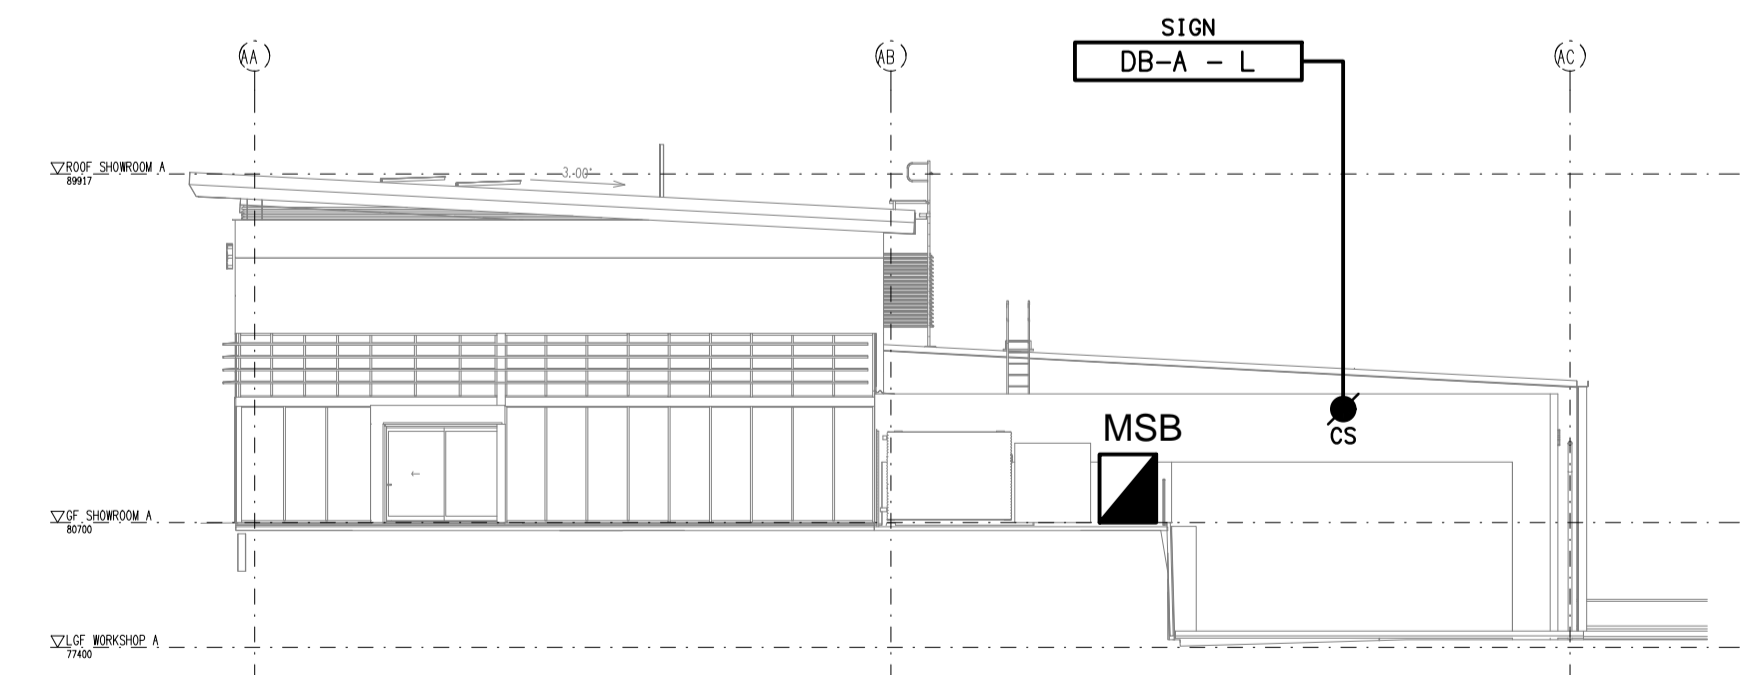

WESTERN ELEVATION

DETAILS
EXTERNAL BUILDING ELEVATIONS
SCALE 1: 200

ELECTRICAL DESIGN GROUP BRISBANE
PTY LTD
ACN 092 710 793
TRADING AS:
ELECTRICAL DESIGN GROUP

THE COPYRIGHT OF THIS DRAWING
REMAINS THE PROPERTY OF THE
ELECTRICAL DESIGN GROUP.

USE FIGURED DIMENSIONS
IN PREFERENCE TO SCALE.

ALL DIMENSIONS TO BE
VERIFIED ONSITE.



Rohrig (Qld) Pty Ltd
ABN 67 093 753 970
QBSA LIC NO 740842
250 Abbotsford Road, Bowen Hills Qld 4006
PO Box 86 Albion DC Qld 4010
T+61 (7) 3257 4411 F+61 (7) 3257 2211
www.rohrig.com.au

ELECTRICAL DESIGN GROUP
ELECTRICAL BUILDING SERVICES CONSULTANTS
BRISBANE GOLD COAST

P.O. Box 15, Sherwood Q.4075
Phone: (07) 3278 4375
Email: brisbane@edg.net.au
Web: www.edg.net.au

PROJECT:
LLEWELLYN MOTORS SPRINGFIELD - LOT 34

LOT 34 AUGUSTA PARKWAY, AUGUSTINE HEIGHTS

D	80% DEVELOPED	24/02/2025
REV:	DESCRIPTION:	DATE:

DRAWING:
**ELECTRICAL SERVICES
ROOF PLAN & ELEVATIONS**

SCALE:
1:200

AT A1

PROJECT NO:
C3396a

DRAWING NO:
E07

REVISION:
D