



REFER OVERLAY PLAN FOR PROPOSED WORKS

**BASEMENT**  
OVERALL SITE PLAN  
SCALE 1:200

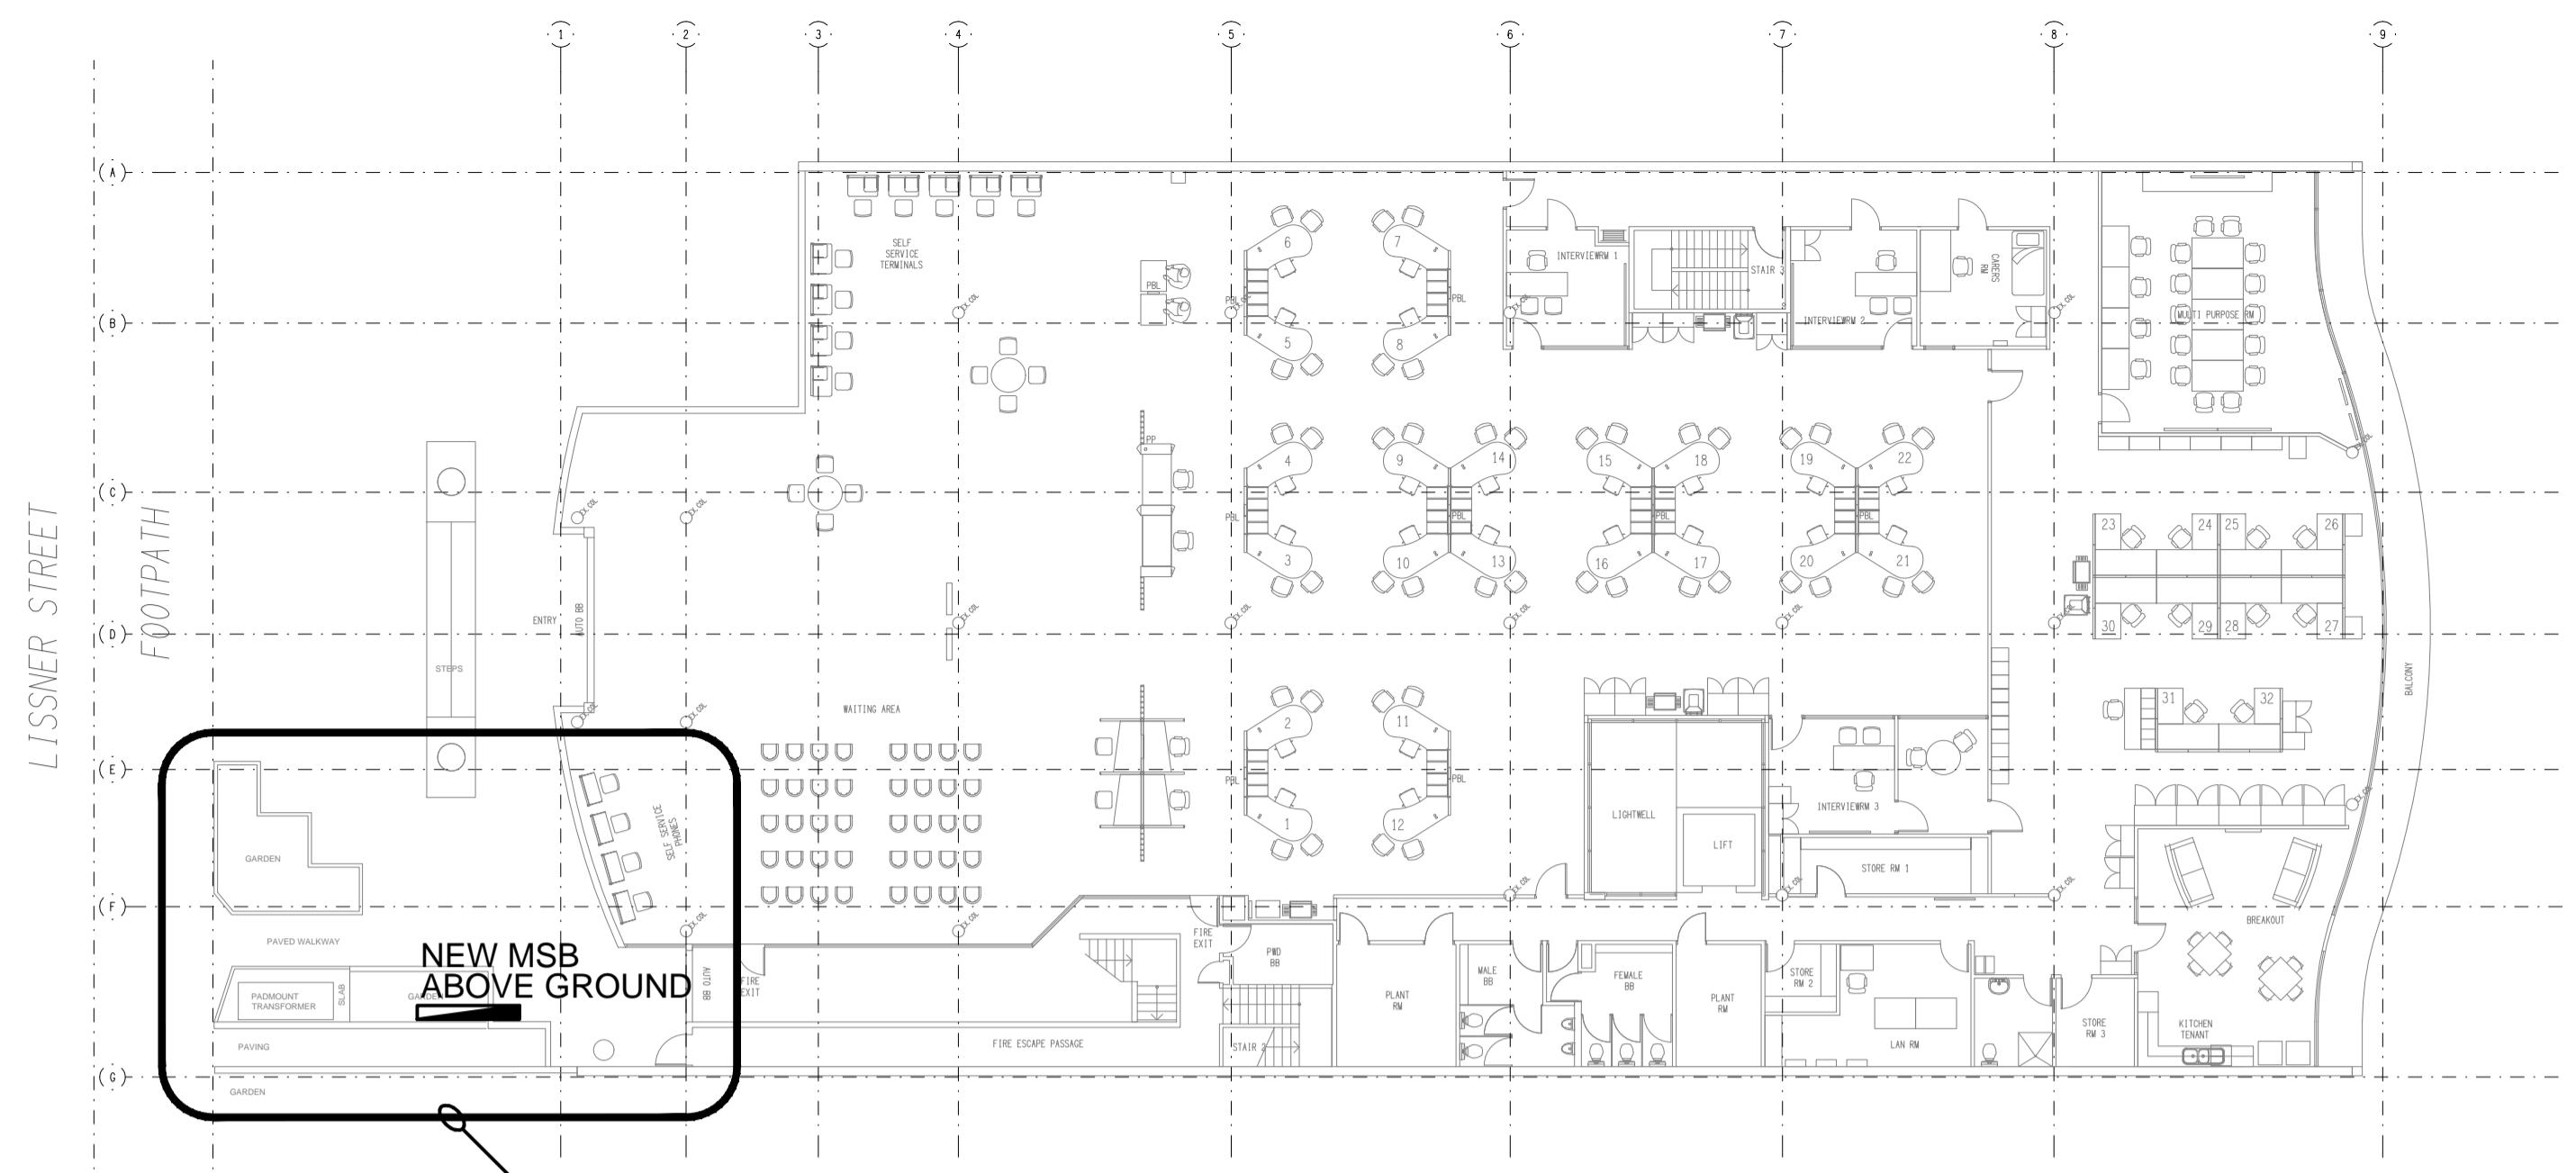


REFER OVERLAY PLAN FOR PROPOSED WORKS

**GROUND LEVEL**  
OVERALL SITE PLAN  
SCALE 1:200

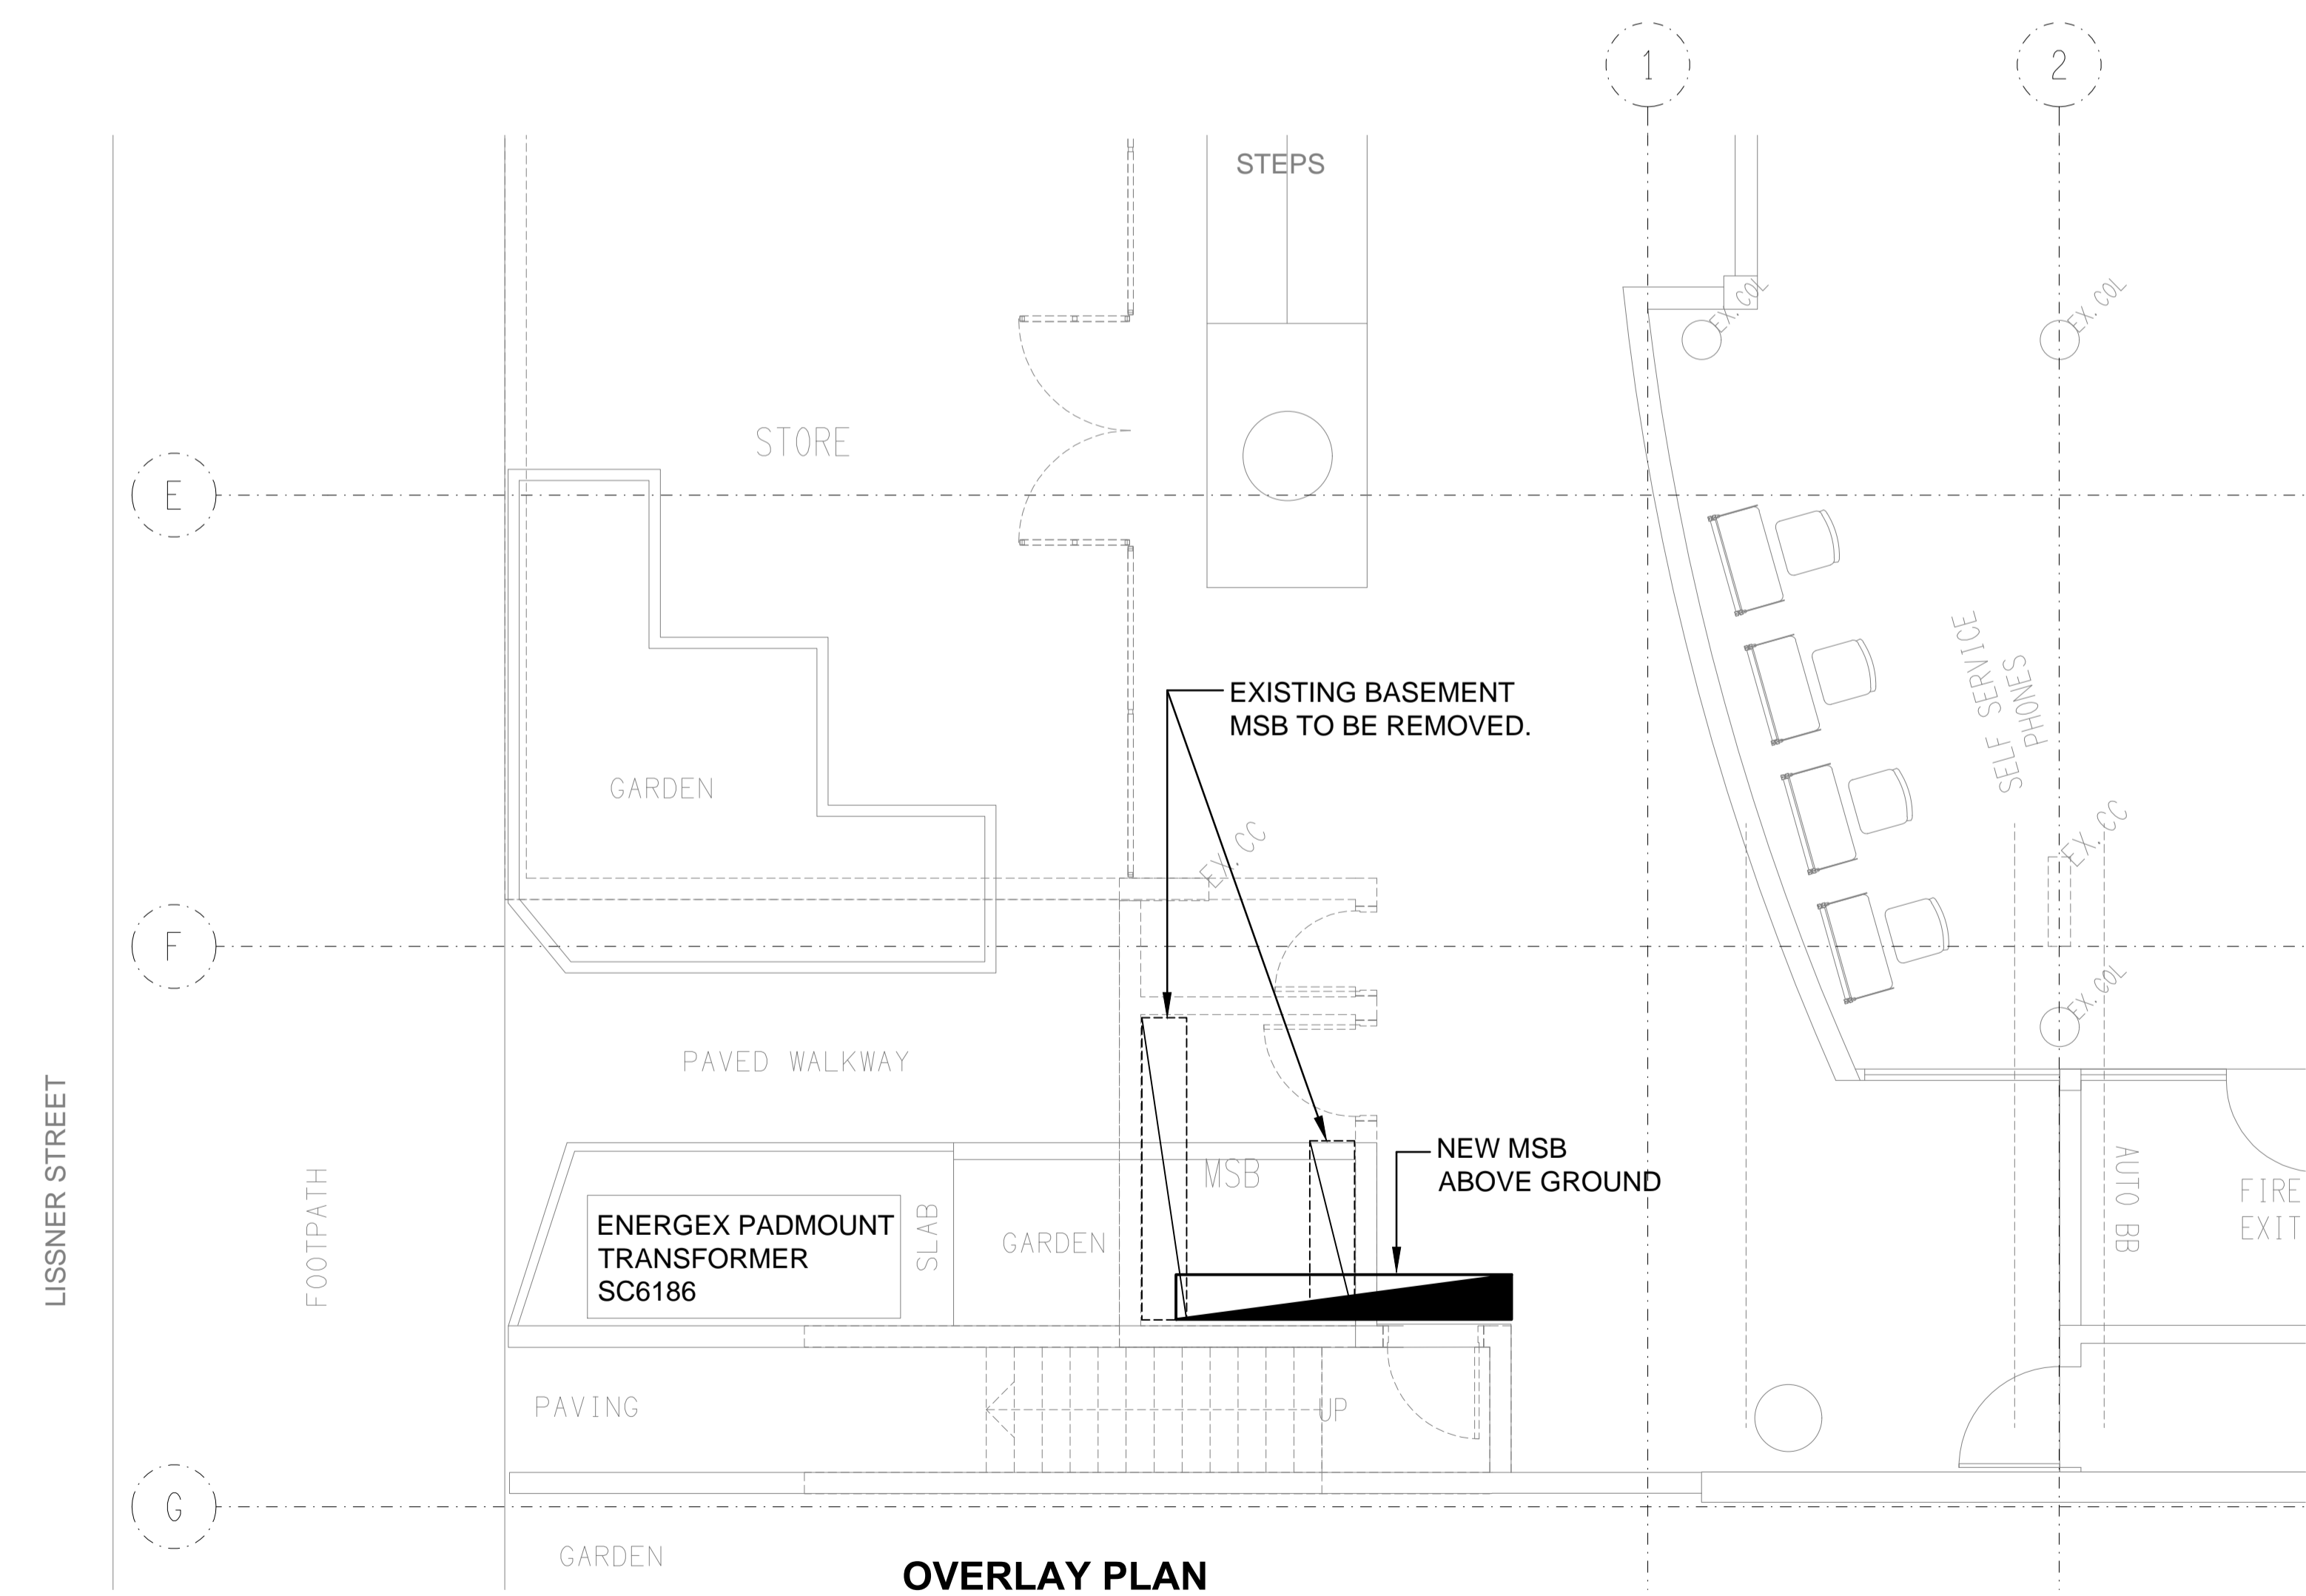

**OVERLAY PLAN**  
BASEMENT / GROUND PROPOSED WORKS  
SCALE 1:50

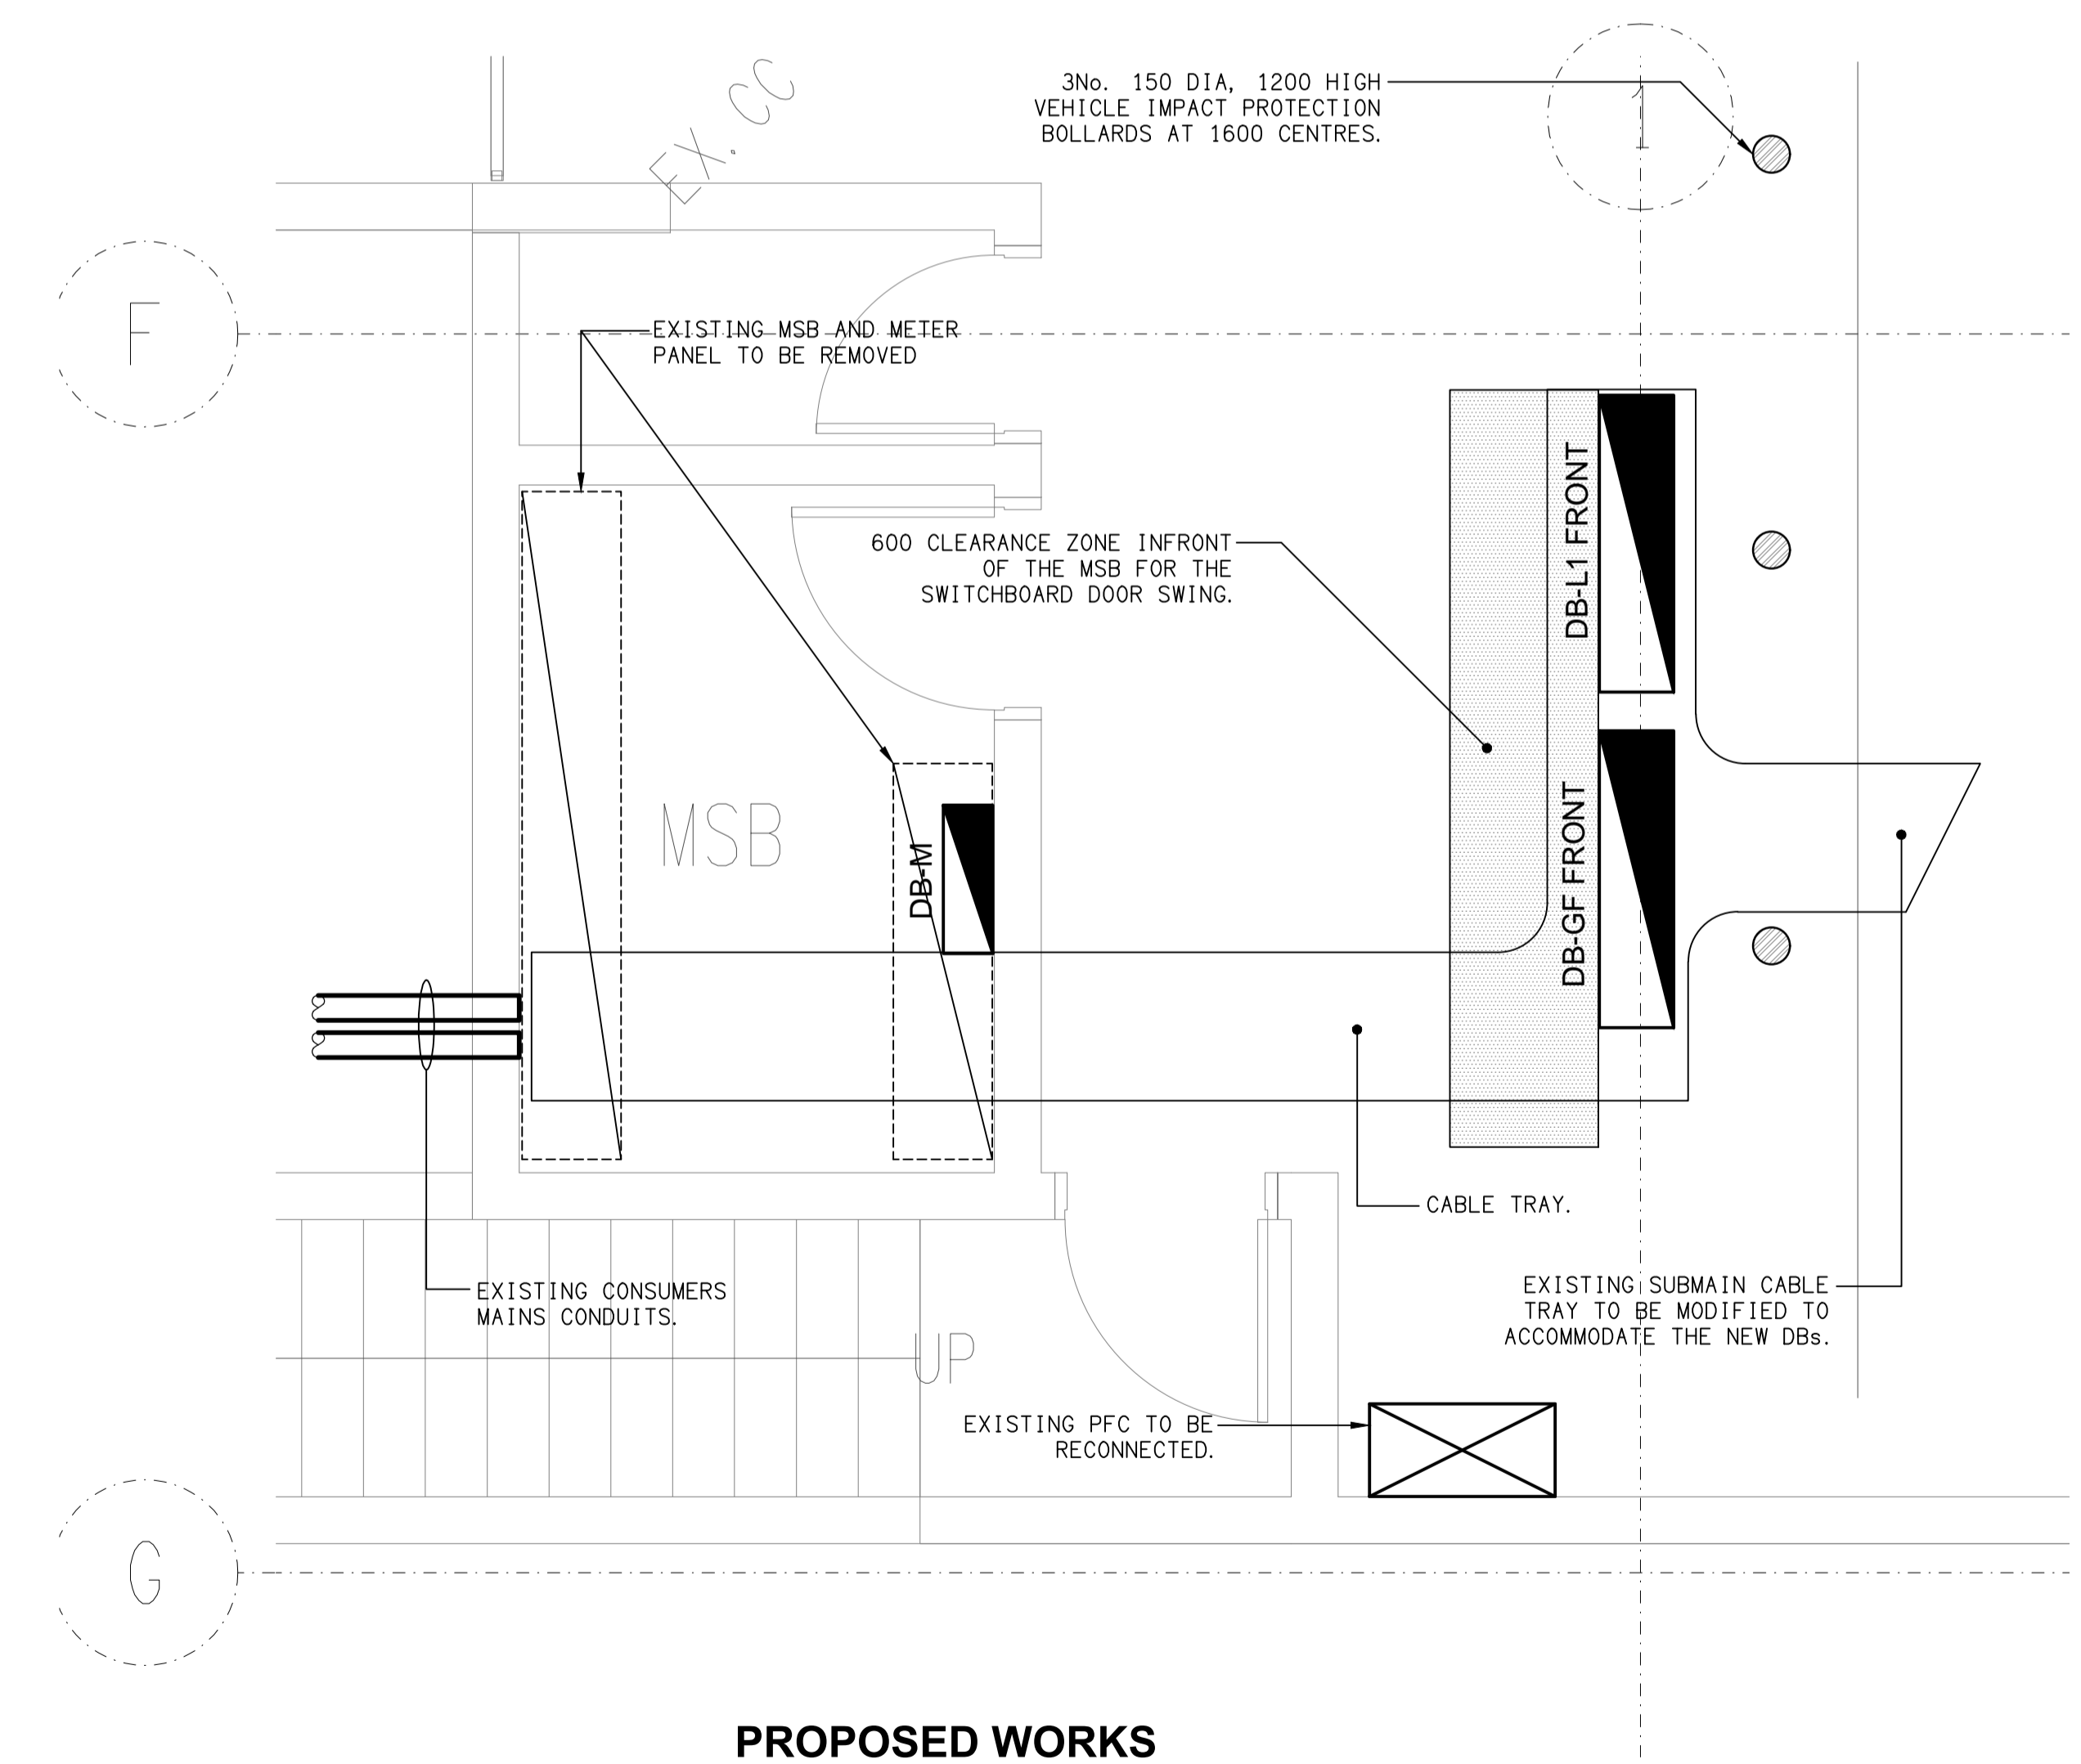

**PROPOSED WORKS**  
BASEMENT MSB CONFIGURATION  
SCALE 1:25

ELECTRICAL DESIGN GROUP BRISBANE  
PTY LTD  
ACN 092 710 793  
TRADING AS:  
ELECTRICAL DESIGN GROUP

THE COPYRIGHT OF THIS DRAWING  
REMAINS THE PROPERTY OF THE  
ELECTRICAL DESIGN GROUP.  
USE FIGURED DIMENSIONS  
IN PREFERENCE TO SCALE.  
ALL DIMENSIONS TO BE  
VERIFIED ONSITE.

**ELECTRICAL DESIGN GROUP**  
ELECTRICAL BUILDING SERVICES CONSULTANTS  
BRISBANE GOLD COAST  
P.O. Box 15, Sherwood Q.4075  
Phone: (07) 3278 4375  
Email: brisbane@edg.net.au  
Web: www.edg.net.au

PROJECT:  
**17-19 LISSNER STREET, TOOWONG**

C	TENDER	07/02/2025
REV.	DESCRIPTION:	DATE:
DRAWING: <b>ELECTRICAL SERVICES</b> SITE PLAN		
SCALE: AS SHOWN	AT A1	PROJECT NO: <b>C3401a</b>
		DRAWING NO: <b>E01</b>
		REVISION: <b>C</b>