



EXISTING SCHEMATIC
POWER CONFIGURATION
NOT TO SCALE

- LEGEND**
- ELECTRICAL SERVICES SWITCHBOARD.
 - SWITCHBOARD / CONTROL PANEL NOT PROVIDED AS PART OF THE ELECTRICAL SUBCONTRACT.
 - SINGLE PHASE ISOLATOR.
 - THREE PHASE ISOLATOR.
 - JUNCTION BOX.
 - CONDUIT ROUTE.
 - CABLE TRAY AS NOTED.
 - ELECTRICAL EQUIPMENT AS NOTED.
 - QECM V4 COMPLIANT ELECTRICITY METER.
 - QECM V4 COMPLIANT METERING TEST BLOCK.
 - QECM V4 COMPLIANT GENERATION SIGNALING DEVICE.
 - QECM V4 COMPLIANT DEMAND RESPONSE SITE CONTROLLER.

- LEGEND**
- FUSE.
 - SINGLE PHASE.
 - THREE PHASE.
 - QECM V4 COMPLIANT CURRENT TRANSFORMER C/W REMOVABLE LINK.
 - QECM V4 COMPLIANT FUSE LINK.
 - COMBINED FUSE SWITCH.
 - CIRCUIT BREAKER.
 - LOAD BREAK NON AUTO ISOLATOR.
 - QECM V4 COMPLIANT NETWORK CONTROL DEVICE.
 - CONTACTOR.

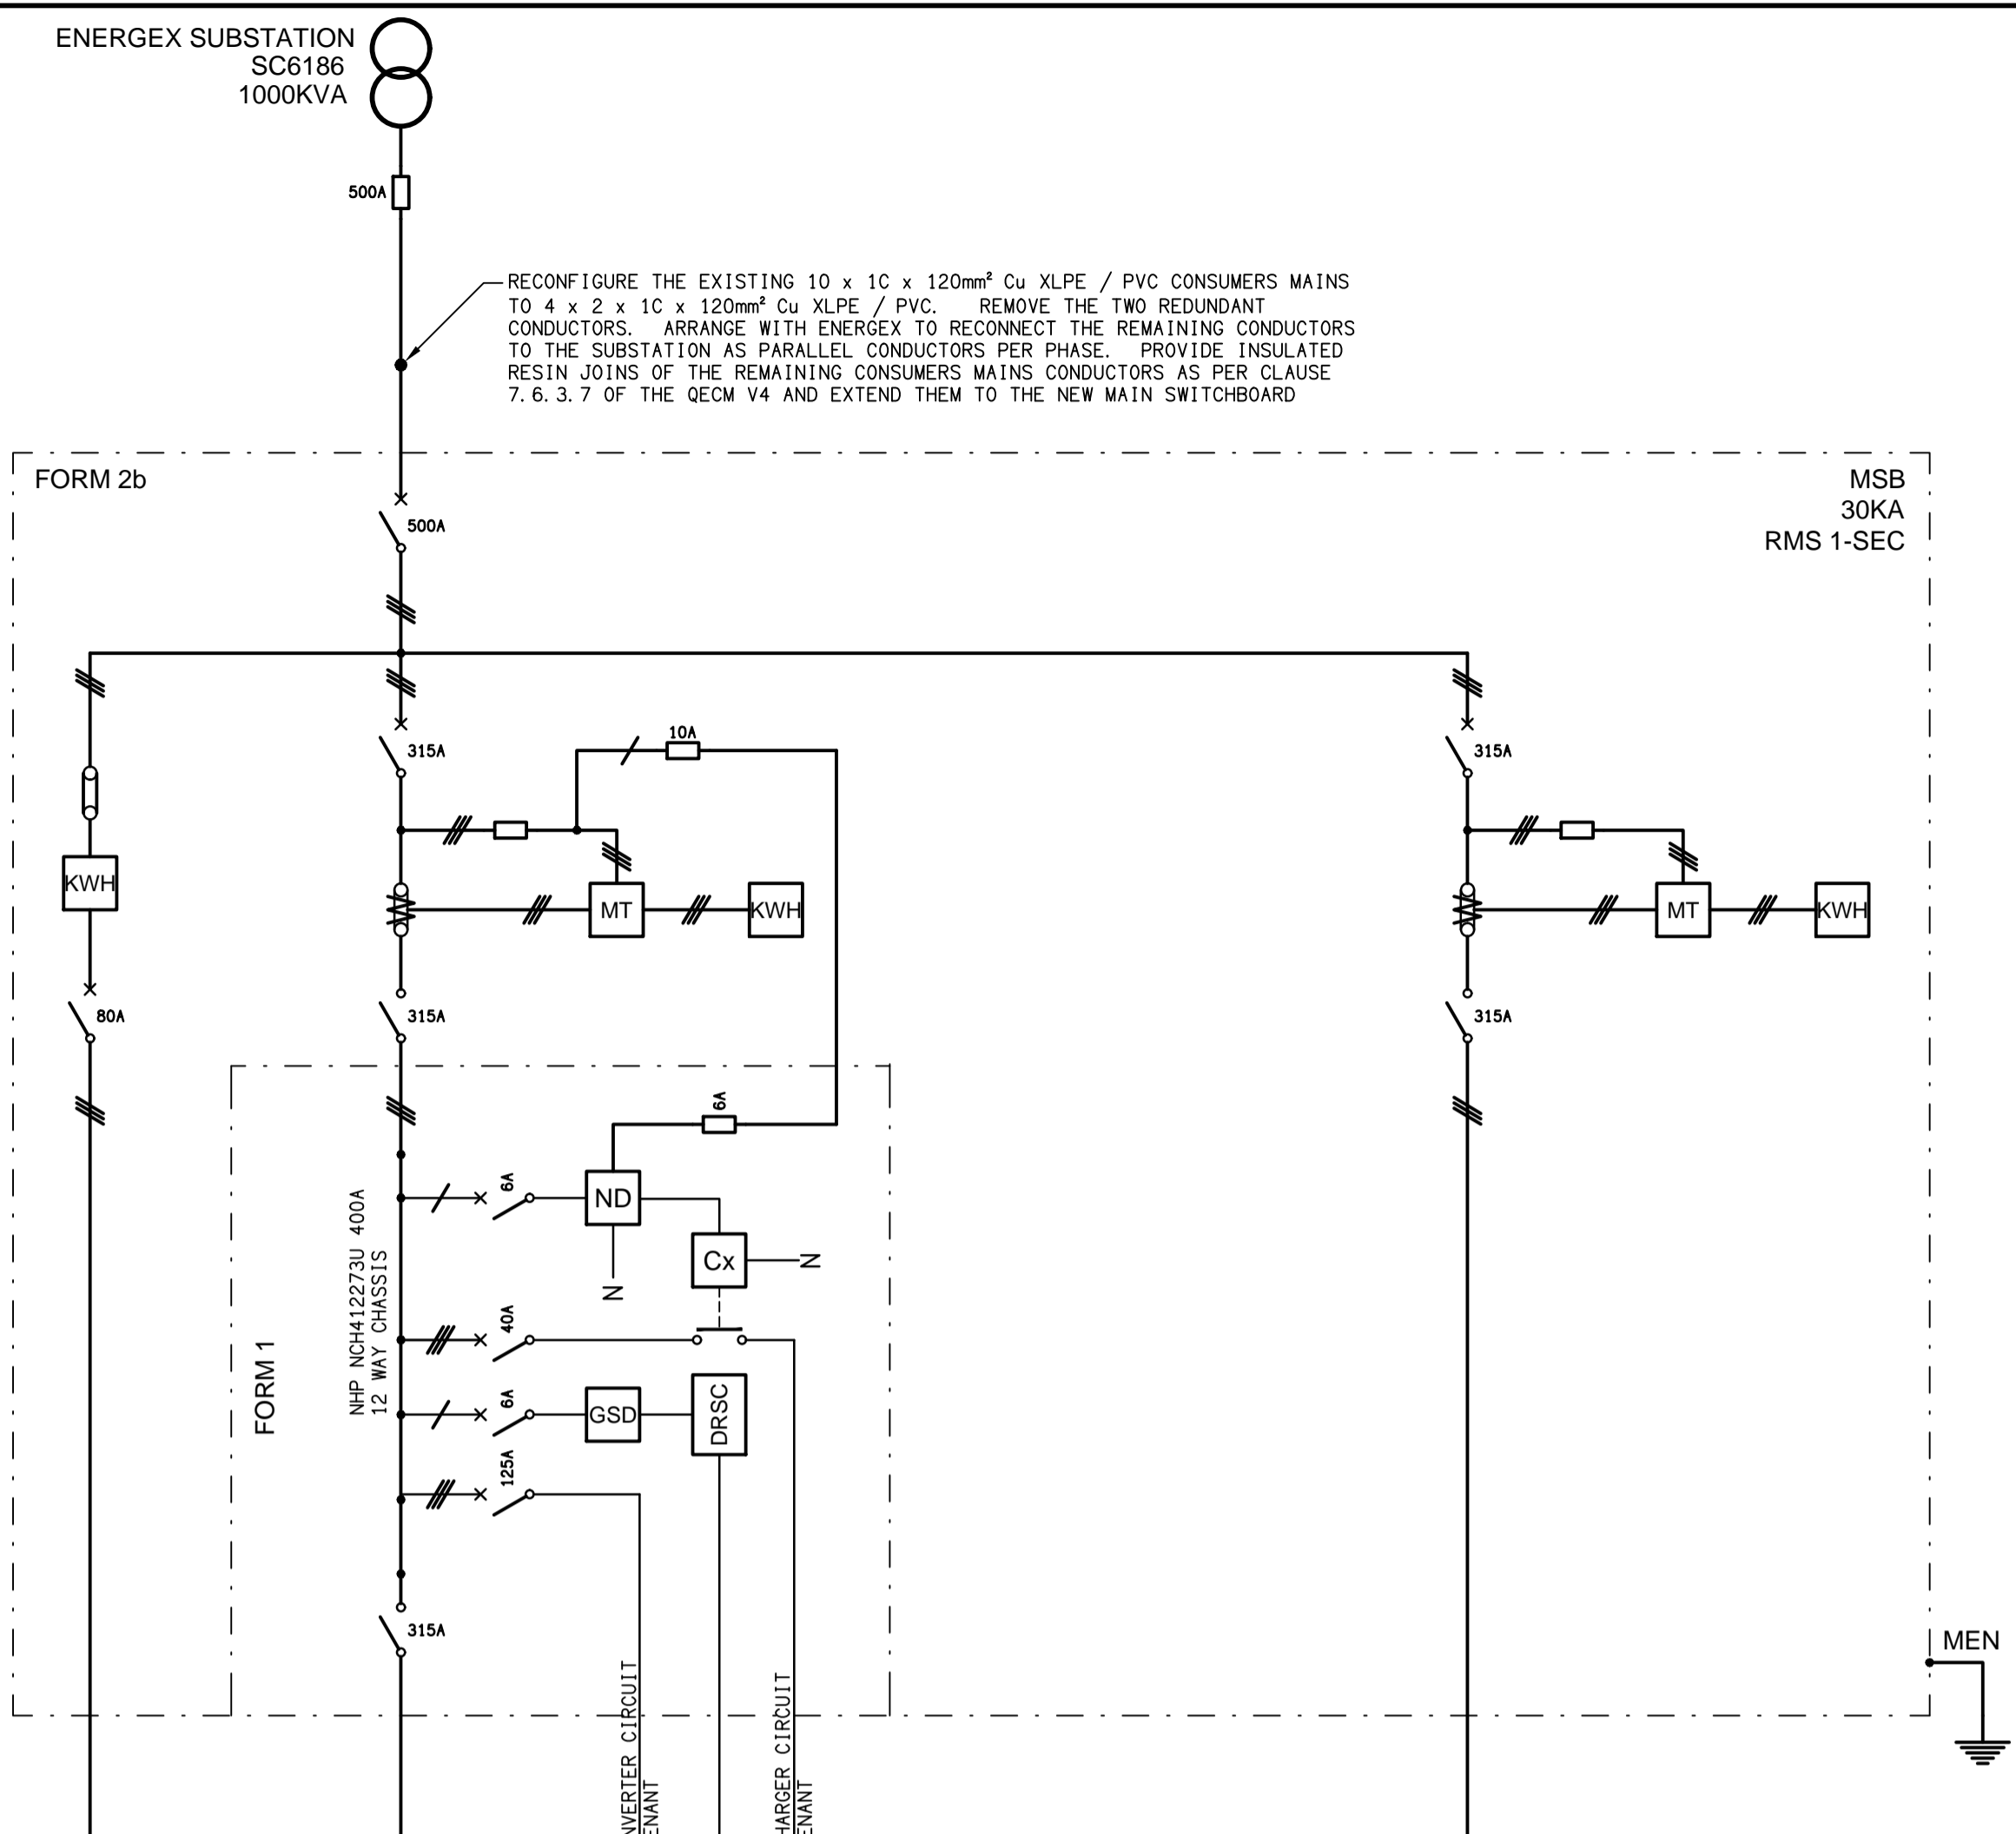

PROPOSED SCHEMATIC
POWER CONFIGURATION
NOT TO SCALE

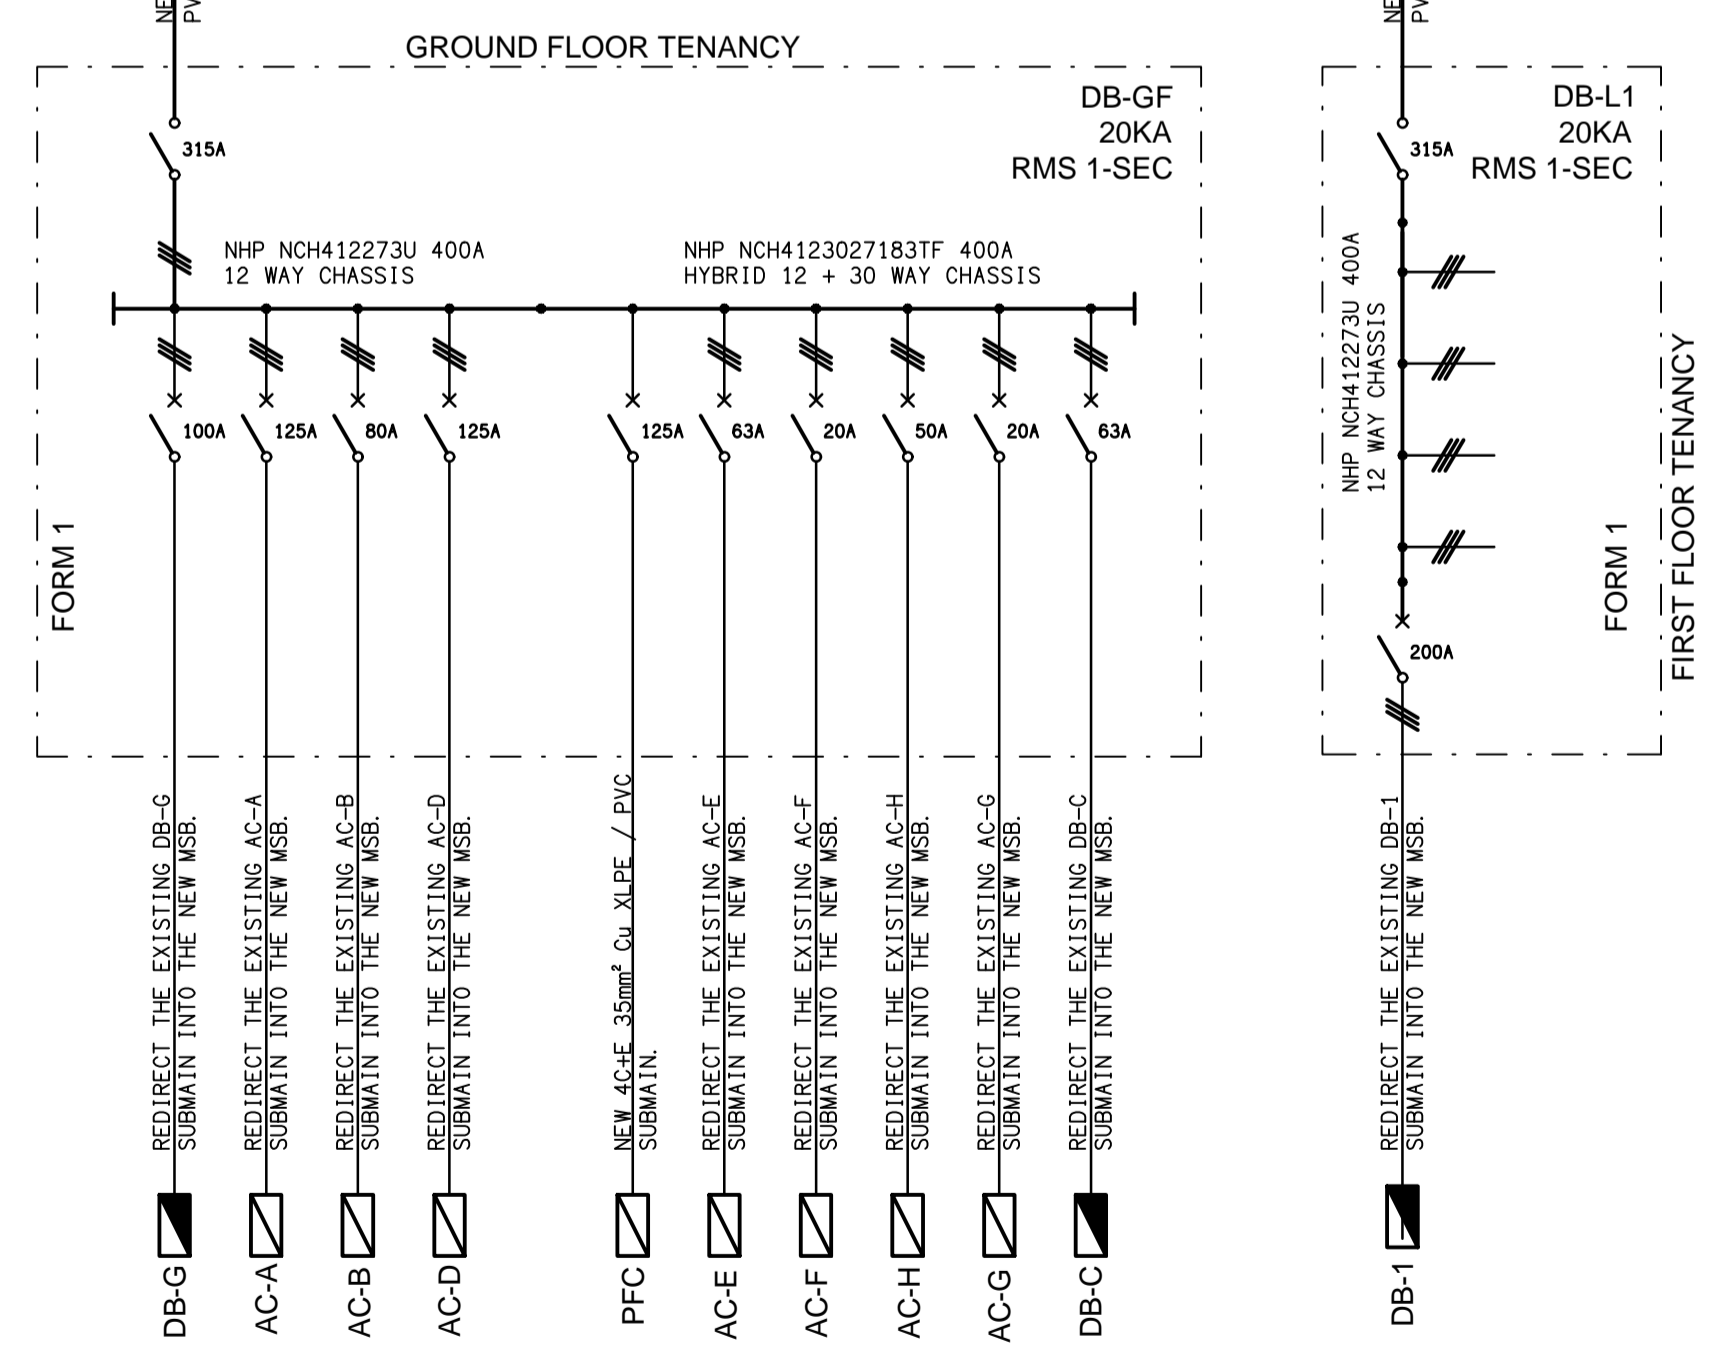

ELECTRICAL DESIGN GROUP BRISBANE
PTY LTD
ACN 092 710 793
TRADING AS:
ELECTRICAL DESIGN GROUP

THE COPYRIGHT OF THIS DRAWING
REMAINS THE PROPERTY OF THE
ELECTRICAL DESIGN GROUP.
USE FIGURED DIMENSIONS
IN PREFERENCE TO SCALE.
ALL DIMENSIONS TO BE
VERIFIED ONSITE.

ELECTRICAL DESIGN GROUP
ELECTRICAL BUILDING SERVICES CONSULTANTS
BRISBANE GOLD COAST
P.O. Box 15, Sherwood Q.4075
Phone: (07) 3278 4375
Email: brisbane@edg.net.au
Web: www.edg.net.au

PROJECT:
17-19 LISSNER STREET, TOOWONG

C	TENDER	07/02/2025
REV:	DESCRIPTION:	DATE:
DRAWING: ELECTRICAL SERVICES SITE PLAN		
SCALE: AS SHOWN	AT A1	PROJECT NO: C3401a
		DRAWING NO: E01
		REVISION: C