

 ELECTRICAL SERVICES SWITCHBOARD.

 SWITCHBOARD BY OTHERS.

 SINGLE POWER OUTLET.

 DOUBLE POWER OUTLET.

 USB DOUBLE POWER OUTLET C/W USB CHARGER.

 SPECIAL PURPOSE POWER OUTLET.

 SIGN CONNECTION.

 SINGLE PHASE ISOLATOR.

 ELECTRICAL FLOOR BOX, TYPE AS NOTED.

 LIGHTING CONTROL SWITCH PANEL, TYPE

 ONE-WAY LIGHT SWITCH.

 CIRCUIT LINE.

 SWITCH LINE.


L10 L10: NEW 300 X 1200 4000K BACKLITE LED PANEL LIGHT TO REPLACE THE EXISTING FITTING.

L11 L11: NEW LED DOWNLIGHT TO REPLACE THE EXISTING FITTING.

L12 L12: NEW SUSPENDED LINEAR LED EXTRUSION LIGHT TO REPLACE THE EXISTING FITTING.


L13 L13: NEW 600 X 600 4000K BACKLITE LED PANEL LIGHT TO REPLACE THE EXISTING FITTING.

ALL ELECTRICAL PENETRATIONS THROUGH THE ROOF SHEETING ARE TO BE IN LINE WITH THE STRUCTURAL OR MECHANICAL SERVICES PENETRATIONS TO AVOID DEDICATED FLASHINGS FOR THE ELECTRICAL SERVICES

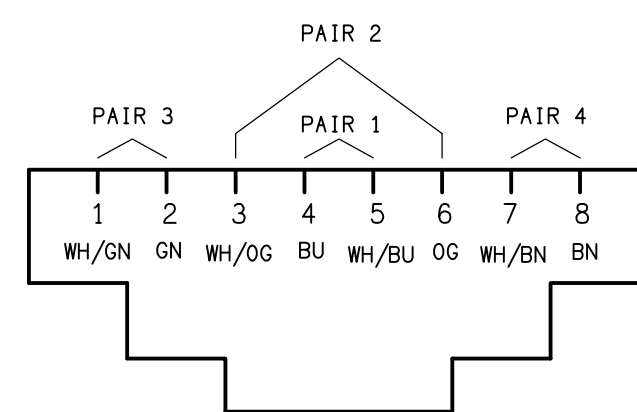


RJ45 PINOUT CONFIGURATION

NOT TO SCALE

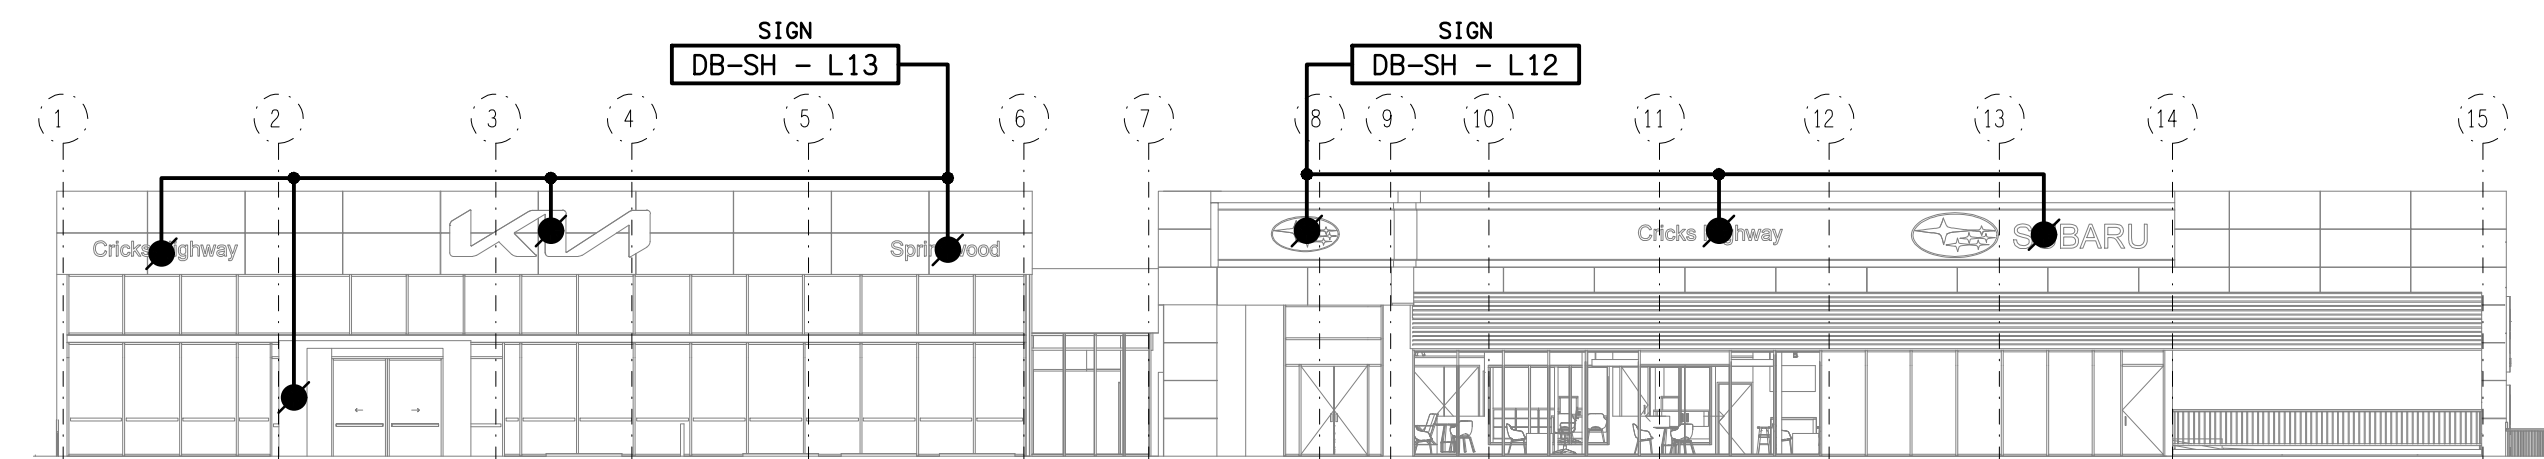

PACIFIC HIGHWAY SERVICE ROAD SIDE
SCALE 1:200

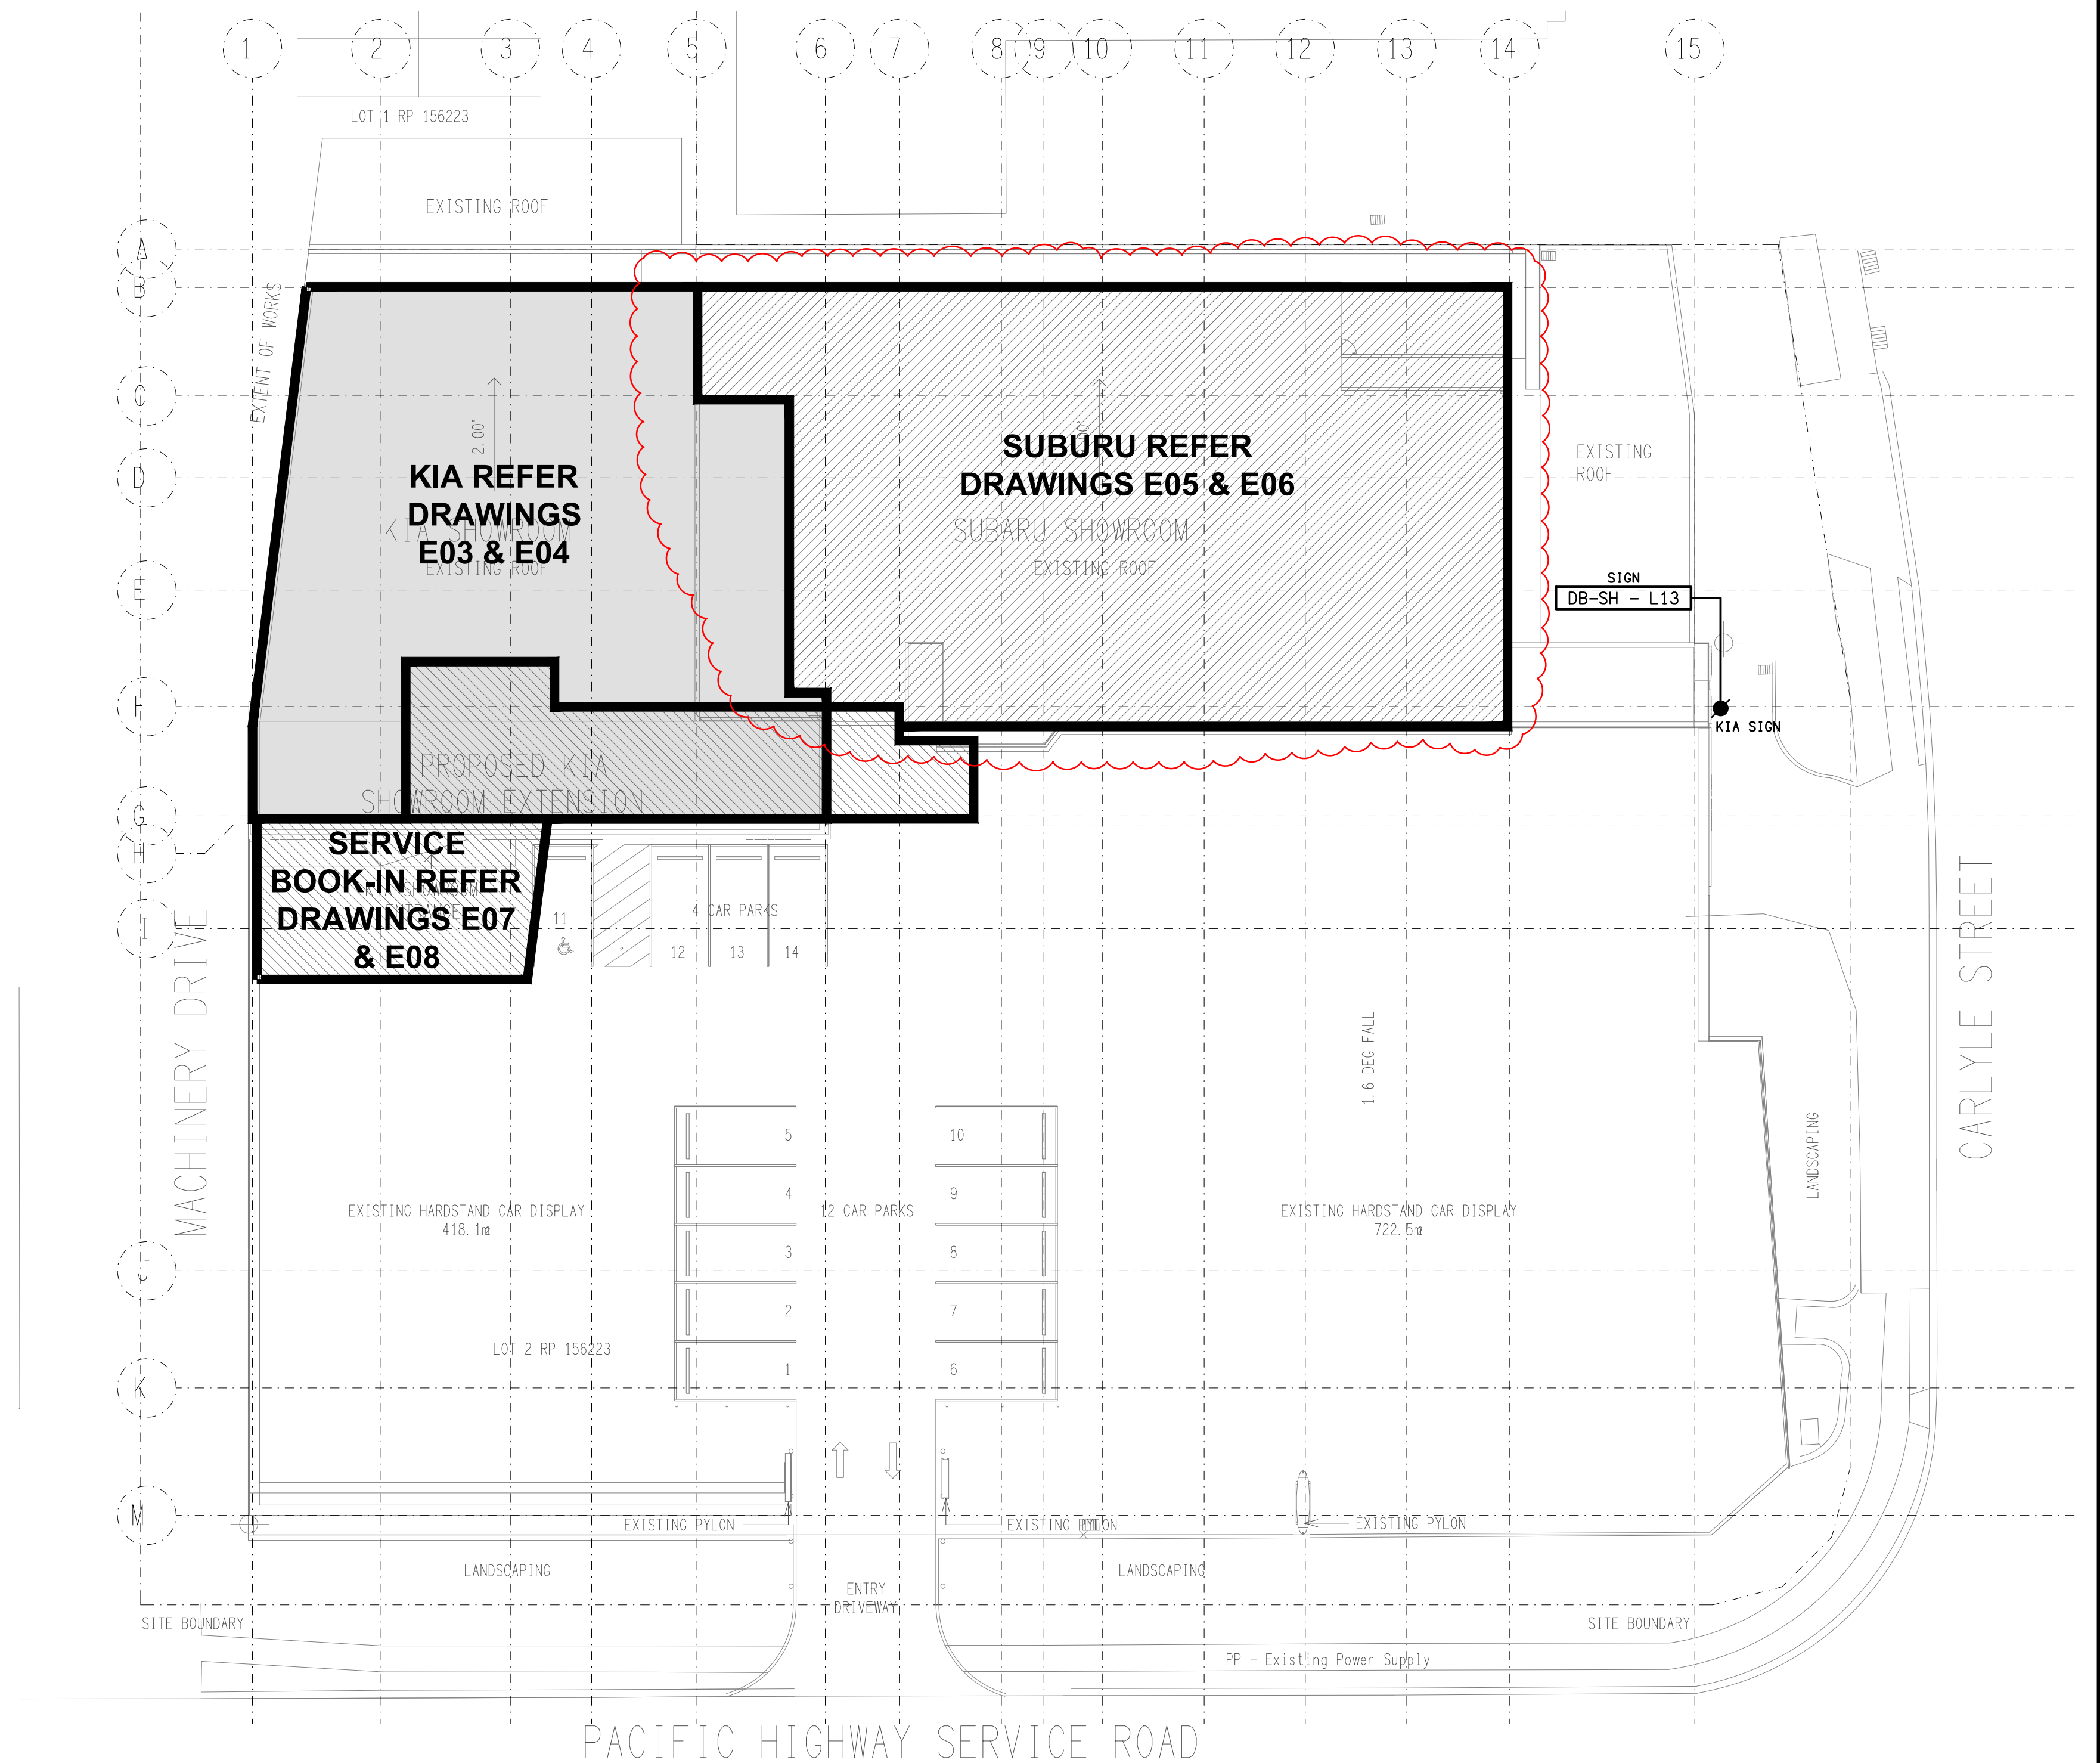

KIA & SUBARU SHOWROOMS
SCALE 1:200

DRAWING: **ELECTRICAL SERVICES**
LEGEND & SITE PLAN

SCALE: 1:200	AT A1	PROJECT NO: C3403a	DRAWING NO: E01	REVISION: C
-----------------	-------	------------------------------	---------------------------	-----------------------

ELECTRICAL DESIGN GROUP BRISBANE
PTY LTD
ACN 092 710 793

TRADING AS:
ELECTRICAL DESIGN GROUP

THE COPYRIGHT OF THIS DRAWING
REMAINS THE PROPERTY OF THE
ELECTRICAL DESIGN GROUP.

USE FIGURED DIMENSIONS
IN PREFERENCE TO SCALE.

ALL DIMENSIONS TO BE
VERIFIED ONSITE.

ELECTRICAL DESIGN GROUP
ELECTRICAL BUILDING SERVICES CONSULTANTS
BRISBANE GOLD COAST

P.O.Box 15, Sherwood Q.4075
Phone: (07) 3278 4375
Email: brisbane@edg.net.au
Web: www.edg.net.au

PROJECT: AUTOPACT KIA SPRINGWOOD

3477-3483 PACIFIC HIGHWAY, SLACKS CREEK