


GROUND LEVEL
FLOOR PLAN
SCALE 1:100

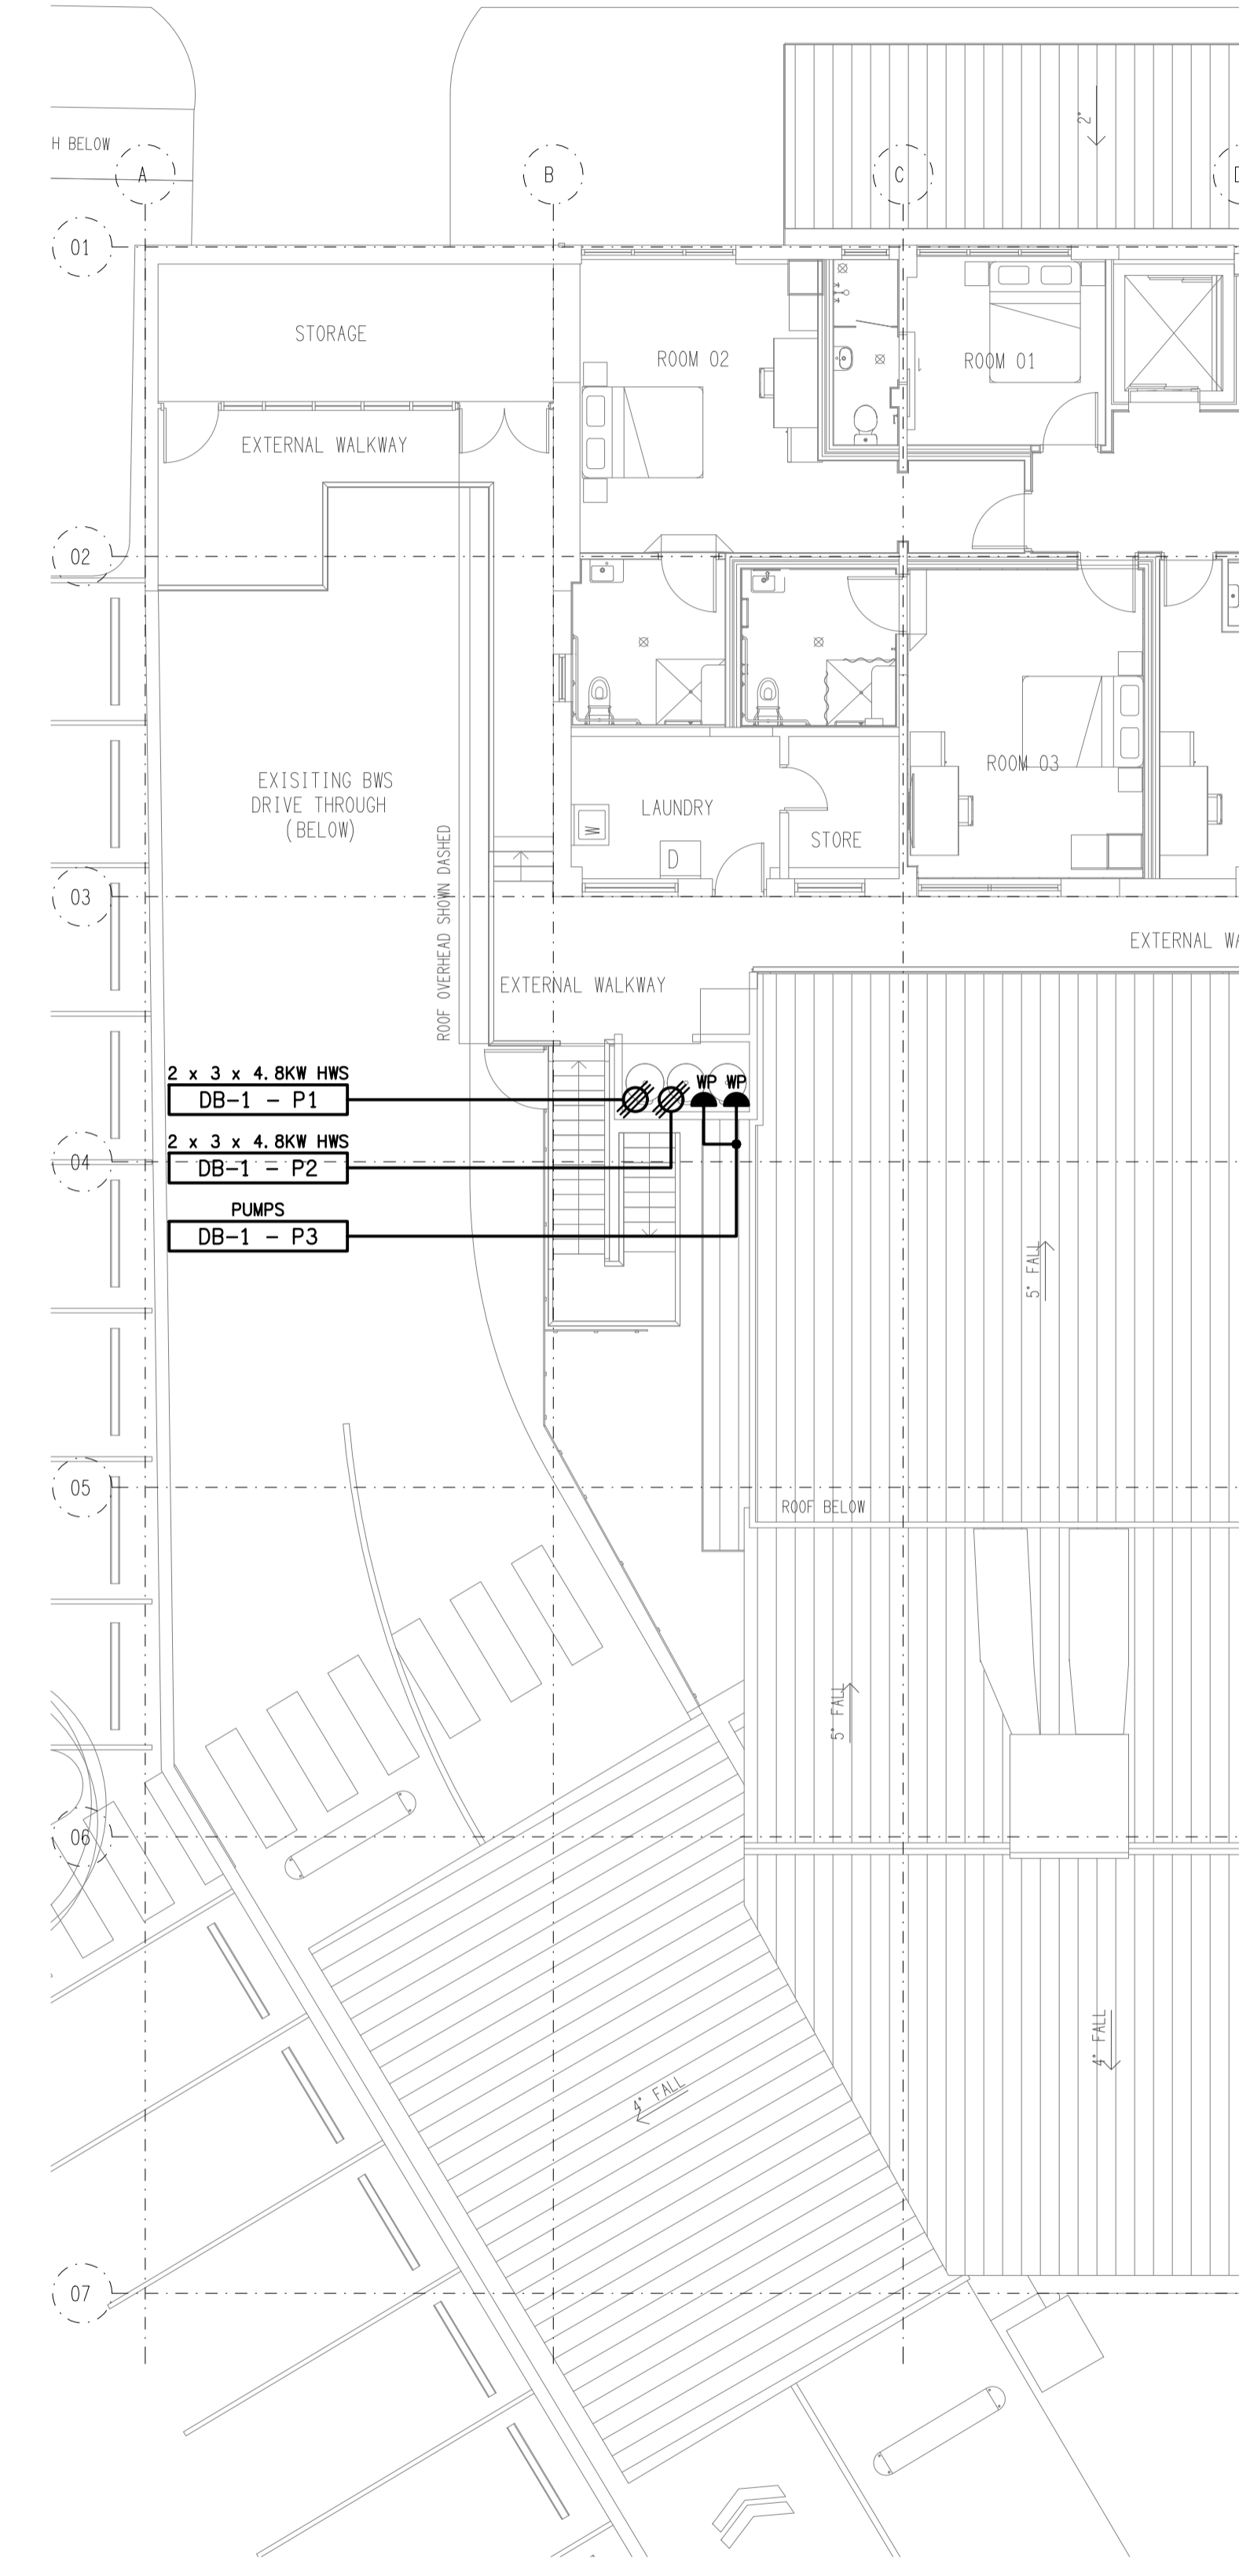

LEVEL 1
PART FLOOR PLAN
SCALE 1:100

ELECTRICAL DESIGN GROUP BRISBANE
PTY LTD
ACN 092 710 793
TRADING AS:
ELECTRICAL DESIGN GROUP

THE COPYRIGHT OF THIS DRAWING
REMAINS THE PROPERTY OF THE
ELECTRICAL DESIGN GROUP.
USE FIGURED DIMENSIONS
IN PREFERENCE TO SCALE.
ALL DIMENSIONS TO BE
VERIFIED ONSITE.

ELECTRICAL DESIGN GROUP
ELECTRICAL BUILDING SERVICES CONSULTANTS
BRISBANE GOLD COAST

P.O. Box 15, Sherwood Q.4075
Phone: (07) 3278 4375
Email: brisbane@edg.net.au
Web: www.edg.net.au

PROJECT:
PRINCE OF WALES HOTEL, NUNDAH
100 BUCKLAND ROAD, NUNDAH

| | | |
|------|--------------|------------|
| A | PRELIMINARY | 19/02/2025 |
| REV: | DESCRIPTION: | DATE: |

DRAWING:
**ELECTRICAL SERVICES
FLOOR PLAN**

| | | | |
|-----------------|------------------------------|---------------------------|-----------------------|
| SCALE: 1:100 | PROJECT NO: C3419a | DRAWING NO: E03 | REVISION: A |
|-----------------|------------------------------|---------------------------|-----------------------|