


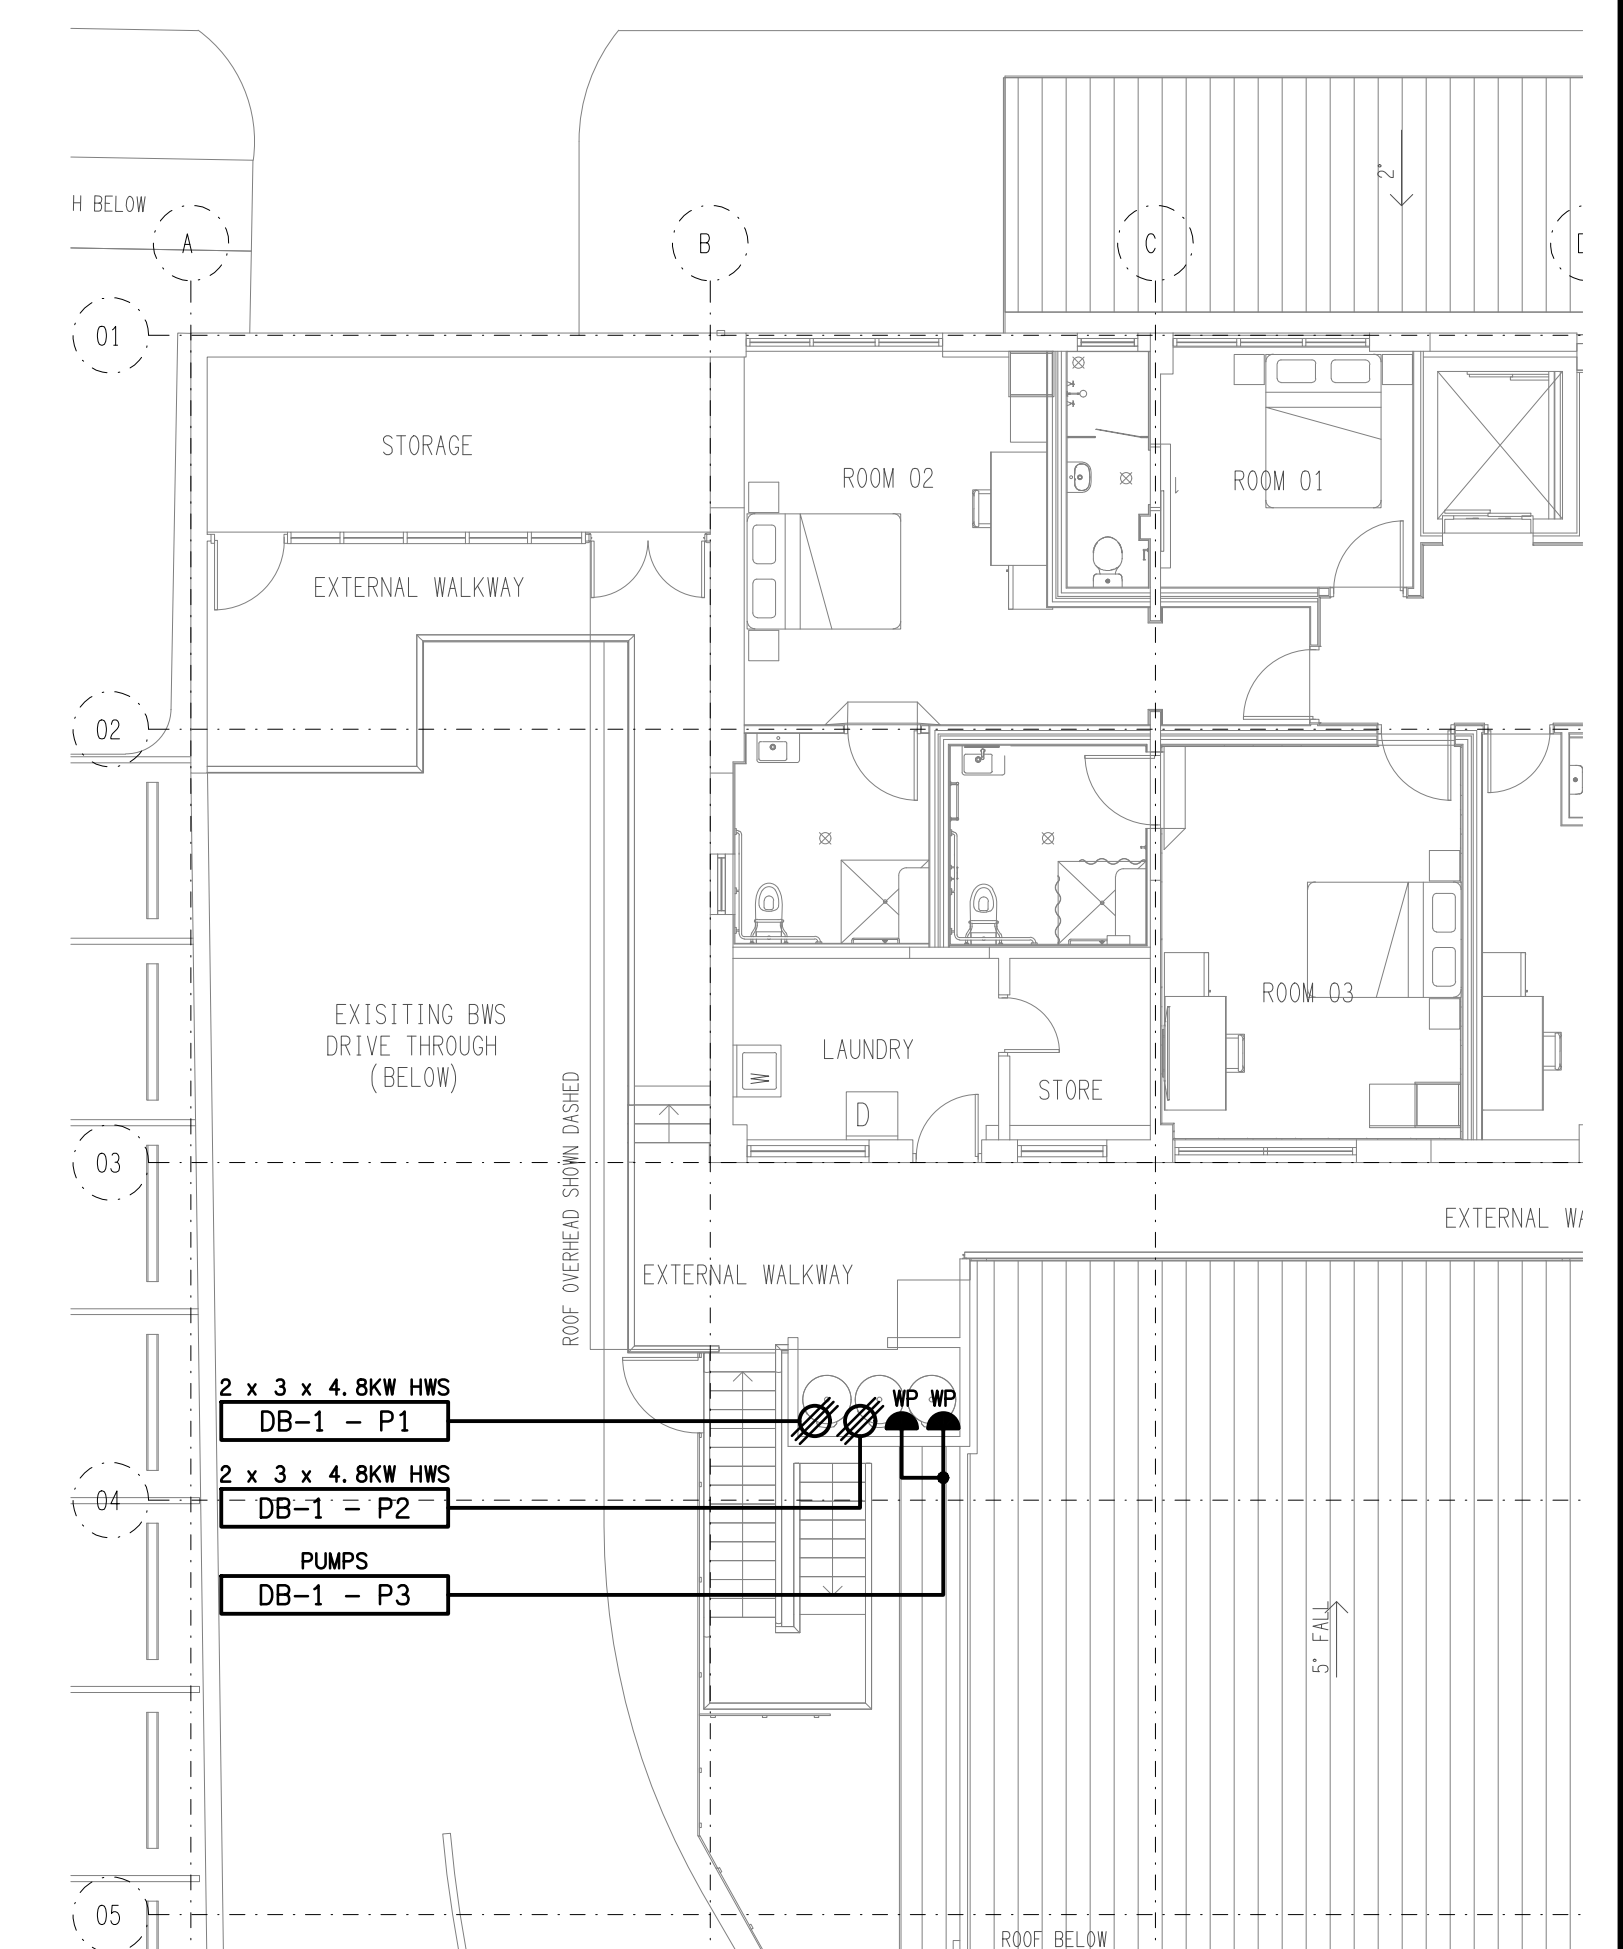

E	CONSTRUCTION	28/08/2025
REV:	DESCRIPTION:	DATE:

DRAWING: ELECTRICAL SERVICES FLOOR PLAN		PROJECT NO: C3419a	DRAWING NO: E03	REVISION: E
SCALE: 1:100 UNO		AT A1		

100 BUCKLAND ROAD, NUNDAH