
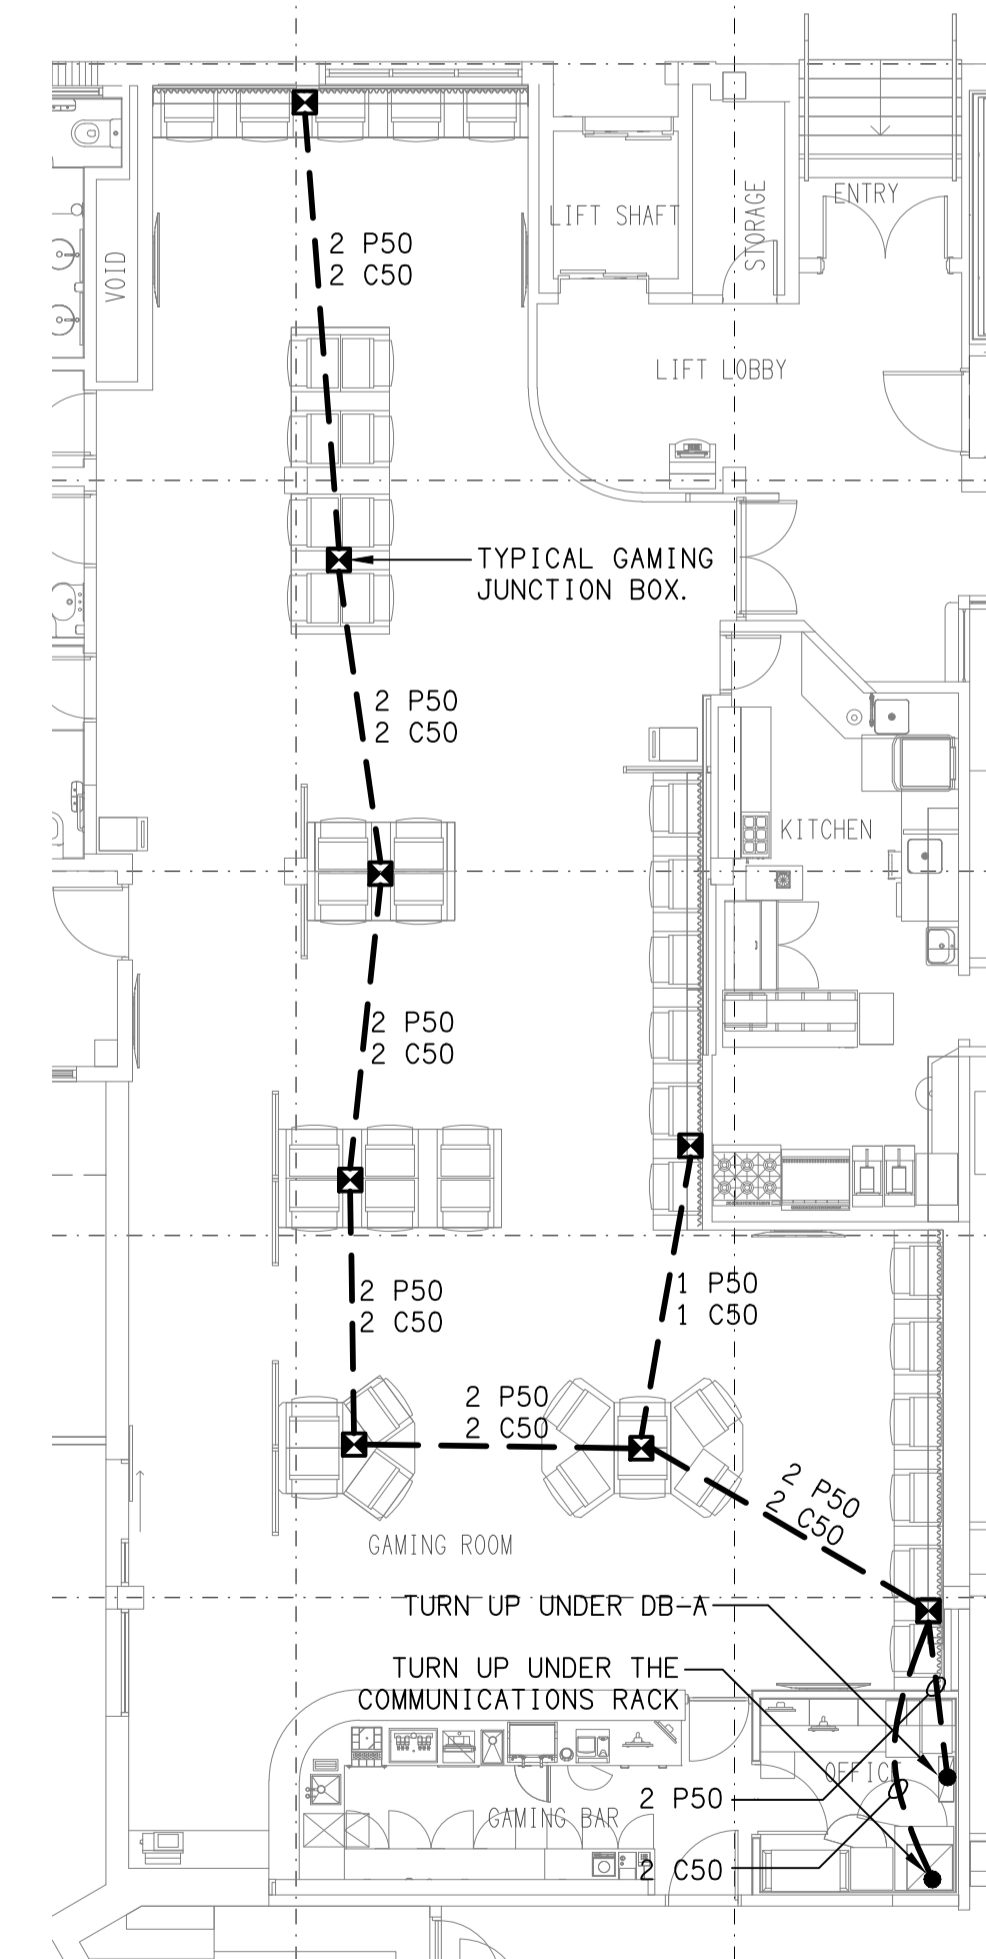


GAMING & AMENITIES
FLOOR PLAN
SCALE 1:50

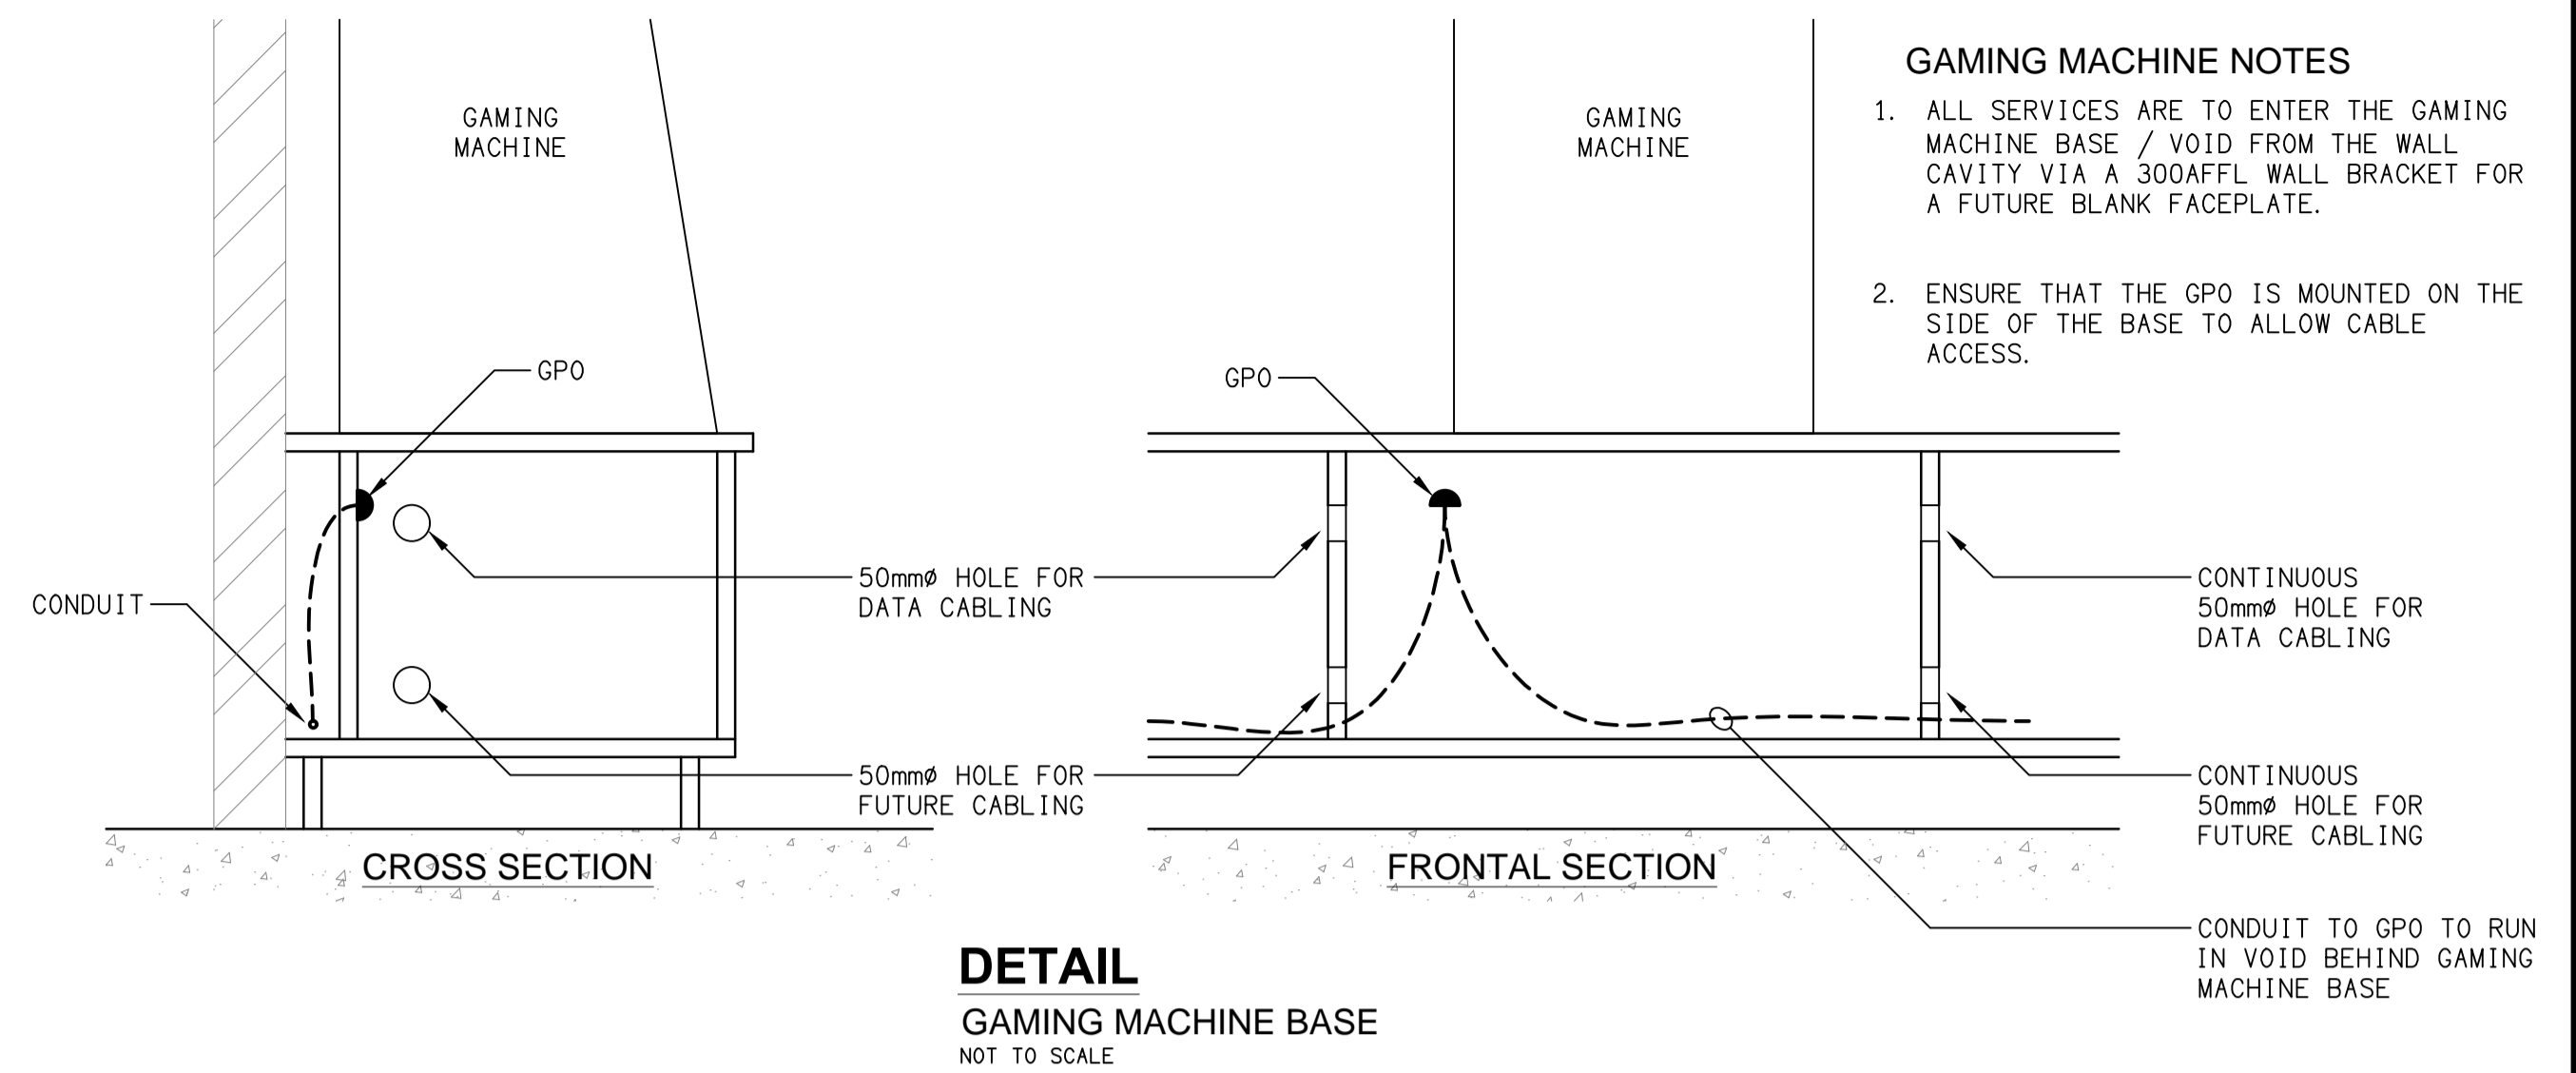

ELECTRICAL DESIGN GROUP BRISBANE
PTY LTD
ACN 092 710 793
TRADING AS:
ELECTRICAL DESIGN GROUP

THE COPYRIGHT OF THIS DRAWING
REMAINS THE PROPERTY OF THE
ELECTRICAL DESIGN GROUP.
USE FIGURED DIMENSIONS
IN PREFERENCE TO SCALE.
ALL DIMENSIONS TO BE
VERIFIED ONSITE.

ELECTRICAL DESIGN GROUP
ELECTRICAL BUILDING SERVICES CONSULTANTS
BRISBANE GOLD COAST

P.O. Box 15, Sherwood Q.4075
Phone: (07) 3278 4375
Email: brisbane@edg.net.au
Web: www.edg.net.au

PROJECT:
PRINCE OF WALES HOTEL, NUNDAH

100 BUCKLAND ROAD, NUNDAH

A	PRELIMINARY	19/02/2025
REV:	DESCRIPTION:	DATE:

DRAWING:
ELECTRICAL SERVICES
GAMING ROOM & AMENITIES FLOOR PLAN

SCALE:
1:50 & 1:100

AT A1

PROJECT NO:
C3419a

DRAWING NO:
E04

REVISION:
A