




**PART PLAN**  
JOINERY LIGHTING  
SCALE 1:100

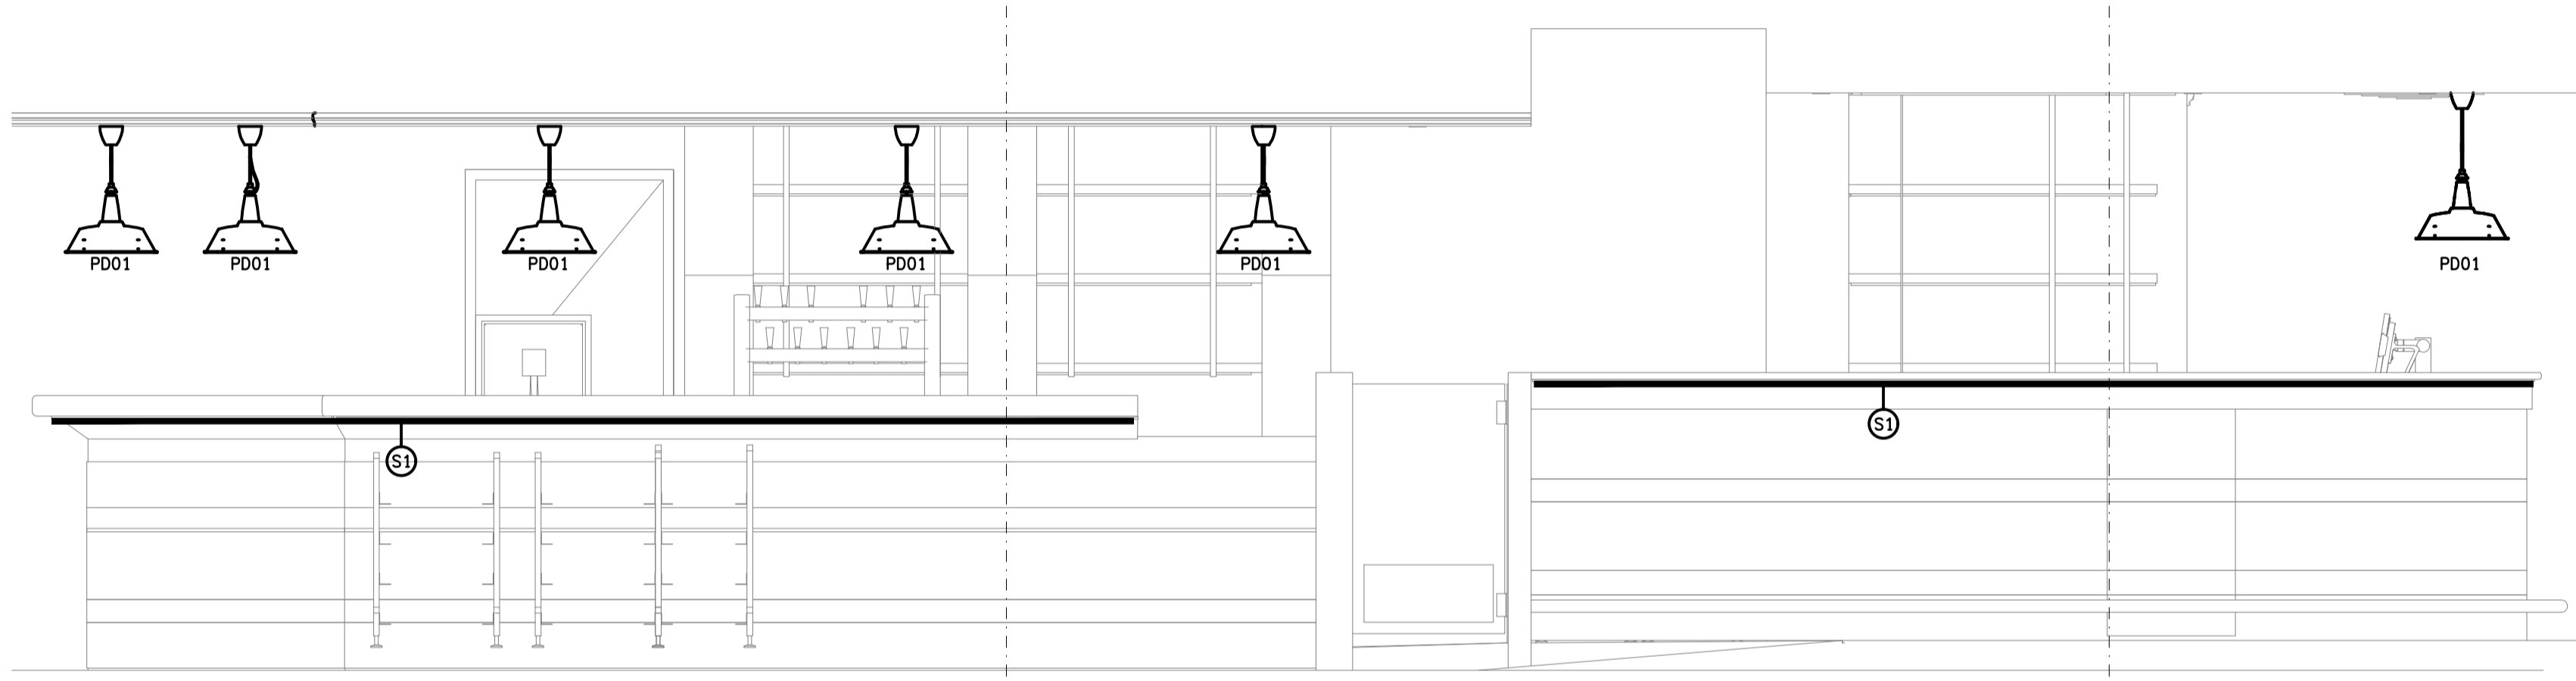


**DETAIL C**  
BISTRO FRONT COUNTER ELEVATION  
SCALE 1:25

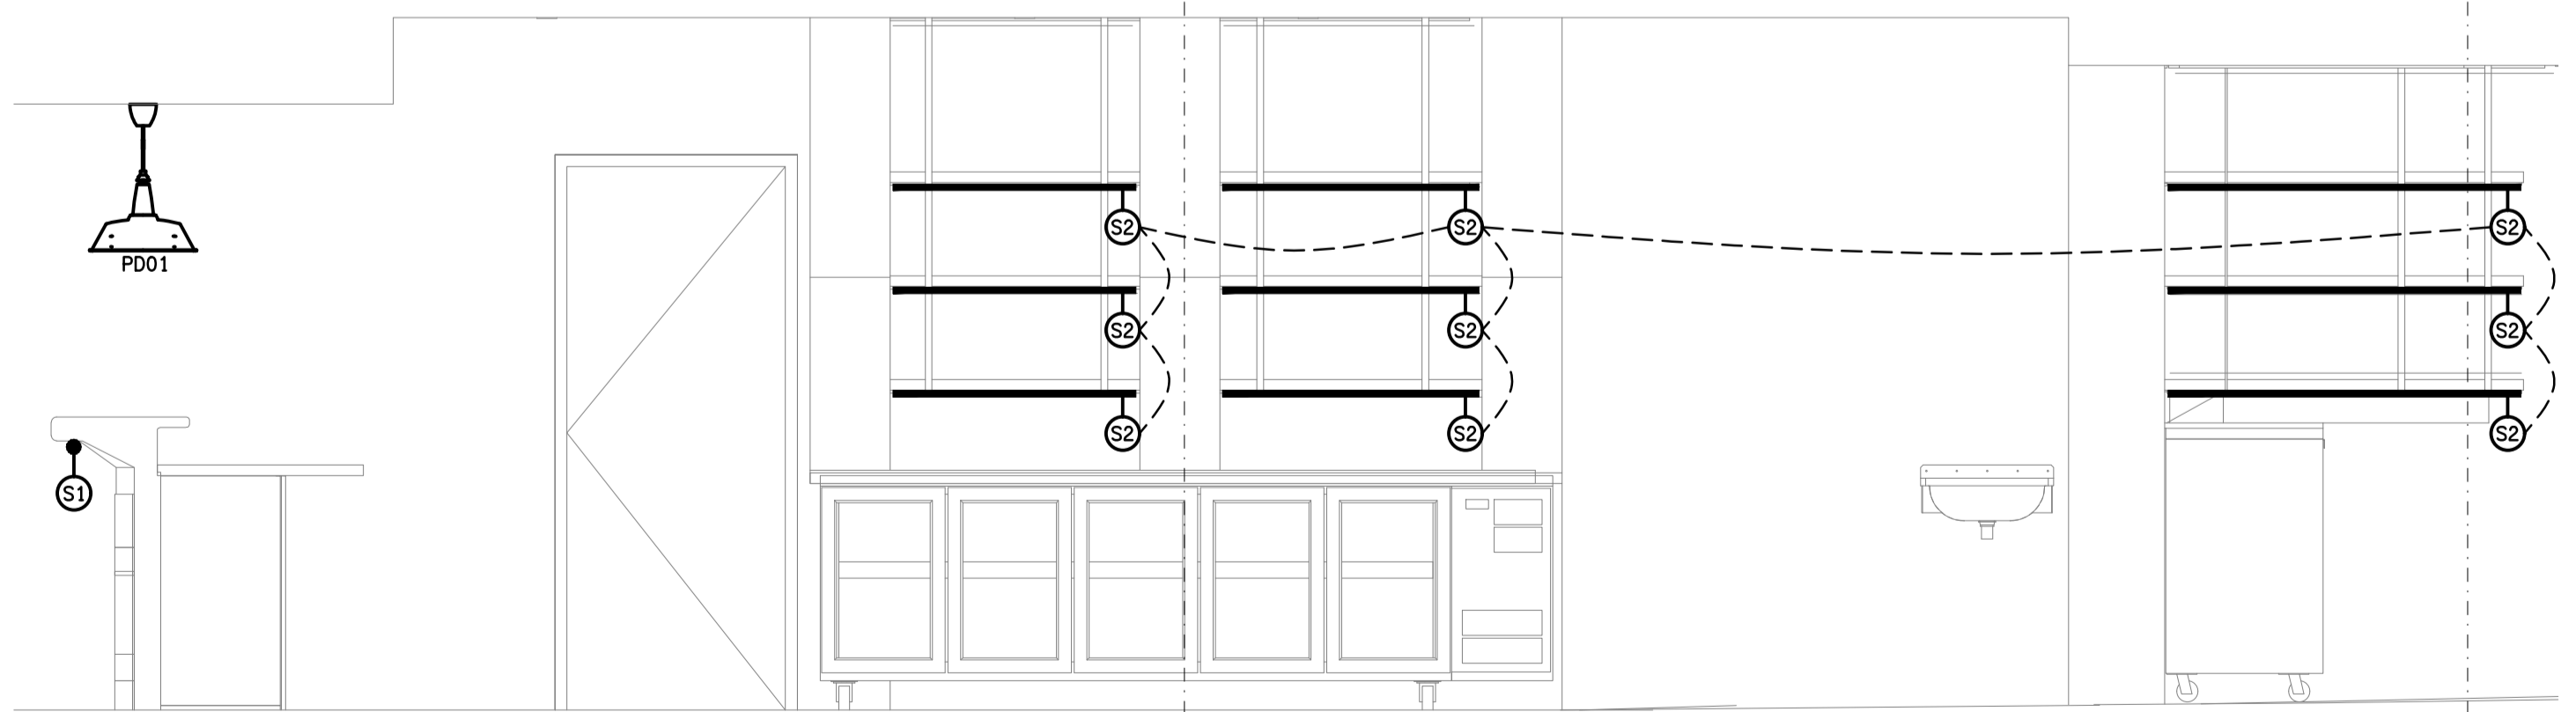


**DETAIL D**  
BISTRO REAR WALL ELEVATION 1  
SCALE 1:25

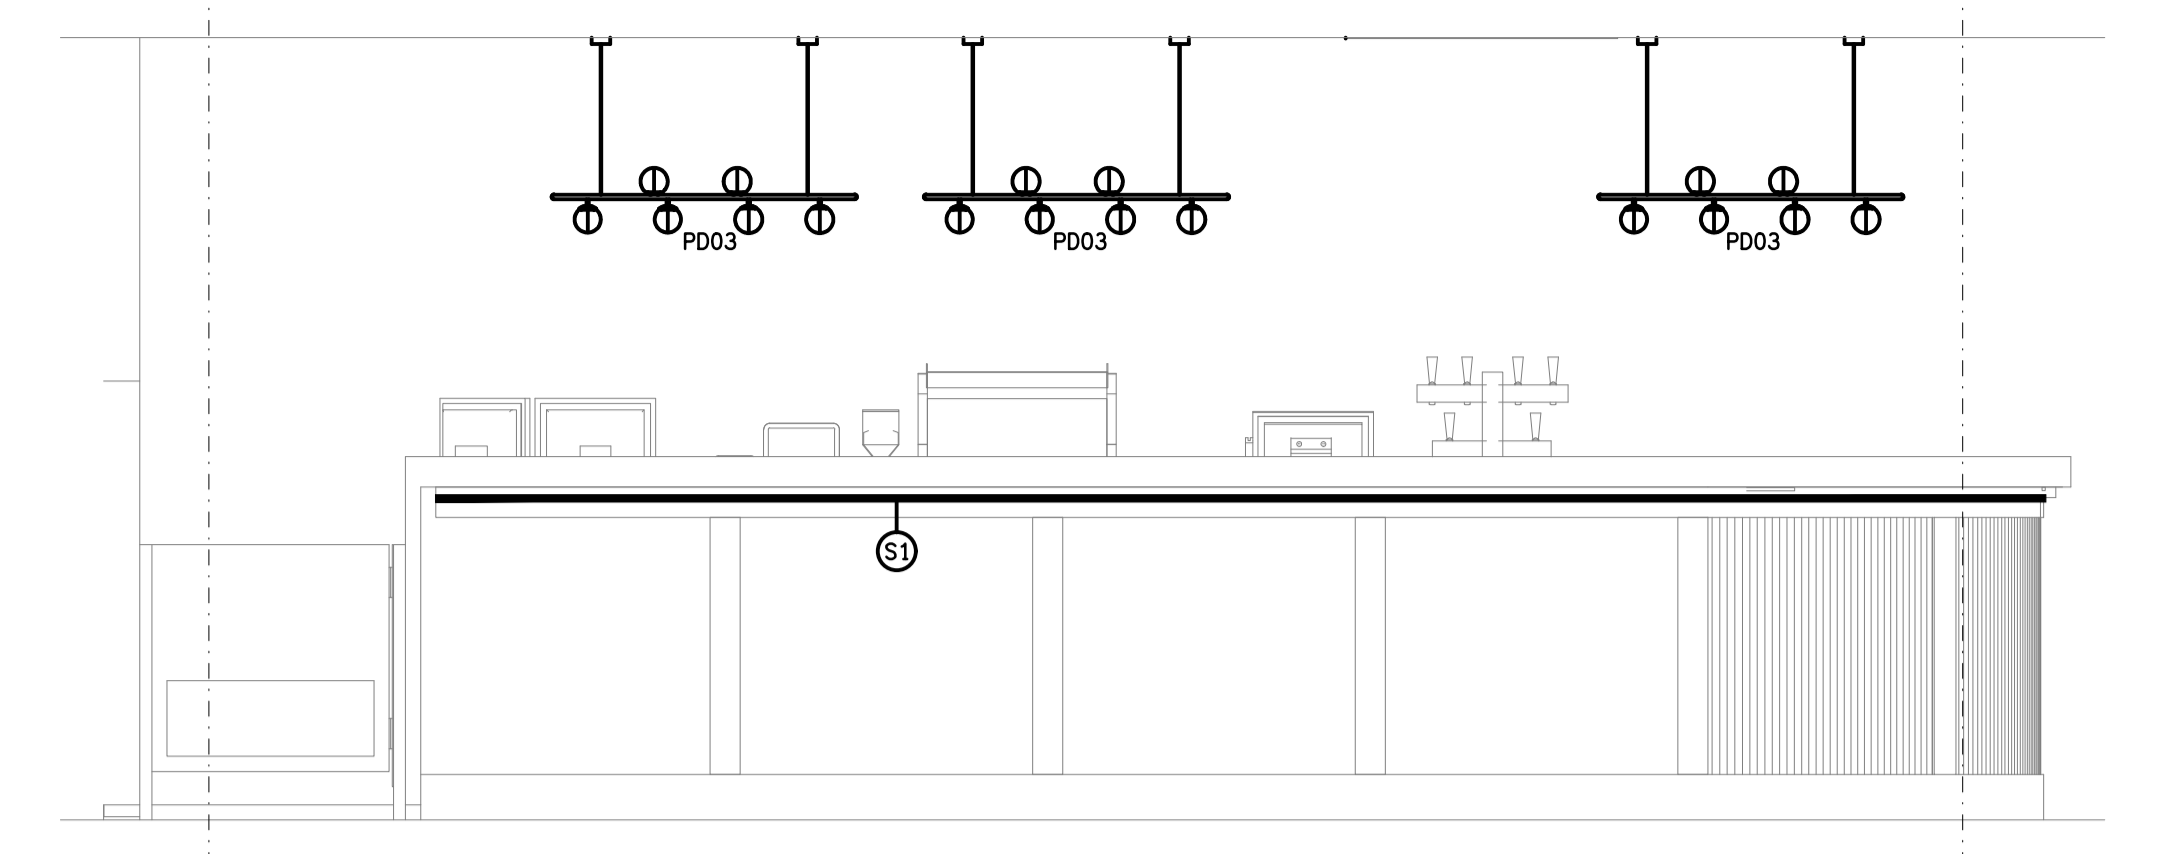

**DETAIL A**  
GAMING FRONT COUNTER ELEVATION  
SCALE 1:25

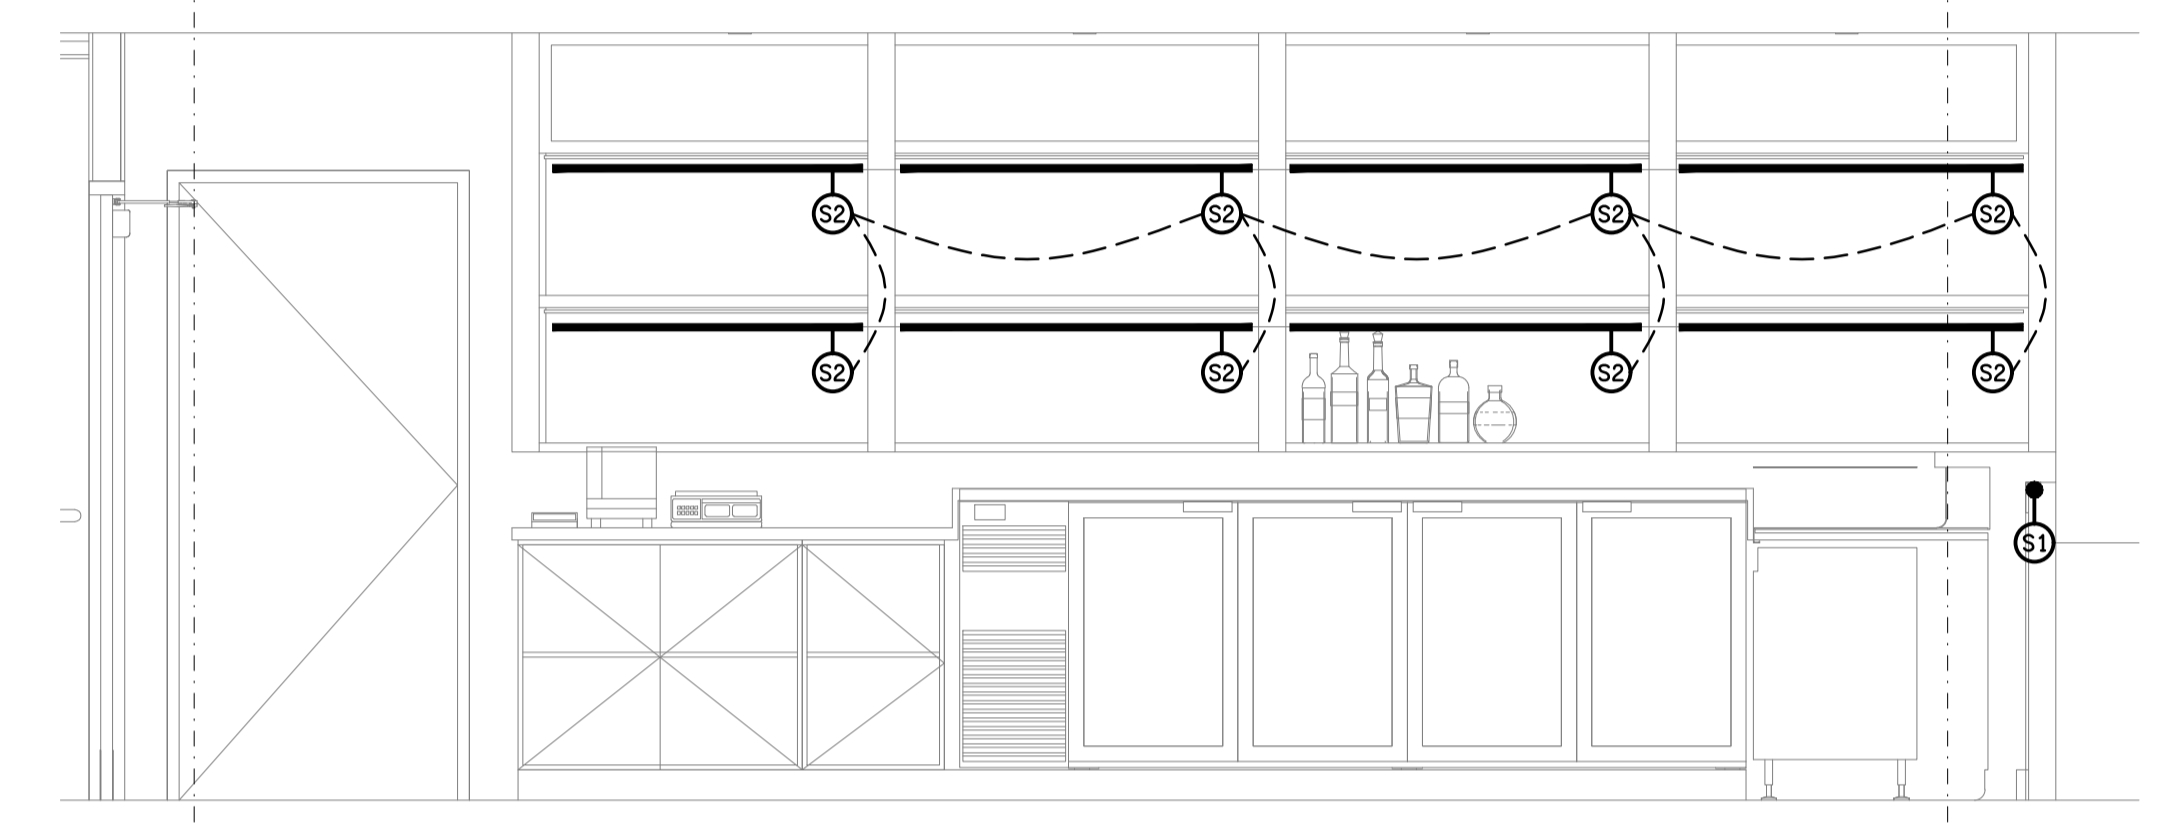

**DETAIL B**  
GAMING REAR WALL ELEVATION  
SCALE 1:25

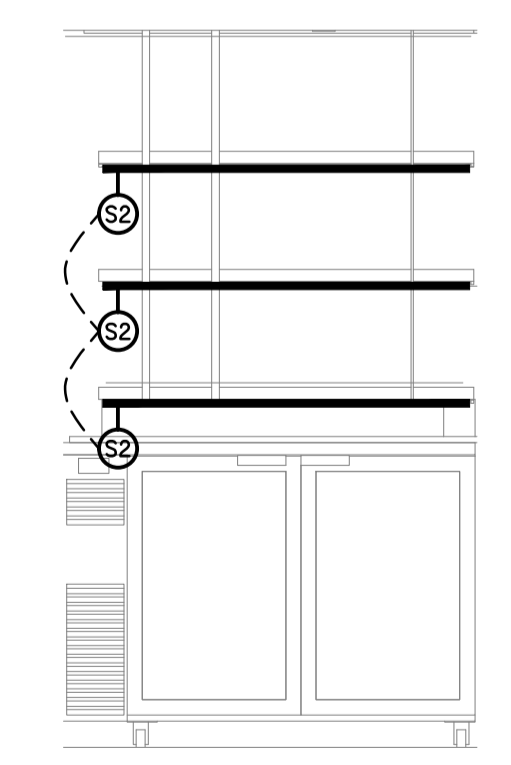

**DETAIL E**  
BISTRO REAR WALL ELEVATION 2  
SCALE 1:25

ELECTRICAL DESIGN GROUP BRISBANE  
PTY LTD  
ACN 092 710 793  
TRADING AS:  
ELECTRICAL DESIGN GROUP

THE COPYRIGHT OF THIS DRAWING  
REMAINS THE PROPERTY OF THE  
ELECTRICAL DESIGN GROUP.  
USE FIGURED DIMENSIONS  
IN PREFERENCE TO SCALE.  
ALL DIMENSIONS TO BE  
VERIFIED ONSITE.

**ELECTRICAL DESIGN GROUP**  
ELECTRICAL BUILDING SERVICES CONSULTANTS  
BRISBANE GOLD COAST  
P.O. Box 15, Sherwood Q.4075  
Phone: (07) 3278 4375  
Email: brisbane@edg.net.au  
Web: www.edg.net.au

PROJECT:  
**PRINCE OF WALES HOTEL, NUNDAH**  
100 BUCKLAND ROAD, NUNDAH

A	PRELIMINARY	19/02/2025
REV:	DESCRIPTION:	DATE:
DRAWING: <b>ELECTRICAL SERVICES JOINERY LIGHTING PLAN</b>		
SCALE: 1:100 & 1:25	PROJECT NO: <b>C3419a</b>	DRAWING NO: <b>E06</b>
AT A1	REVISION: <b>A</b>	