


**BUILDING 1**  
**FLOOR PLAN**  
 SCALE 1:50

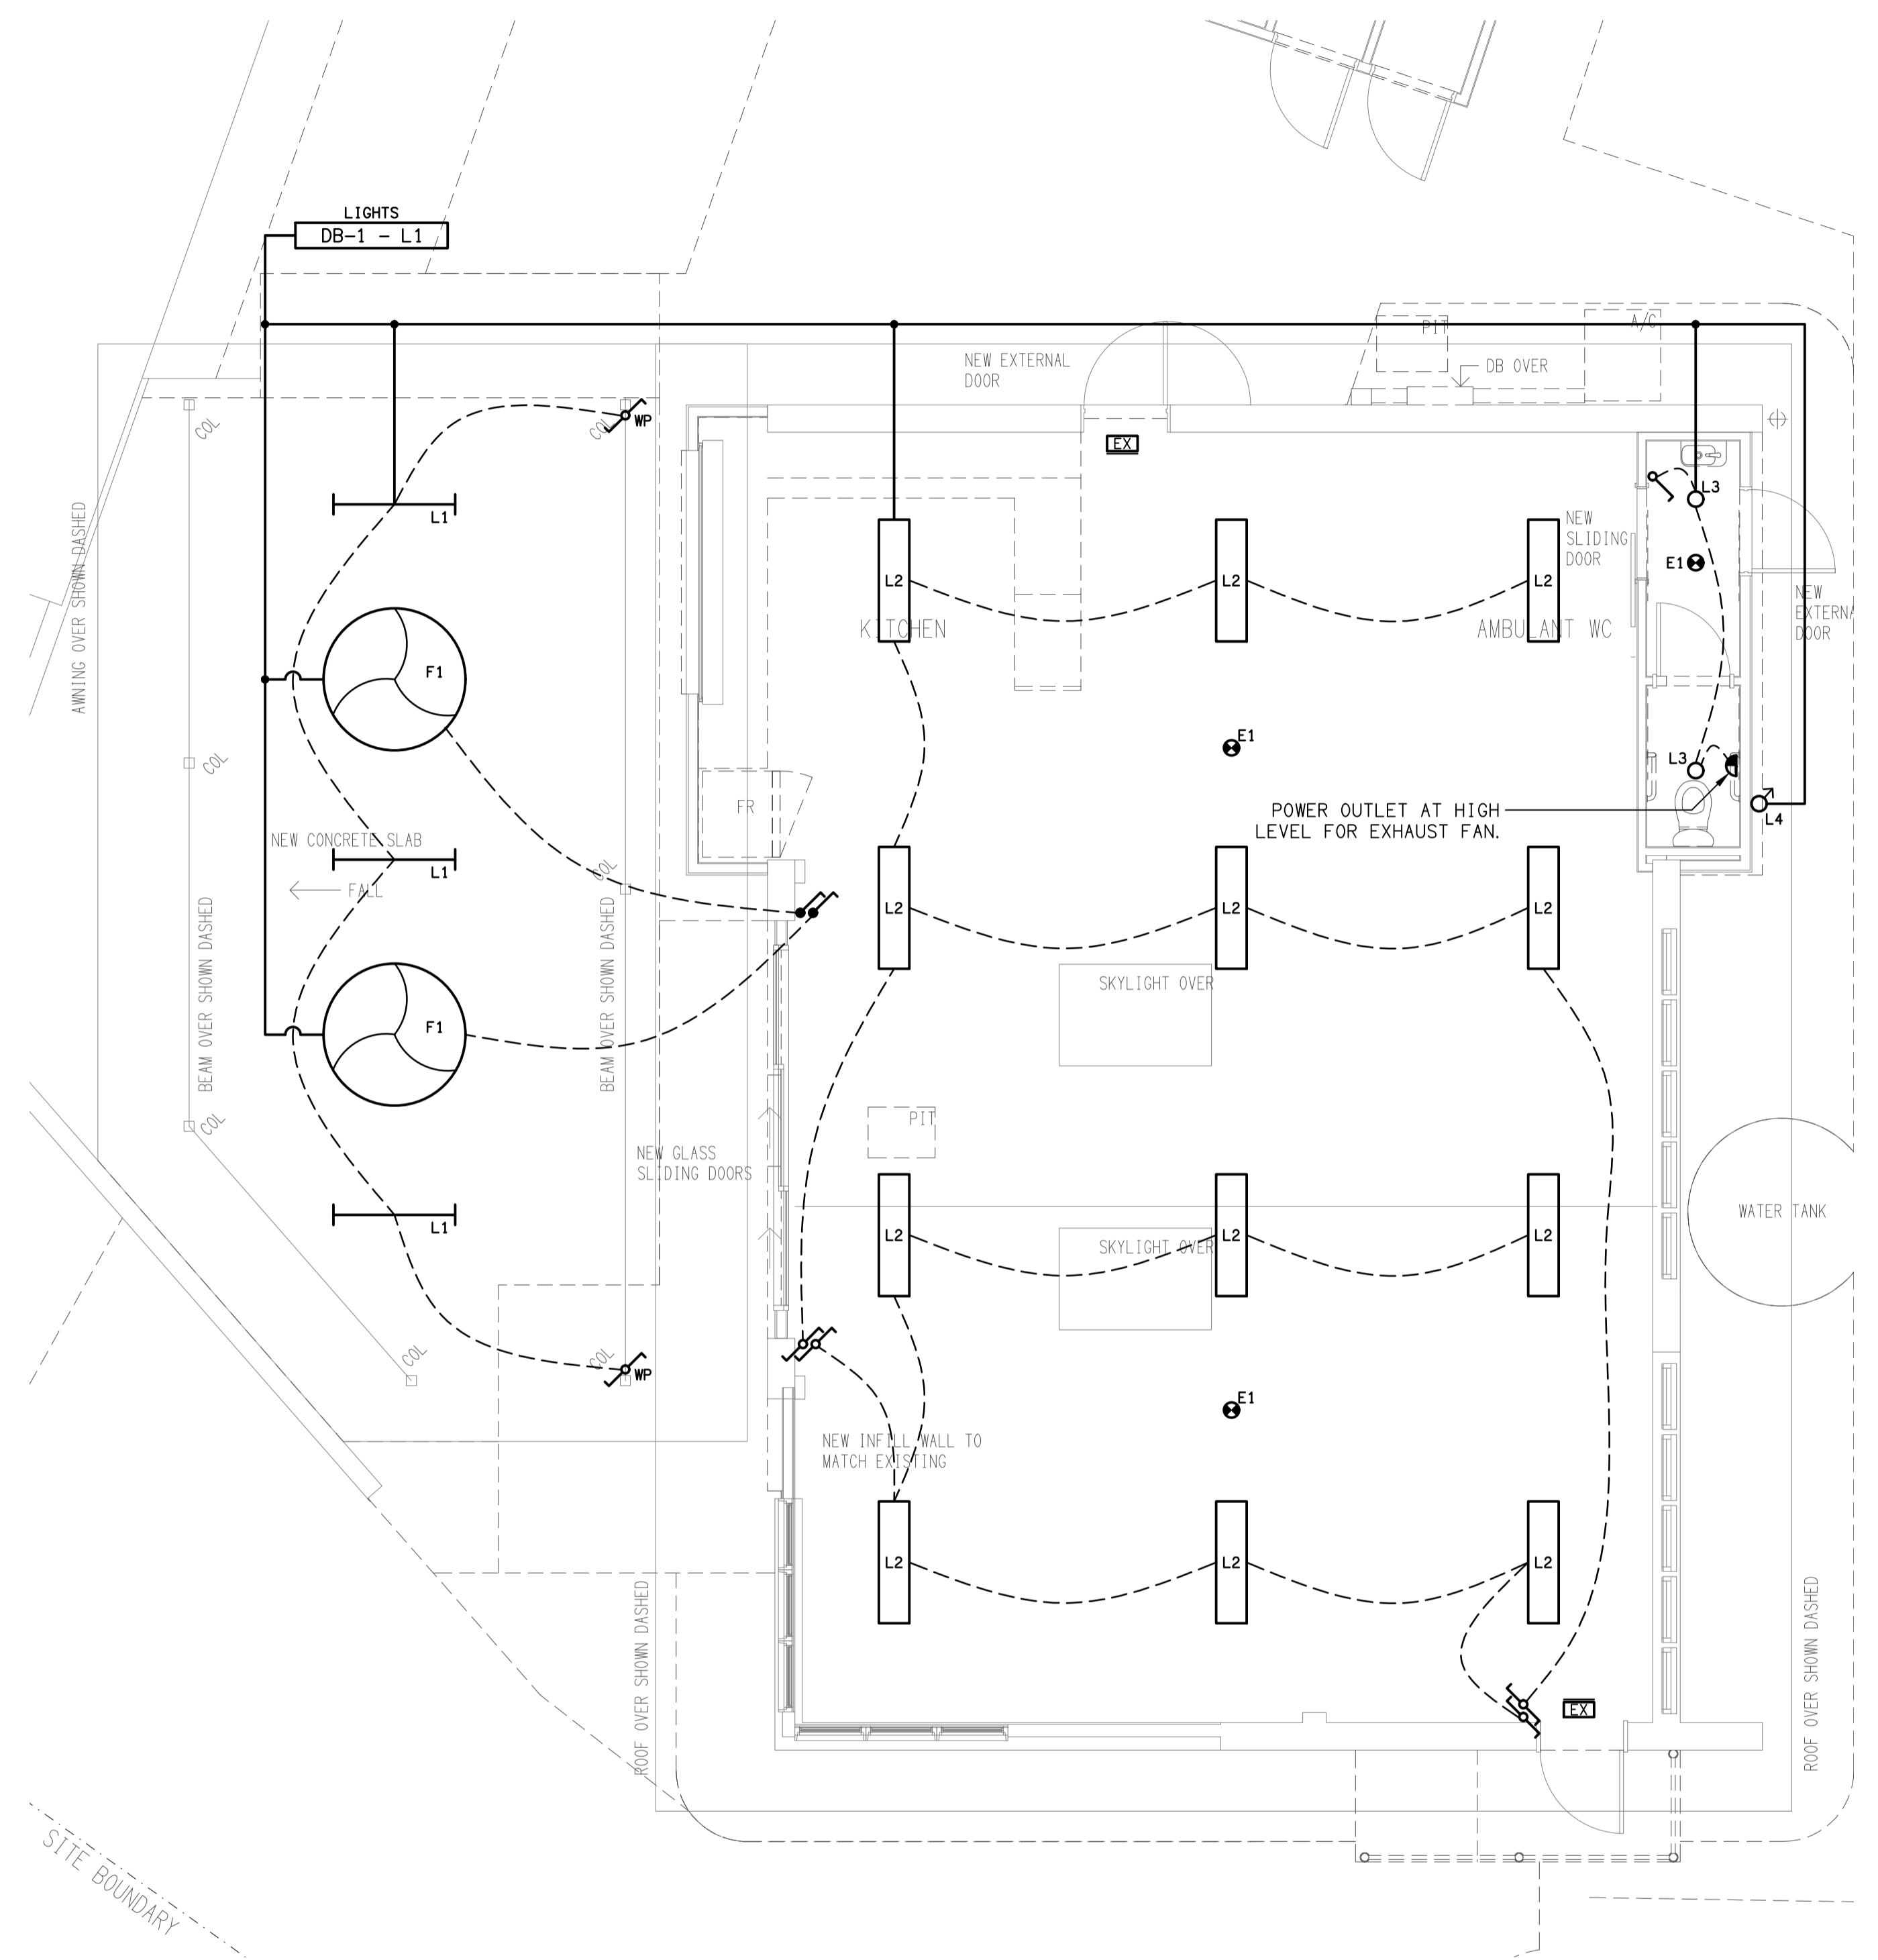

**BUILDING 1**  
**REFLECTED CEILING PLAN**  
 SCALE 1:50

ELECTRICAL DESIGN GROUP BRISBANE  
 PTY LTD  
 ACN 092 710 793  
 TRADING AS:  
 ELECTRICAL DESIGN GROUP

THE COPYRIGHT OF THIS DRAWING  
 REMAINS THE PROPERTY OF THE  
 ELECTRICAL DESIGN GROUP.  
 USE FIGURED DIMENSIONS  
 IN PREFERENCE TO SCALE.  
 ALL DIMENSIONS TO BE  
 VERIFIED ONSITE.

**ELECTRICAL DESIGN GROUP**  
 ELECTRICAL BUILDING SERVICES CONSULTANTS  
 BRISBANE GOLD COAST  
 P.O. Box 15, Sherwood Q.4075  
 Phone: (07) 3278 4375  
 Email: brisbane@edg.net.au  
 Web: www.edg.net.au

PROJECT:  
**KENMORE COMMUNITY CENTRE**  
 98 BROOKFIELD ROAD, KENMORE HILLS

B	TENDER	06/02/2025
REV.	DESCRIPTION:	DATE:
DRAWING: <b>ELECTRICAL SERVICES BUILDING 1 PLANS</b>		
SCALE: 1:50	AT A1	PROJECT NO: <b>C3425a</b>
		DRAWING NO: <b>E04</b>
		REVISION: <b>B</b>