


**BUILDING 3**  
FLOOR / REFLECTED CEILING PLAN  
SCALE 1:50

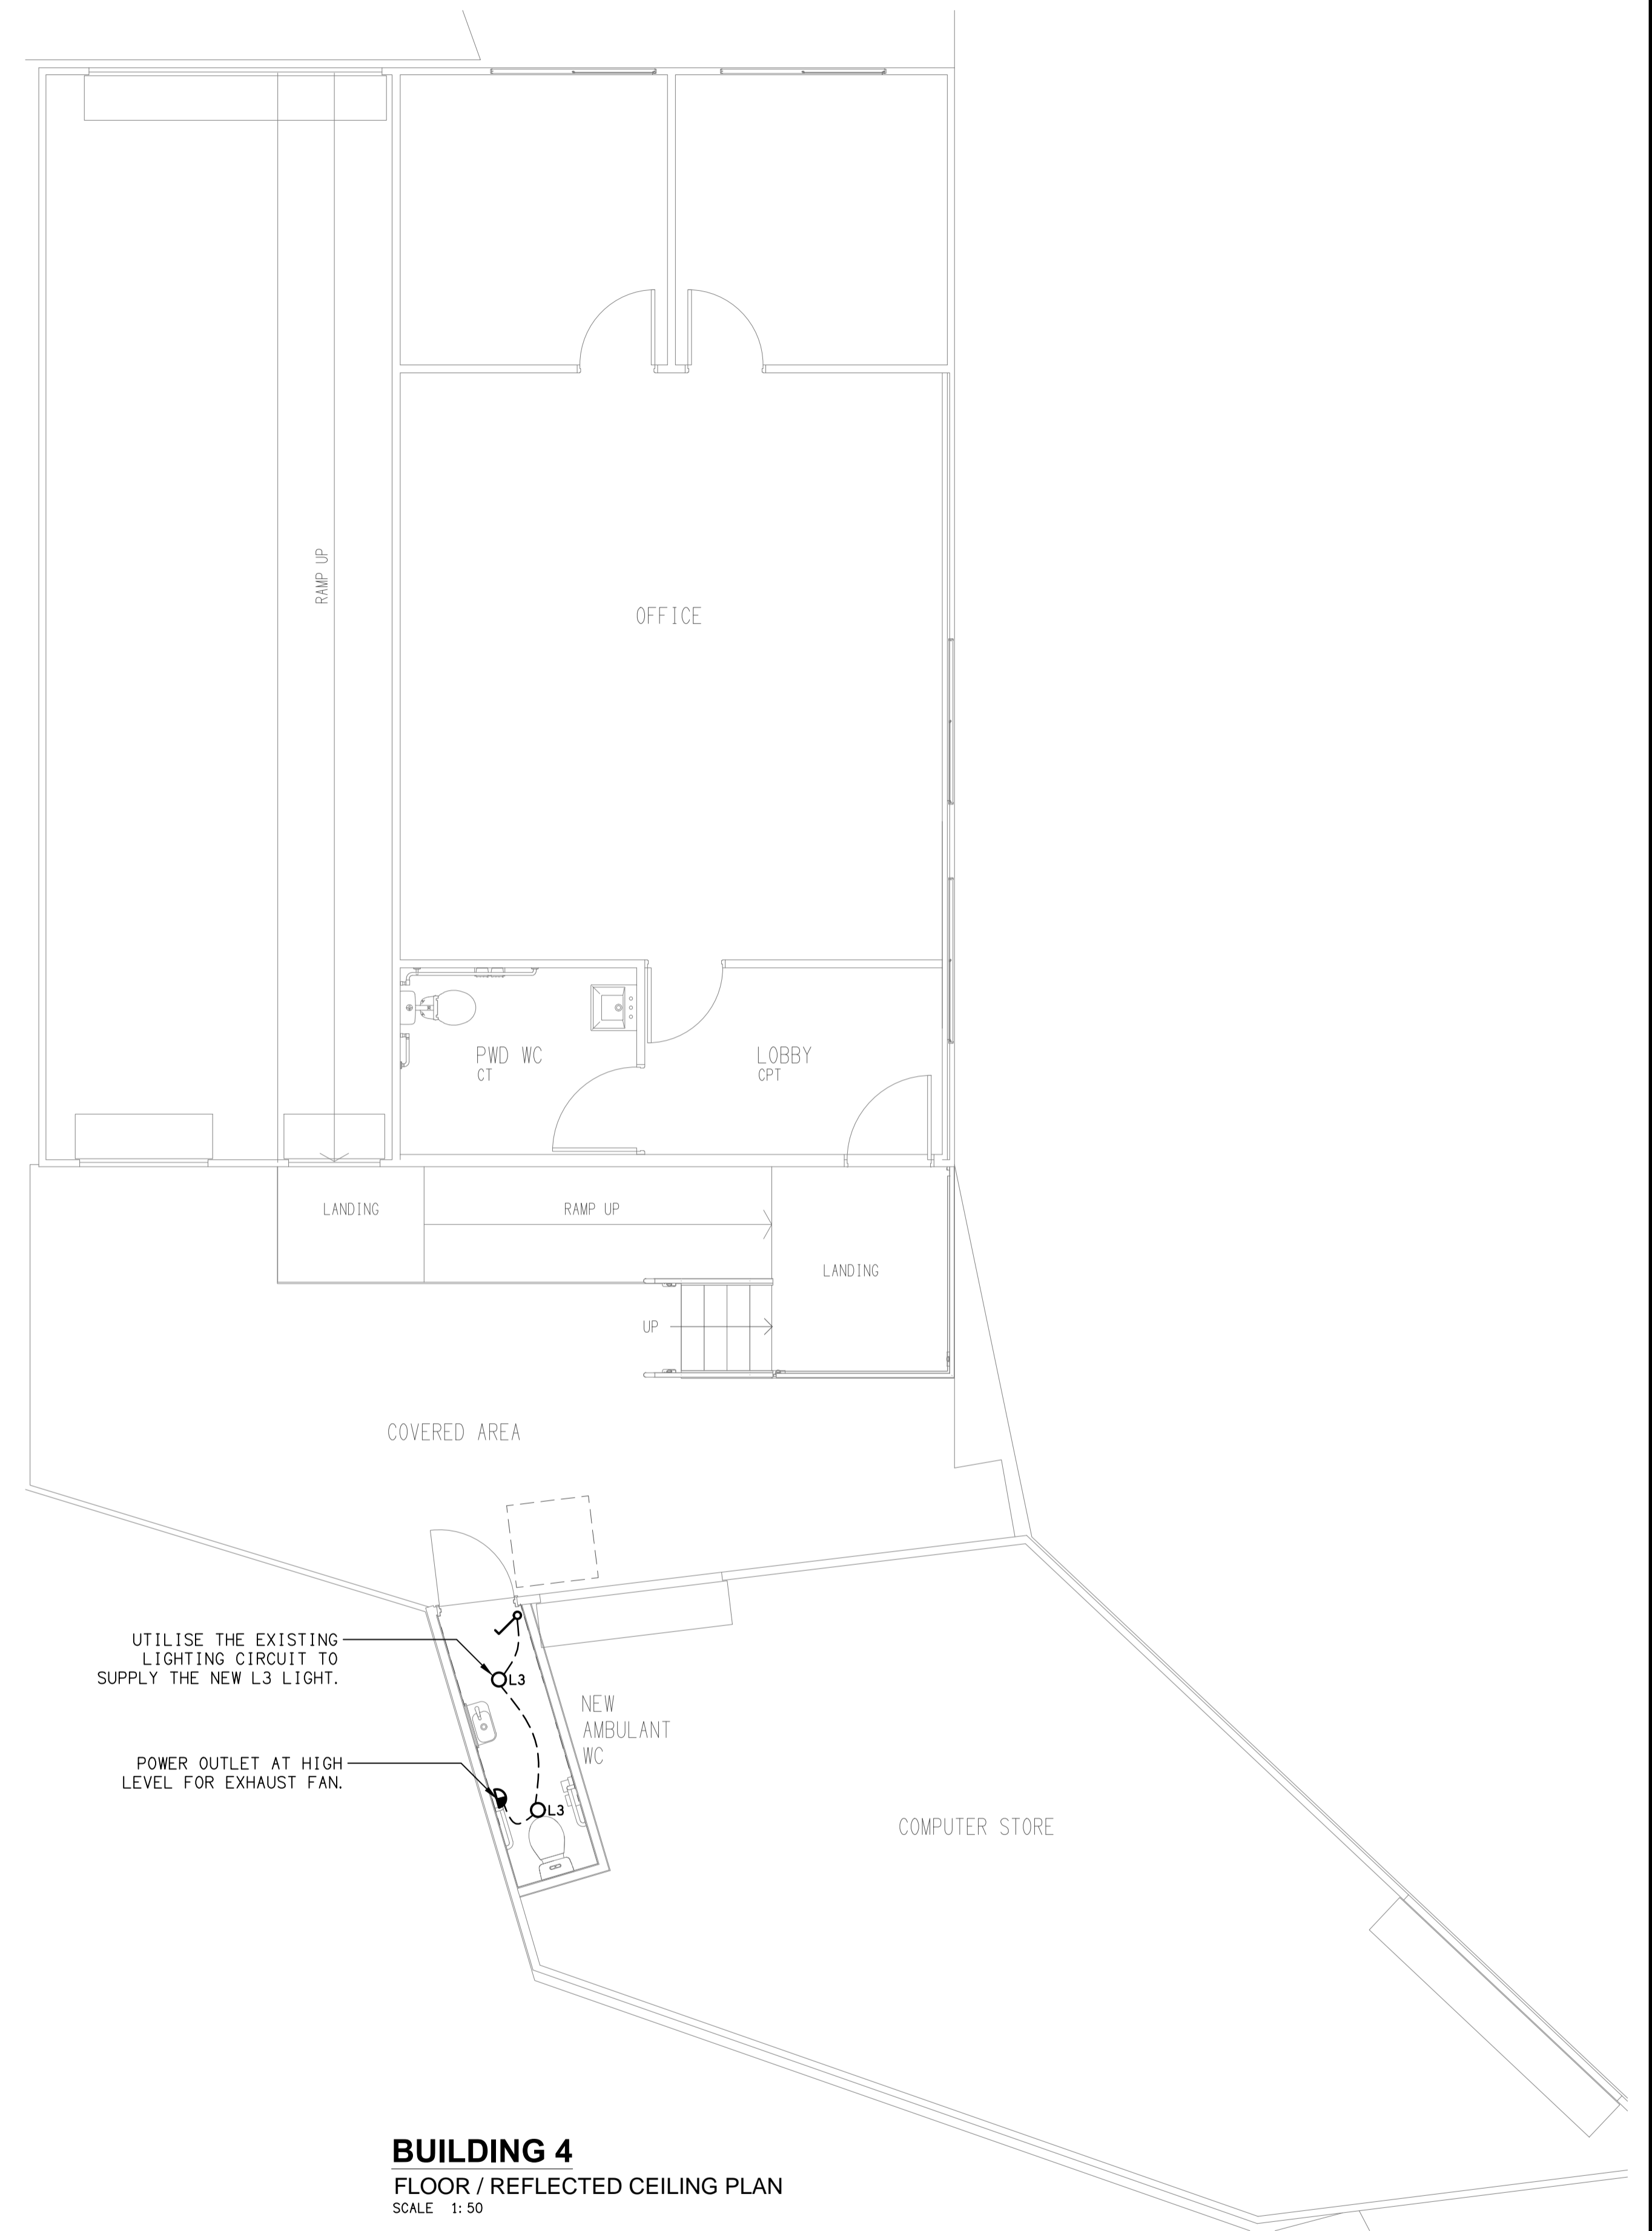

**BUILDING 4**  
FLOOR / REFLECTED CEILING PLAN  
SCALE 1:50

ELECTRICAL DESIGN GROUP BRISBANE  
PTY LTD  
ACN 092 710 793  
TRADING AS:  
ELECTRICAL DESIGN GROUP

THE COPYRIGHT OF THIS DRAWING  
REMAINS THE PROPERTY OF THE  
ELECTRICAL DESIGN GROUP.  
USE FIGURED DIMENSIONS  
IN PREFERENCE TO SCALE.  
ALL DIMENSIONS TO BE  
VERIFIED ONSITE.

**ELECTRICAL DESIGN GROUP**  
ELECTRICAL BUILDING SERVICES CONSULTANTS  
BRISBANE GOLD COAST

P.O.Box 15, Sherwood Q.4075  
Phone: (07) 3278 4375  
Email: brisbane@edg.net.au  
Web: www.edg.net.au

PROJECT:  
**KENMORE COMMUNITY CENTRE**

98 BROOKFIELD ROAD, KENMORE HILLS

B	TENDER	06/02/2025
REV:	DESCRIPTION:	DATE:

DRAWING:  
**ELECTRICAL SERVICES  
BUILDING 3 & 4 PLANS**

SCALE:  
1:50

AT A1

PROJECT NO:  
**C3425a**

DRAWING NO:  
**E06**

REVISION:  
**B**