


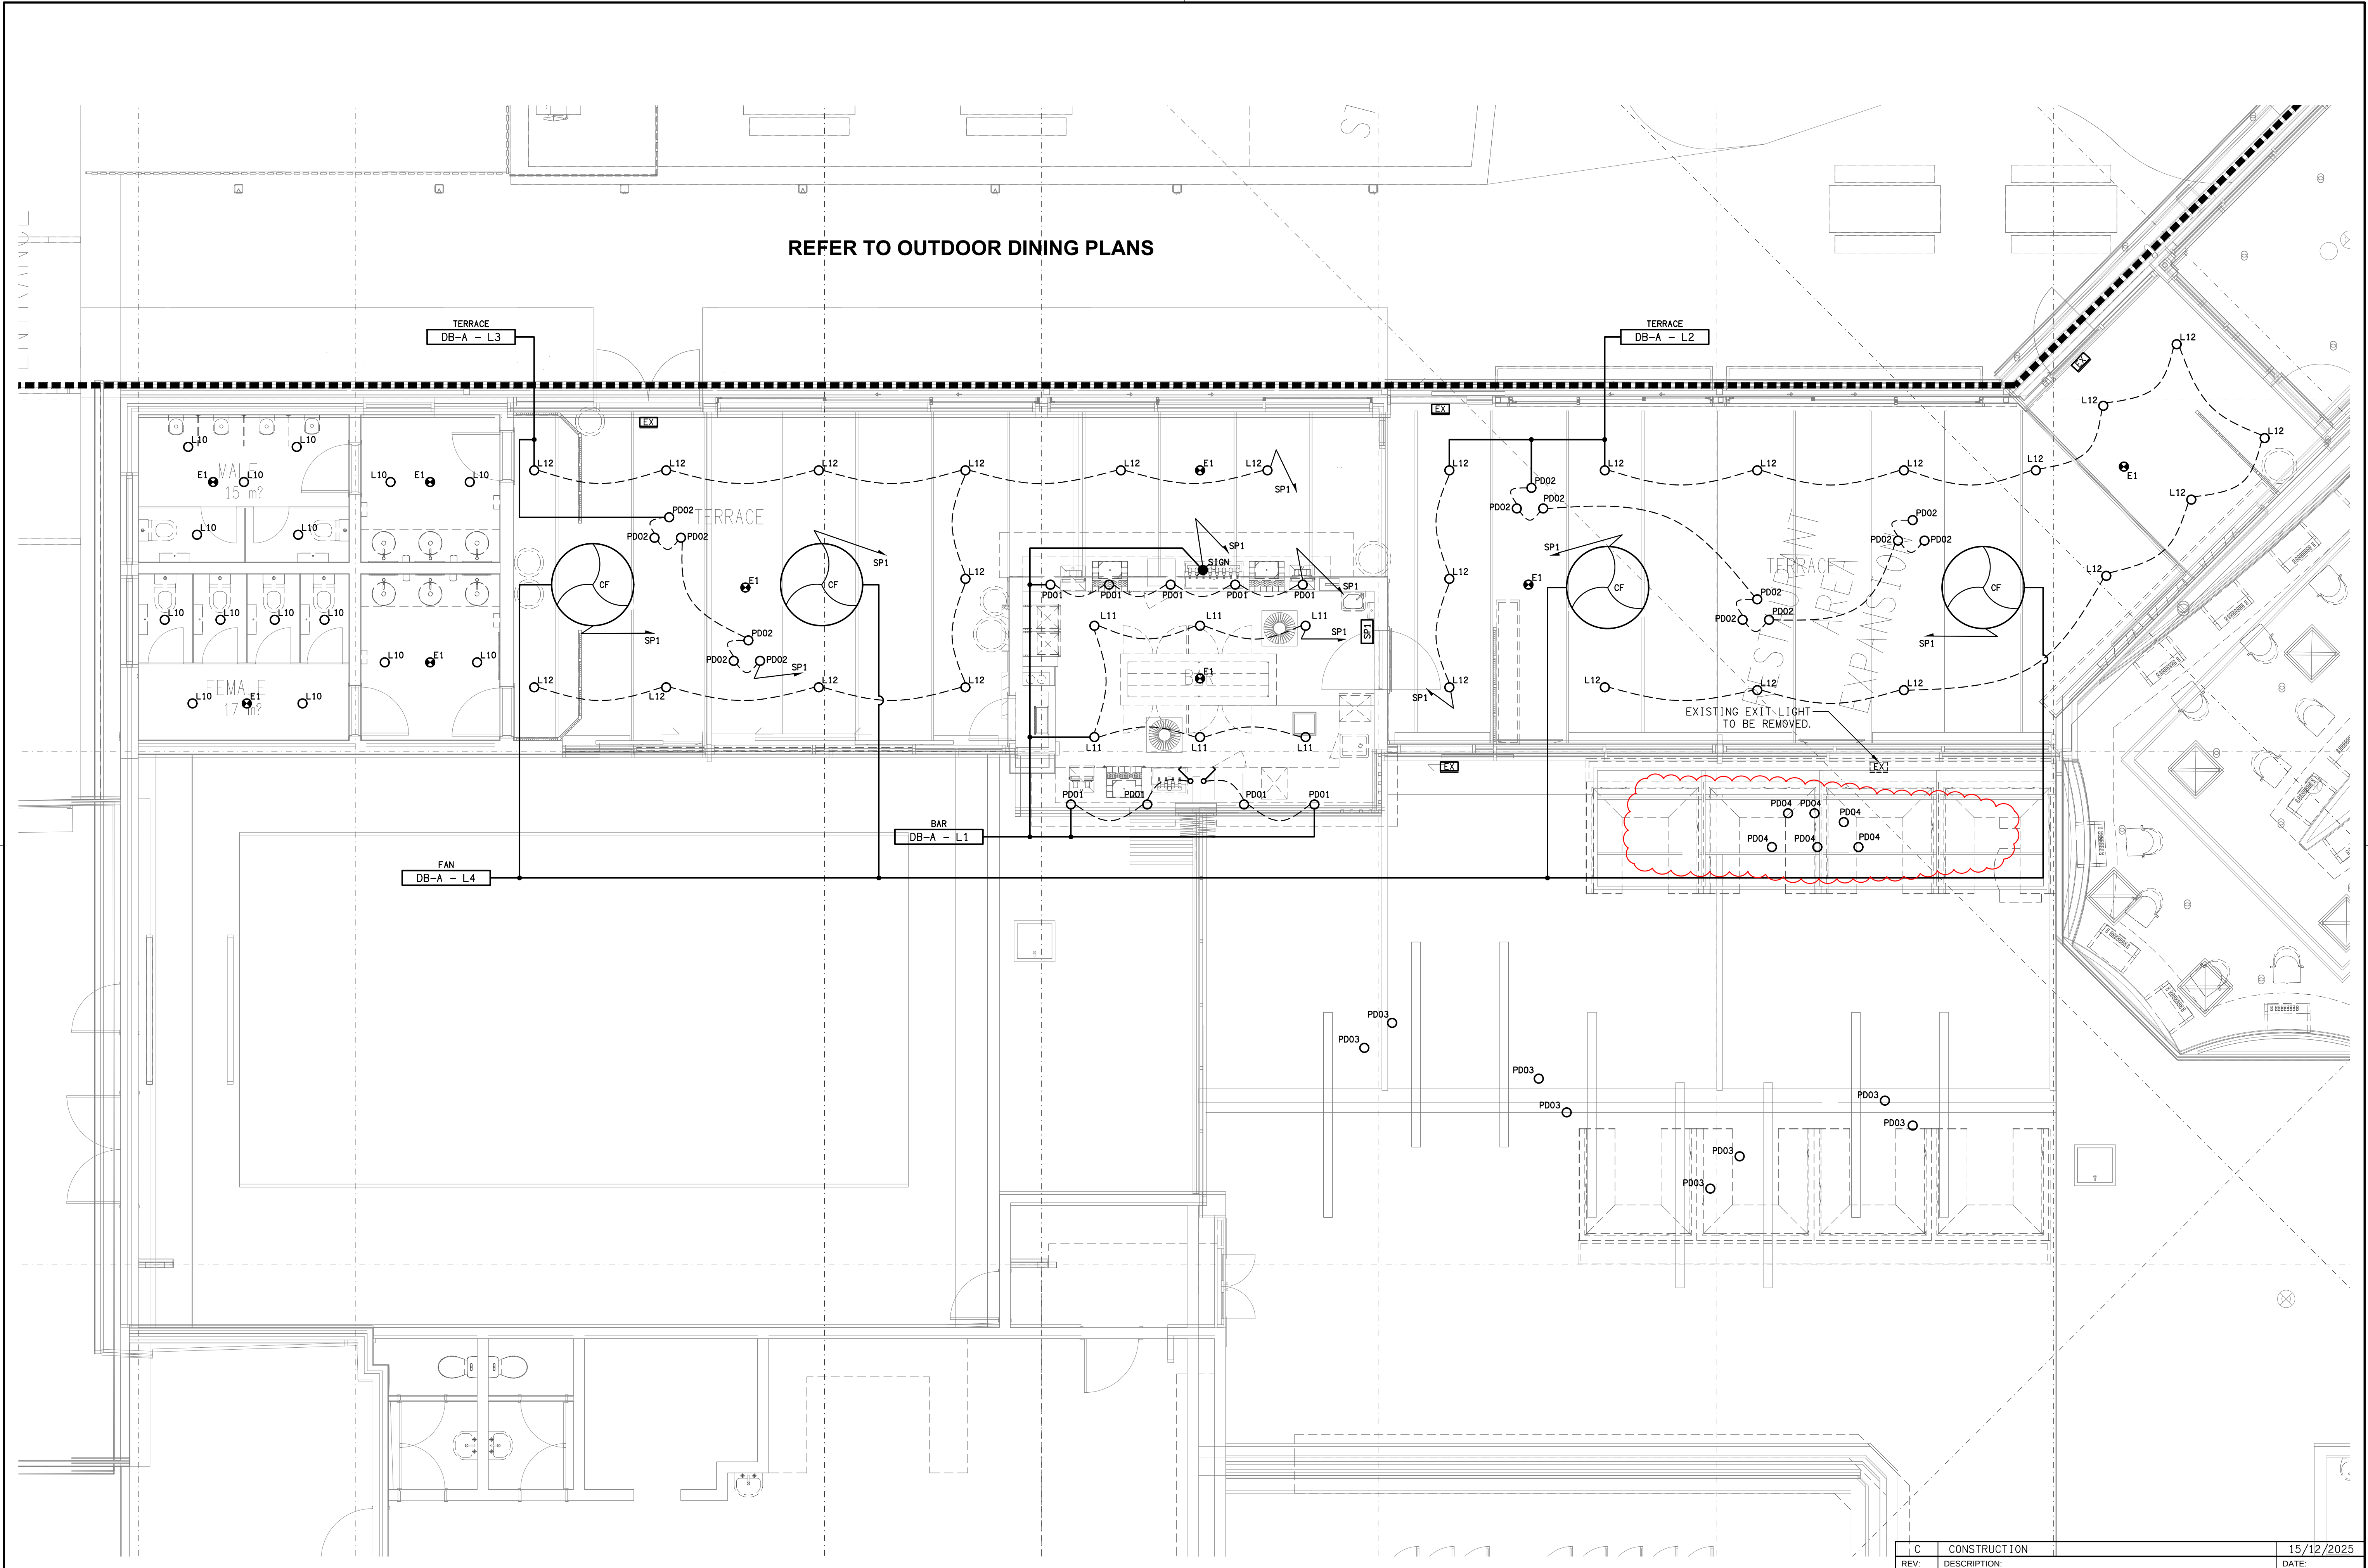

ELECTRICAL DESIGN GROUP BRISBANE PTY LTD ACN 092 710 793 TRADING AS: ELECTRICAL DESIGN GROUP	THE COPYRIGHT OF THIS DRAWING REMAINS THE PROPERTY OF THE ELECTRICAL DESIGN GROUP. USE FIGURED DIMENSIONS IN PREFERENCE TO SCALE. ALL DIMENSIONS TO BE VERIFIED ONSITE.	ELECTRICAL DESIGN GROUP ELECTRICAL BUILDING SERVICES CONSULTANTS BRISBANE GOLD COAST P.O. Box 15, Sherwood Q. 4075 Phone: (07) 3278 4375 Email: brisbane@edg.net.au Web: www.edg.net.au	PROJECT: MARABOON TAVERN, EMERALD 2025 ALTERATIONS CORNER HOSPITAL ROAD & ESMOND STREET, EMERALD	<table><tr><td>C</td><td>CONSTRUCTION</td><td>15/12/2025</td></tr><tr><td>REV:</td><td>DESCRIPTION:</td><td>DATE:</td></tr></table> DRAWING: ELECTRICAL SERVICES TAVERN REFLECTED CEILING PLAN <table><tr><td>SCALE: 1:50 UNO</td><td>AT A1</td><td>PROJECT NO: C3446a</td><td>DRAWING NO: E05</td><td>REVISION: C</td></tr></table>	C	CONSTRUCTION	15/12/2025	REV:	DESCRIPTION:	DATE:	SCALE: 1:50 UNO	AT A1	PROJECT NO: C3446a	DRAWING NO: E05	REVISION: C
C	CONSTRUCTION	15/12/2025													
REV:	DESCRIPTION:	DATE:													
SCALE: 1:50 UNO	AT A1	PROJECT NO: C3446a	DRAWING NO: E05	REVISION: C											