




DETAIL
PCD MOUNTING
NOT TO SCALE

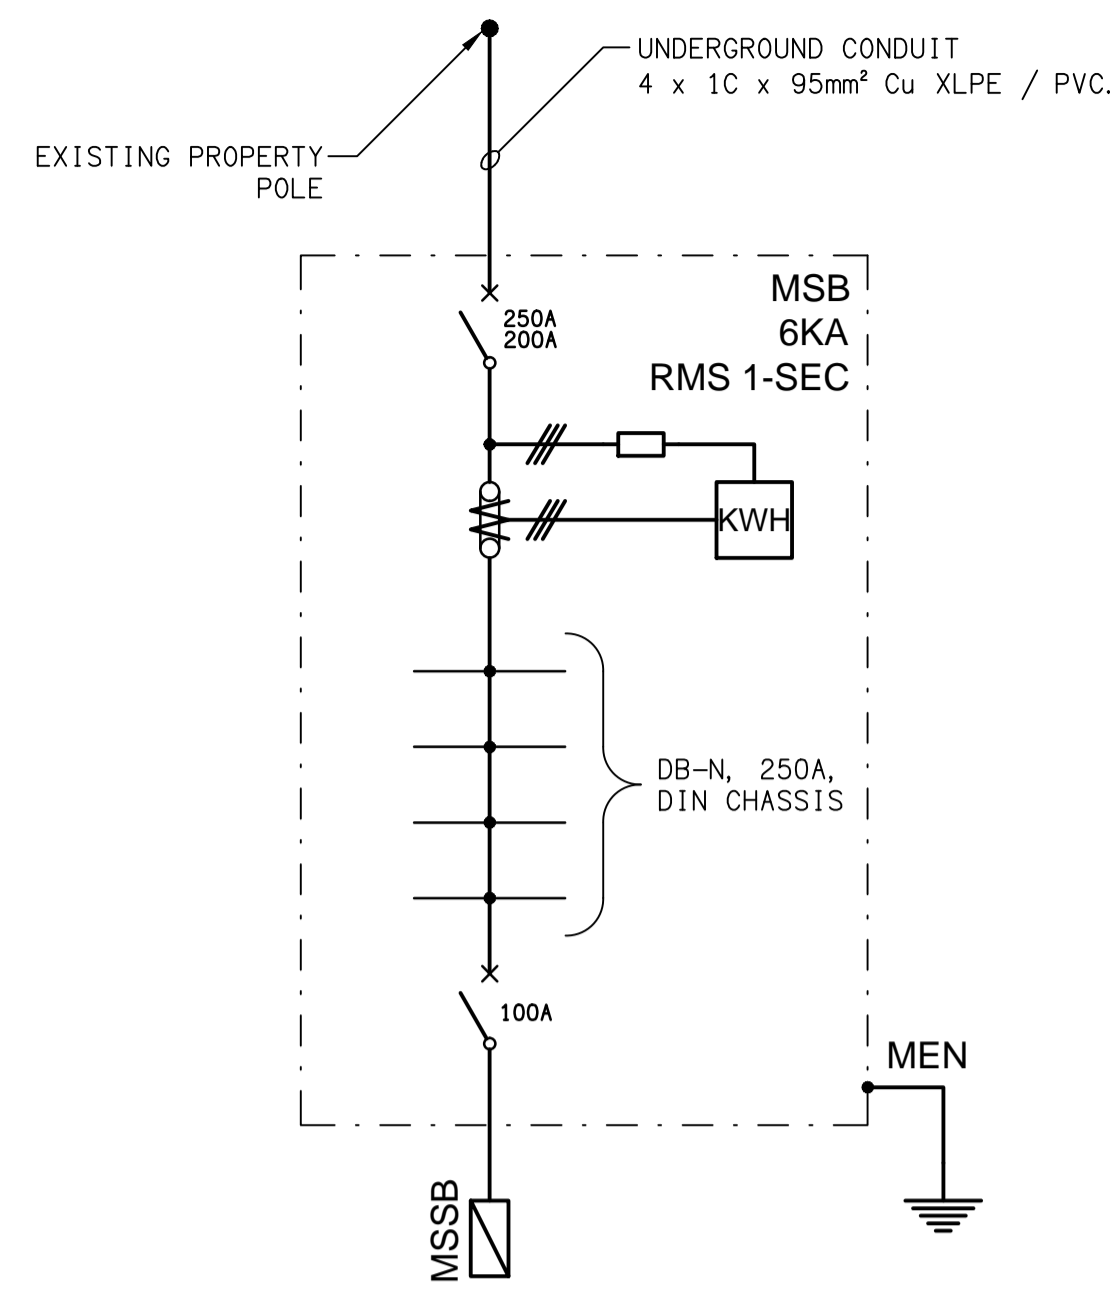

EXISTING SCHEMATIC
POWER CONFIGURATION
NOT TO SCALE

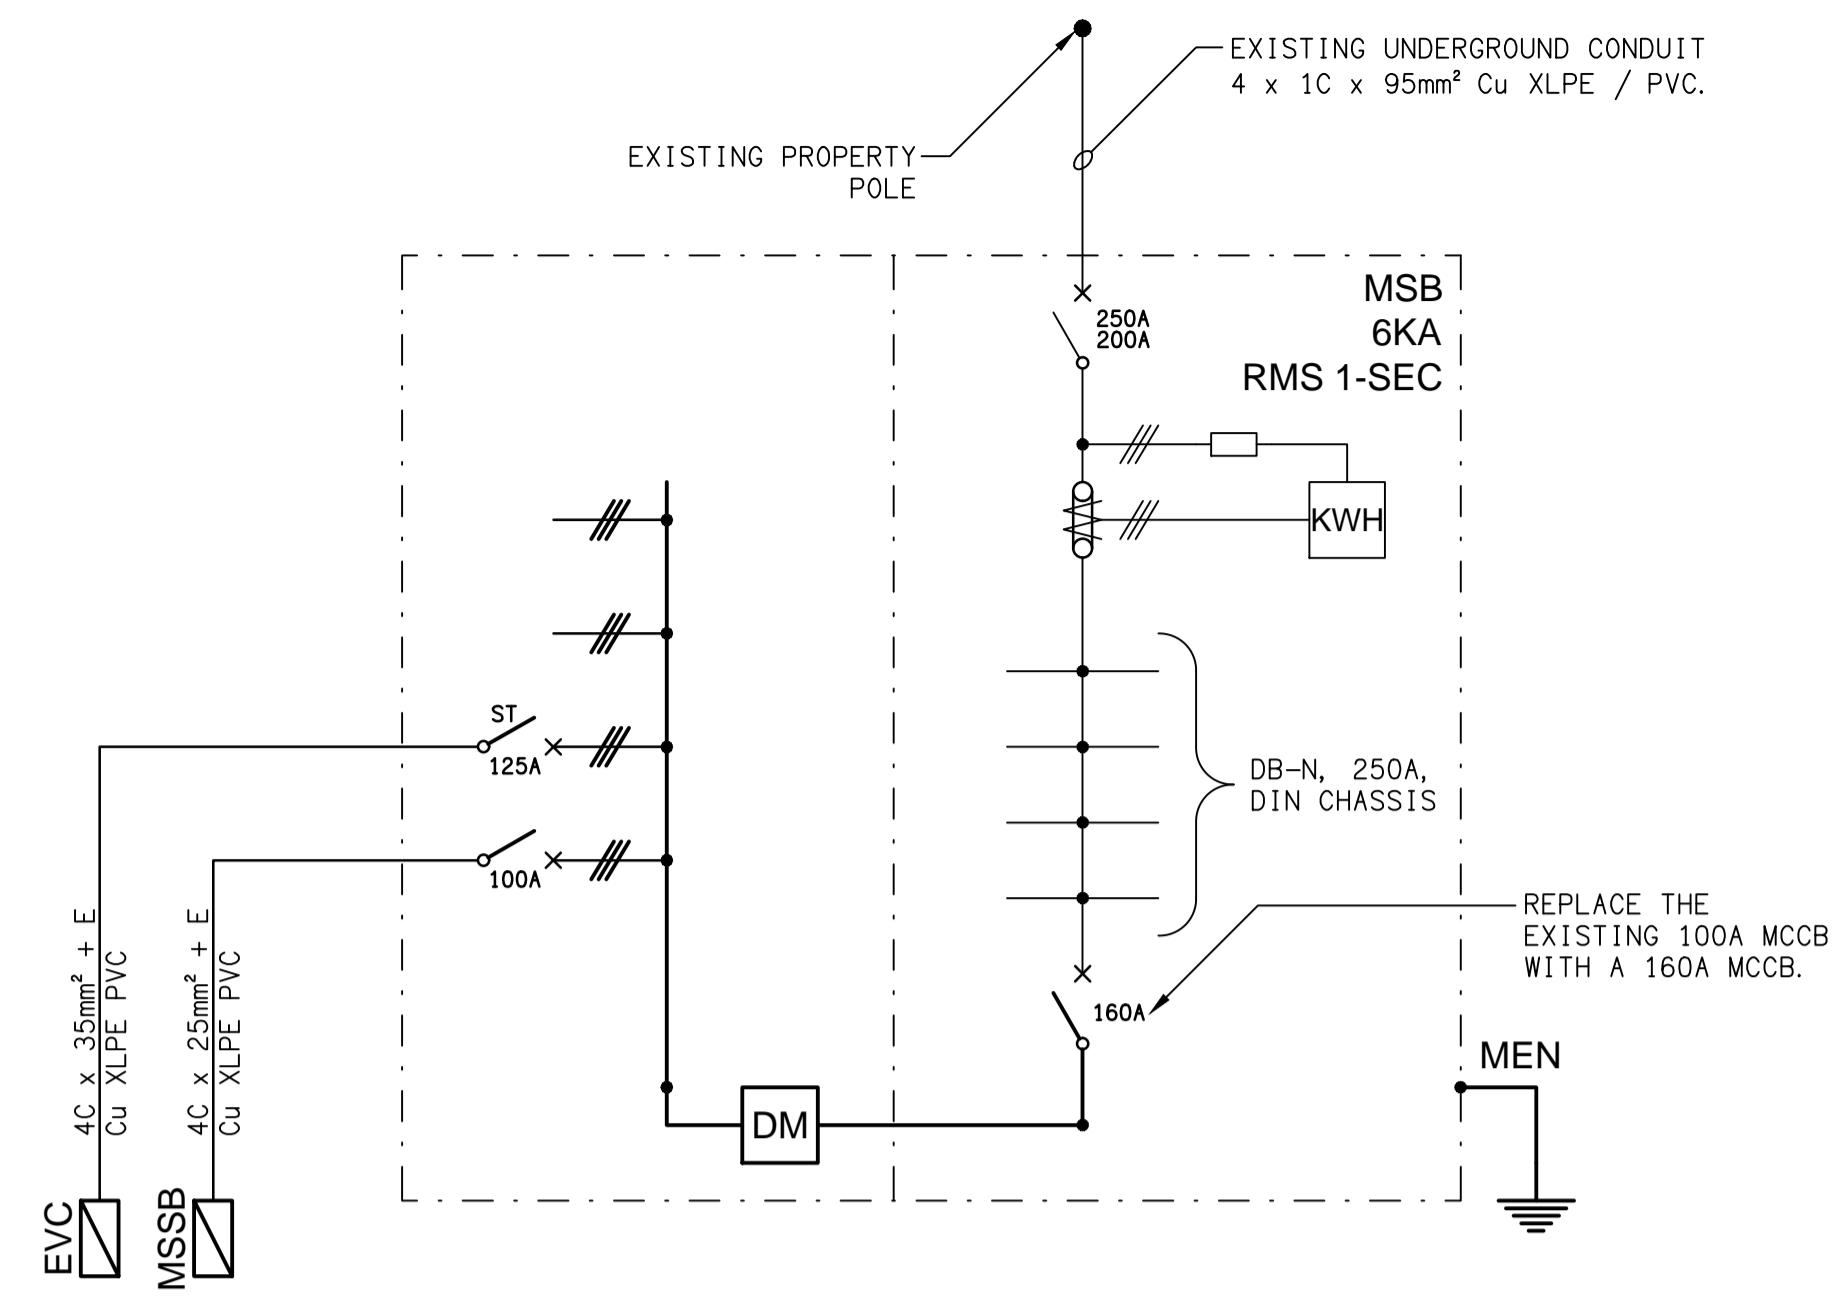

PROPOSED SCHEMATIC
POWER CONFIGURATION
NOT TO SCALE

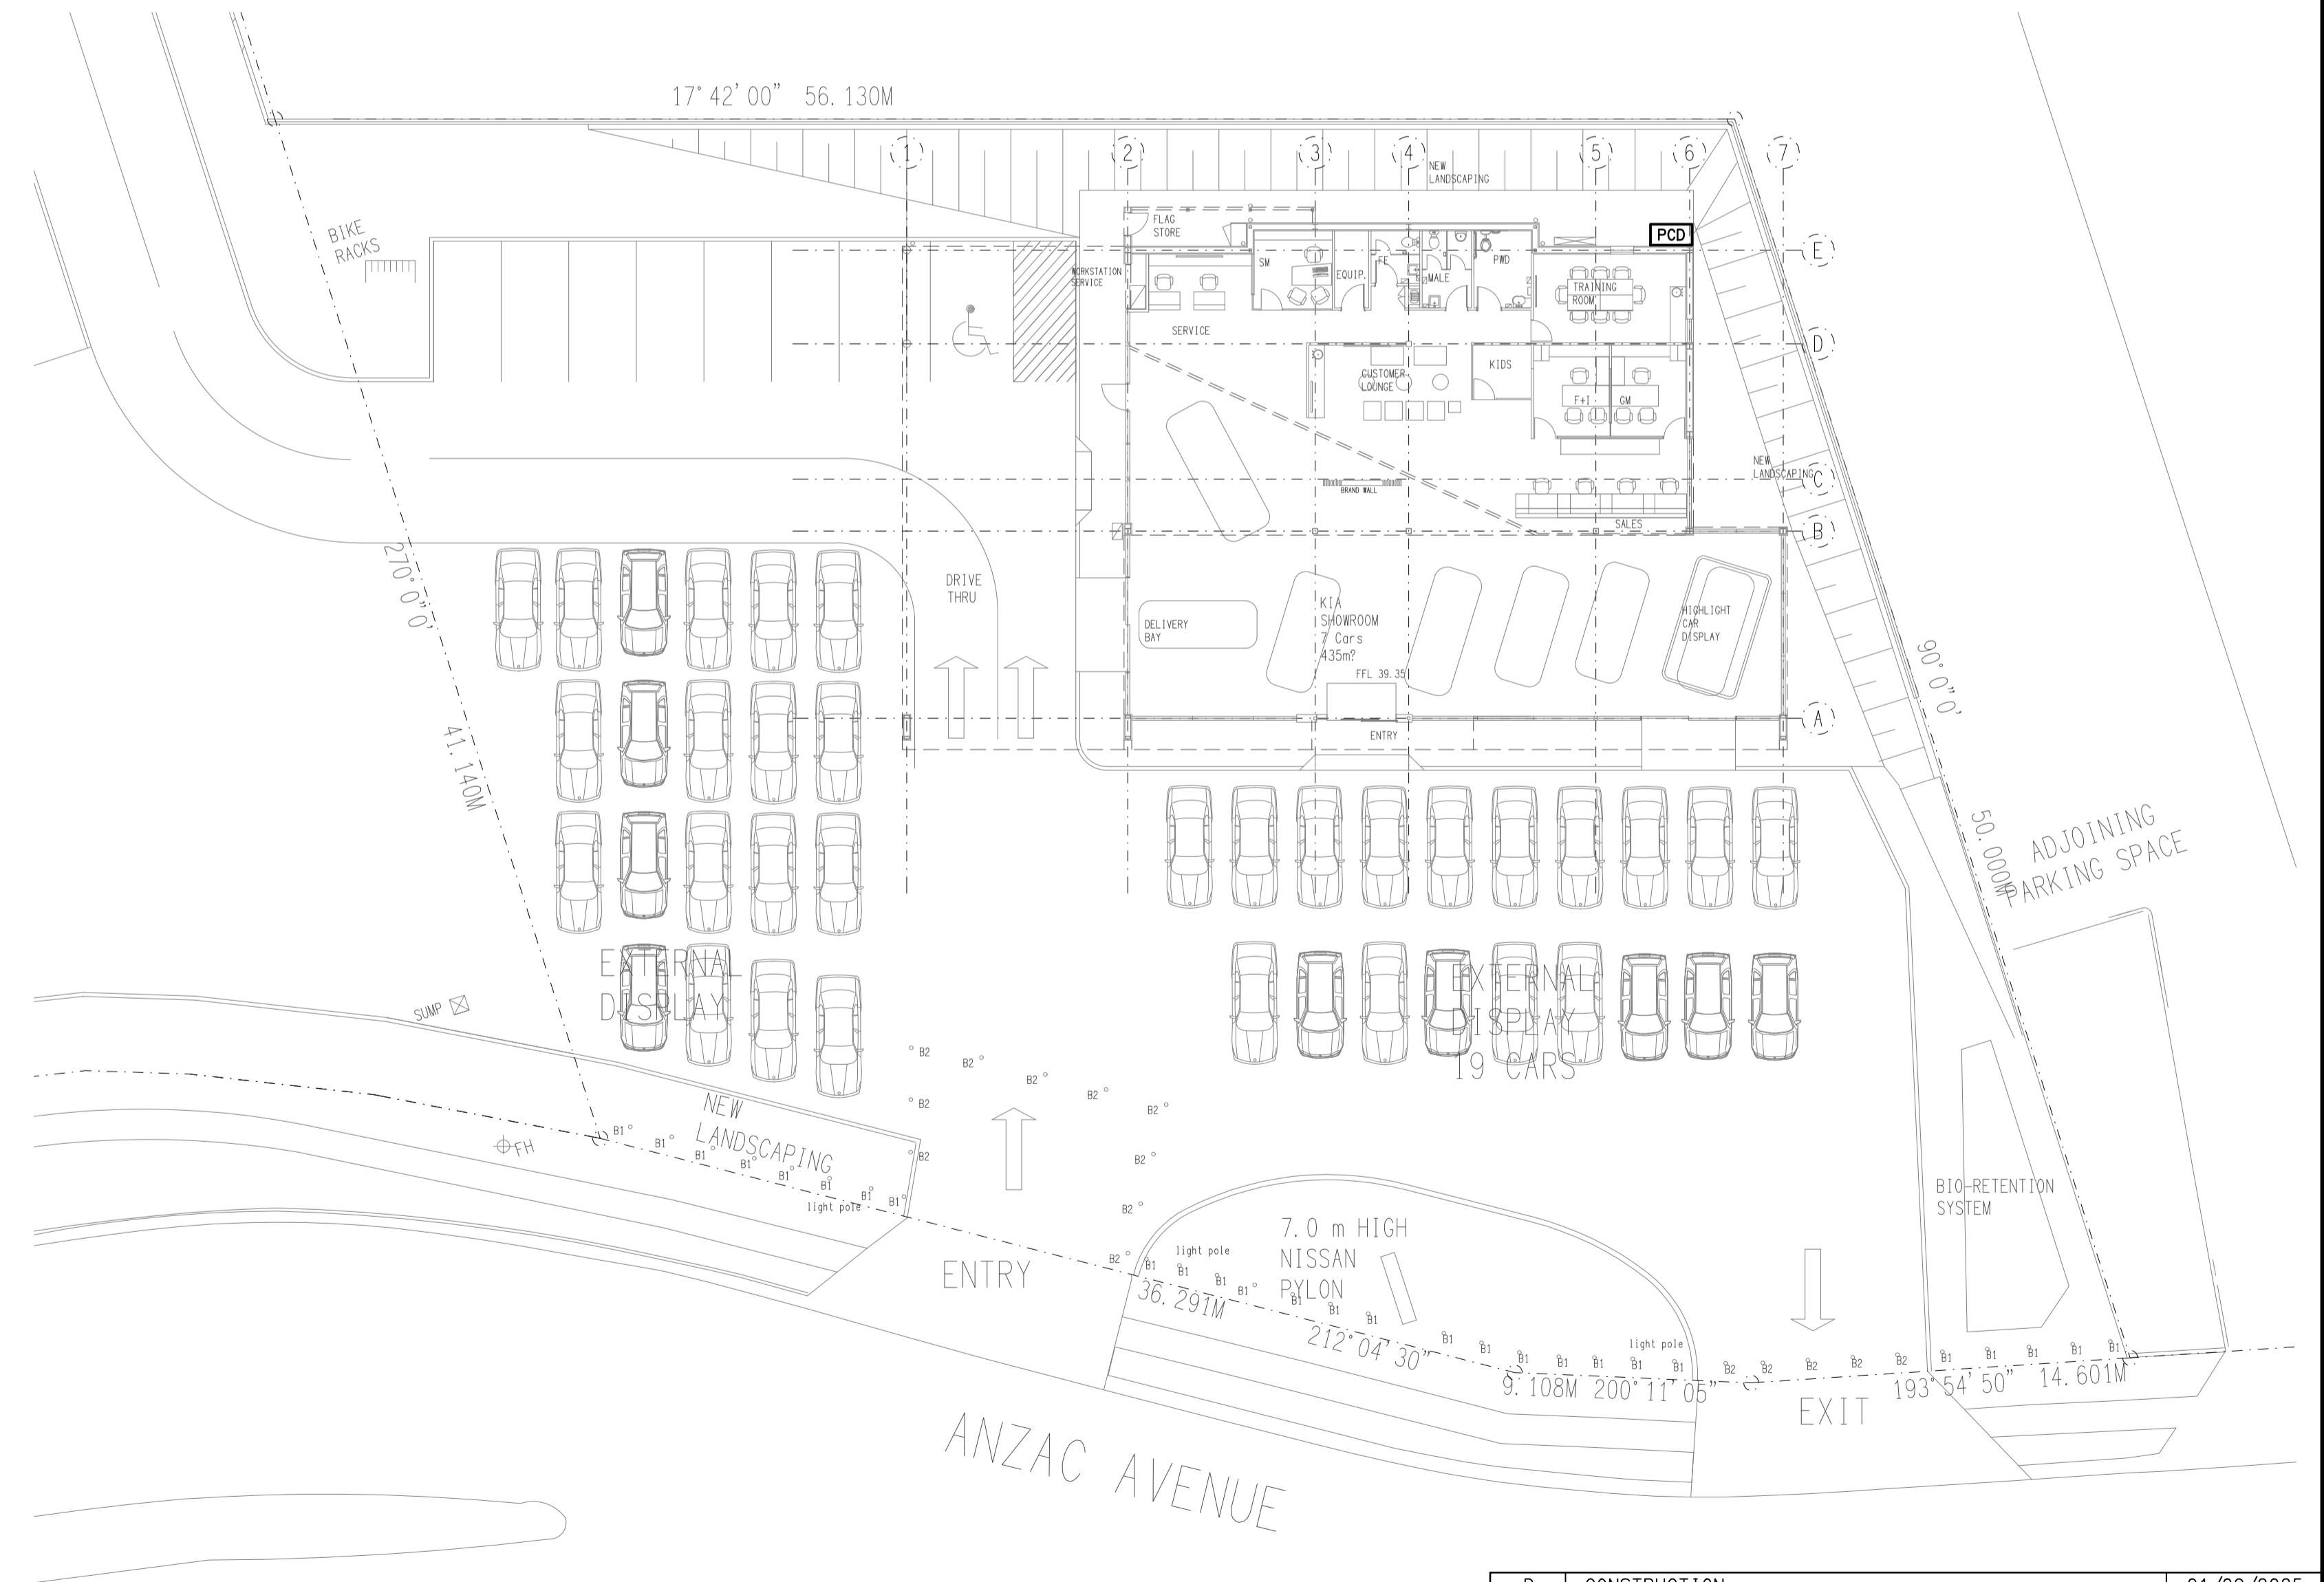

ELECTRICAL DESIGN GROUP BRISBANE
PTY LTD
ACN 092 710 793
TRADING AS:
ELECTRICAL DESIGN GROUP

THE COPYRIGHT OF THIS DRAWING
REMAINS THE PROPERTY OF THE
ELECTRICAL DESIGN GROUP.
USE FIGURED DIMENSIONS
IN PREFERENCE TO SCALE.
ALL DIMENSIONS TO BE
VERIFIED ONSITE.

ELECTRICAL DESIGN GROUP
ELECTRICAL BUILDING SERVICES CONSULTANTS
BRISBANE GOLD COAST

P.O. Box 15, Sherwood Q.4075
Phone: (07) 3278 4375
Email: brisbane@edg.net.au
Web: www.edg.net.au

PROJECT:
MOTORAMA - HILLCREST KIA
74 ANZAC AVENUE, HILLCREST

D	CONSTRUCTION	01/09/2025
REV:	DESCRIPTION:	DATE:

DRAWING:
**ELECTRICAL SERVICES
SITE PLAN**

SCALE: 1:200	AT A1	PROJECT NO: C3454a	DRAWING NO: E02	REVISION: D
-----------------	-------	------------------------------	---------------------------	-----------------------