


**SCHEMATIC**  
SWITCH PANEL SP1 / SP2 CONFIGURATION  
NOT TO SCALE

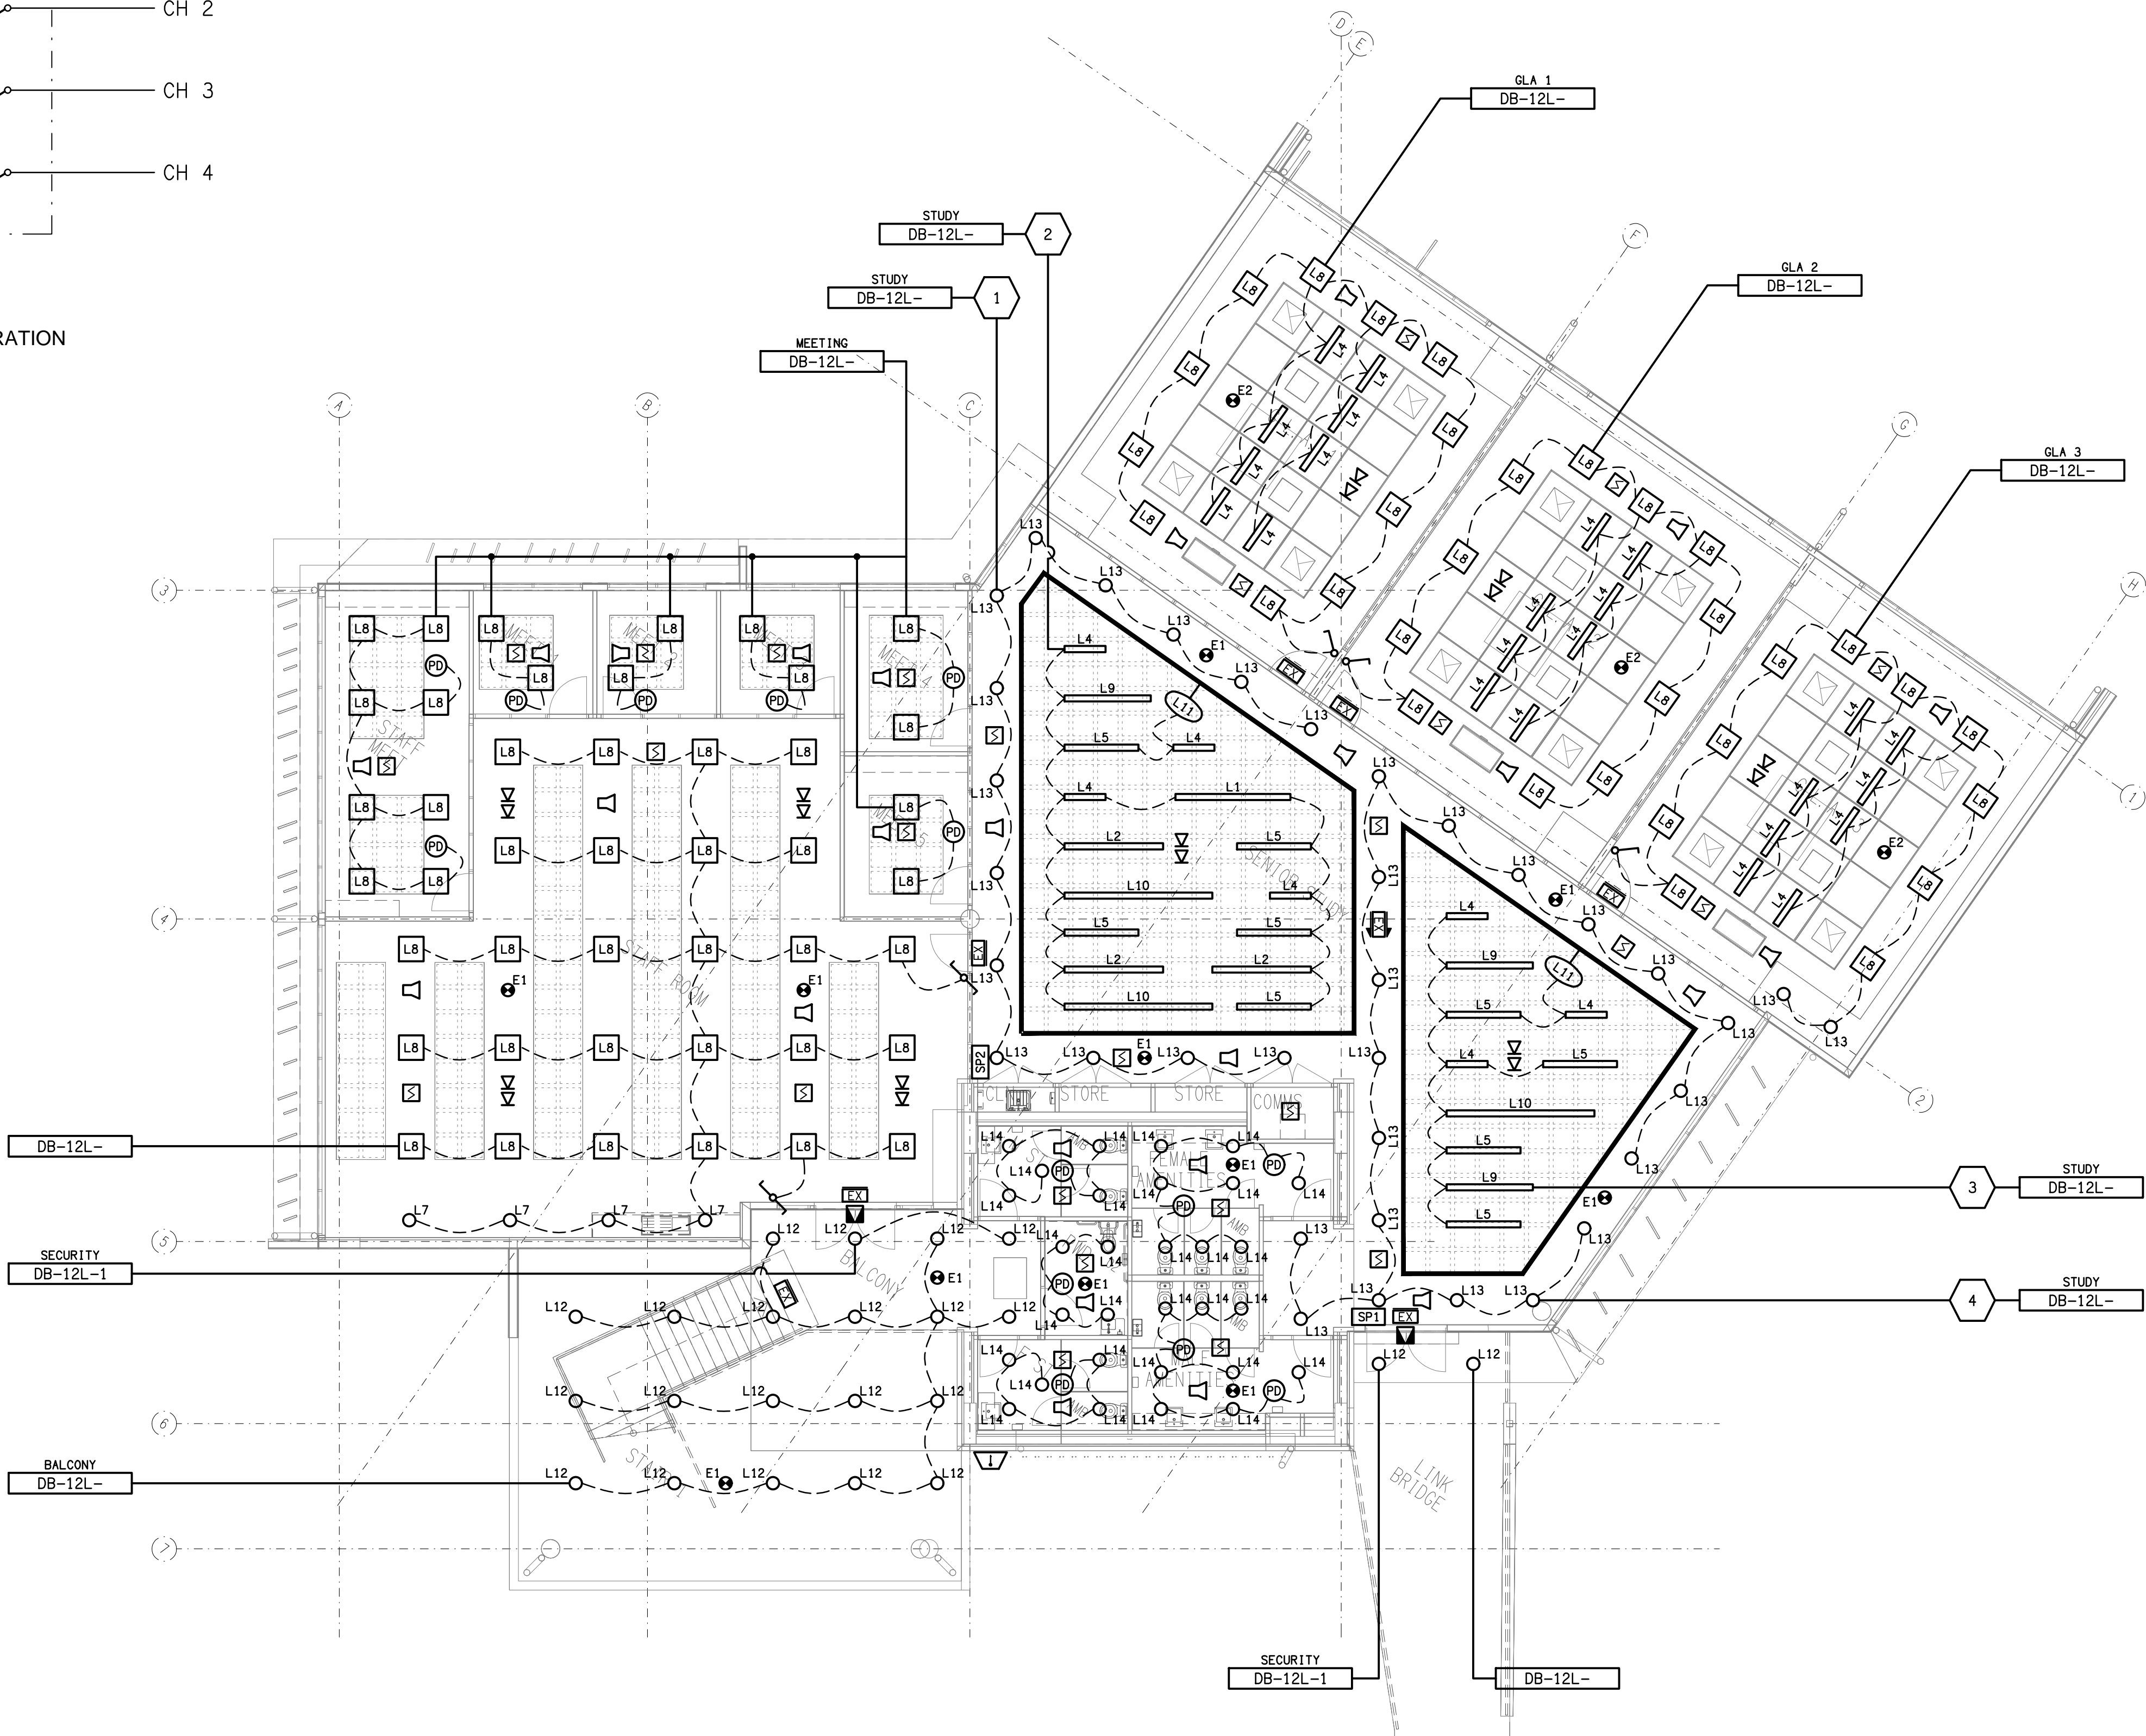

ELECTRICAL DESIGN GROUP BRISBANE  
PTY LTD  
ACN 092 710 793  
TRADING AS:  
ELECTRICAL DESIGN GROUP

THE COPYRIGHT OF THIS DRAWING  
REMAINS THE PROPERTY OF THE  
ELECTRICAL DESIGN GROUP.  
USE FIGURED DIMENSIONS  
IN PREFERENCE TO SCALE.  
ALL DIMENSIONS TO BE  
VERIFIED ONSITE.

**ELECTRICAL DESIGN GROUP**  
ELECTRICAL BUILDING SERVICES CONSULTANTS  
BRISBANE GOLD COAST

P.O. Box 15, Sherwood Q.4075  
Phone: (07) 3278 4375  
Email: brisbane@edg.net.au  
Web: www.edg.net.au

PROJECT:  
**KINGS CHRISTIAN COLLEGE  
CHAMBERS FLAT, SENIOR SCHOOL CHA12**

38-112 ANZAC AVENUE, CHAMBERS FLAT

A	PRELIMINARY	18/12/2025
REV.	DESCRIPTION:	DATE:

DRAWING:	PROJECT NO:	DRAWING NO:	REVISION:
<b>ELECTRICAL SERVICES LEVEL 2 REFLECTED CEILING PLAN</b>		<b>C3474a E10</b>	<b>A</b>
SCALE: 1:100	AT A1		