
 






 


 
 
 




 







 


 




 

 
 
 



 
 
 

 





LEGEND

-  ELECTRICAL SERVICES SWITCHBOARD.
-  SWITCHBOARD / CONTROL PANEL NOT PROVIDED AS PART OF THE ELECTRICAL SUBCONTRACT.
-  SINGLE POWER OUTLET.
-  DOUBLE POWER OUTLET.
-  SPECIAL PURPOSE POWER OUTLET.
-  SINGLE PHASE ISOLATOR.
-  THREE PHASE ISOLATOR.
-  DALI MANUAL POT SWITCH DIMMER.
-  LIGHTING CONTROL SWITCH PANEL.
-  ONE-WAY LIGHT SWITCH.
-  TWO-WAY LIGHT SWITCH.
-  CIRCUIT LINE.
-  SWITCH LINE.
-  POWER CIRCUIT DESIGNATION. DENOTES DB AND CIRCUIT.
-  LIGHTING CONTROL CHANNEL REFERENCE.
-  ELECTRICAL EQUIPMENT AS NOTED.
-  RECESS KIT OUTLET.
-  RJ45 COMMUNICATIONS OUTLET.
-  CAT-6 LINK CABLE.
-  CCTV CAMERA TO BE RELOCATED.
-  SECURITY DATA GATHERING PANEL.
-  SECURITY DIRECTIONAL MOTION DETECTOR.
-  SECURITY PIEZO SIREN TO BE RELOCATED.
-  EXISTING SCHOOL BELL PA HORN TO BE REMOVED.
-  EXISTING SCHOOL BELL PA SPEAKER TO BE REMOVED.
-  RECESSED SCHOOL BELL PA CEILING SPEAKER.
-  EXISTING AUDIO SYSTEM SPEAKER TO BE RELOCATED.
-  EXISTING PROJECTOR OUTLETS TO BE RELOCATED.
-  EXISTING MOTORISED SCREEN OUTLETS TO BE RELOCATED.
-  EXISTING HOOP SERVICES TO REMAIN AS IS.
-  EXISTING HOOP CONTROL SERVICES TO REMAIN AS IS.
-  REDCAT HEARING AUGMENTATION SPEAKER.
-  CLASS ROOM FAN CONTROLLER.
-  BIG ASS FAN CONTROLLER.
-  F1: CLASS ROOM FAN.
-  F2: BIG ASS FAN.


LEGEND

-  REFER TO DETAIL NOTED FOR THE AREA SHOWN HATCHED. ADDITIONAL OUTLETS & FITTINGS MAY BE SHOWN ON DETAIL.
-  E1: GENERAL LED EMERGENCY LIGHT.
-  E2: BALL PROOF IMPACT RESISTANT EMERGENCY EXIT LIGHT.
-  EX: EMERGENCY LED EXIT LIGHT.
-  L1: 300 x 1200 LAY-IN LED TROFFER.
-  L2: 300 x 1200 PLASTERBOARD LED TROFFER.
-  L3: 1200 LONG LED BATTEN.
-  L4: SIDE MOUNTED EXTRUSION LIGHT. LENGTH AS NOTED.
-  L5: EXISTING BATTEN TO BE REMOVED.
-  L6: VERTICAL RECESSED DIMMABLE EXTRUSION LIGHT.
-  L7: RECESSED DOWNLIGHT.
-  L8: ADJUSTABLE RECESSED DOWNLIGHT.
-  L9: WALL MOUNTED AREA LIGHT.

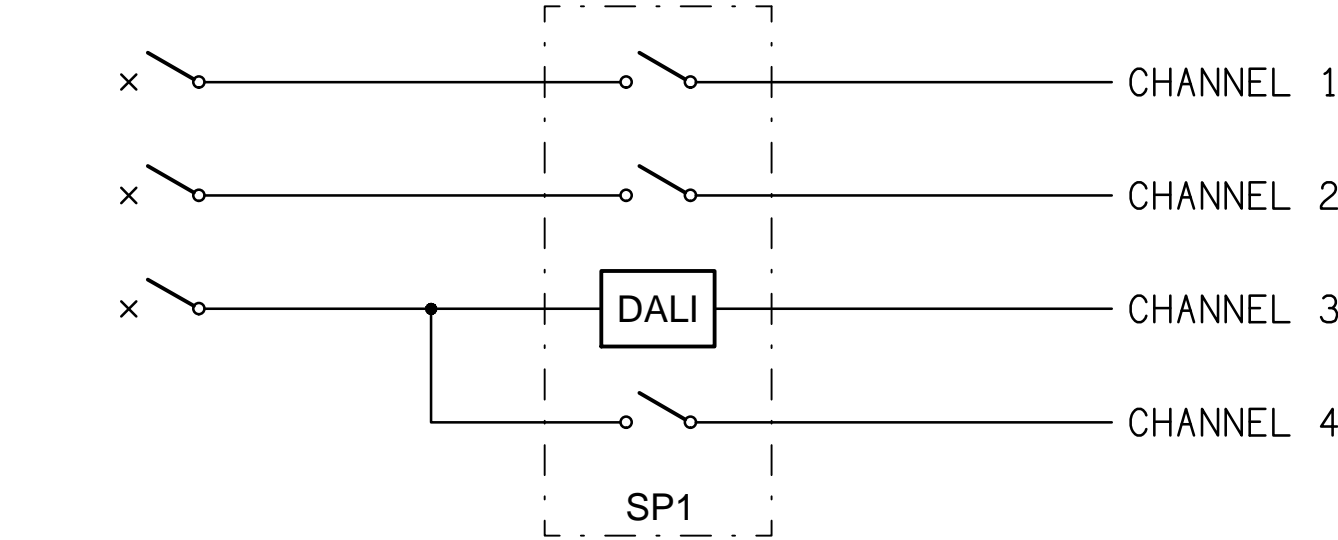


SCHEMATIC

SWITCH PANEL SP1 CONFIGURATION
NOT TO SCALE

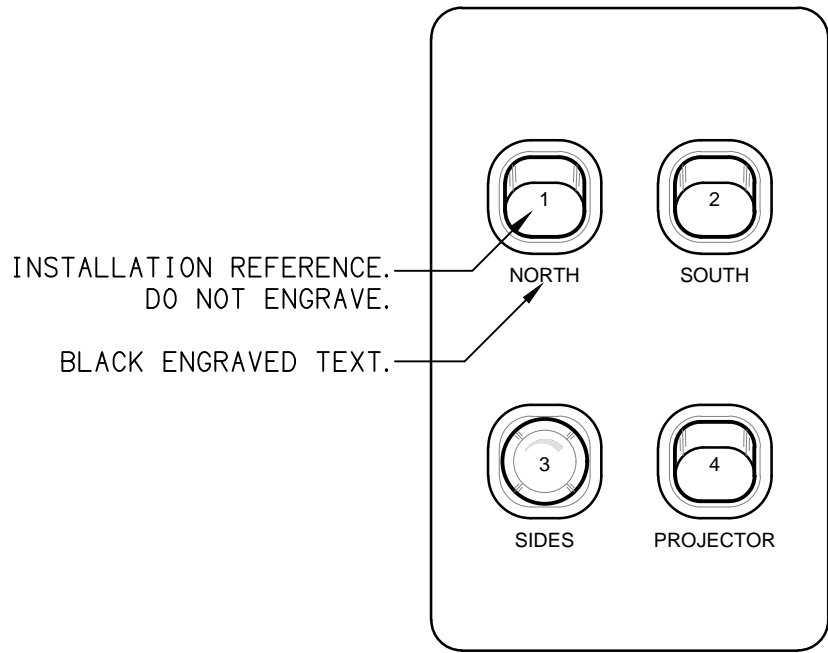

DETAIL

SWITCH PANEL SP1 ELEVATION
NOT TO SCALE

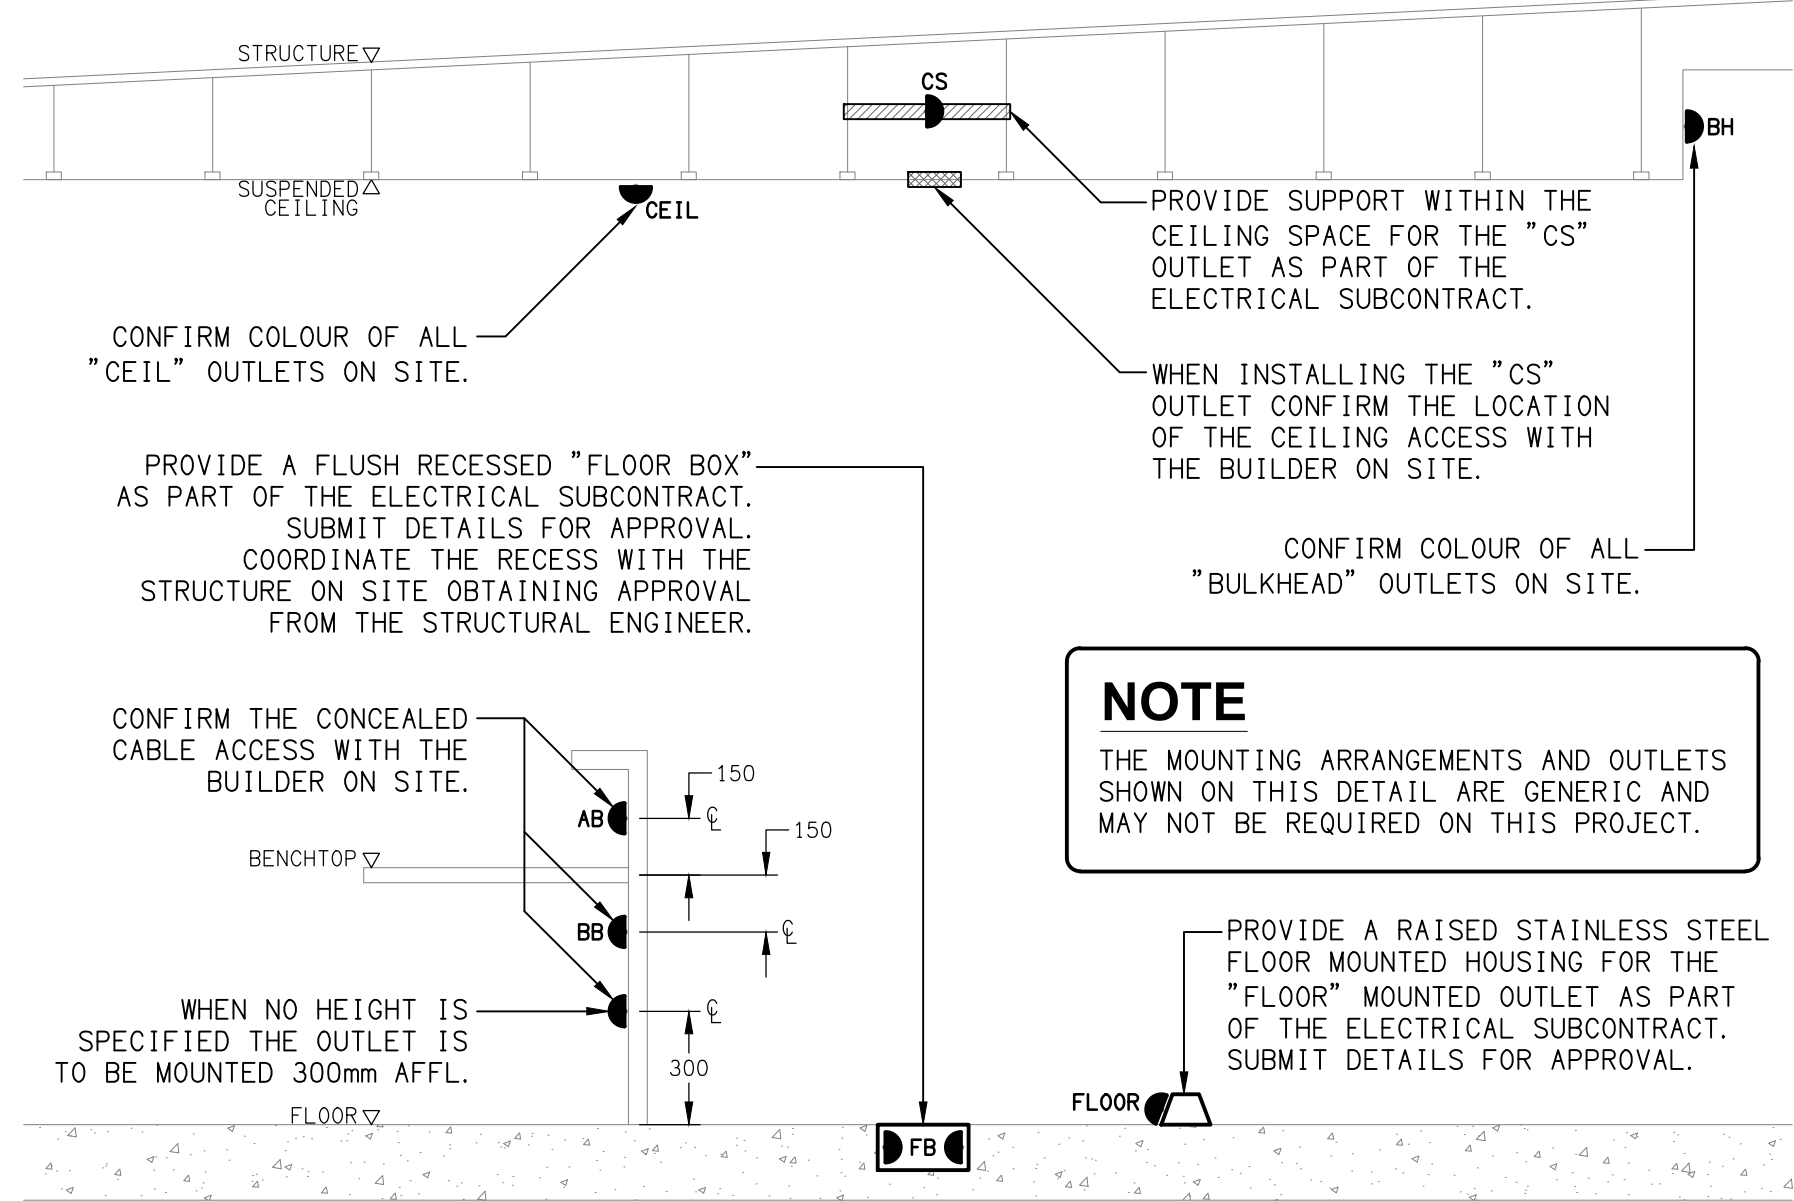


DETAIL

TYPICAL OUTLET MOUNTINGS
NOT TO SCALE

NOTE


THE MOUNTING ARRANGEMENTS AND OUTLETS SHOWN ON THIS DETAIL ARE GENERIC AND MAY NOT BE REQUIRED ON THIS PROJECT.

PROVIDE A RAISED STAINLESS STEEL FLOOR MOUNTED HOUSING FOR THE "FLOOR" MOUNTED OUTLET AS PART OF THE ELECTRICAL SUBCONTRACT. SUBMIT DETAILS FOR APPROVAL.

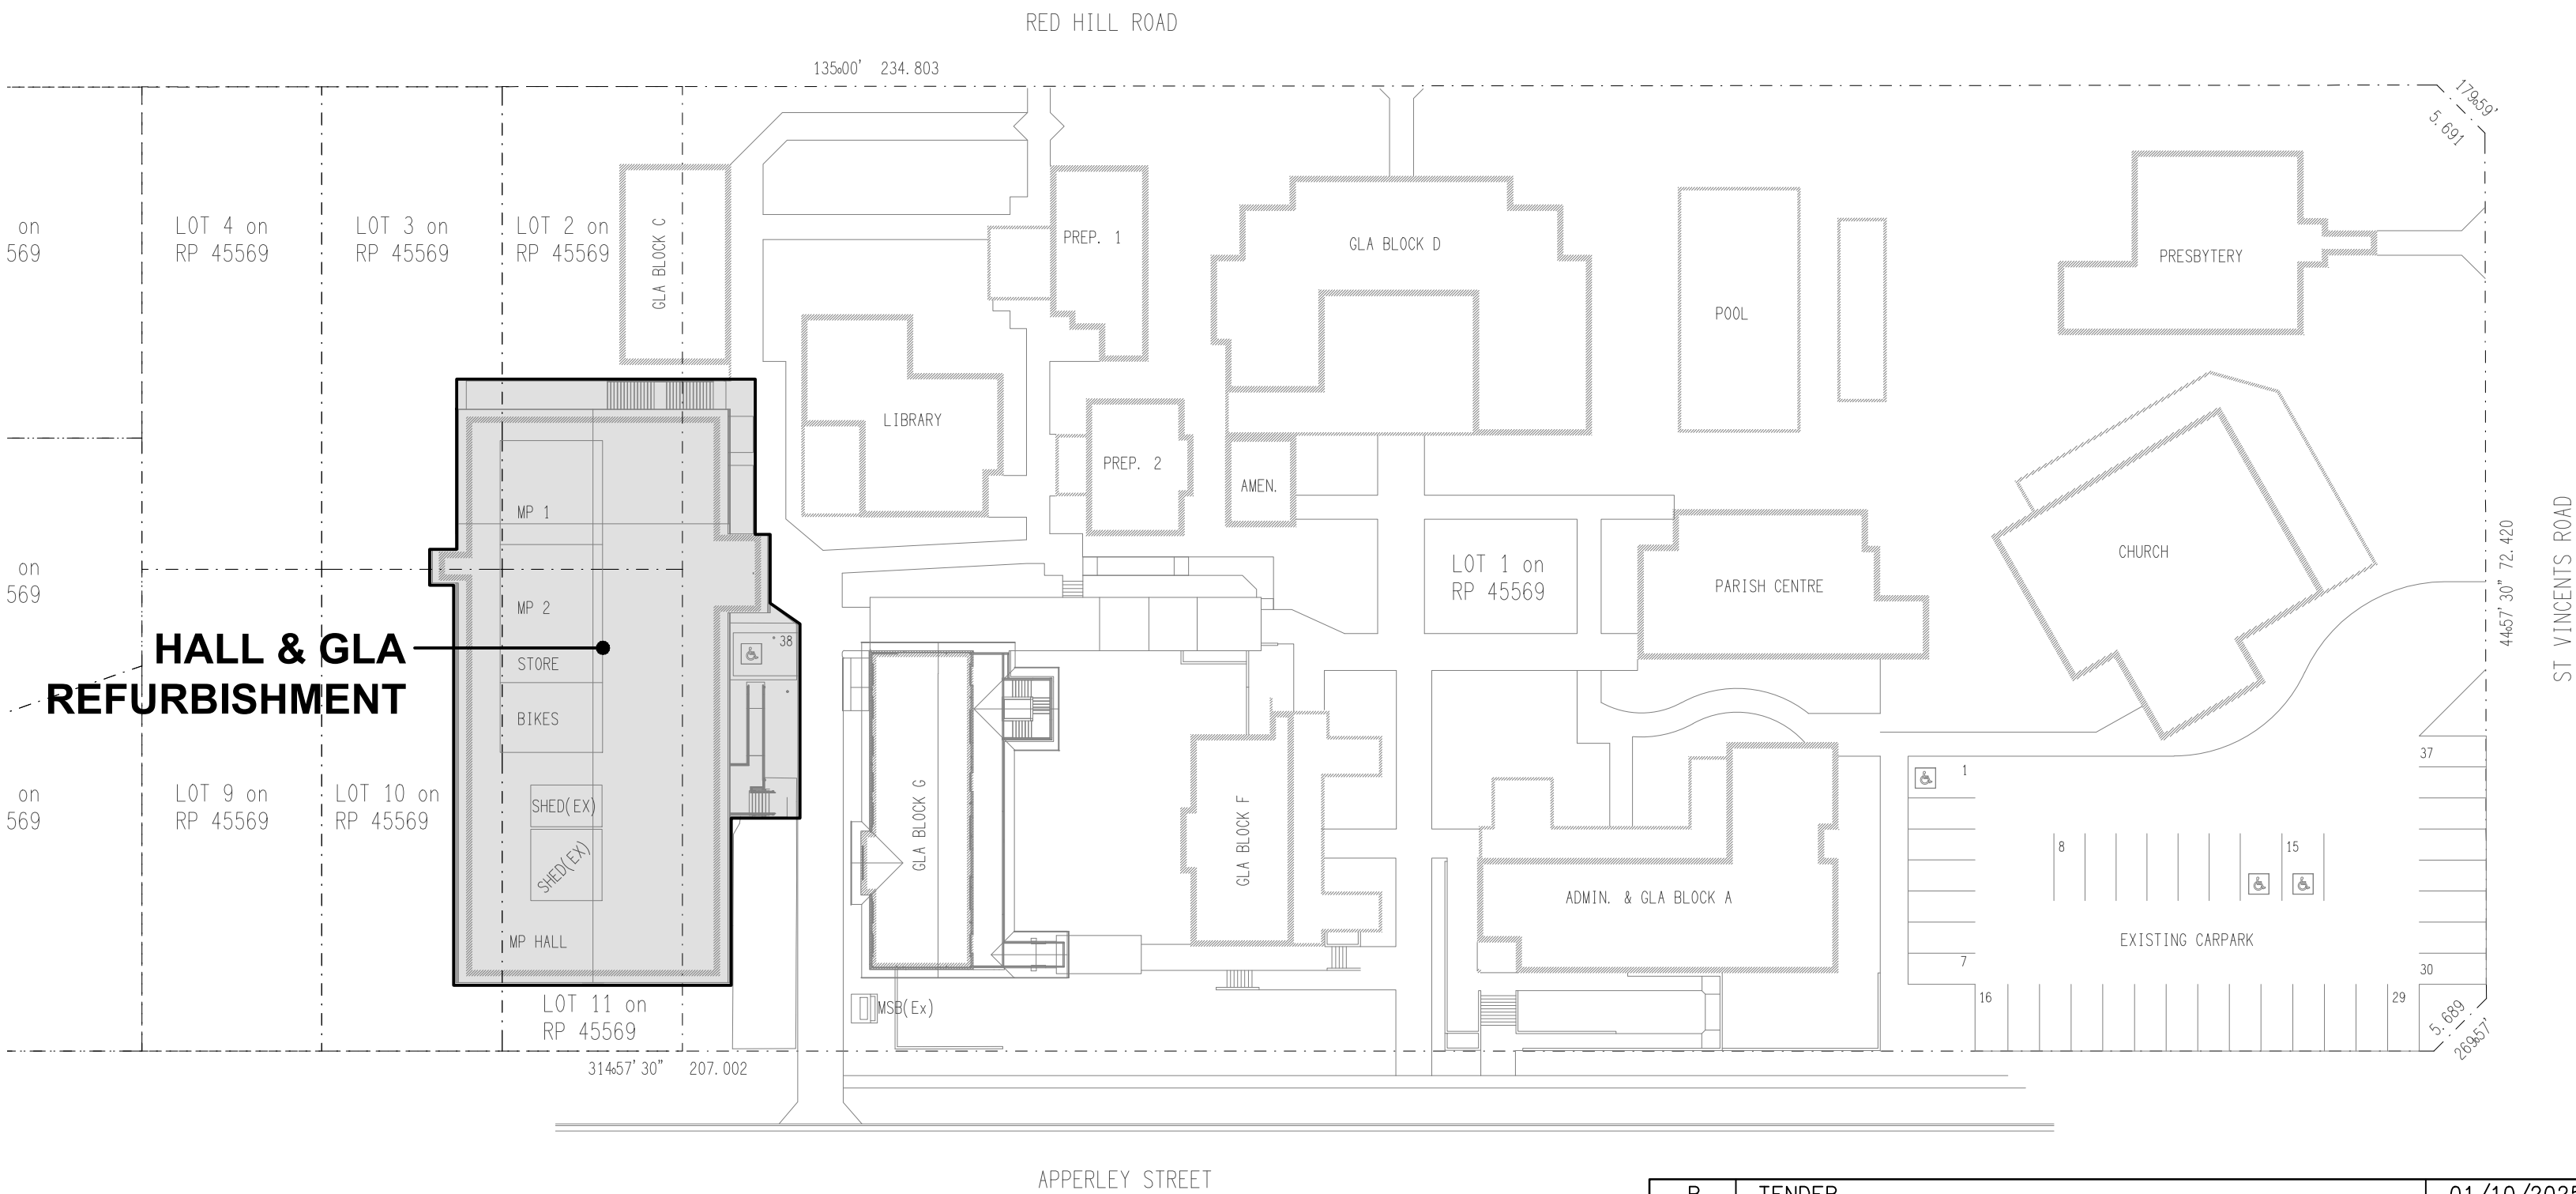

SCHEMATIC

RJ45 PINOUT CONFIGURATION
NOT TO SCALE

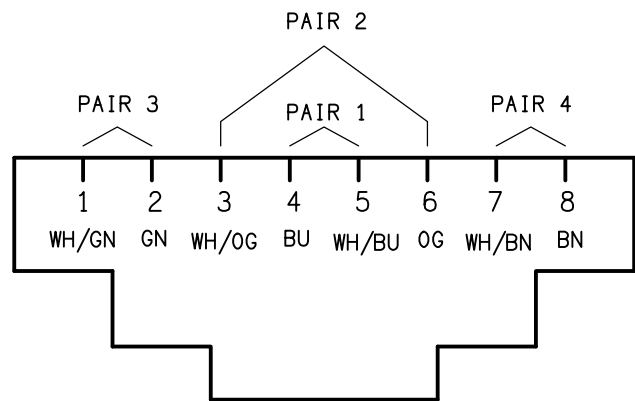

ELECTRICAL DESIGN GROUP BRISBANE
PTY LTD
ACN 092 710 793
TRADING AS:
ELECTRICAL DESIGN GROUP

THE COPYRIGHT OF THIS DRAWING
REMAINS THE PROPERTY OF THE
ELECTRICAL DESIGN GROUP.
USE FIGURED DIMENSIONS
IN PREFERENCE TO SCALE.
ALL DIMENSIONS TO BE
VERIFIED ONSITE.

ELECTRICAL DESIGN GROUP
ELECTRICAL BUILDING SERVICES CONSULTANTS
BRISBANE GOLD COAST

P.O.Box 15, Sherwood Q.4075
Phone: (07) 3278 4375
Email: brisbane@edg.net.au
Web: www.edg.net.au

PROJECT:
**ST PIUS PRIMARY SCHOOL, BANYO
HALL & GLA REFURBISHMENT**

APPERLEY STREET, BANYO, QUEENSLAND

B	TENDER	01/10/2025
REV.	DESCRIPTION:	DATE:

DRAWING:
**ELECTRICAL SERVICES
LEGEND & SITE PLAN**

SCALE:
1:500

AT A1

PROJECT NO:
C3491a

DRAWING NO:
E01

REVISION:
B