




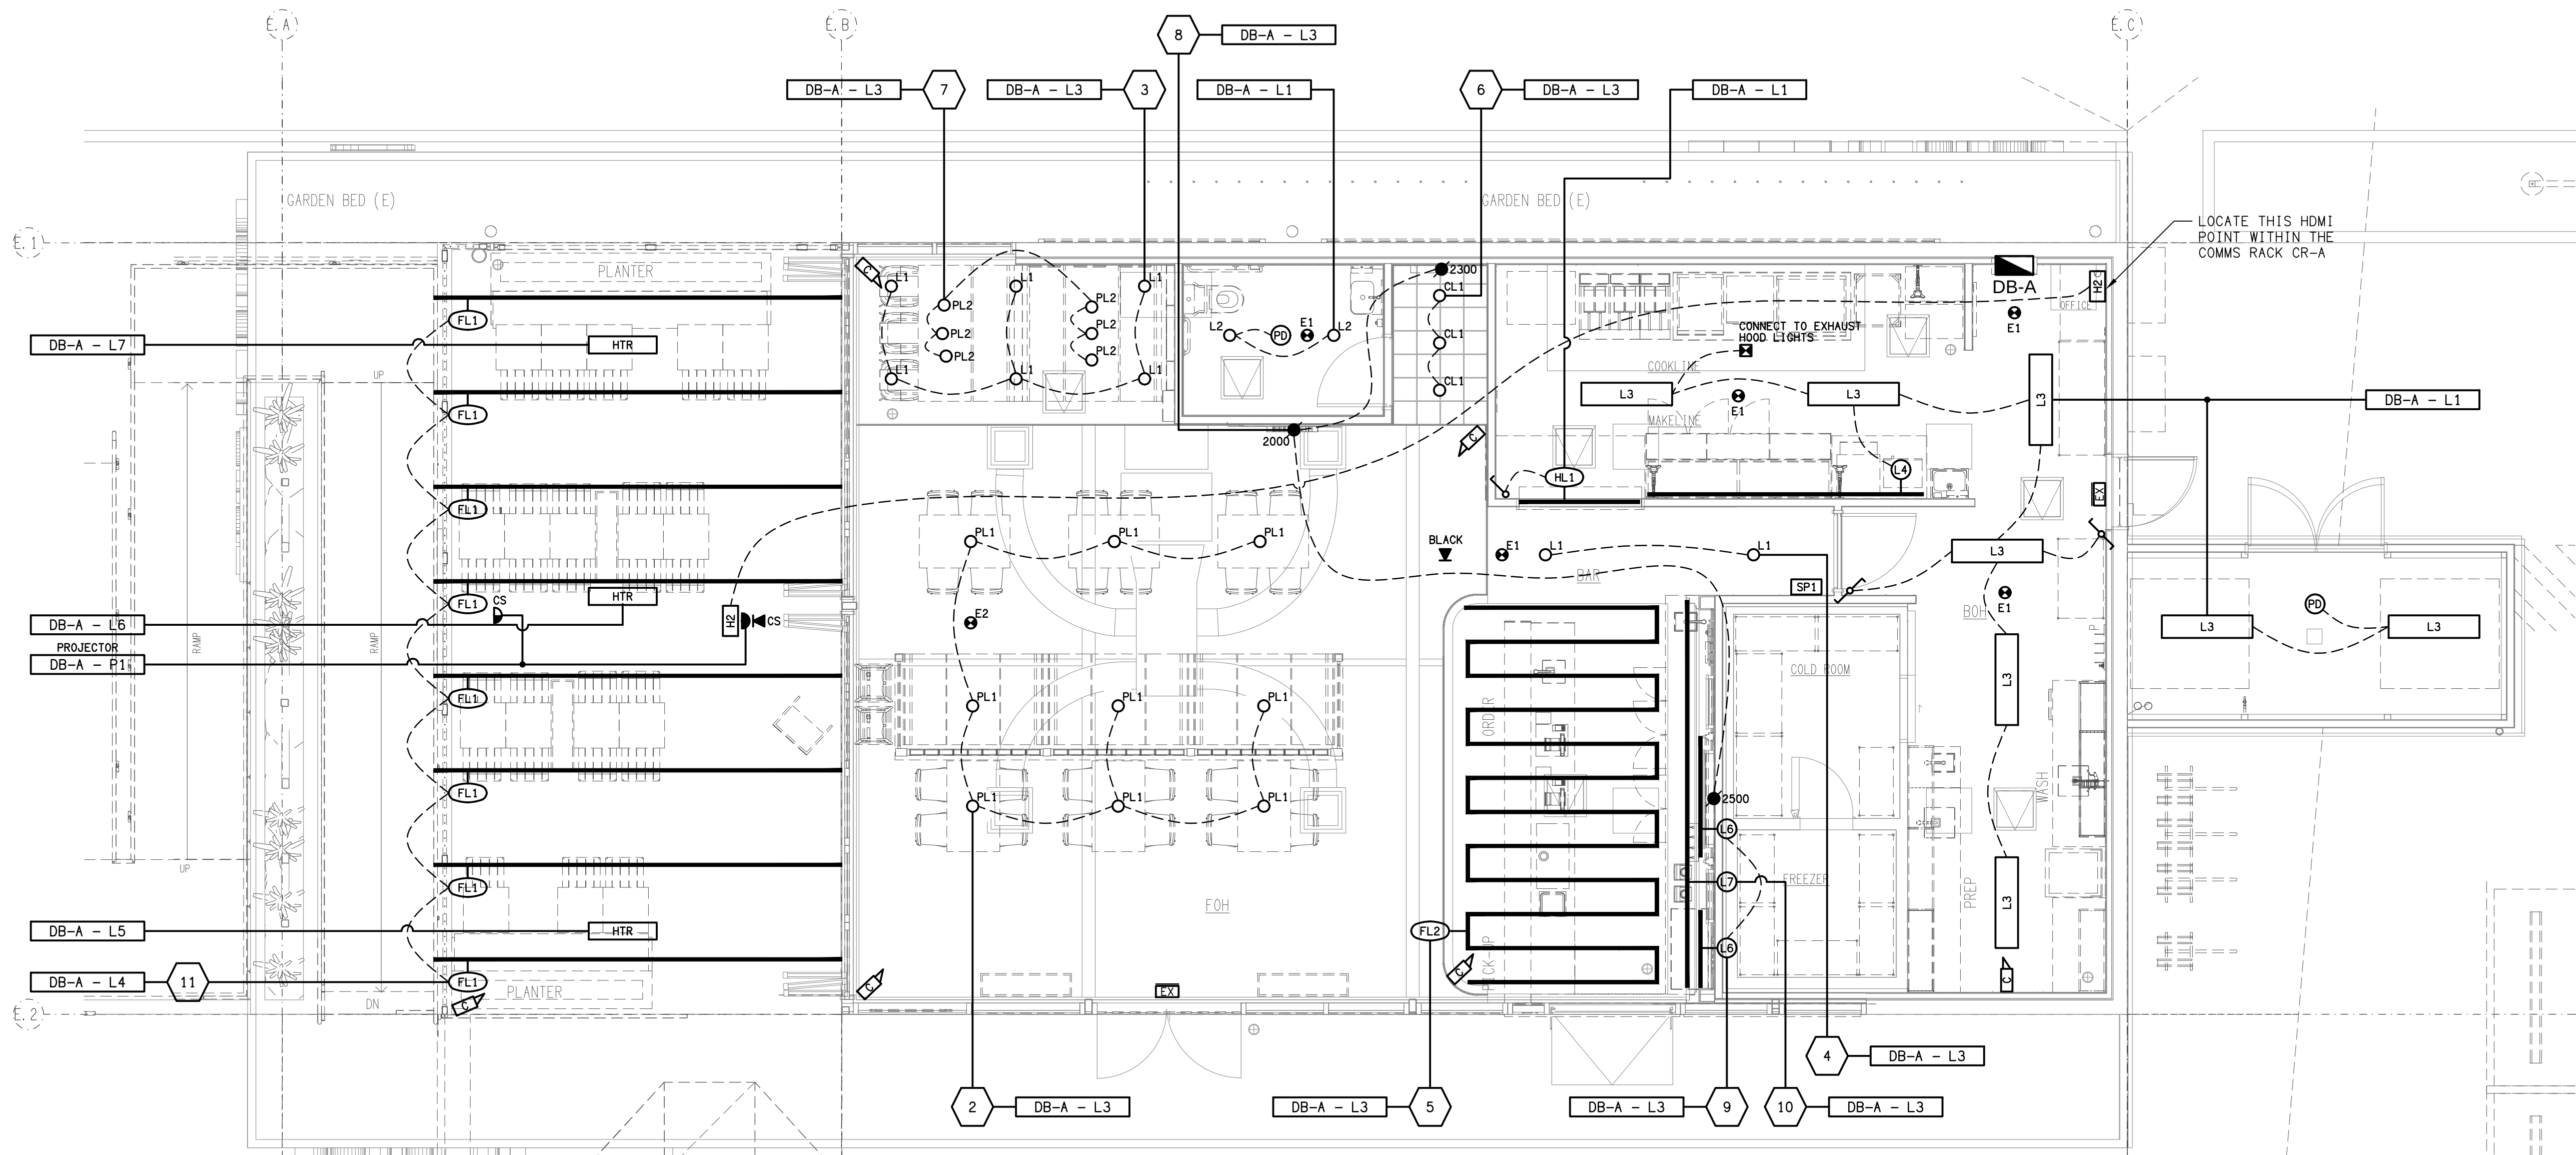


REFLECTED CEILING PLAN
BURGER URGE TENANCY
SCALE 1:50

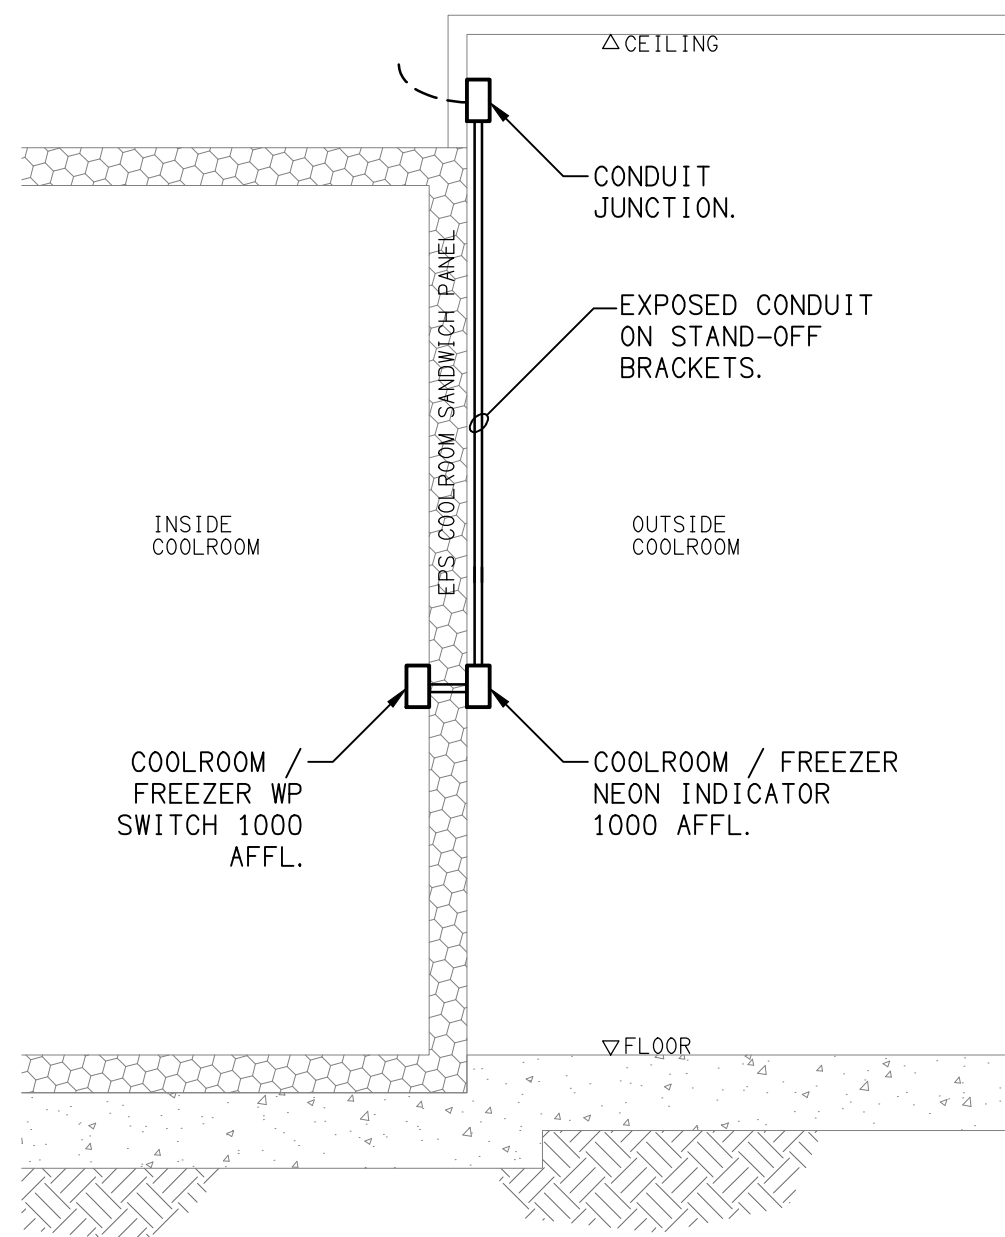


DETAIL A
COOLROOM / FREEZER LIGHTING CONTROL
NOT TO SCALE

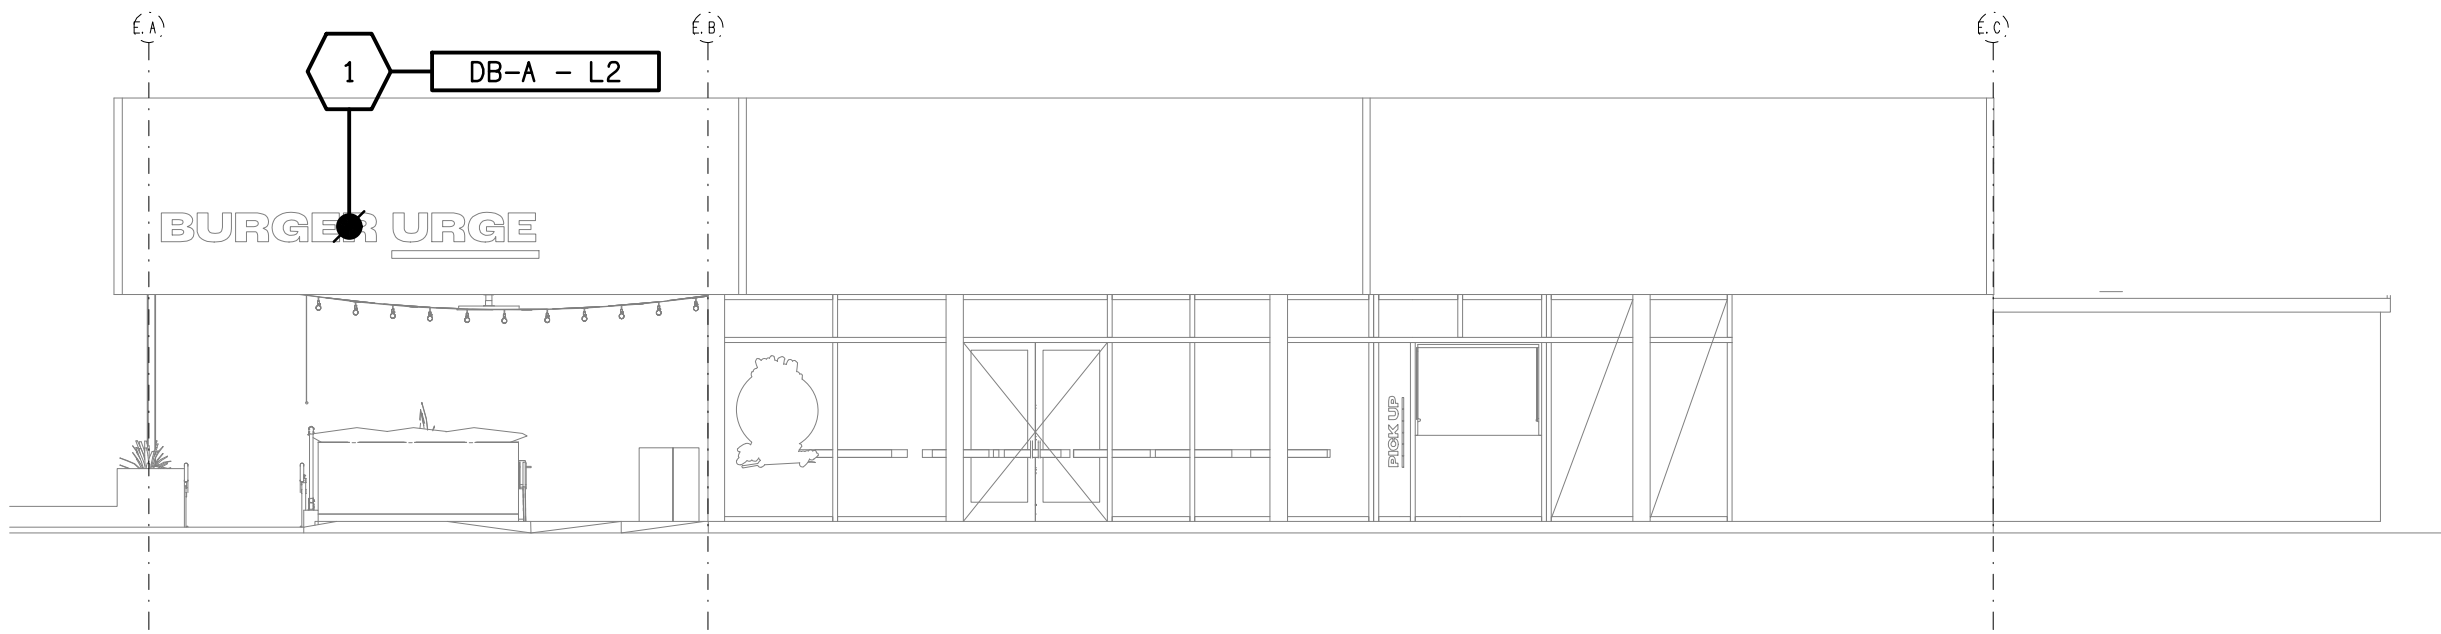

SOUTH
EXTERNAL BUILDING ELEVATION
SCALE 1:100

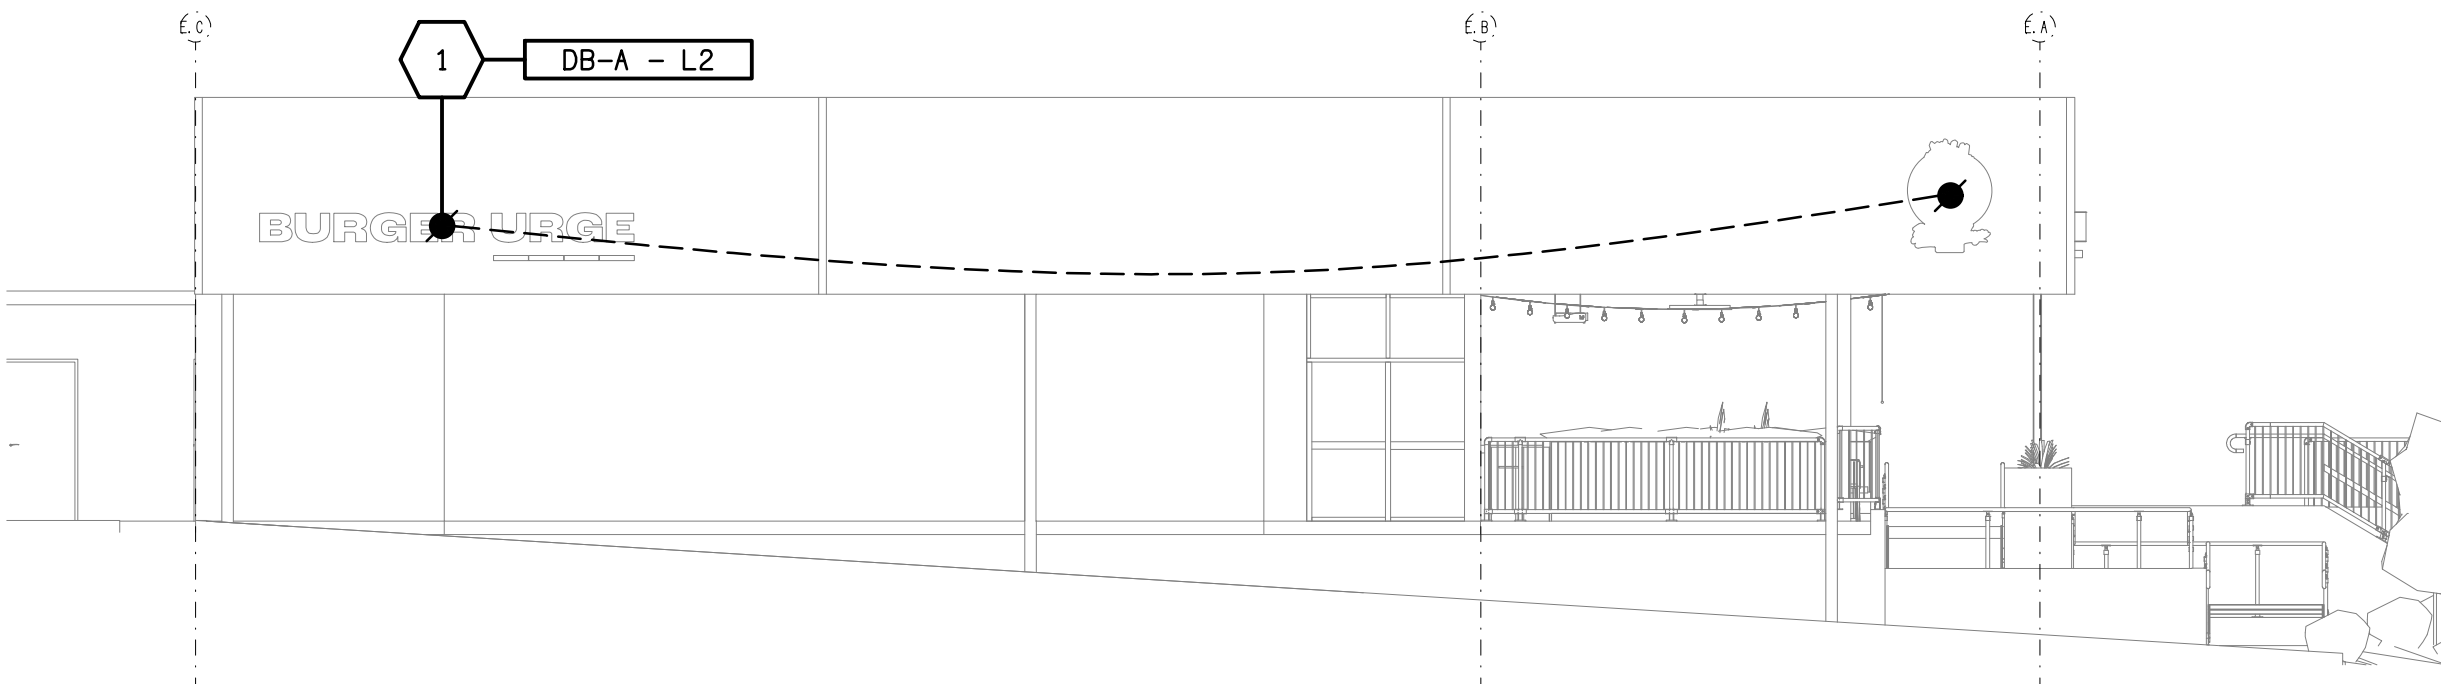

NORTH
EXTERNAL BUILDING ELEVATION
SCALE 1:100

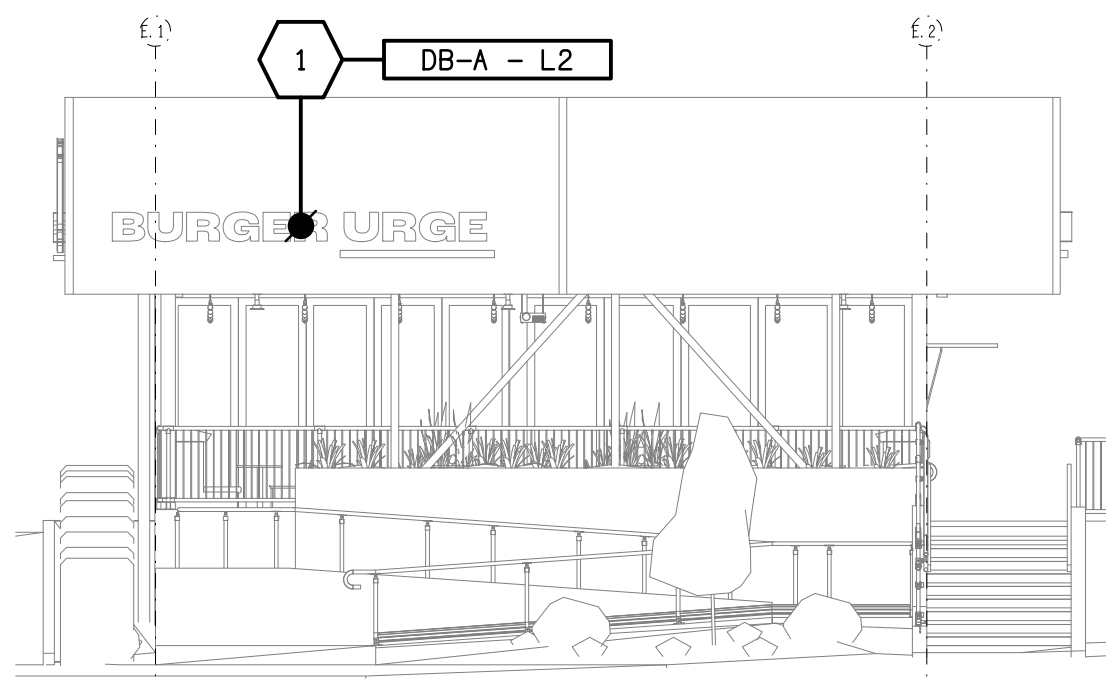

WEST
EXTERNAL BUILDING ELEVATION
SCALE 1:100

THE COPYRIGHT OF THIS DRAWING REMAINS THE PROPERTY OF THE ELECTRICAL DESIGN GROUP.

USE FIGURED DIMENSIONS IN PREFERENCE TO SCALE.

ALL DIMENSIONS TO BE VERIFIED ONSITE.

BURGER URGE

D	CONSTRUCTION	24/07/2025
REV:	DESCRIPTION:	DATE:

ELECTRICAL DESIGN GROUP
ELECTRICAL BUILDING SERVICES CONSULTANTS

BRISBANE: P.O. Box 15 Sherwood Qld 4075
Phone: (07) 3278 4375
Email: brisbane@edg.net.au
Web: www.edg.net.au

ELECTRICAL DESIGN GROUP BRISBANE PTY LTD
ACN 092 710 793

TRADING AS:
ELECTRICAL DESIGN GROUP

PROJECT:

**BURGER URGE
WILSONTON**

SITE ADDRESS:

CORNER BRIDGE STREET &
RICHMOND DRIVE, WILSONTON,
QUEENSLAND

SCALE: SHEET SIZE:

1:50 AT A1

DRAWING TITLE:

**ELECTRICAL SERVICES
REFLECTED CEILING PLAN**

PROJECT NO: DRAWING NO: REVISION:

C3520a E04 D