



SANDGATE ROAD
STAGE 1 EXTERNAL BUILDING ELEVATION
SCALE 1:200

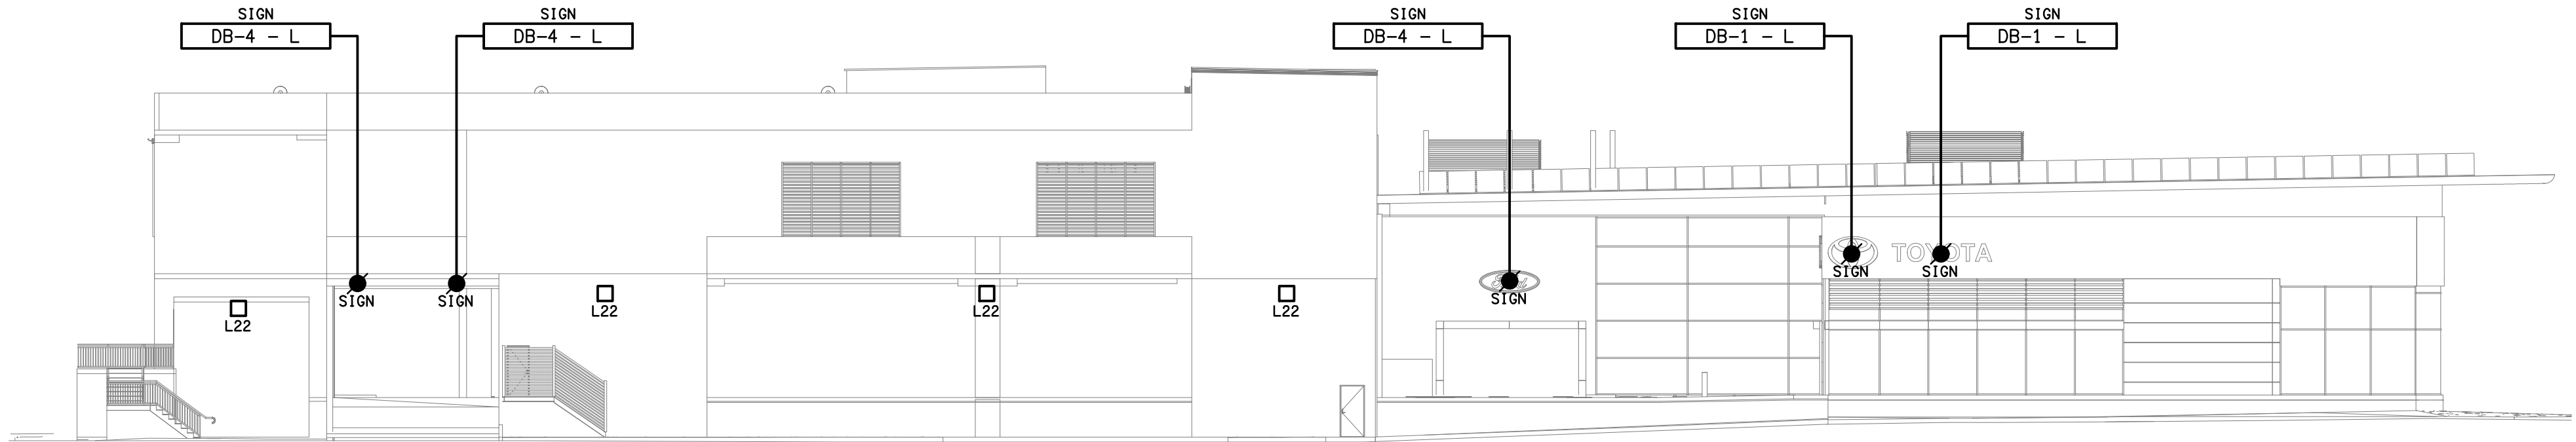


COLLINGWOOD STREET
STAGE 1 EXTERNAL BUILDING ELEVATION
SCALE 1:200

NOTE:
THE L22 LIGHT FITTINGS SHOWN ON THIS
PLAN ARE THE SAME LIGHT FITTINGS
SHOWN ON THE REFLECTED CEILING PLANS.

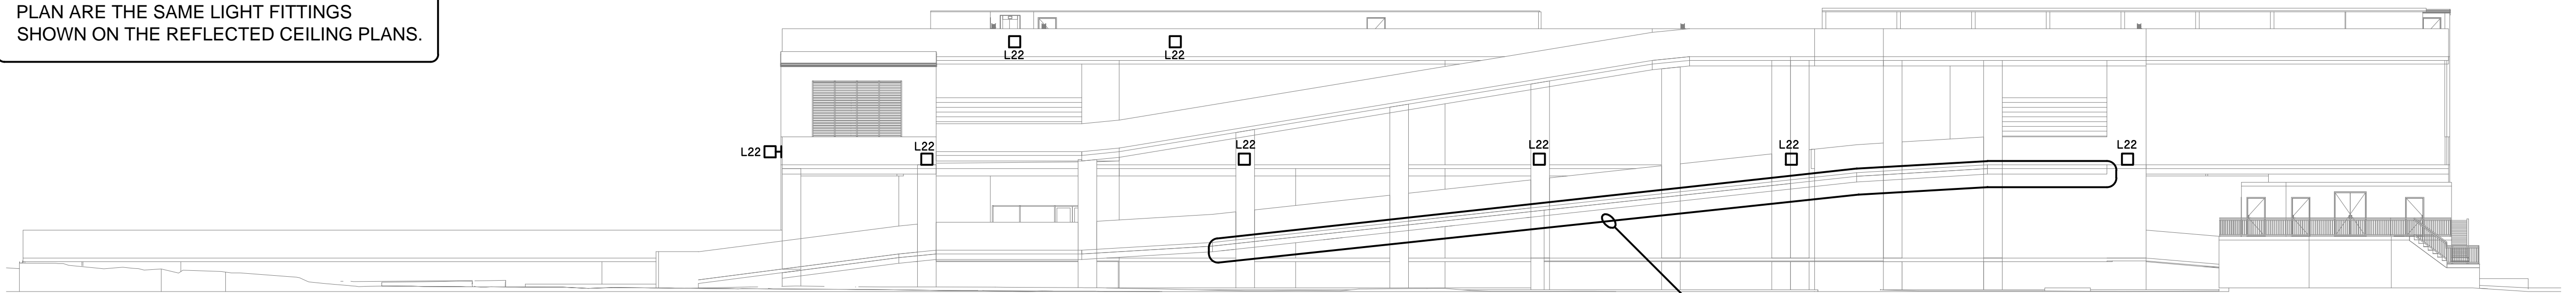

TATE STREET
STAGE 1 EXTERNAL BUILDING ELEVATION
SCALE 1:200

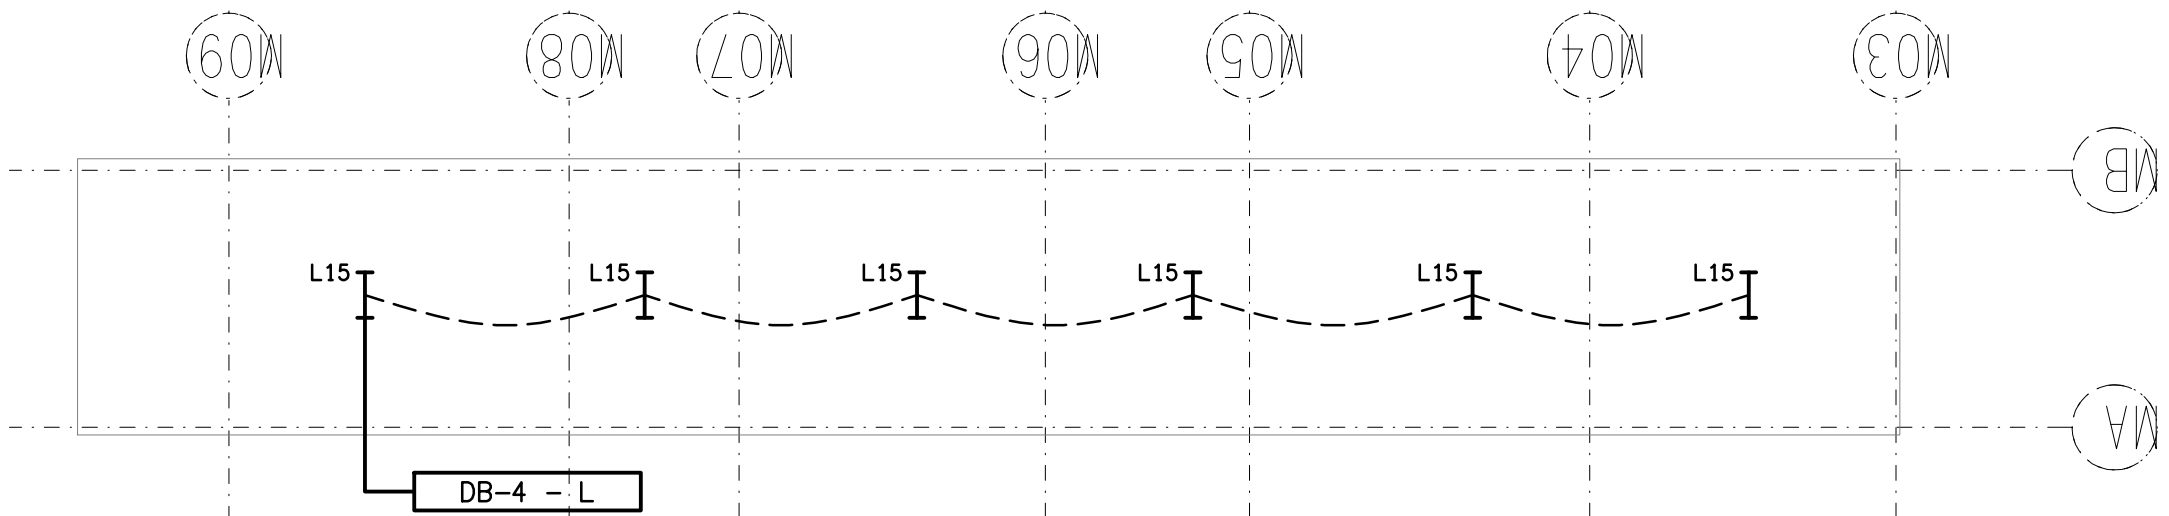

LOWER RAMP PLAN
LIGHTING LAYOUT
SCALE 1:200