




DETAIL A
TRANSFORMER ROOM VENTILATION SECTION
SCALE 1: 50

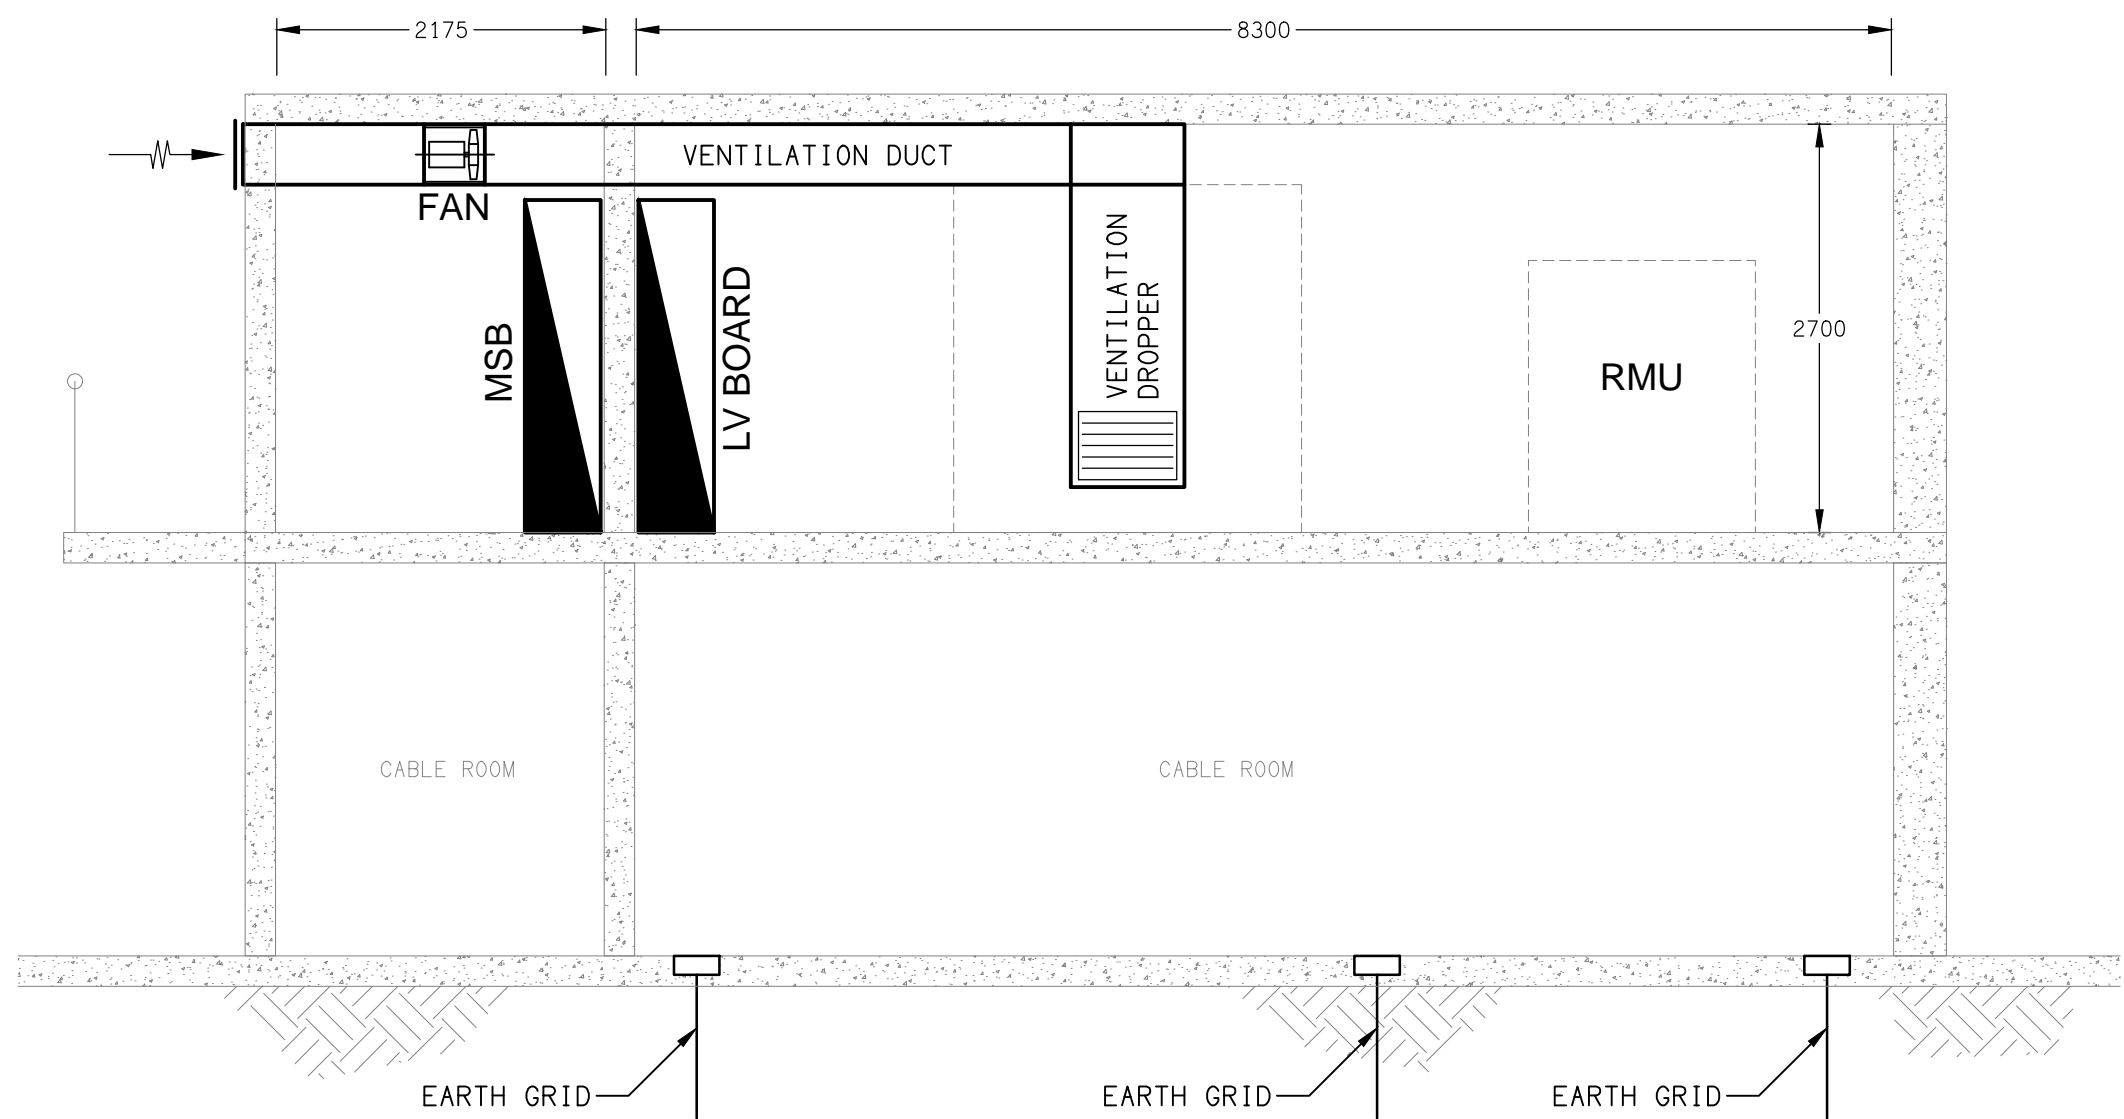

DETAIL B
TRANSFORMER ROOM VENTILATION / EARTH GRID SECTION
SCALE 1: 50

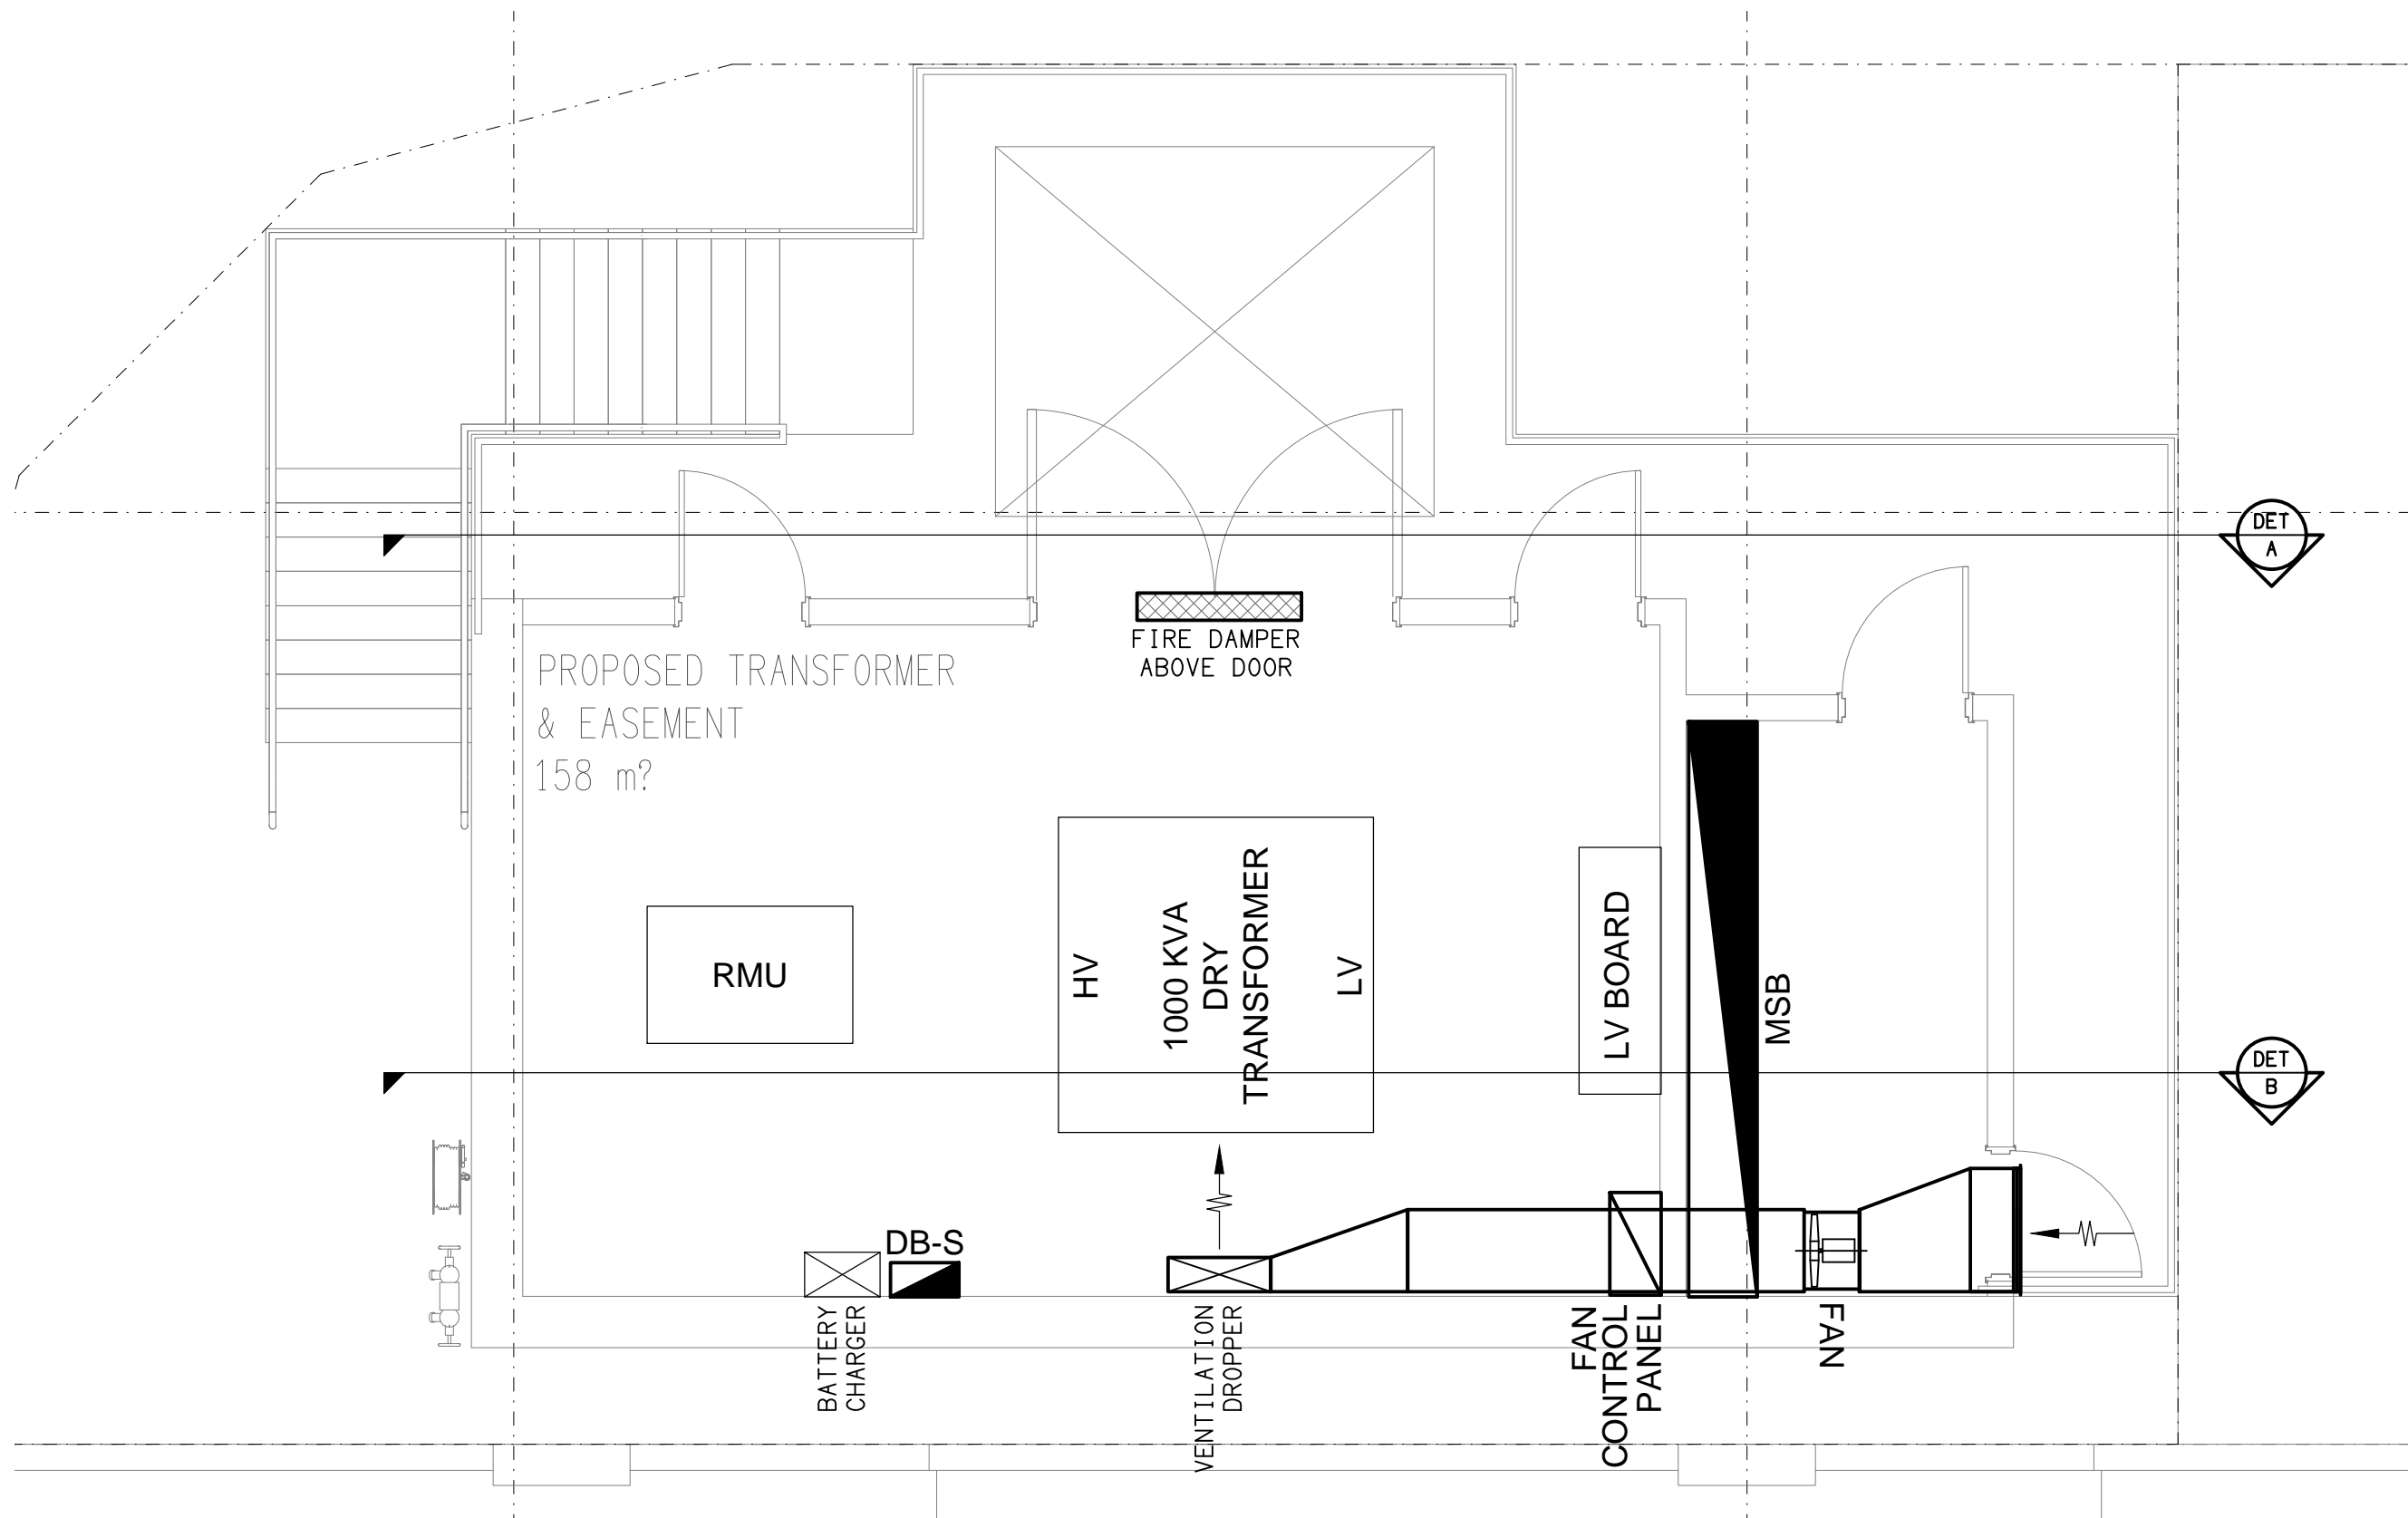

VENTILATION PLAN
TRANSFORMER ROOM
SCALE 1: 50

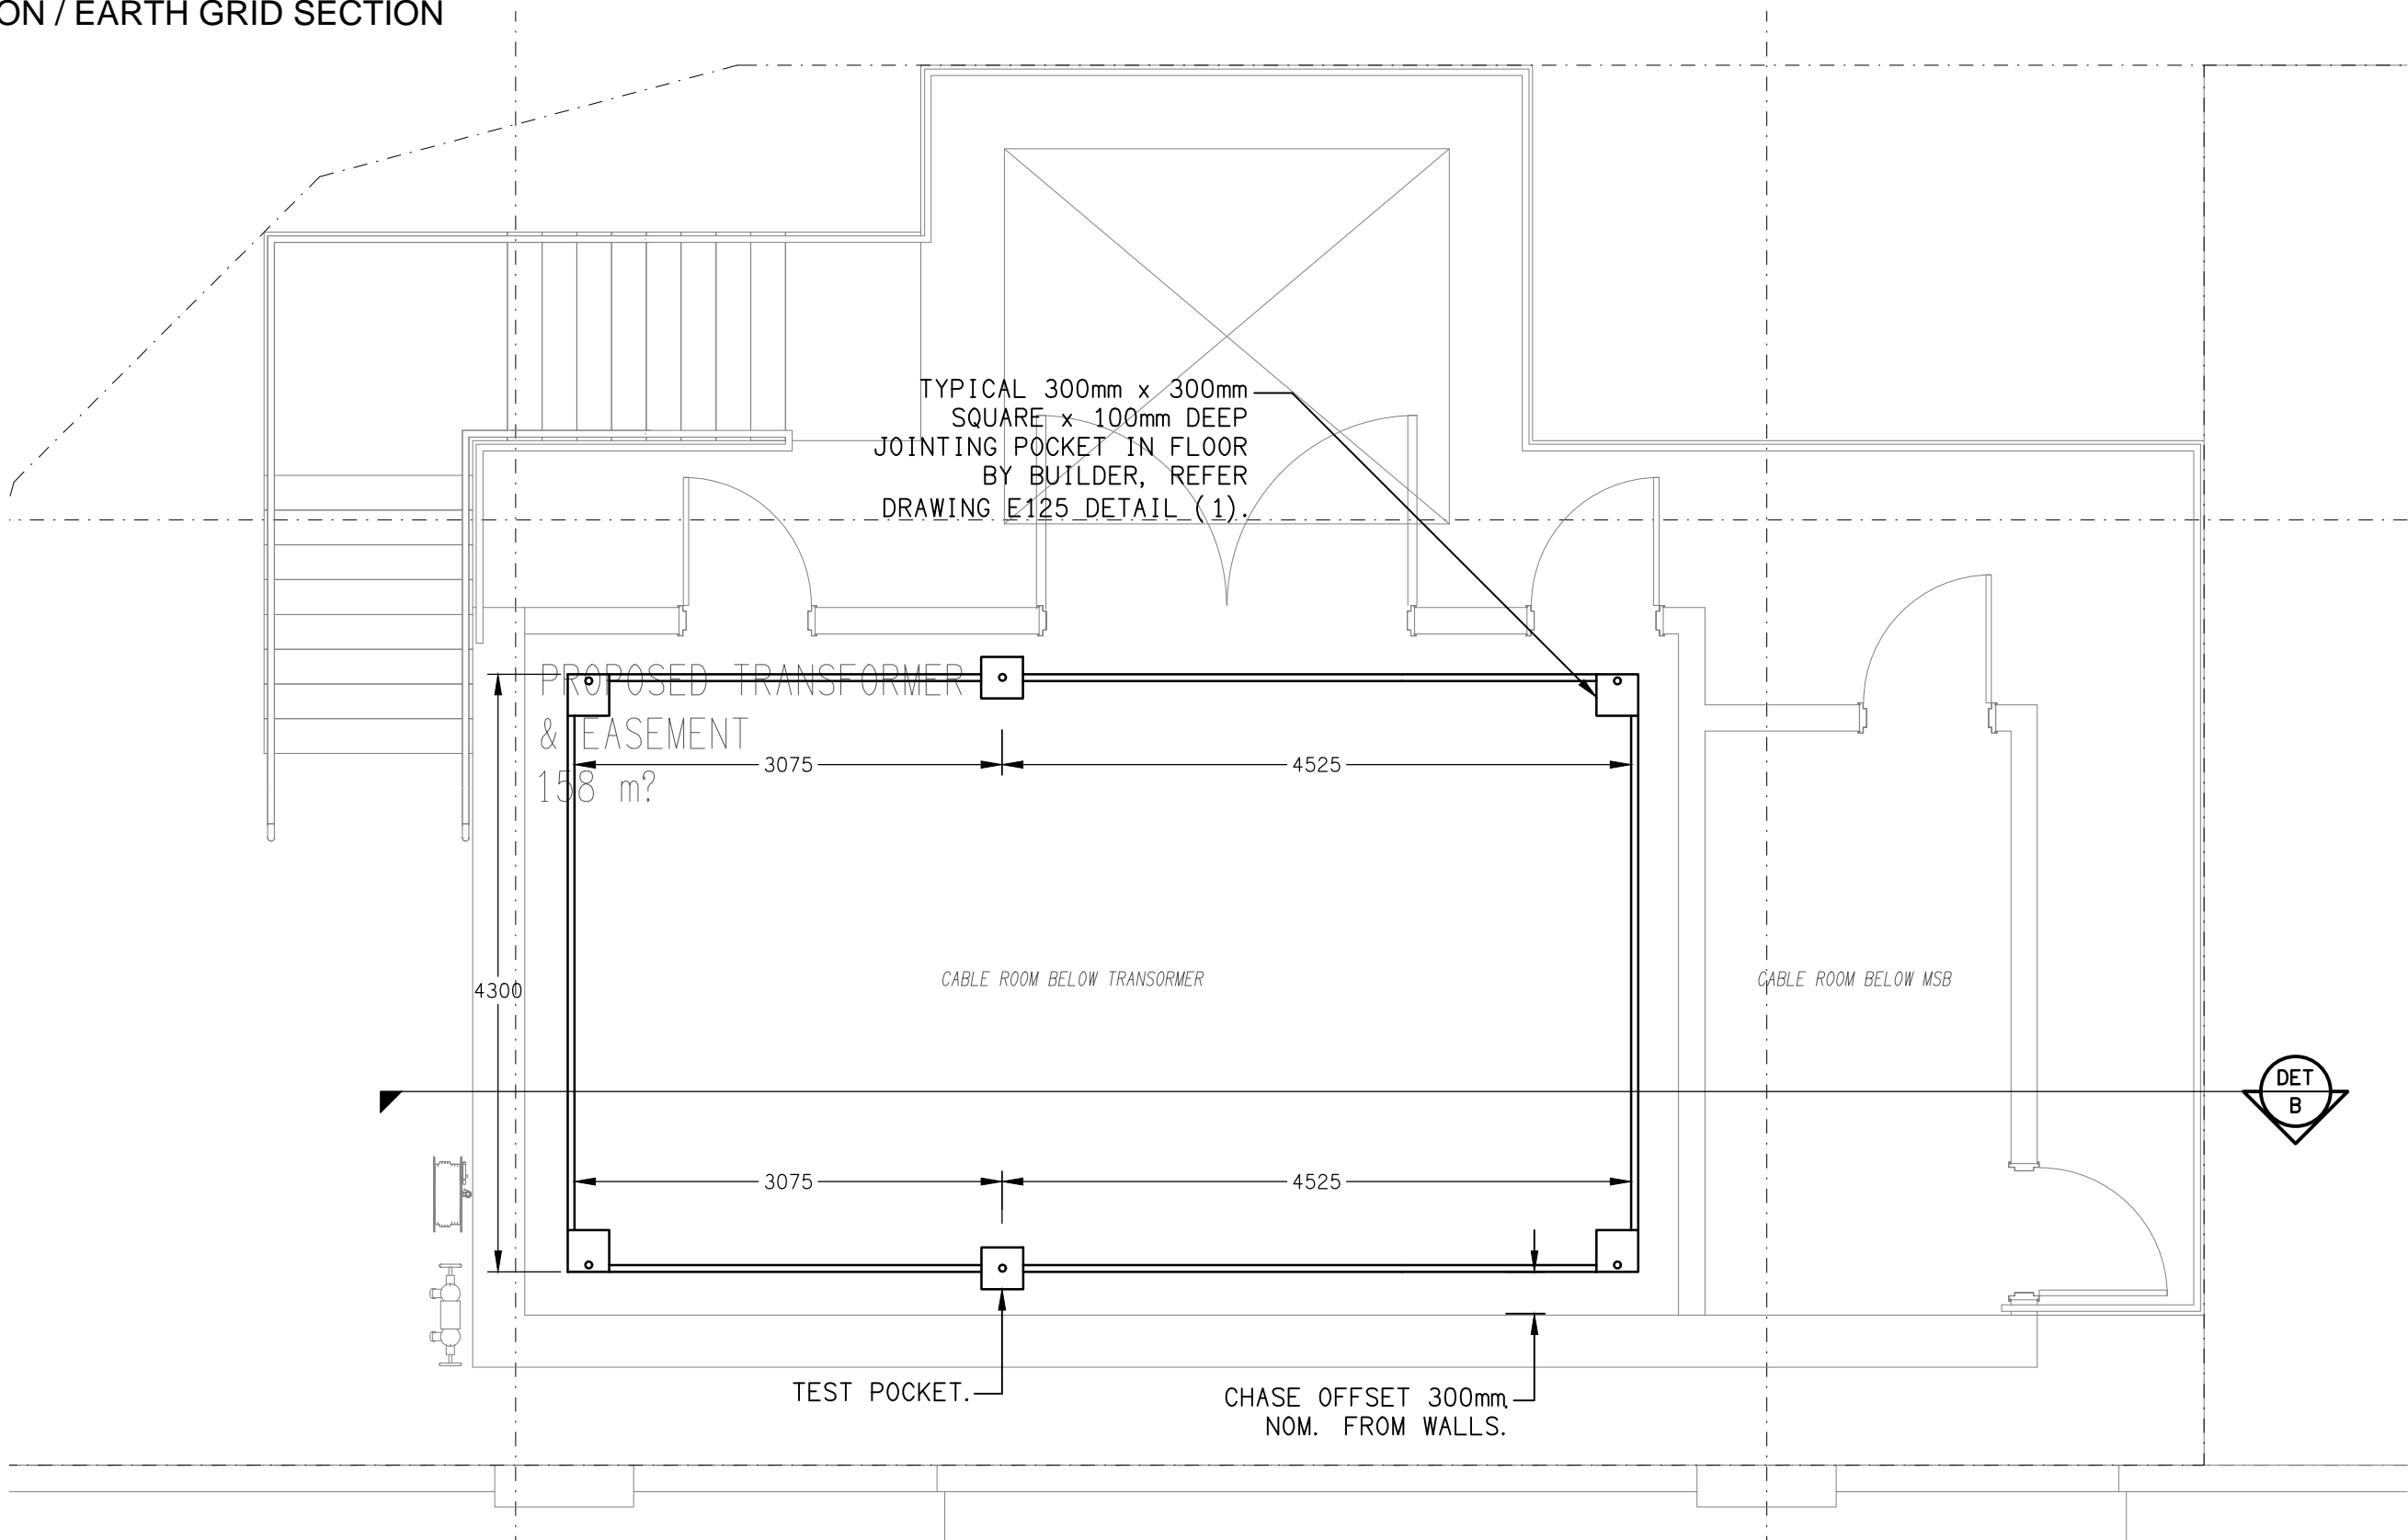

EARTH GRID PLAN
TRANSFORMER CABLE ROOM BELOW
SCALE 1: 50