


NOTE:

REFER TO DRAWING C3540a-E06.dwg & C3540a-E07.dwg FOR
ADDITIONAL JOINERY & WALL LIGHTING PLANS & DETAILS.

ELECTRICAL CEILING AND WALL
FITTINGS WITHIN THIS DASH LINED
AREA ARE TO BE REMOVED,
UNLESS NOTED OTHERWISE.

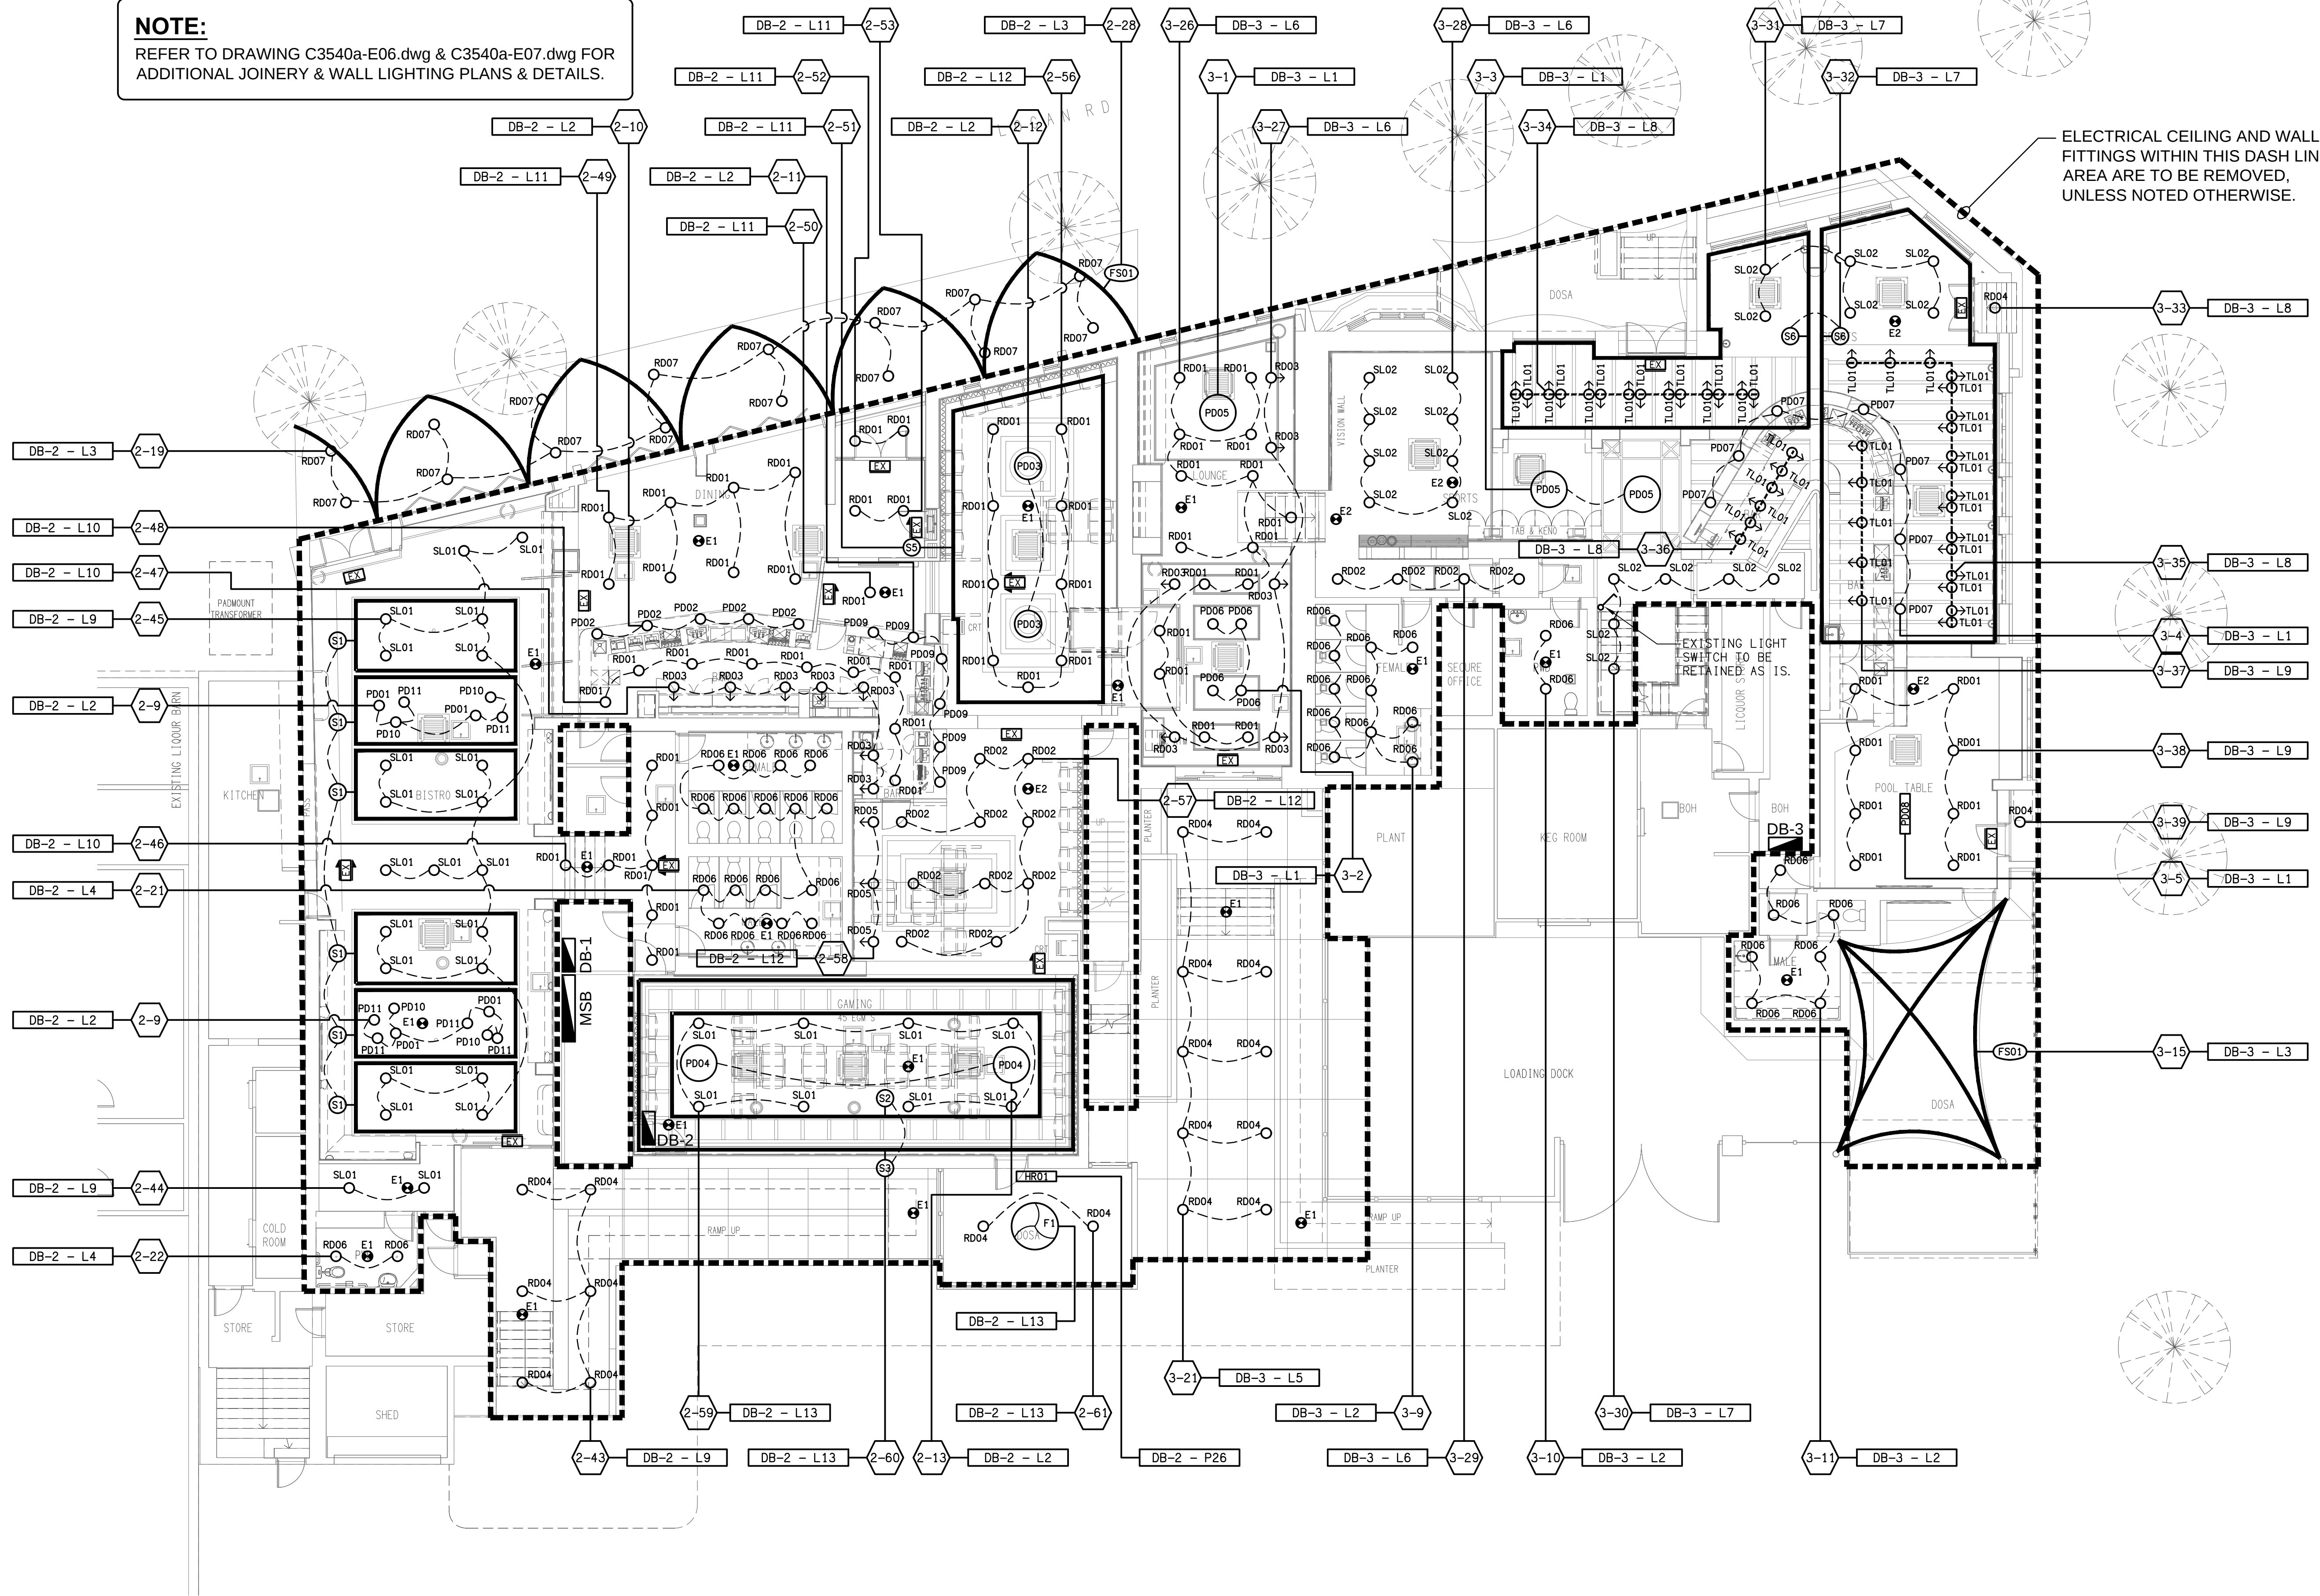

ELECTRICAL DESIGN GROUP BRISBANE
PTY LTD
ACN 092 710 793
TRADING AS:
ELECTRICAL DESIGN GROUP

THE COPYRIGHT OF THIS DRAWING
REMAINS THE PROPERTY OF THE
ELECTRICAL DESIGN GROUP.
USE FIGURED DIMENSIONS
IN PREFERENCE TO SCALE.
ALL DIMENSIONS TO BE
VERIFIED ONSITE.

ELECTRICAL DESIGN GROUP
ELECTRICAL BUILDING SERVICES CONSULTANTS
BRISBANE GOLD COAST

P.O. Box 15, Sherwood Q. 4075
Phone: (07) 3278 4375
Email: brisbane@edg.net.au
Web: www.edg.net.au

PROJECT:
HOLLAND PARK HOTEL

945 LOGAN ROAD, HOLLAND PARK

B	TENDER	05/05/2025
REV.	DESCRIPTION:	DATE:

DRAWING:
**ELECTRICAL SERVICES
REFLECTED CEILING PLAN**

SCALE:
1:100

AT A1

PROJECT NO:
C3540a

DRAWING NO:
E05

REVISION:
B