


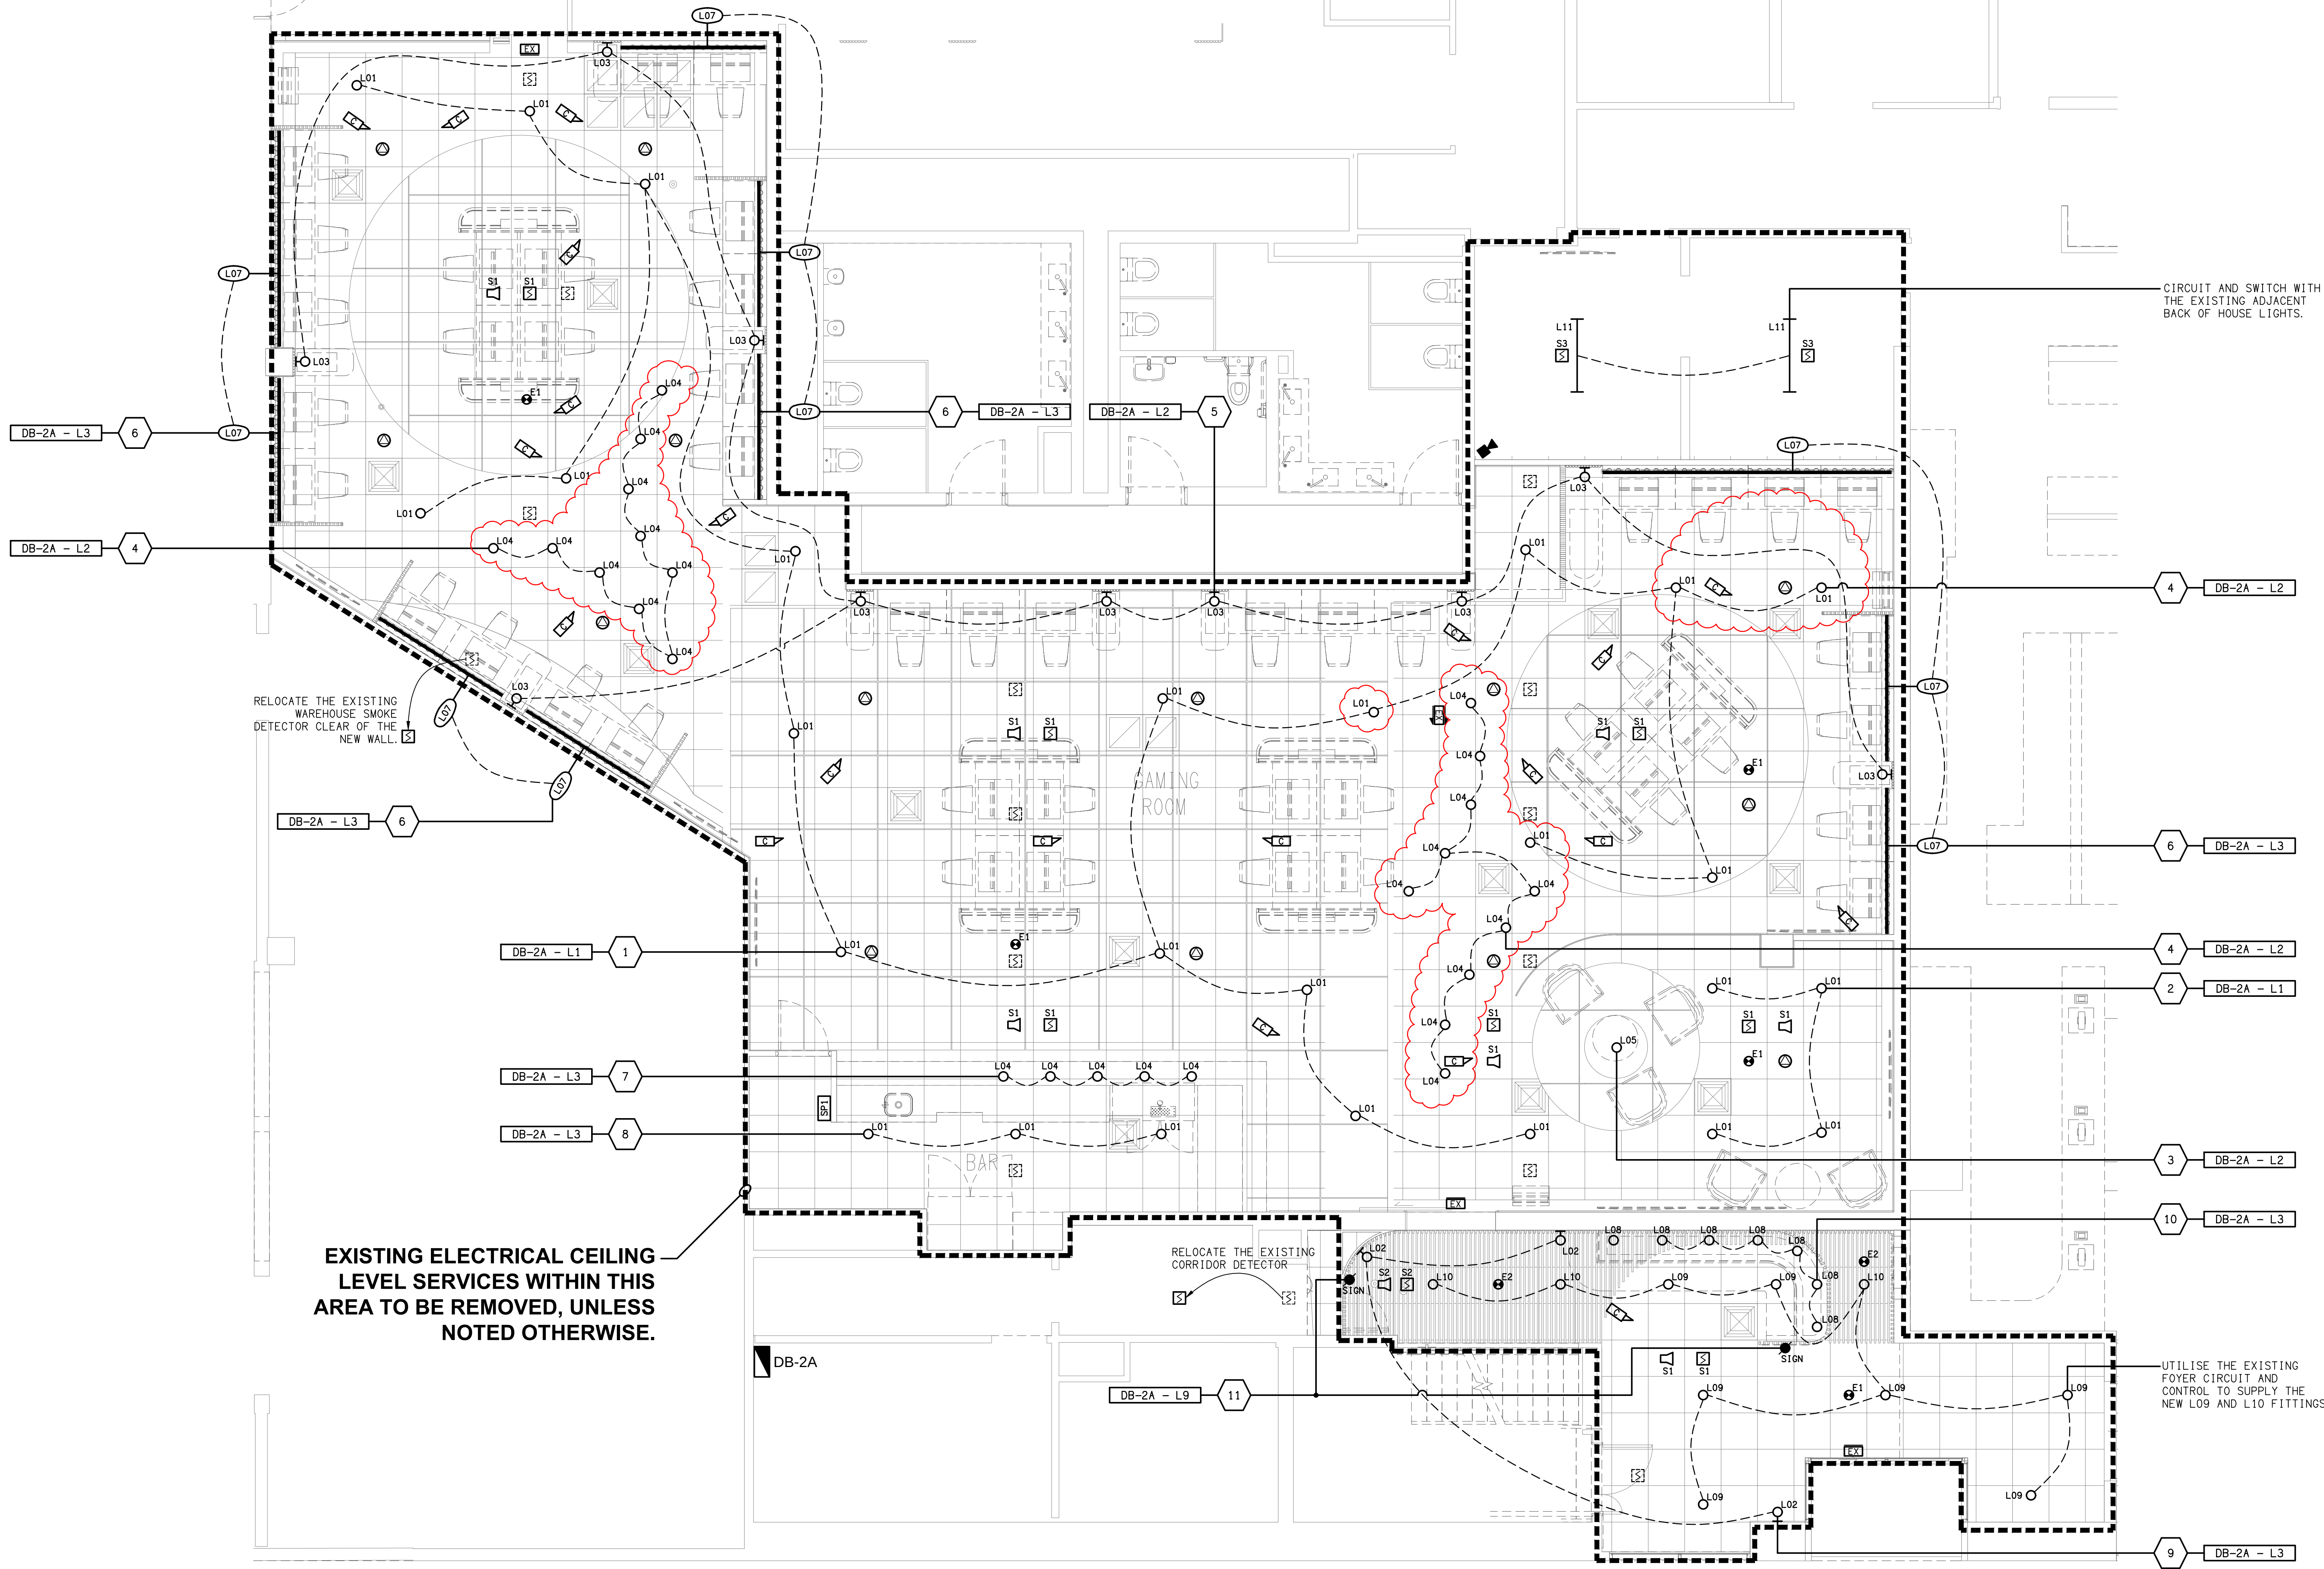

EXISTING ELECTRICAL CEILING
LEVEL SERVICES WITHIN THIS
AREA TO BE REMOVED, UNLESS
NOTED OTHERWISE.

ELECTRICAL DESIGN GROUP BRISBANE
PTY LTD
ACN 092 710 793
TRADING AS:
ELECTRICAL DESIGN GROUP

THE COPYRIGHT OF THIS DRAWING
REMAINS THE PROPERTY OF THE
ELECTRICAL DESIGN GROUP.
USE FIGURED DIMENSIONS
IN PREFERENCE TO SCALE.
ALL DIMENSIONS TO BE
VERIFIED ONSITE.

ELECTRICAL DESIGN GROUP
ELECTRICAL BUILDING SERVICES CONSULTANTS
BRISBANE GOLD COAST

P.O. Box 15, Sherwood Q. 4075
Phone: (07) 3278 4375
Email: brisbane@edg.net.au
Web: www.edg.net.au

PROJECT:
ISA HOTEL - GAMING ROOM UPGRADE

13 MILES STREET, MOUNT ISA, QUEENSLAND

B	CONSTRUCTION	16/01/2026
REV:	DESCRIPTION:	DATE:

DRAWING:
**ELECTRICAL SERVICES
REFLECTED CEILING PLAN**

SCALE:
1:50

AT A1

PROJECT NO:
C3543a

DRAWING NO:
E03

REVISION:
B